


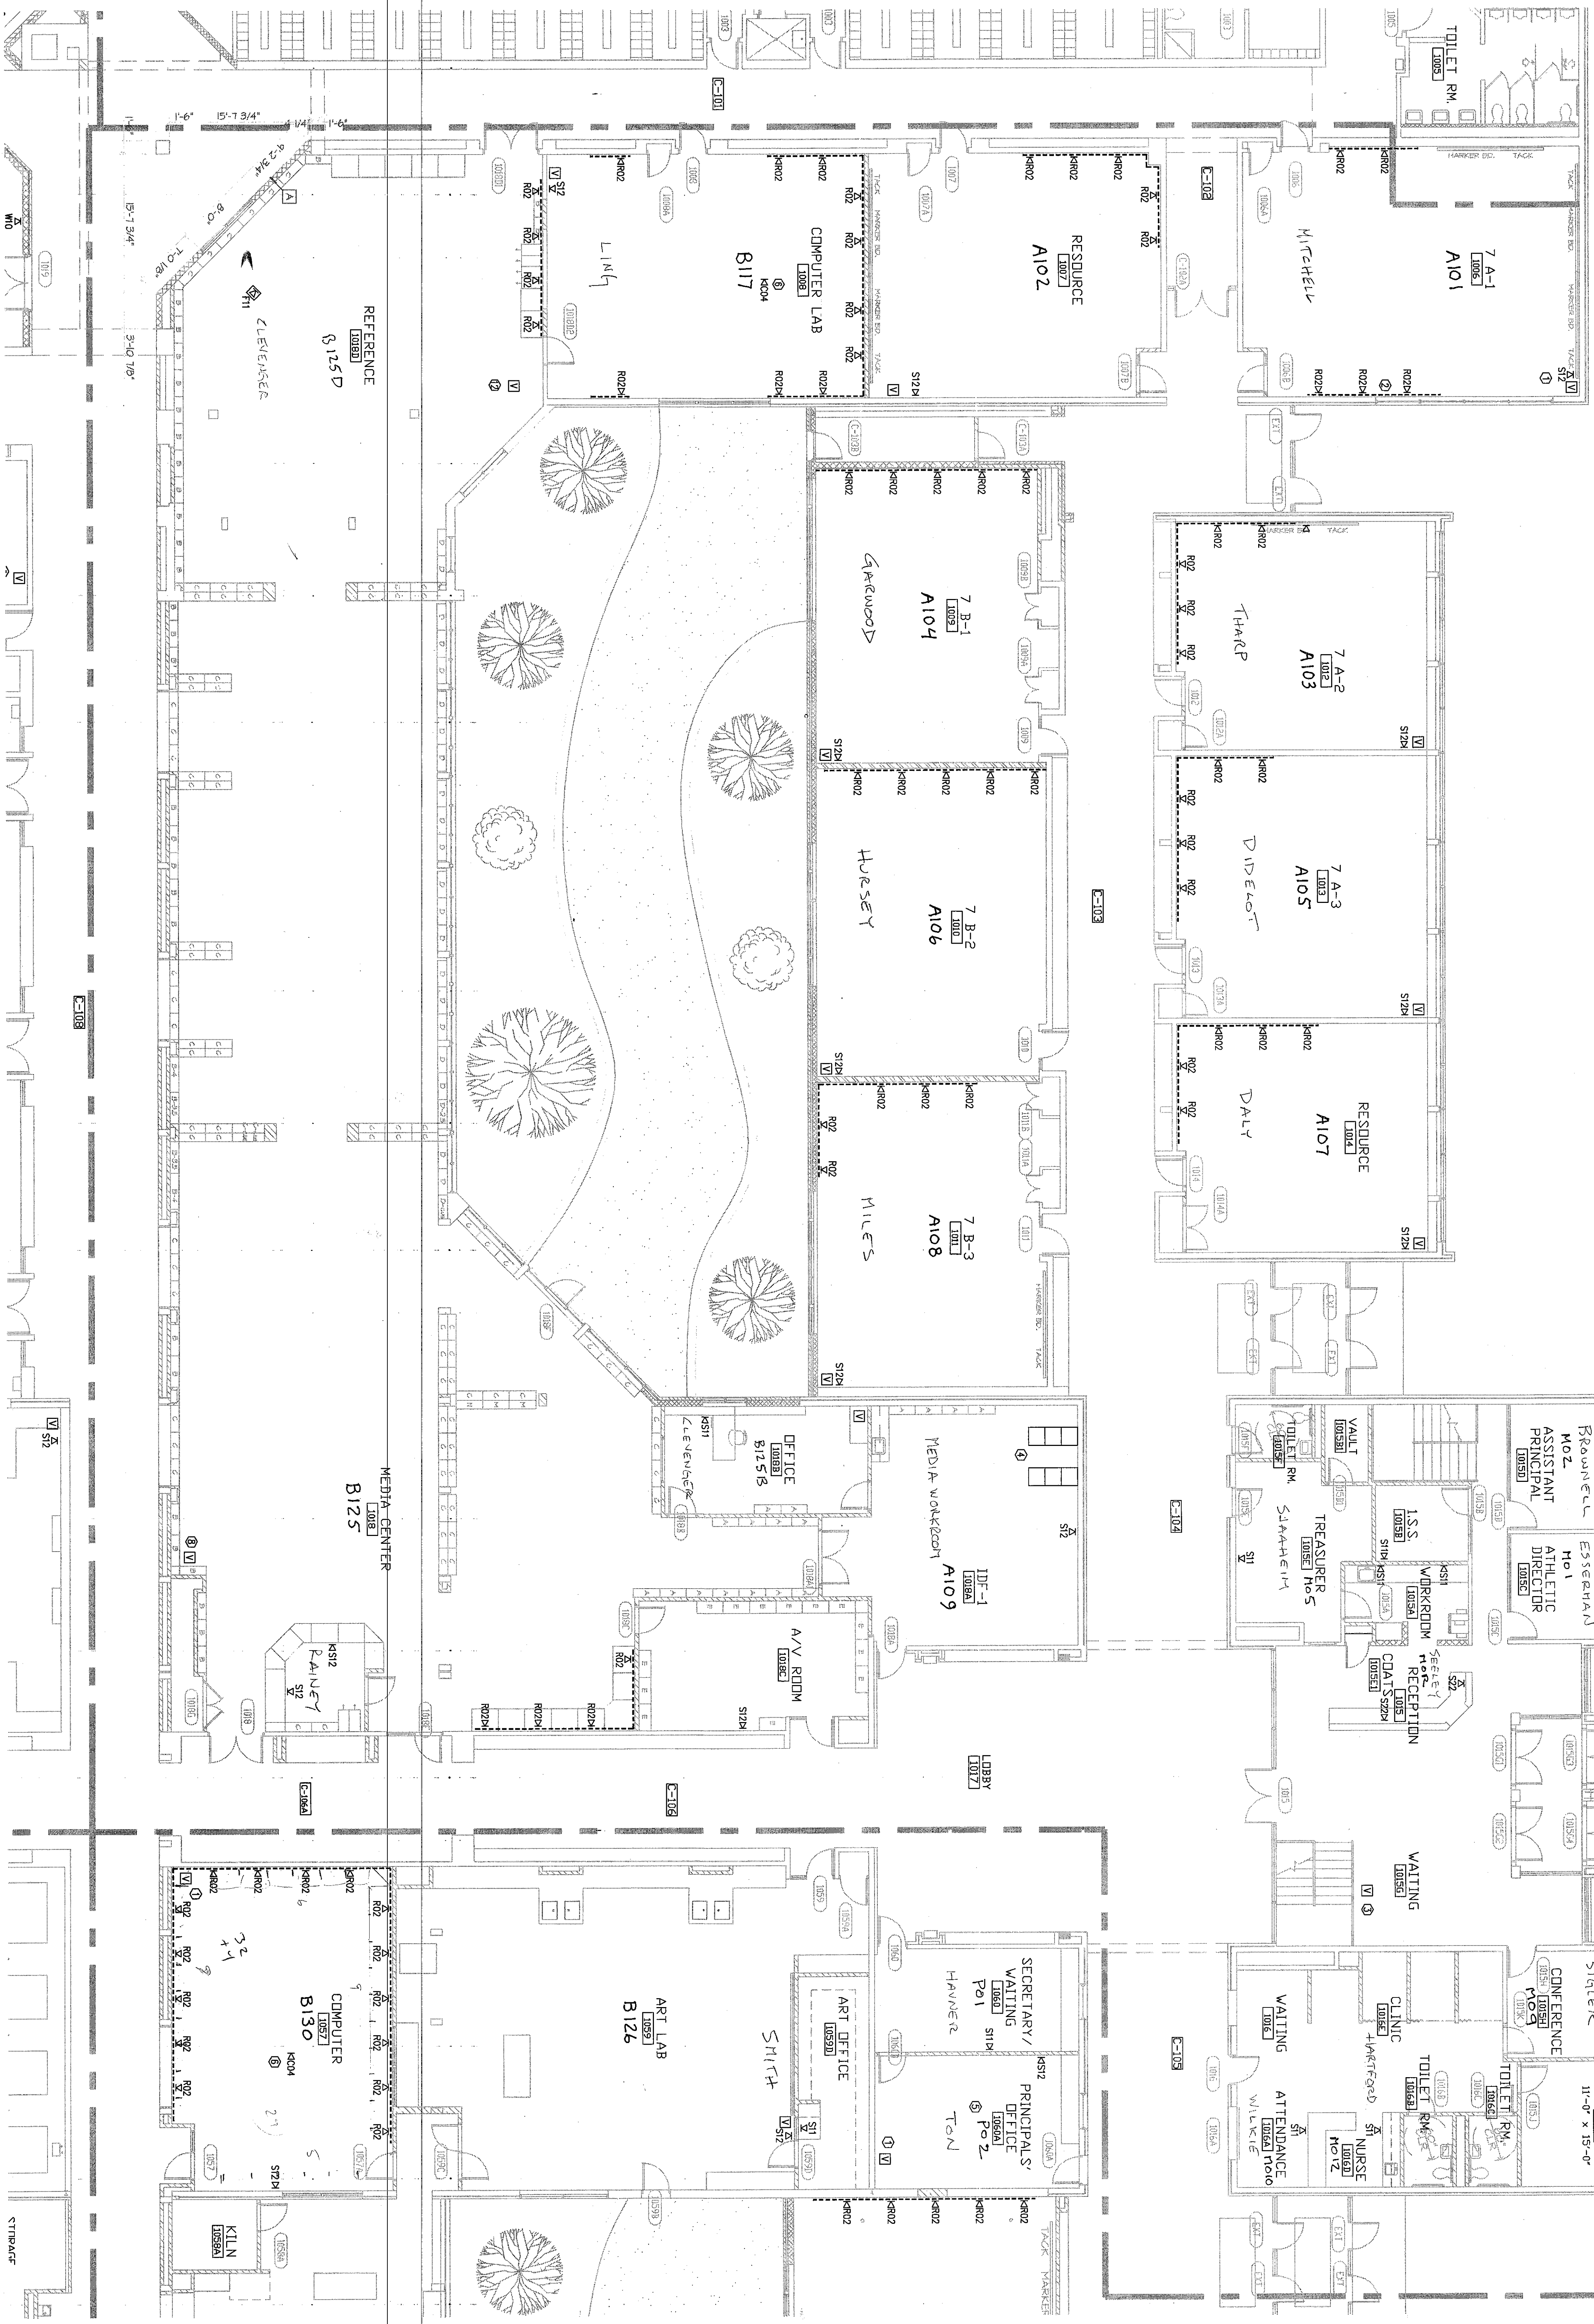

1 FLOOR PLAN
TS 12 SCALE 1/8"=1'-0"


UNIT B

- GENERAL NOTES:
1. DIVISION 16 CONTRACTOR RESPONSIBLE FOR RACKING.
 2. ALL CABLES, BUSES, DUAL-COMPONENT RACKINGS, AND OTHER EQUIPMENT SHALL BE INSTALLED IN ACCORDANCE WITH THE FOLLOWING NOTES.
 3. SHOW IN DRAWINGS FOR REFERENCE ONLY.

REFERENCES:

1. 2000-15-63
2. 2000-15-63
3. 2000-15-63
4. 2000-15-63
5. 2000-15-63
6. 2000-15-63
7. 2000-15-63
8. 2000-15-63
9. 2000-15-63
10. 2000-15-63
11. 2000-15-63
12. 2000-15-63
13. 2000-15-63
14. 2000-15-63
15. 2000-15-63
16. 2000-15-63
17. 2000-15-63
18. 2000-15-63
19. 2000-15-63
20. 2000-15-63
21. 2000-15-63

KEY PLAN

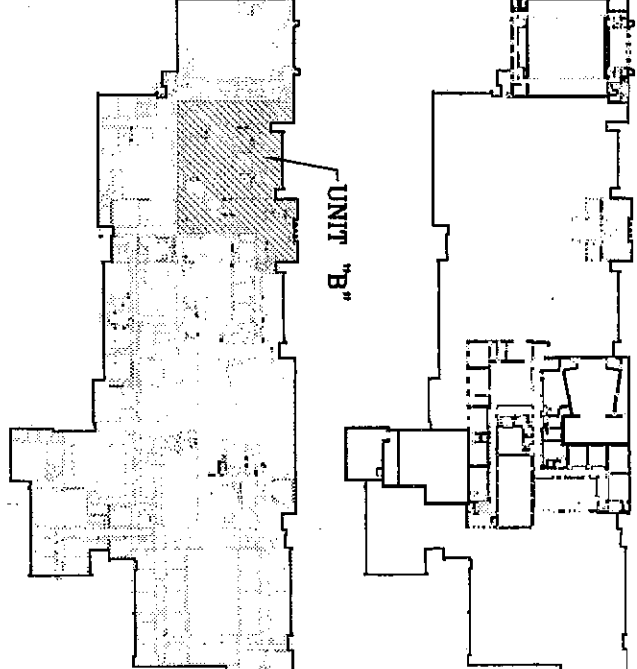

NORTH
SCALE: NTS

DS&A
Technology Design Consultants
4448 East 116th Street
Indianapolis, IN 46240-9500
765-244-5552
D&A ARCHITECTS

ARCHITECTS
ENGINEERS
PLANNERS

**VEAZEY
PARROTT
&
DURKIN
SHOULDERS**

3800 Phares Ave S.W.
Indianapolis, IN 46240

RENOVATION PROJECT FOR:
**DUNE AND SCHOOL
CORPORATION**
CHESTER, INDIANA

TECHNOLOGY SYSTEMS
FLOOR PLAN (UNIT B)

Drawing Title:

Project No:

Project Date:

Drawn By:

Approved By:

Drawing No:

TS 12