


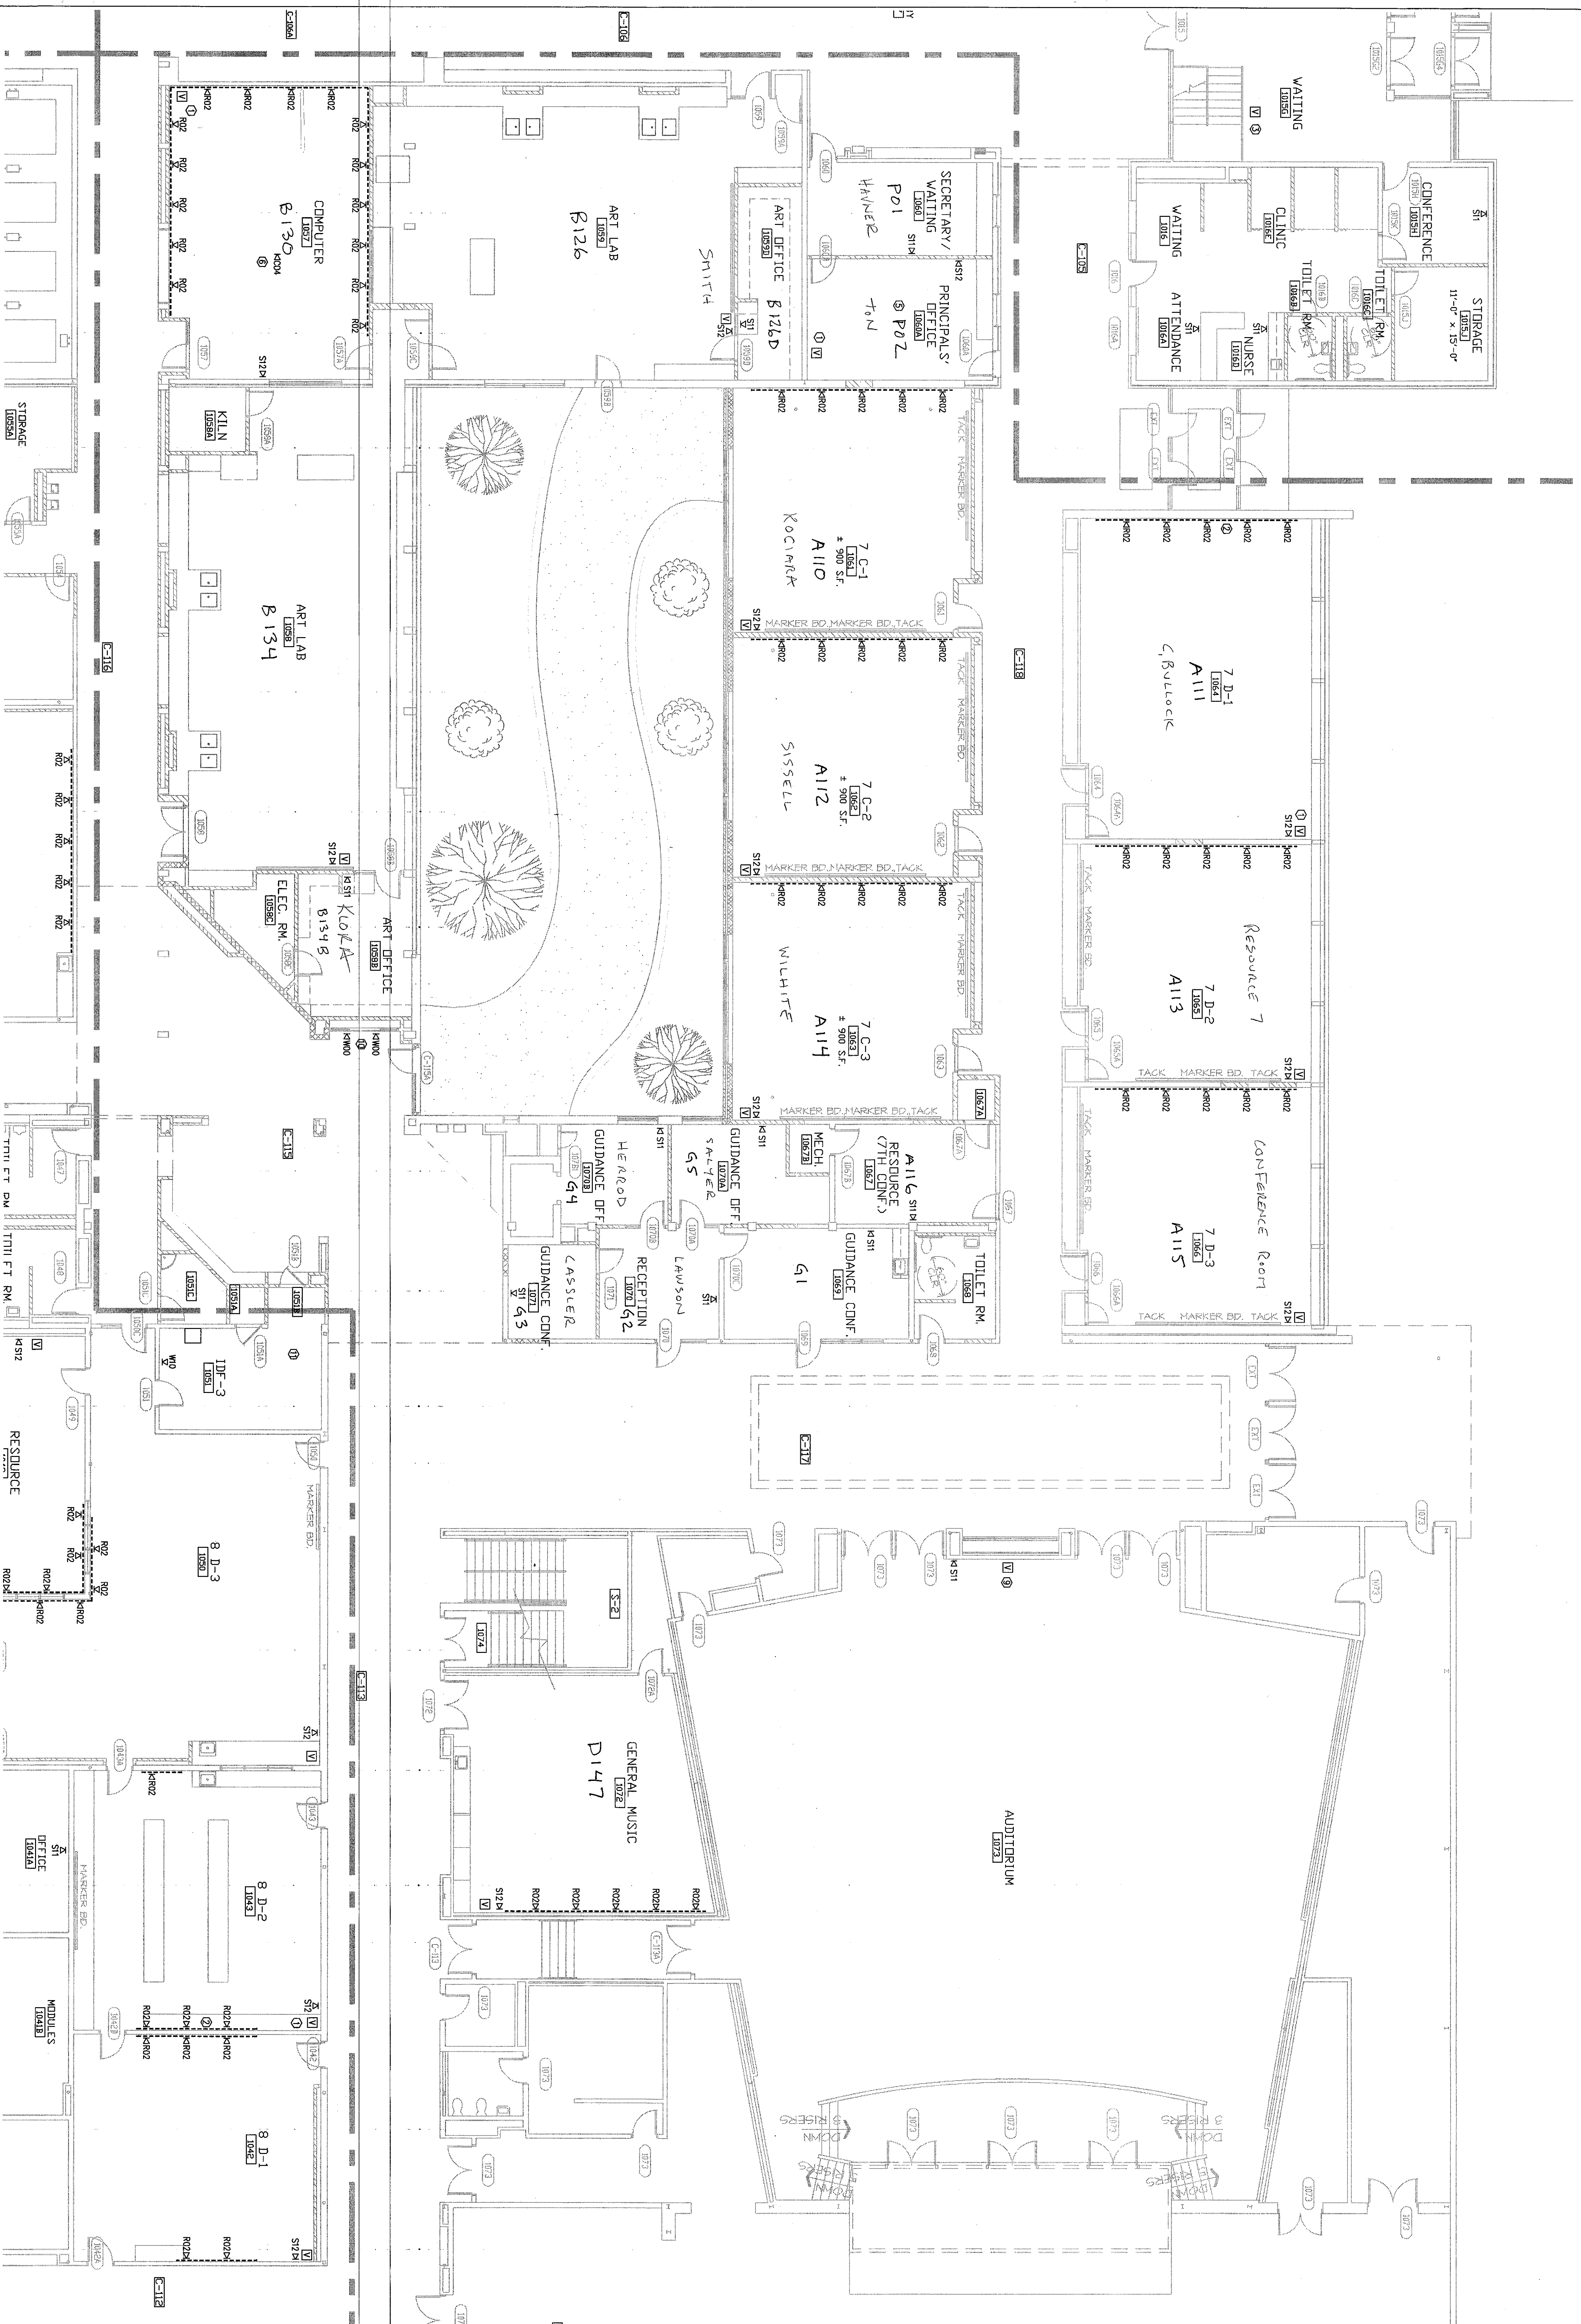


- GENERAL NOTES:
- 1 DIVISION 16 CONTRACTOR RESPONSIBLE FOR ALL CONDUIT, BOXES, DUAL-COMPARTMENT RACEWAYS, CABLE TRAY PROVIDED BY DIVISION 16 CONTRACTOR. SHOWN IN DRAWINGS FOR REFERENCE ONLY.

5

- [illegible]

KEY PLAN:

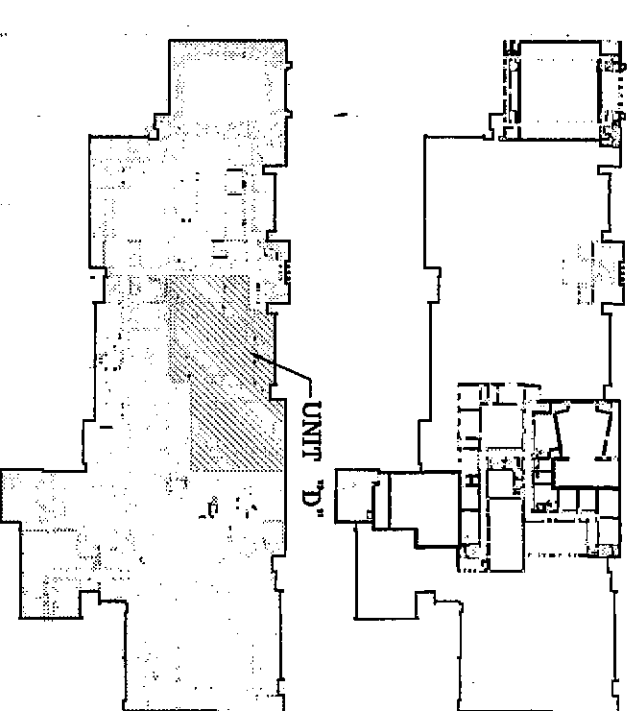

NORTH
SCALE: NTS

Technology Design Consultants
16618 East 176th Street
Noblesville IN 46060-9530
765.753-4512
D&A INCORPORATED

**ARCHITECT
ENGINEERS
PLANNERS**

VEAZEY
PARROTT
DURKIN &
SHOULDERS

**RENOVATION PROJECT FOR:
DUNELAND SCHOOL
CORPORATION
CHESTERTON MIDDLE SCHOOL
CHESTERTON, INDIANA**

TECHNOLOGY SYSTEMS
FLOOR PLAN (UNIT "D")

Project No:	99-1029
Project Date:	6-14-2000
Drawn By:	TDES
Approved By:	LMD
Drawing No:	

TS 1.4