


- GENERAL NOTES:
1. DIVISION 16 CONTRACTOR RESPONSIBLE FOR ALL MOUNT, BOXES, DUAL-COMPONENT RACKING'S, CABLE TRAY PROVIDED BY DIVISION 16 CONTRACTOR.
 2. SHOWN IN DRAWINGS FOR REFERENCE ONLY.

REFERENCES NOTES

1. SEE TS-5.0(2), TYPICAL FOR ALL CABLES, PROVIDE WALL MOUNT BRACKET.
2. PROVIDE 3" (76.2MM) DIA. (1/2") X 1/2" DIA. IN RACKING PROVIDED BY DIVISION 16 CONTRACTOR.
3. PROVIDE 3" (76.2MM) DIA. (1/2") X 1/2" DIA. IN RACKING PROVIDED BY DIVISION 16 CONTRACTOR.
4. PROVIDE 3" (76.2MM) DIA. (1/2") X 1/2" DIA. IN RACKING PROVIDED BY DIVISION 16 CONTRACTOR.
5. PROVIDE 3" (76.2MM) DIA. (1/2") X 1/2" DIA. IN RACKING PROVIDED BY DIVISION 16 CONTRACTOR.
6. PROVIDE 3" (76.2MM) DIA. (1/2") X 1/2" DIA. IN RACKING PROVIDED BY DIVISION 16 CONTRACTOR.
7. PROVIDE 3" (76.2MM) DIA. (1/2") X 1/2" DIA. IN RACKING PROVIDED BY DIVISION 16 CONTRACTOR.
8. PROVIDE 3" (76.2MM) DIA. (1/2") X 1/2" DIA. IN RACKING PROVIDED BY DIVISION 16 CONTRACTOR.
9. PROVIDE 3" (76.2MM) DIA. (1/2") X 1/2" DIA. IN RACKING PROVIDED BY DIVISION 16 CONTRACTOR.
10. PROVIDE 3" (76.2MM) DIA. (1/2") X 1/2" DIA. IN RACKING PROVIDED BY DIVISION 16 CONTRACTOR.
11. PROVIDE 3" (76.2MM) DIA. (1/2") X 1/2" DIA. IN RACKING PROVIDED BY DIVISION 16 CONTRACTOR.
12. PROVIDE 3" (76.2MM) DIA. (1/2") X 1/2" DIA. IN RACKING PROVIDED BY DIVISION 16 CONTRACTOR.
13. PROVIDE 3" (76.2MM) DIA. (1/2") X 1/2" DIA. IN RACKING PROVIDED BY DIVISION 16 CONTRACTOR.
14. PROVIDE 3" (76.2MM) DIA. (1/2") X 1/2" DIA. IN RACKING PROVIDED BY DIVISION 16 CONTRACTOR.
15. PROVIDE 3" (76.2MM) DIA. (1/2") X 1/2" DIA. IN RACKING PROVIDED BY DIVISION 16 CONTRACTOR.
16. PROVIDE 3" (76.2MM) DIA. (1/2") X 1/2" DIA. IN RACKING PROVIDED BY DIVISION 16 CONTRACTOR.
17. PROVIDE 3" (76.2MM) DIA. (1/2") X 1/2" DIA. IN RACKING PROVIDED BY DIVISION 16 CONTRACTOR.
18. PROVIDE 3" (76.2MM) DIA. (1/2") X 1/2" DIA. IN RACKING PROVIDED BY DIVISION 16 CONTRACTOR.
19. PROVIDE 3" (76.2MM) DIA. (1/2") X 1/2" DIA. IN RACKING PROVIDED BY DIVISION 16 CONTRACTOR.
20. PROVIDE 3" (76.2MM) DIA. (1/2") X 1/2" DIA. IN RACKING PROVIDED BY DIVISION 16 CONTRACTOR.
21. PROVIDE 3" (76.2MM) DIA. (1/2") X 1/2" DIA. IN RACKING PROVIDED BY DIVISION 16 CONTRACTOR.

KEY PLAN:

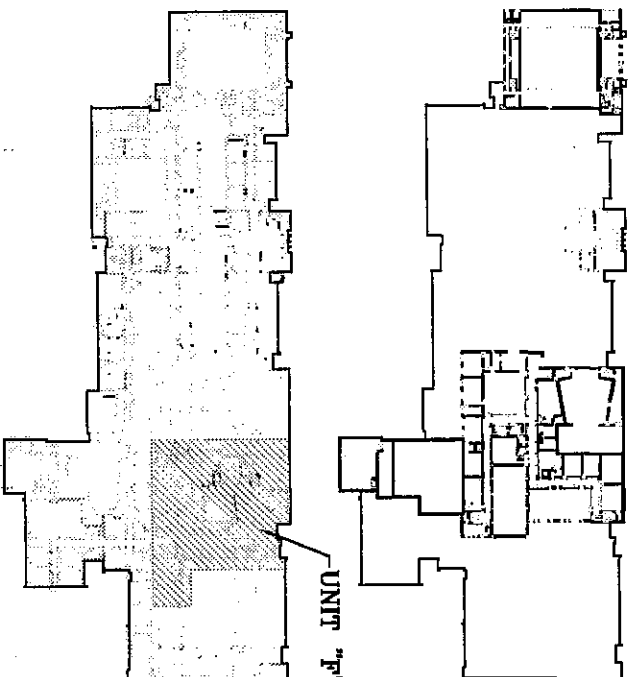

NORTH
SCALE: NTS

16 FLOOR PLAN
SCALE: 1/8"=1'-0"

UNIT F

D S & A
Technology Design Consultants
14418 East 196th Street
Niles, IL 60067-2500
708.534.5152
D S & A ARCHITECTS

ARCHITECTS
ENGINEERS
PLANNERS

**VEAZEY
PARROTT
DURKIN &
SHOULDERS**

RENOVATION PROJECT FOR:
**DUNEALD SCHOOL
CORPORATION
CHERTON MIDDLE SCHOOL
CHERTON, INDIANA**

Drawing Title:
**TECHNOLOGY SYSTEMS
FLOOR PLAN (UNIT F)**

Project No.: 99-1024
Project Date: 6-14-2000
Drawn By: TDES
Approved By: LVD
Drawing No.: 99-1024-01
TS 16