



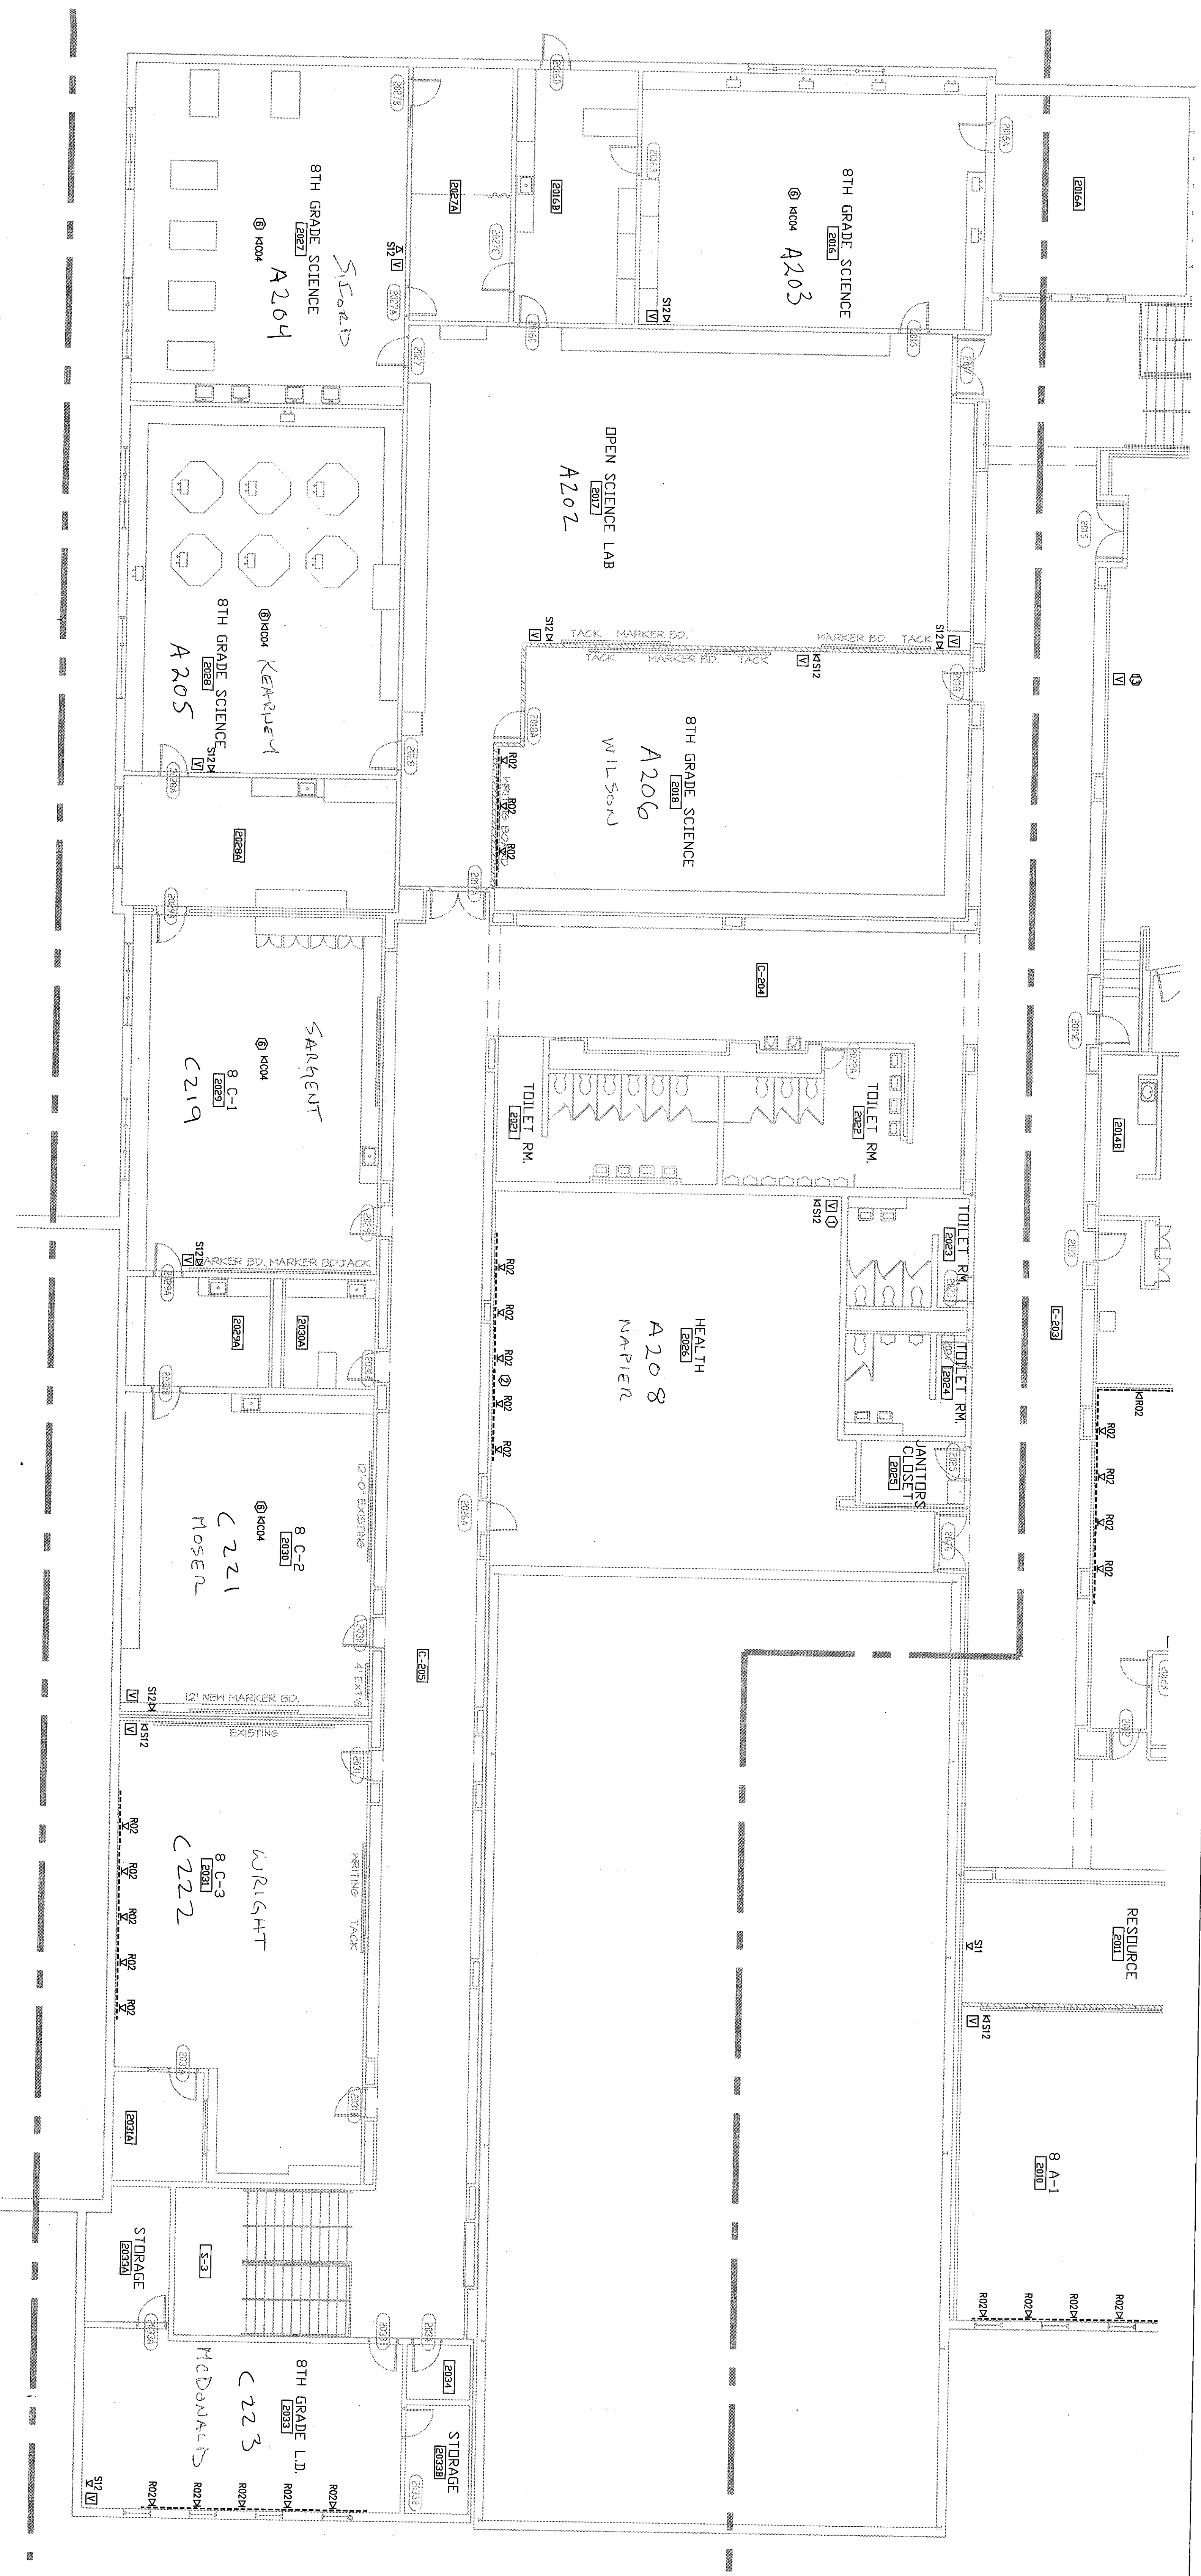

1 FLOOR PLAN
TS 21 SCALE: 1/8"=1'-0"
UNIT: H

- GENERAL NOTES:
1. ALL CONDUIT, BOXES, DUAL-COMPONENT RACEWAYS, CABLE TRAY PROVIDED BY DIVISION 16 CONTRACTOR. SHOWN IN DRAWINGS FOR REFERENCE ONLY.
 2. SEE TS-5.1(2) TYPICAL FOR ALL CLASSROOMS. PROVIDE (1) 7" MULTI-MEDIA MONITOR & (1) 5" NIS VCR IN DIVISION 16 CONTRACTOR. TYPICAL AS INDICATED.
 3. PROVIDE 36" MONITOR/BROADCAST AND NOISE-SHIELDING ENCLOSURE FOR EACH CLASSROOM. PROVIDE 36" MONITOR/BROADCAST AND NOISE-SHIELDING ENCLOSURE FOR EACH CLASSROOM. PROVIDE 36" MONITOR/BROADCAST AND NOISE-SHIELDING ENCLOSURE FOR EACH CLASSROOM.
 4. PROVIDE EQUIVALENT NUMBER OF CAT 6 CABLES AND COAX TO PROVIDE SAME SERVICE AS PRINCIPAL'S. PROVIDE 36" CABLE IN COIL IN CLASSROOMS. PROVIDE 36" CABLE IN COIL IN CLASSROOMS. PROVIDE 36" CABLE IN COIL IN CLASSROOMS.
 5. PROVIDE 36" CABLE IN COIL IN CLASSROOMS. PROVIDE 36" CABLE IN COIL IN CLASSROOMS. PROVIDE 36" CABLE IN COIL IN CLASSROOMS.
 6. PROVIDE 36" CABLE IN COIL IN CLASSROOMS. PROVIDE 36" CABLE IN COIL IN CLASSROOMS. PROVIDE 36" CABLE IN COIL IN CLASSROOMS.
 7. PROVIDE 36" CABLE IN COIL IN CLASSROOMS. PROVIDE 36" CABLE IN COIL IN CLASSROOMS. PROVIDE 36" CABLE IN COIL IN CLASSROOMS.
 8. PROVIDE 36" CABLE IN COIL IN CLASSROOMS. PROVIDE 36" CABLE IN COIL IN CLASSROOMS. PROVIDE 36" CABLE IN COIL IN CLASSROOMS.
 9. PROVIDE 36" CABLE IN COIL IN CLASSROOMS. PROVIDE 36" CABLE IN COIL IN CLASSROOMS. PROVIDE 36" CABLE IN COIL IN CLASSROOMS.
 10. PROVIDE 36" CABLE IN COIL IN CLASSROOMS. PROVIDE 36" CABLE IN COIL IN CLASSROOMS. PROVIDE 36" CABLE IN COIL IN CLASSROOMS.
 11. PROVIDE 36" CABLE IN COIL IN CLASSROOMS. PROVIDE 36" CABLE IN COIL IN CLASSROOMS. PROVIDE 36" CABLE IN COIL IN CLASSROOMS.
 12. PROVIDE 36" CABLE IN COIL IN CLASSROOMS. PROVIDE 36" CABLE IN COIL IN CLASSROOMS. PROVIDE 36" CABLE IN COIL IN CLASSROOMS.
 13. PROVIDE 36" CABLE IN COIL IN CLASSROOMS. PROVIDE 36" CABLE IN COIL IN CLASSROOMS. PROVIDE 36" CABLE IN COIL IN CLASSROOMS.
 14. PROVIDE 36" CABLE IN COIL IN CLASSROOMS. PROVIDE 36" CABLE IN COIL IN CLASSROOMS. PROVIDE 36" CABLE IN COIL IN CLASSROOMS.
 15. PROVIDE 36" CABLE IN COIL IN CLASSROOMS. PROVIDE 36" CABLE IN COIL IN CLASSROOMS. PROVIDE 36" CABLE IN COIL IN CLASSROOMS.
 16. PROVIDE 36" CABLE IN COIL IN CLASSROOMS. PROVIDE 36" CABLE IN COIL IN CLASSROOMS. PROVIDE 36" CABLE IN COIL IN CLASSROOMS.
 17. PROVIDE 36" CABLE IN COIL IN CLASSROOMS. PROVIDE 36" CABLE IN COIL IN CLASSROOMS. PROVIDE 36" CABLE IN COIL IN CLASSROOMS.
 18. PROVIDE 36" CABLE IN COIL IN CLASSROOMS. PROVIDE 36" CABLE IN COIL IN CLASSROOMS. PROVIDE 36" CABLE IN COIL IN CLASSROOMS.
 19. PROVIDE 36" CABLE IN COIL IN CLASSROOMS. PROVIDE 36" CABLE IN COIL IN CLASSROOMS. PROVIDE 36" CABLE IN COIL IN CLASSROOMS.
 20. PROVIDE 36" CABLE IN COIL IN CLASSROOMS. PROVIDE 36" CABLE IN COIL IN CLASSROOMS. PROVIDE 36" CABLE IN COIL IN CLASSROOMS.
 21. PROVIDE 36" CABLE IN COIL IN CLASSROOMS. PROVIDE 36" CABLE IN COIL IN CLASSROOMS. PROVIDE 36" CABLE IN COIL IN CLASSROOMS.

KEY PLAN:

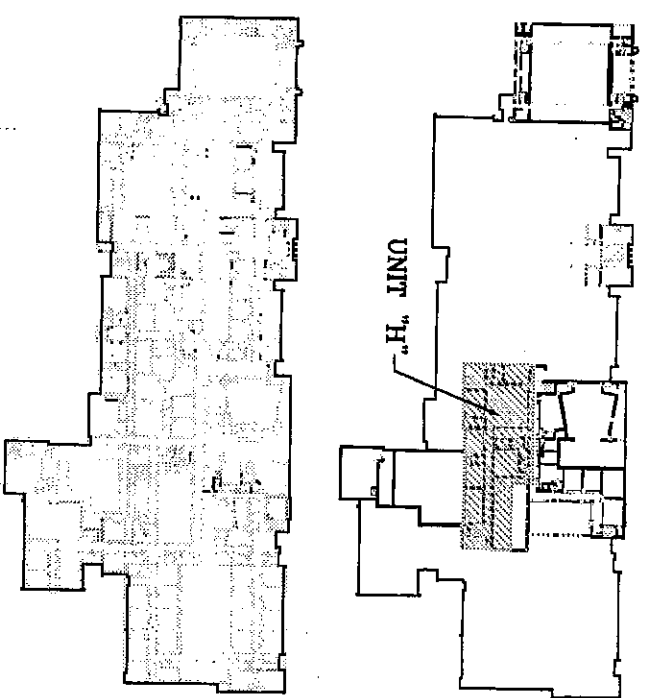

NORTH
SCALE: NTS

DS&A INC.
Technology Design Consultants
1618 East 19th Street
Indianapolis, IN 46204-9530
763-345152
ID S&A 1000000000

**VEAZEY
PARROTT
DURKIN &
SHOULDERS**

ARCHITECTS
ENGINEERS
PLANNERS

RENOVATION PROJECT FOR:
DUNELAND SCHOOL
CORPORATION
CHESTERTON, INDIANA

Drawing Title:
**TECHNOLOGY SYSTEMS
FLOOR PLAN (UNIT 7)**
Project No.: 94-1024
Project Date: 6-14-2000
Drawn By: TDES
Approved By: LVD
Drawing No.: 2000-TS-04
TS 2.1