


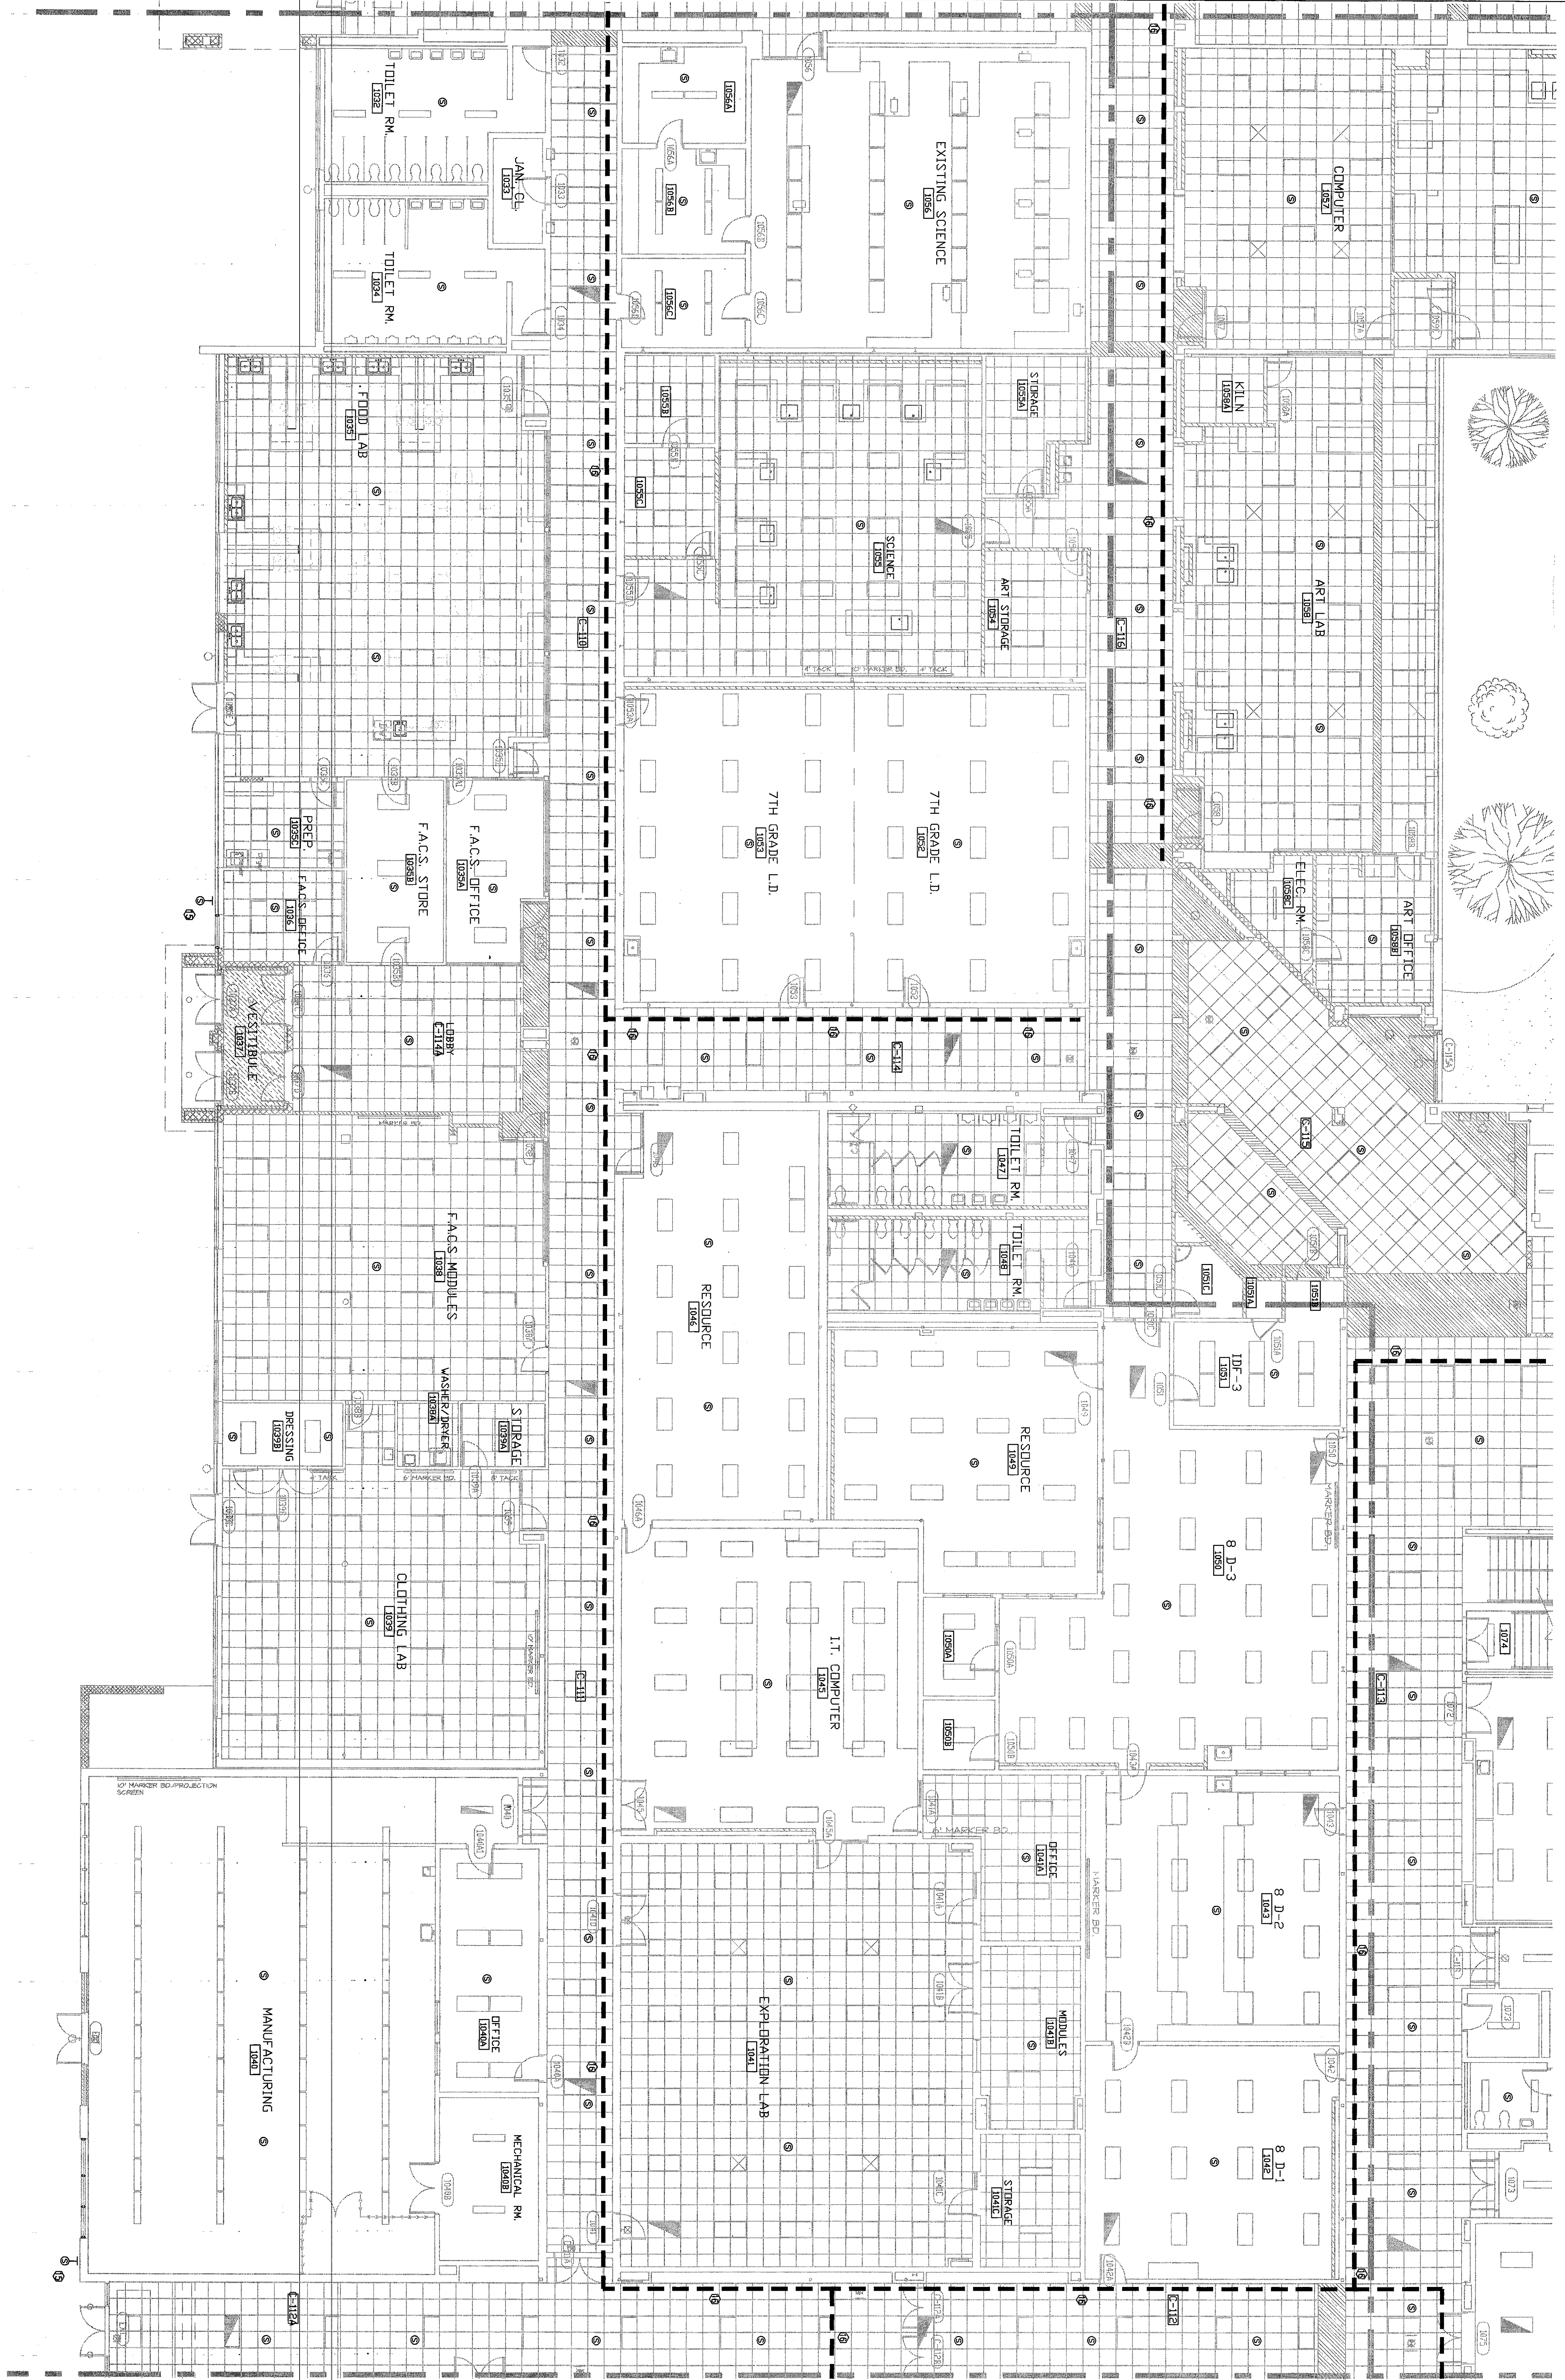


1 REFLECTED CEILING PLAN
TS 3.5 SCALE 1/8"=1'-0"

UNIT E


- GENERAL NOTES
- DIVISION IS CONTRACTOR RESPONSIBLE FOR ALL CONDUIT, BOXES, DUAL-COMPONENT RACKINGS, CABLE TRAY PROVIDED BY DIVISION IS CONTRACTOR. SHOWN IN DRAWINGS FOR REFERENCE ONLY.

- REFERENCES NOTES
- SEE TS-5.0(2) TYPICAL FOR ALL CLASSROOMS PROVIDE WALL MOUNT BRACKET.
 - MOUNT DEVICES (PLATE/PAPER) IN ROOMS PROVIDED BY DIVISION IS CONTRACTOR. TYPICAL AS INDICATED. NO VES. MOUNT AT 6" TO BOTTOM OF BRACKET.
 - SEE TS-5.0(1) FOR ADDITIONAL INFORMATION.
 - PROVIDE EQUIPMENT NUMBER OF CAT 6 CABLES AND CABLE TRAY PROVIDED BY DIVISION IS CONTRACTOR. PROVIDE 30'-0" CAT 6 CABLE (CABLE TRAY) ABOVE CABLE TRAY AND UNDER CABLE TRAY. PROVIDE 27' LOOP SPACERS FROM PRIMARY MONITOR. NO VES. LOOP SPACERS FROM PRIMARY MONITOR.
 - PROVIDE ONE (1) TV CONNECTION IN PLATE FOR LOCAL RAY TELEPHONE LOCATION. NO VES. MOUNT AT 10' TO RT.
 - SEE TS-5.1(4) FOR ADDITIONAL INFORMATION.
 - MONITOR (1) TV PART AND PLATE FOR PRIMARY/VIDEO MONITOR. PROVIDE NO VES. PROVIDE 35' MULTIMEDIA MONITOR/BROCKET. NO VES.
 - SEE TS-5.1(3) PROVIDE 35' MULTIMEDIA MONITOR/BROCKET. NO VES.
 14. 35' MULTIMEDIA MONITOR/BROCKET. NO VES.
 15. INTERCOM HORN SPEAKER MOUNTED 15' ABOVE GROUND.
 16. CABLE TRAY SHOWN FOR REFERENCE ONLY.
 17. CEILING SPEAKERS. ROUTE TO ROOM WHEN AMPLIFIER. TYPICAL OF 16.
 18. SURFACE MOUNT AUDIOVISUAL SPEAKER.
 19. WALL MOUNT 9x12 PROJECTION SCREEN.
 20. CEILING MOUNT LED PROJECTION. ROUTE CABLE TO AV CONTROL ROOM.
 21. AUDIOVISUAL EQUIPMENT RACK.

KEY PLAN

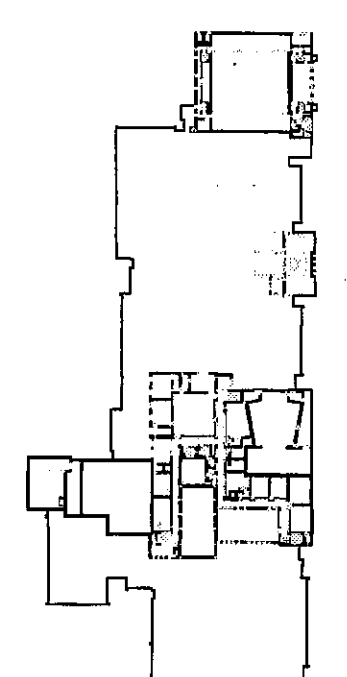

NORTH
SCALE: NTS

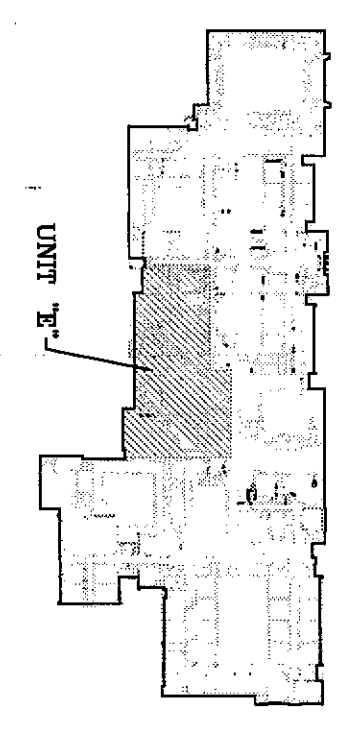

DS&A INC.
Technology Design Consultants
14410 East 19th St
Noblesville, IN 46060-9530
765.334.4552
D S A A ARCHITECTS

**VEAZEY
PARROTT
&
SHOULDERS**
ARCHITECTS
ENGINEERS
PLANNERS

RENOVATION PROJECT FOR:
**DUNELAND SCHOOL
CORPORATION**
CHESTERTON MIDDLE SCHOOL
CHESTERTON, INDIANA

Drawing Title:
**TECHNOLOGY SYSTEMS REFLECTED
CEILING PLAN (UNIT E)**

Project No.: 99-10291
Project Date: 6-14-2000
Drawn By: TDES
Approved By: LVD
Drawing No.: TS 3.5