


- GENERAL NOTES:
- DIVISION IS CONTRACTOR RESPONSIBLE FOR ALL CONDUIT, BOXES, DUCT, COMMUNICATION RACKS, SHOW IN DRAWINGS FOR REFERENCE ONLY.


REFERENCE NOTES:

- SEE TS-5-100, TYPICAL FOR ALL CLASSROOMS. PROVIDE 27" MULTI-MEDIA MONITOR & (1) 5-MIN VCR IN WALL MOUNT BRACKET.
- PROVIDE 27" MULTI-MEDIA MONITOR IN CLASSROOMS BY DIVISION. PROVIDE 27" MONITOR/BRACKET AND NO VCR. MOUNT AT 36" TO BOTTOM OF BRACKET.
- SEE TS-5-103, PROVIDE 36" MONITOR/BRACKET AND NO VCR. MOUNT AT 36" TO BOTTOM OF BRACKET.
- SEE TS-5-103 FOR ADDITIONAL INFORMATION. PROVIDE 36" MONITOR/BRACKET AND NO VCR. MOUNT AT 36" TO BOTTOM OF BRACKET.
- PROVIDE 36" MONITOR/BRACKET AND NO VCR. MOUNT AT 36" TO BOTTOM OF BRACKET.
- PROVIDE 36" MONITOR/BRACKET AND NO VCR. MOUNT AT 36" TO BOTTOM OF BRACKET.
- PROVIDE 27" MULTI-MEDIA MONITOR/BRACKET ONLY. PROVIDE 27" MONITOR/BRACKET ONLY. NO VCR.
- PROVIDE ONE (1) 7" T. CONNECTOR IN PLATE FOR LOCAL INPUT ONLY. NO MONITOR. NO VCR. MOUNT AT 18" AFF.
- PAY TELEPHONE LOCATION.
- SEE TS-5-11 (1) FOR ADDITIONAL INFORMATION.
- PROVIDE (1) 7" PORT AND PLATE FOR PORTABLE/FUTURE MONITOR. PROVIDE NO MONITOR. PROVIDE NO VCR. MOUNT AT 36" TO BOTTOM OF BRACKET.
- SEE TS-5-11 (1) FOR ADDITIONAL INFORMATION.
- INTERCOM HORN SPEAKER MOUNTED AT 12" AFF OR NEAR CEILING.
- INTERCOM HORN SPEAKER MOUNTED 15' ABOVE GROUND.
- CABLE TRAY SHOWN FOR REFERENCE ONLY.
- CEILING SPEAKERS. ROUTE TO ROOM W/IN/W/AFTER.
- SURFACE MOUNT ADDITIONAL SPEAKERS.
- WALL MOUNT 54"X7" PROJECTION SCREEN.
- CEILING MOUNT LID PROTECTOR. ROUTE CABLE TO AV EQUIPMENT RACK.
- ADDITIONAL EQUIPMENT RACK.

KEY PLAN:

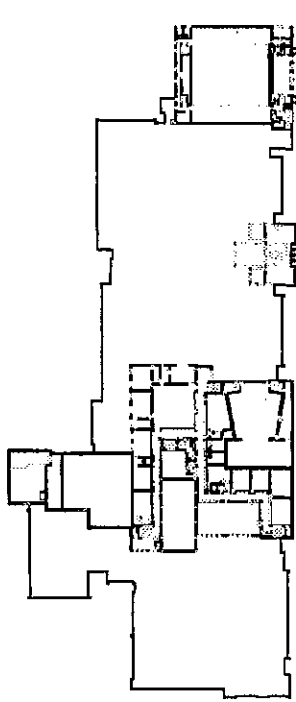

NORTH
SCALE: NTS

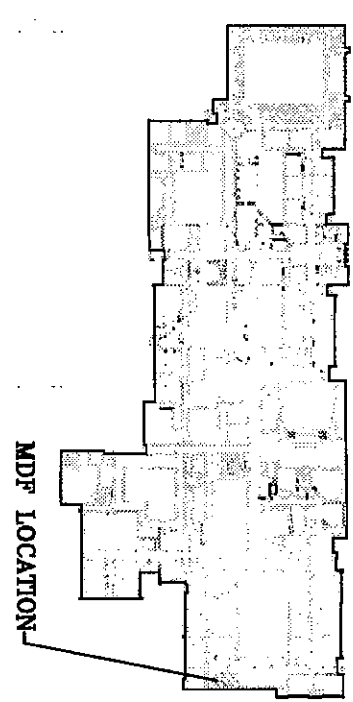

D & A INC.
Technology Design Consultants
1443 East 196th Street
Mokena, IL 60449-9530
708.534.5152
D & A ARCHITECTS

ARCHITECTS
ENGINEERS
PLANNERS

**VEAZEY
PARROTT
DURKIN &
SHOULDERS**

RENOVATION PROJECT FOR:
**DUNE AND SCHOOL
CORPORATION**
OBERLIN, INDIANA

Drawing Title:
**TECHNOLOGY SYSTEMS REFLECTED
CEILING PLAN (MDF DETAIL)**

Project Date: 6-14-2000
Drawn By: TDES
Approved By: LMD
Drawing No: **TS 3.8**

1
REFLECTED CEILING PLAN
SCALE: 1/8"=1'-0"

MDF