


- GENERAL NOTES:
- DIVISION 16 CONTRACTOR RESPONSIBLE FOR ALL CONDUIT, BOXES, DUAL-COMPONENT RACEWAYS, CABLE TRAY PROVIDED BY DIVISION 16 CONTRACTOR SHOWN IN DRAWINGS FOR REFERENCE ONLY.

REFERENCED NOTES

- SEE TS-5-102, TYPICAL FOR ALL CLASSROOMS. PROVIDE WALL MOUNT MONITOR & (1) 5-WAY FOR IN-WALL MOUNT PROJECTOR.
- WALL MOUNT DEVICES (PLATE/PORT) IN RECESS PROVIDED BY DIVISION 16 CONTRACTOR. TYPICAL AS SHOWN, PROVIDE NO VCR. MOUNT AT 5' TO BOTTOM OF BRACKET.
- SEE TS-5-110 FOR ADDITIONAL INFORMATION.
- PROVIDE EQUIVALENT NUMBER OF CAT 6 CABLES AND COAX TO PROVIDE SOME SHOWN (AS NOT SHOWN). PROVIDE 30' COIL IN CASE IN CENTER OF SPACE.
- PROVIDE 30' OF CAT 6 CABLE COILED NEATLY ABOVE CEILING FOR AND USE FOR FUTURE.
- PROVIDE 27" MULTI-MEDIA MONITOR/BROCKET ONLY. NO VCR. LOOP SIGNALS FROM PRIMARY MONITOR.
- PROVIDE ONE (1) "T" CONNECTOR IN PLATE FOR LOCAL PAY TELEPHONE LOCATION. NO VCR. MOUNT AT 10' AFT.
- SEE TS-5-111 FOR ADDITIONAL INFORMATION.
- PROVIDE (1) "T" PORT AND PLATE FOR PORTABLE/FUTURE MONITOR. PROVIDE NO VCR.
- PROVIDE 36" MULTI-MEDIA MONITOR/BROCKET. NO VCR. SEE TS-5-111 (5).
- INTERCOM HORN SPEAKERS MOUNT AT 12' AFT OR NEAR CEILING.
- INTERCOM HORN SPEAKERS MOUNTED 15' ABOVE GROUND. TYPICAL OF 16.
- SURFACE MOUNT AUDIOVISUAL SPEAKER.
- WALL MOUNT 9"X12" PROJECTOR. ROUTE CABLE TO AV CEILING MOUNT LED PROJECTOR. ROUTE CABLE TO AV CEILING MOUNT LED PROJECTOR.
- AUDIOVISUAL EQUIPMENT RACK.

KEY PLAN:

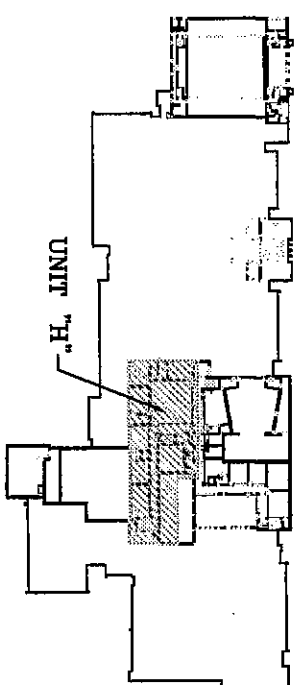

DS&A INC.
Technology Design Consultants
16616 East 196th Street
Northbrook, IL 60062-9530
765.934.5152
D S R A . I N C .

ARCHITECTS
ENGINEERS
PLANNERS

**VEAZEY
PARROTT
&
SHOULDERS**

3800 Priority Way S. Dr.
Suite 100
Overland Park, KS 66204

RENOVATION PROJECT FOR:
**DUNELAND SCHOOL
CORPORATION**
CHESTERTON MIDDLE SCHOOL
CHESTERTON, INDIANA

Drawing Title:
**TECHNOLOGY SYSTEMS, REFLECTED
CEILING PLAN (UNIT 17)**

Project No. 99-1024
Project Date: 6-14-2000
Drawn By: TDES
Approved By: LMD

1 REFLECTED CEILING PLAN
TS 4.1 SCALE: 1/8"=1'-0"

UNIT H

