


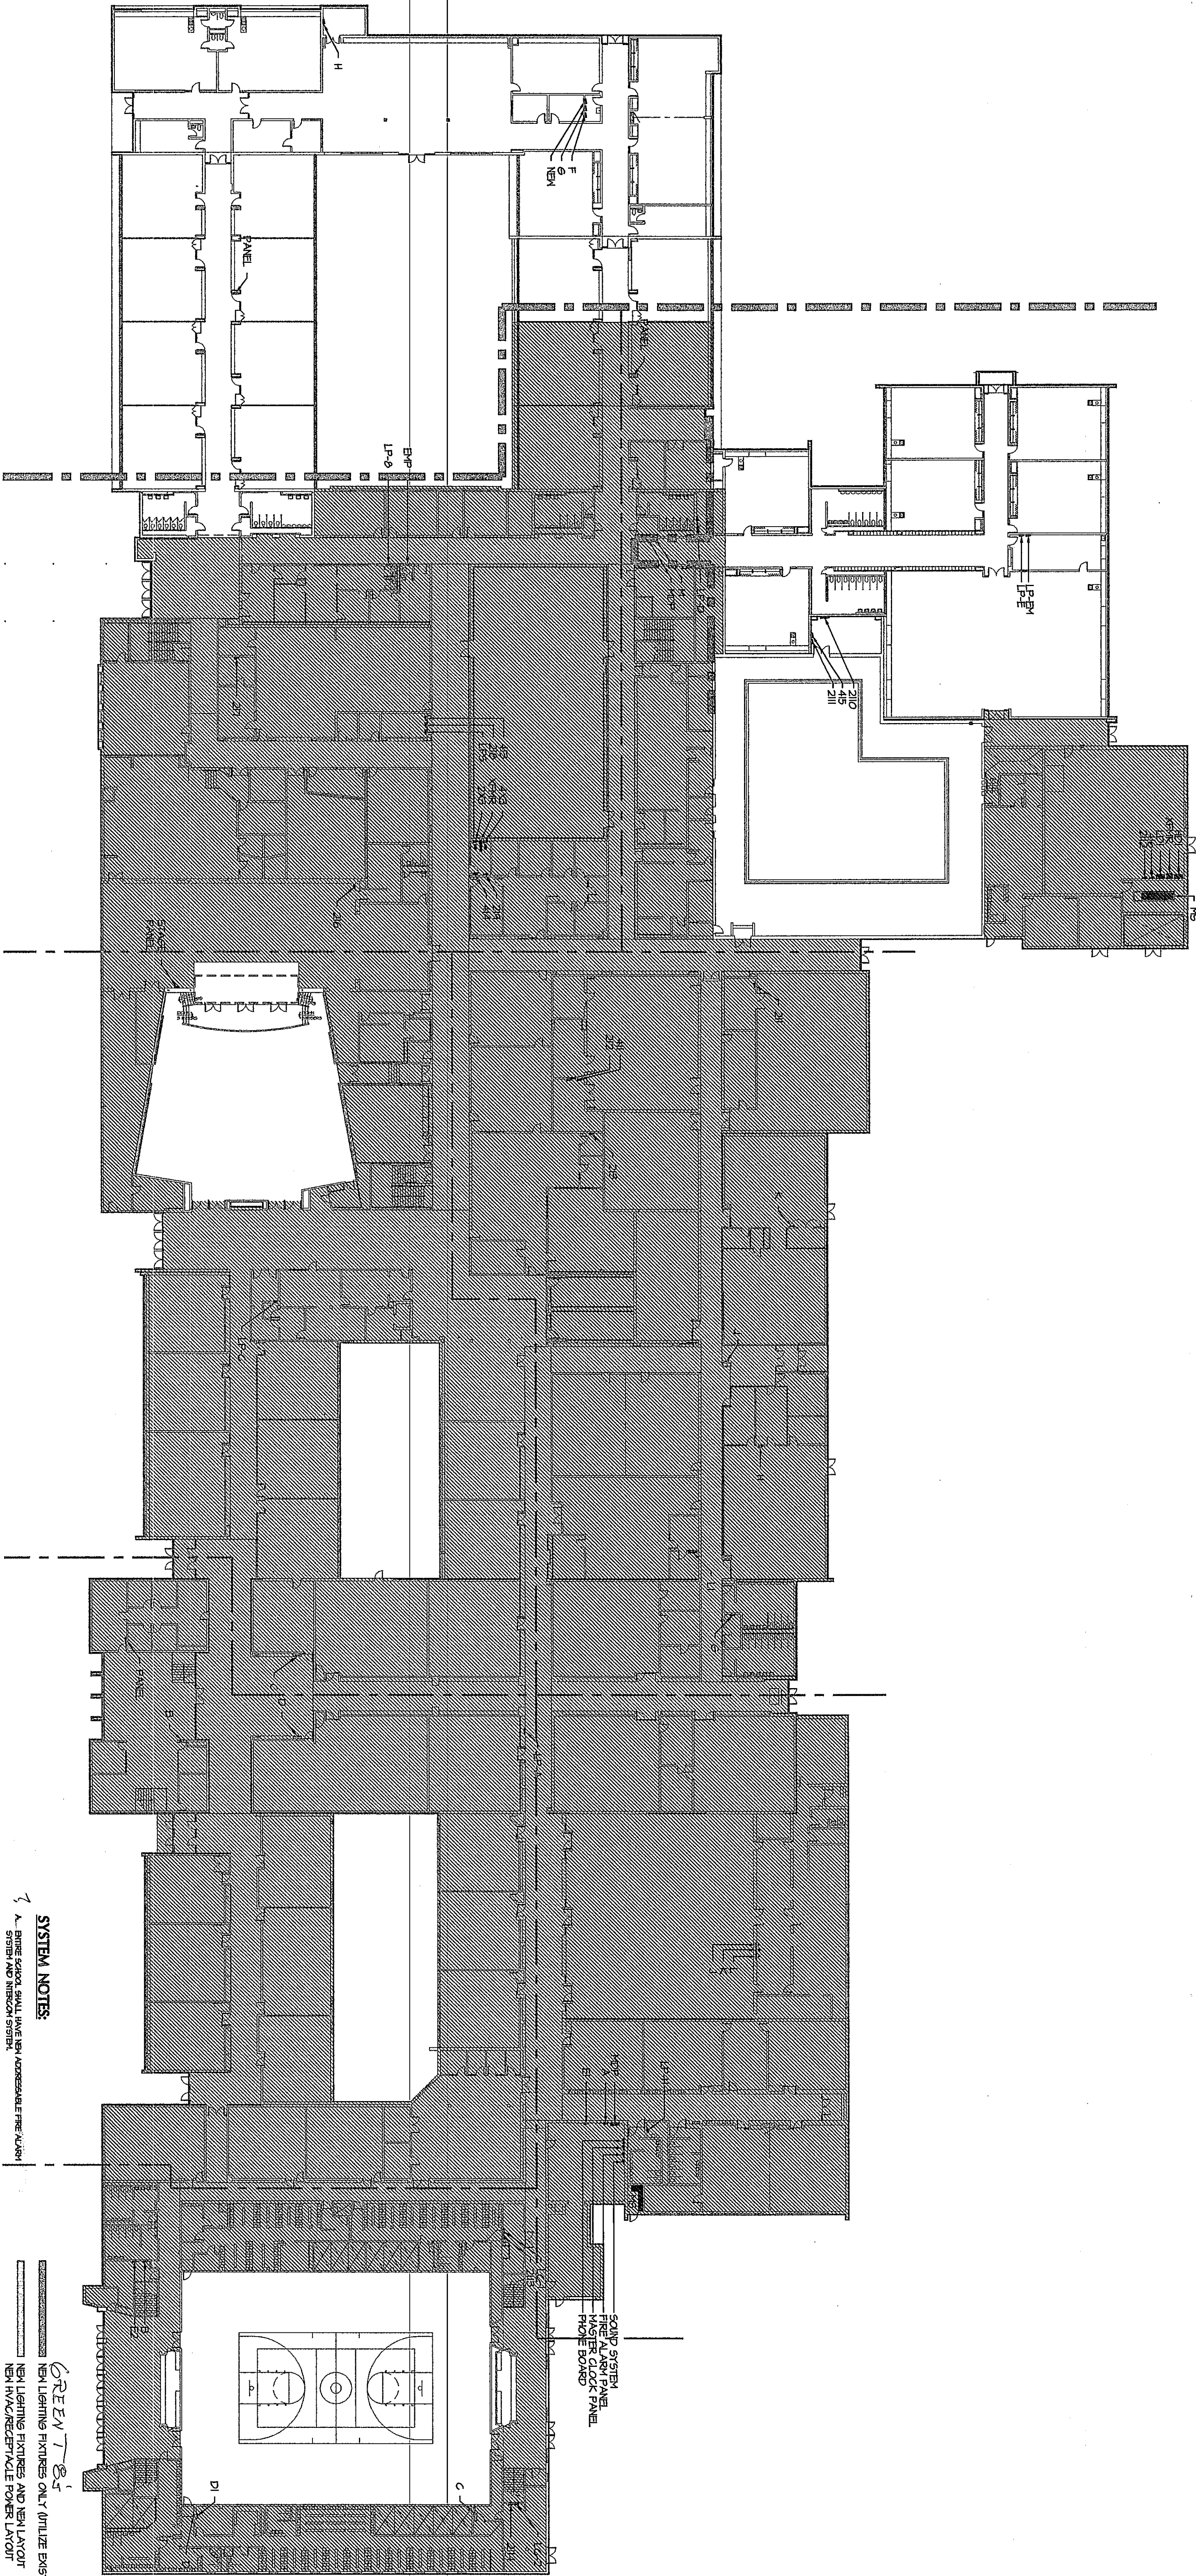

SYSTEM NOTES:
A. BRINE SPOKE SHALL HAVE BRINE APPROPRIATE FIRE RATING
B. ALL SYSTEMS SHALL BE INSTALLED IN ACCORDANCE WITH THE
C. ALL SYSTEMS SHALL BE INSTALLED IN ACCORDANCE WITH THE
D. ALL SYSTEMS SHALL BE INSTALLED IN ACCORDANCE WITH THE

HVAC POWER SYSTEM NOTES:
A. ALL SYSTEMS SHALL BE INSTALLED IN ACCORDANCE WITH THE
B. ALL SYSTEMS SHALL BE INSTALLED IN ACCORDANCE WITH THE
C. ALL SYSTEMS SHALL BE INSTALLED IN ACCORDANCE WITH THE
D. ALL SYSTEMS SHALL BE INSTALLED IN ACCORDANCE WITH THE

EXISTING FLOOR PLANS:
SCALE: 1" = 30'-0"

**VEAZEY
PARROT &
SHOULDERS**

ARCHITECTS
PLANNERS

RENOVATION PROJECT FOR:
DUNELAND SCHOOLS
DUNELAND HIGH SCHOOL/MIDDLE SCHOOL
DUNELAND, INDIANA

Drawing Title:
SCHEMATIC DESIGN FLOOR PLANS

Project No: 0180025
Project Date: 1-24-00
CDD file name: 0180025.dwg
Plot Date: 1-24-00
Drawing No:

E 3.1