

ZONE #X (NEW ADMINISTRATION)  
VAV AIR HANDLING UNIT  
DX COOLING & HW HEAT  
REHEAT VAV BOXES

ZONE #X (RENOVATED CLASSROOMS)  
4-PIPE UNIT VENTILATORS FOR CLASSROOMS  
4-PIPE FAN COIL UNITS FOR OFFICES  
O/A FROM WALL LOUVER

ZONE #X (RENOVATED ROOMS ADJACENT TO CAFE)  
VAV AIR HANDLING UNIT  
CM COOLING & HW HEAT  
REHEAT VAV BOXES

ZONE #X (CLASSROOMS, LECTURE, & CAFE)  
SINGLE ZONE AIR HANDLING UNIT  
CM COOLING & HW HEAT

ZONE #X (SECOND STM & MECH SHOP)  
SINGLE ZONE AIR HANDLING UNIT  
HW HEAT ONLY

ZONE #X (VARIOUS CLASSROOMS & OFFICES)  
4-PIPE FAN COIL UNITS  
O/A FROM NEW AHU B1

ZONE #X (VARIOUS CLASSROOMS & OFFICES)  
4-PIPE FAN COIL UNITS  
O/A FROM NEW AHU B2


ZONE #X (CORRIDORS, LOCKER ROOMS, & RESTROOMS)  
CABINET HEATERS & FAN COIL UNITS

ZONE #X (RENOVATED CLASSROOMS)  
2-PIPE UNIT VENTILATORS FOR CLASSROOMS  
2-PIPE FAN COIL UNITS FOR OFFICES  
O/A FROM WALL LOUVER

ZONE #X (SECOND STM & MECH SHOP)  
2-PIPE SINGLE ZONE AIR HANDLING UNIT


ZONE #X (KITCHEN)  
FUTURE WORK

ZONE #X (AUDITORIUM)  
FUTURE WORK

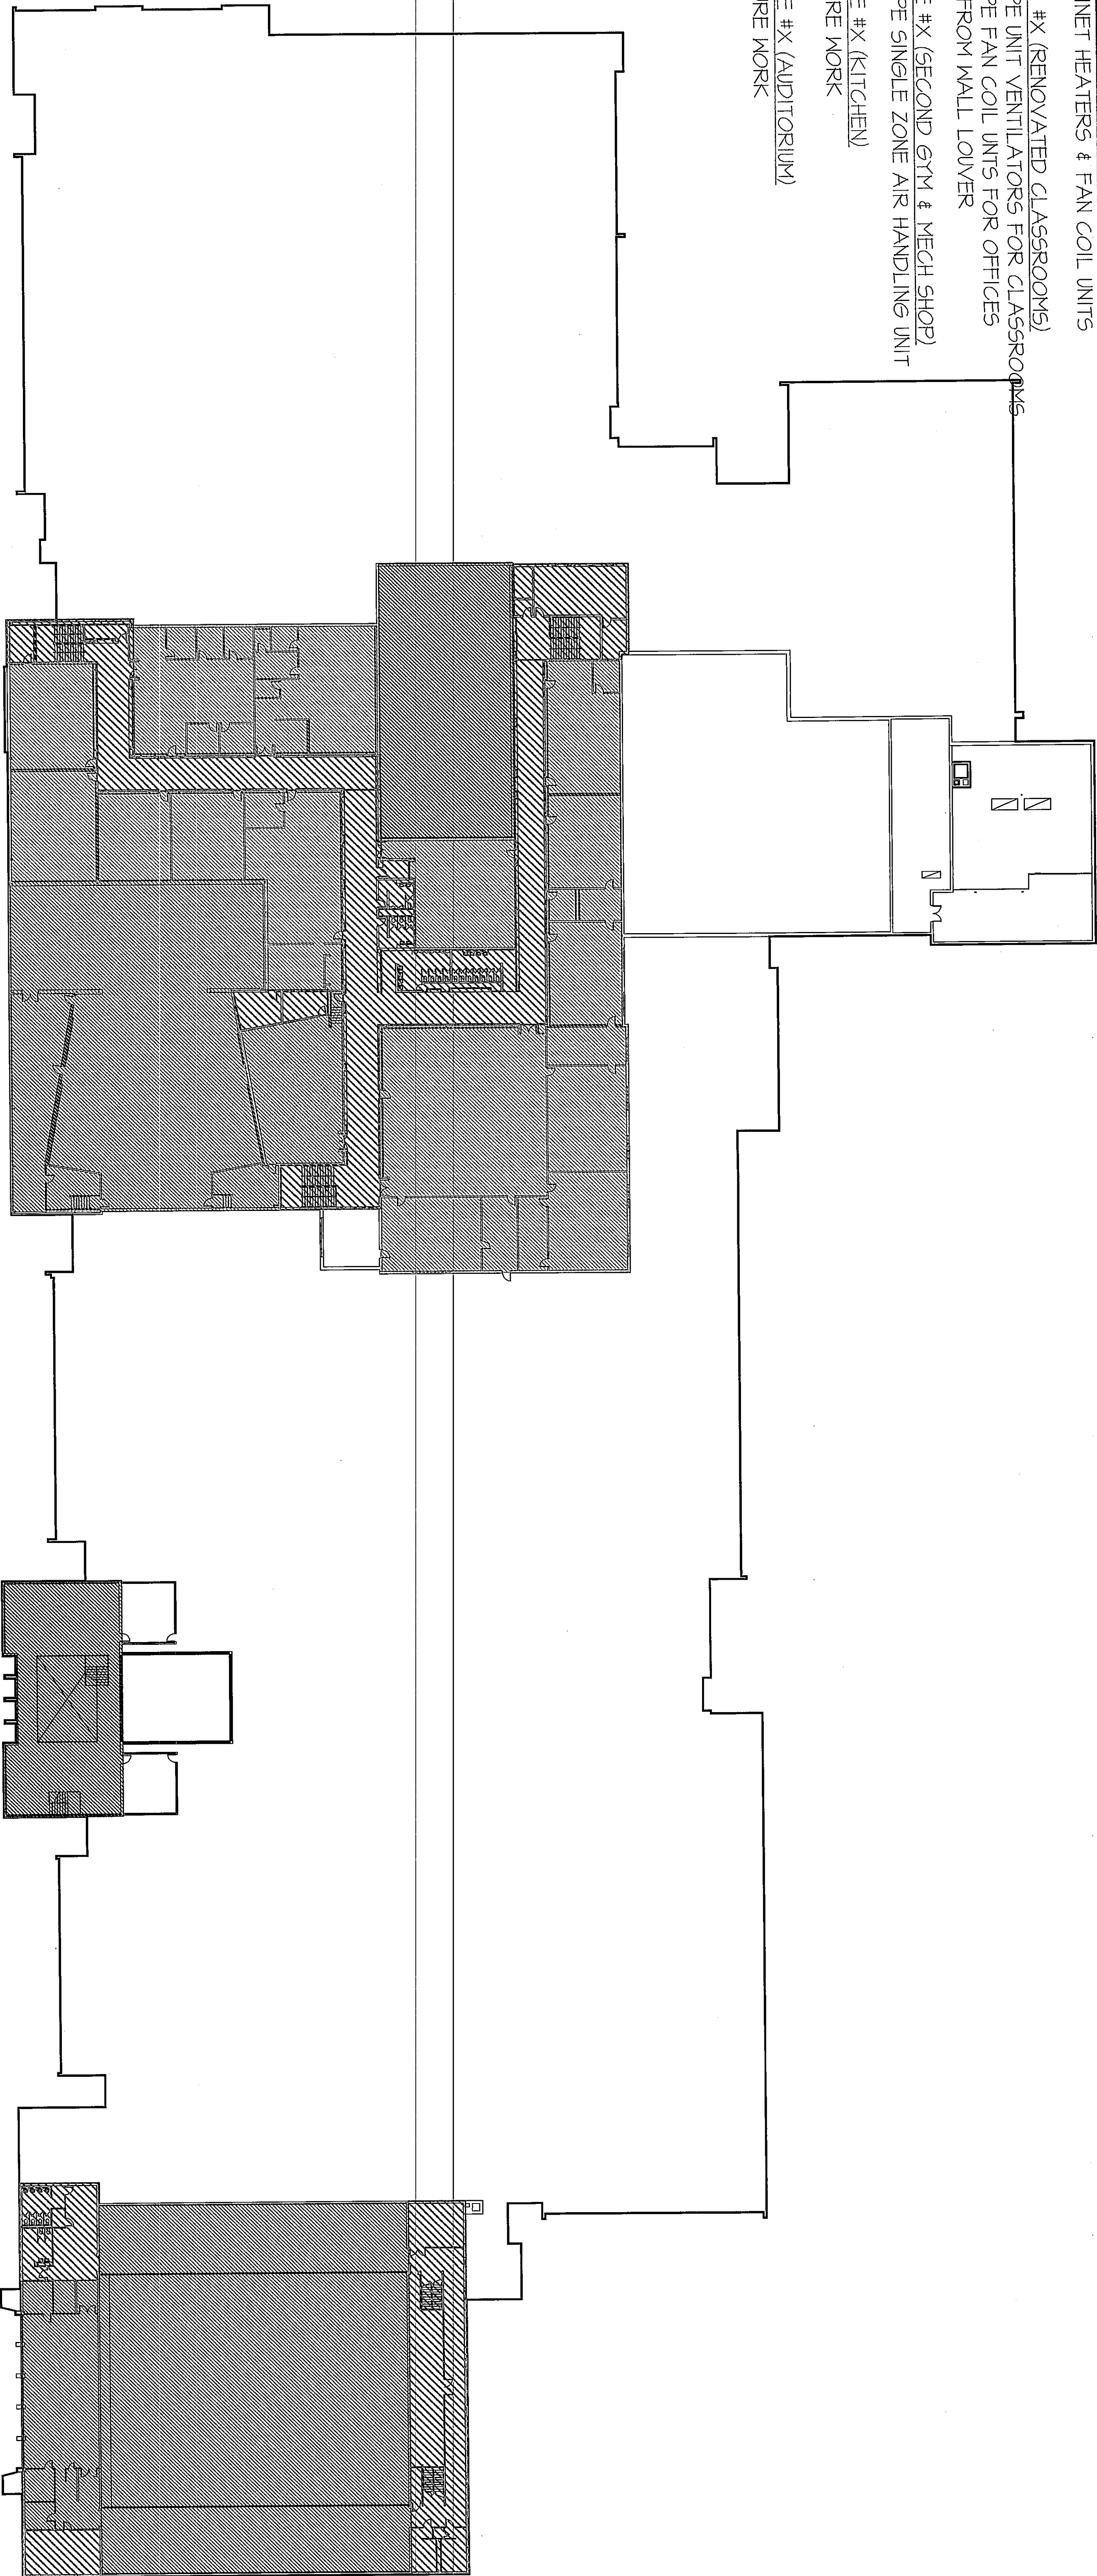

HVAC PLAN SECOND FLOOR  
SCALE 1" = 30'-0"

|                                    |                             |
|------------------------------------|-----------------------------|
| RENOVATION PROJECT FOR:            |                             |
| DUNELAND SCHOOLS                   |                             |
| DUNELAND HIGH SCHOOL/MIDDLE SCHOOL |                             |
| DUNELAND, INDIANA                  |                             |
| Drawing Title:                     | HVAC PLAN SECOND FLOOR PLAN |
| Project No:                        |                             |
| Project Date:                      |                             |
| CAD file name:                     | XXXXXXXX                    |
| CAD plot date:                     |                             |
| Drawing No:                        | M 2.0                       |

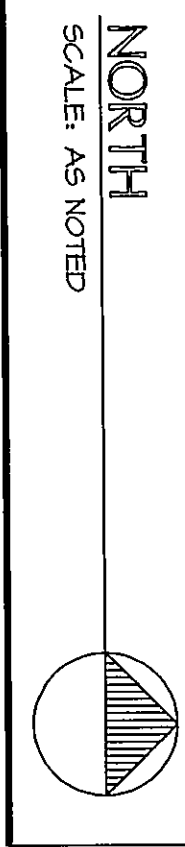

VEAZEY  
PARROTT &  
SHOULDERS

ARCHITECTS  
ENGINEERS  
PLANNERS

8000 Peachtree Hwy S.W.  
Atlanta, GA 30340  
404-252-9970

08-M-02