


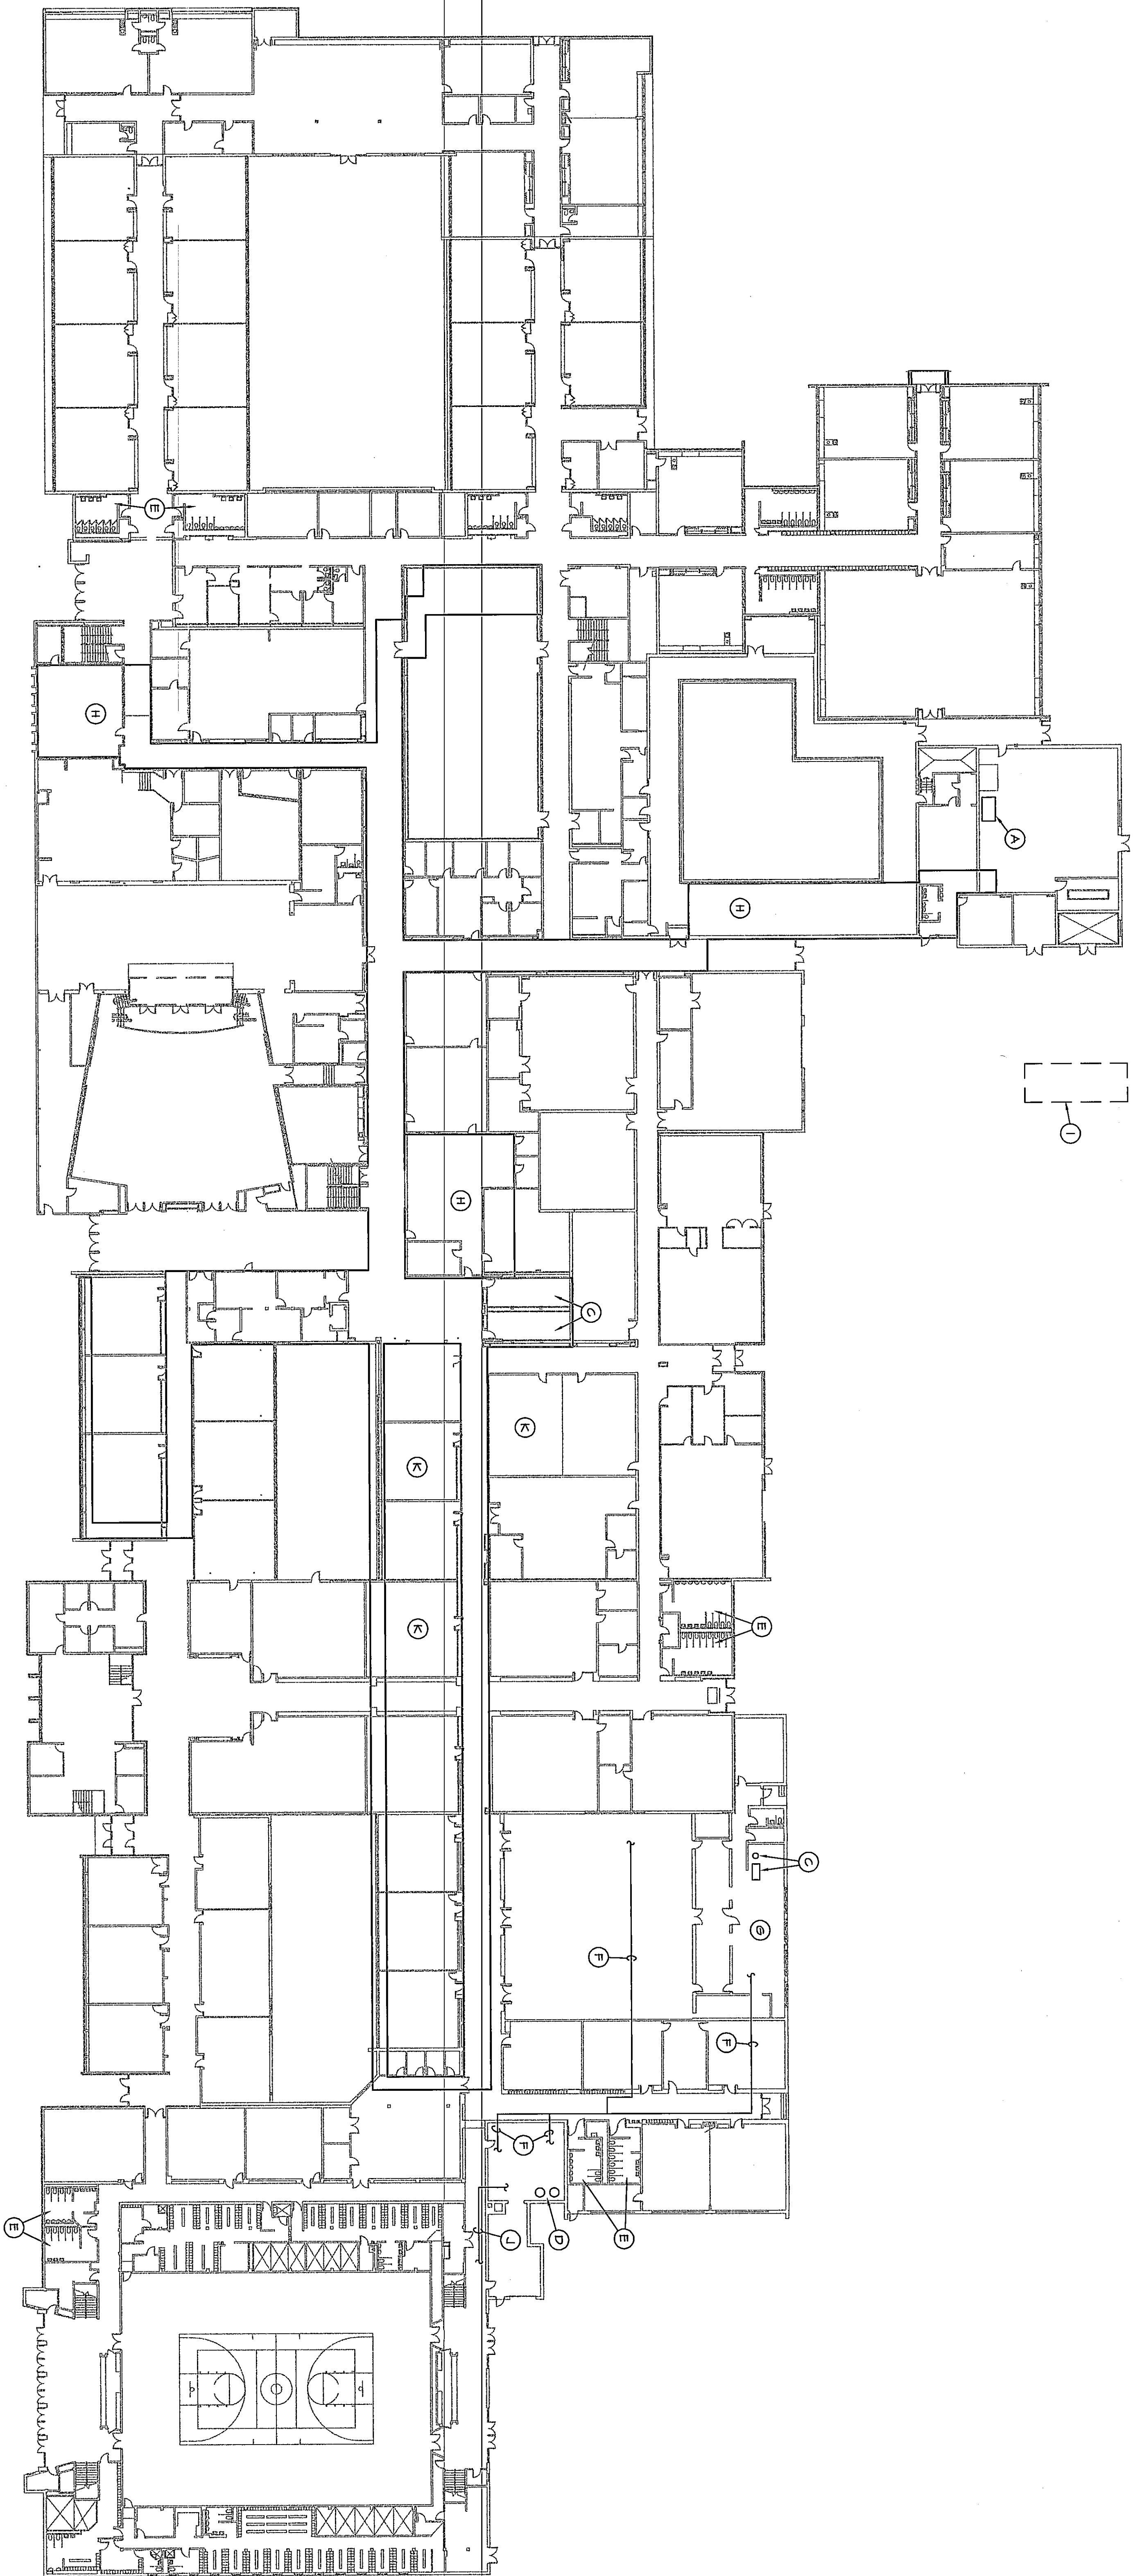

PLUMBING PLAN - FIRST FLOOR
SCALE: 1/8" = 1'-0"

- REFERENCE NOTES**
- A) EXISTING GAS LINES, WATER HEATERS SHALL BE REMOVED AND REPLACED WITH NEW WATER HEATER AND STORAGE TANK.
 - B) REMOVE GAS WATER HEATER, STORAGE TANK, AND GALVANIZED WATER PIPING IN REZONING ABOVE KITCHEN.
 - C) REMOVE PLUMBING FIXTURES AND PIPING IN TOILET ROOMS AND REPLACE WITH NEW.
 - D) REMOVE GAS WATER HEATERS, STORAGE TANK, AND PIPING. REPLACE WITH NEW GAS WATER HEATERS AND STORAGE TANK TO SUPPLY GYMNASIUM AND KITCHEN.
 - E) REPAIR TOILET ROOMS AND INSTALL ADA ACCESSIBLE FIXTURES.
 - F) REMOVE AND REPLACE OVERHEAD DOMESTIC WATER PIPING WITH NEW COPPER.
 - G) REMOVE AND REPLACE OVERHEAD DOMESTIC WATER PIPING IN KITCHEN WITH COPPER.
 - H) REMOVE AND REPLACE GALVANIZED DOMESTIC WATER PIPING IN TUNNELS WITH NEW COPPER.
 - I) RELOCATE GAS WATER ASSEMBLY OUT OF BUS LANE TRAFFIC.
 - J) EXISTING COPPER WATER PIPING TO GYMNASIUM SHALL REMAIN.
 - K) WATER MAIN FOR CLASSROOMS SHALL BE FED FROM TUNNEL TUNNELS BELOW FLOOR.

NORTH
SCALE: AS NOTED

**VEAZEY
PARROT &
SHOULDERS**
ARCHITECTS
ENGINEERS
PLANNERS

**RENOVATION PROJECT FOR:
DUNELAND SCHOOLS
DUNELAND HIGH SCHOOL/MIDDLE SCHOOL
DUNELAND, INDIANA**

Drawing Title:
SCHEMATIC DESIGN PLUMBING PLANS

Project No:	
Project Date:	
Old File Name:	P-001-001
File Name:	
Drawing No:	P 1.0

D06 P-01