


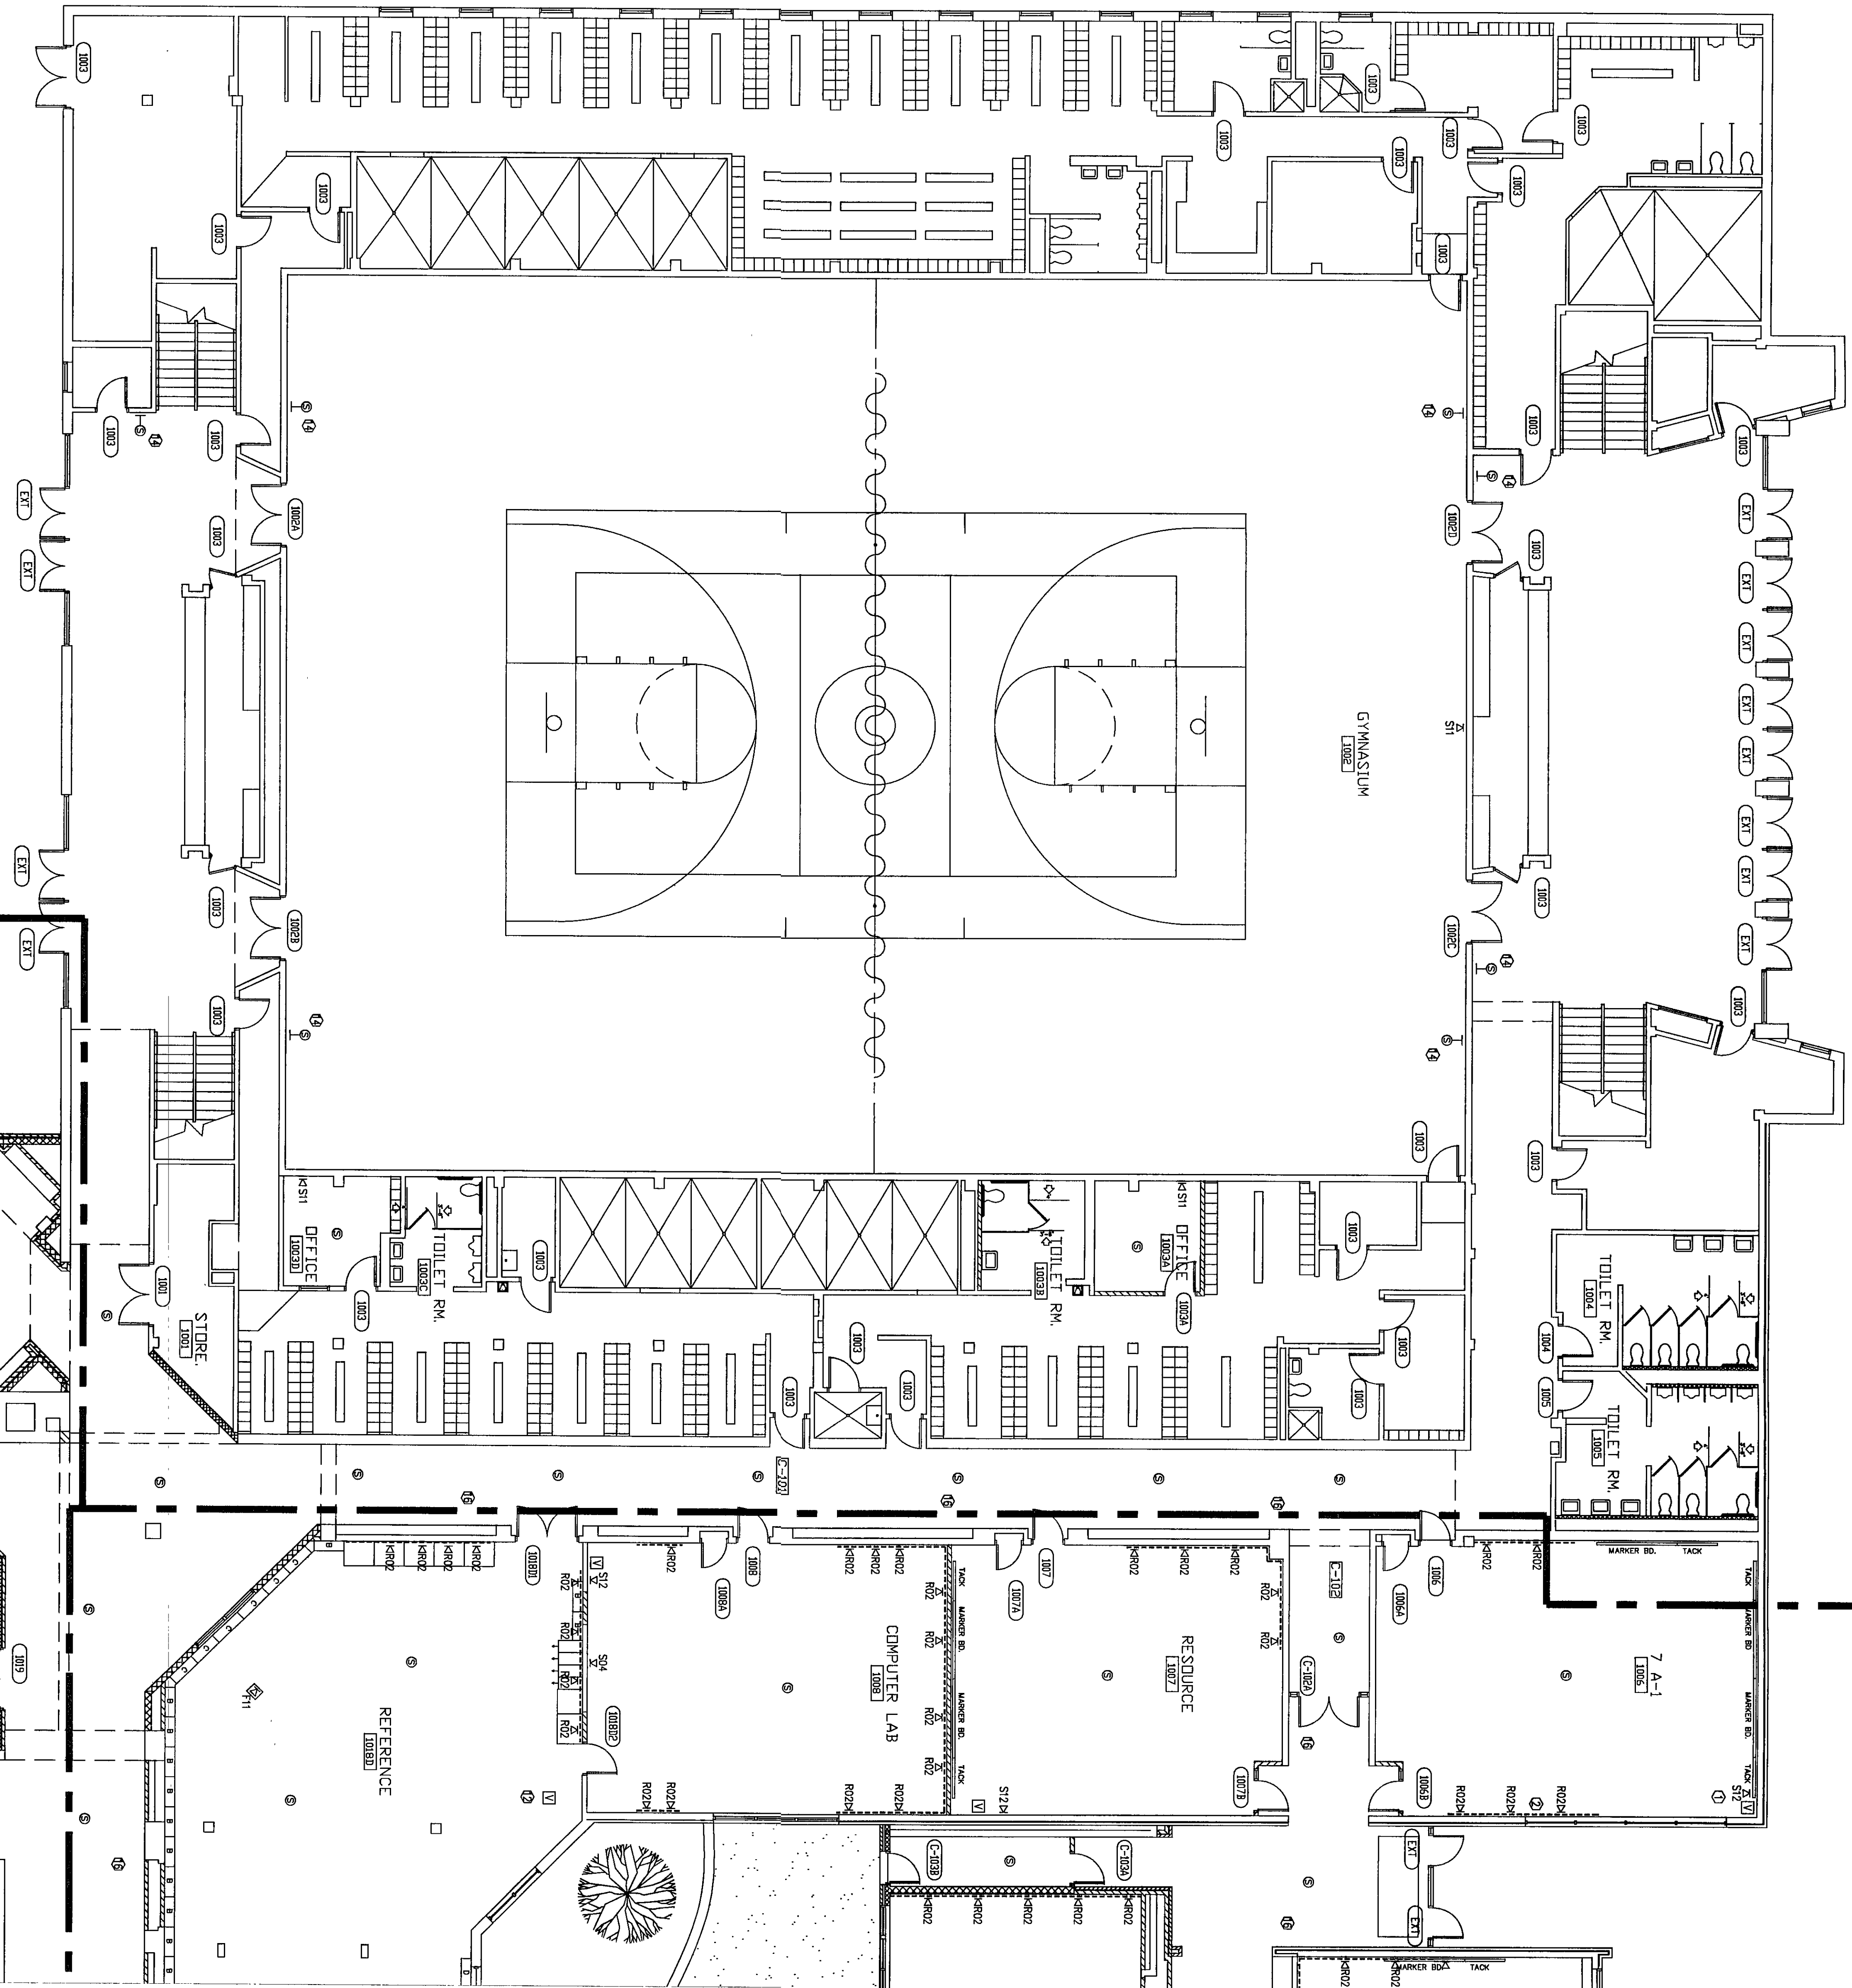


1 FLOOR PLAN
SCALE: 1/8"=1'-0"

REFERENCES

1. TYPICAL FOR ALL CLASSROOMS
2. 27" MULTI-MEDIA MONITOR & (1) 3-WAY VCR IN DESIGN (SEE PARTS) IN ROOMS PROVIDED BY DIVISION 16 CONTRACTOR. TYPICAL AS INDICATED.
3. 36" MONITOR/BRACKET AND 36" MONITOR/BRACKET IN BOTTOM OF BRACKET.
4. SEE TS-5-1(1) FOR ADDITIONAL INFORMATION.
5. NOT USED
6. 36" C/C CABLE COILED NEARLY ABOVE CEILING FOR FUTURE USE. OTHER END TERMINATED
7. 27" MULTI-MEDIA MONITOR/BRACKET ONLY, NO VCR. SIGNALS LOOTED FROM PRIMARY MONITOR.
8. 27" MONITOR/BRACKET ONLY, NO VCR.
9. ONE (1) "T" CONNECTOR IN PLATE FOR LOCAL MONITOR.
10. SEE TS-5-1(1) FOR ADDITIONAL INFORMATION.
11. ONE (1) "T" PORT AND PLATE FOR PERIPHERAL/FUTURE MONITOR. NO MONITOR OR VCR.
12. 36" MULTI-MEDIA MONITOR/BRACKET. NO VCR.
13. INTERCOM HORN SPEAKERS MOUNTED AT 12' AFF OR NEAR CEILING.
14. INTERCOM HORN SPEAKERS MOUNTED 15' ABOVE GROUND.
15. CABLE TRAY SHOWN FOR REFERENCE ONLY.
16. CEILING SPEAKERS. ROUTED TO ROOM W/IN/OUTLET.
17. SURFACE MOUNT AUDIOVISUAL SPEAKERS.
18. WALL MOUNTED 5000 PROJECTION SCREEN.
19. CEILING MOUNTED LCD PROJECTOR. CABLE ROUTED TO AV EQUIPMENT RACK.
20. AUDIOVISUAL EQUIPMENT RACK.

SYMBOL LEGEND

PART DESIGNATIONS:

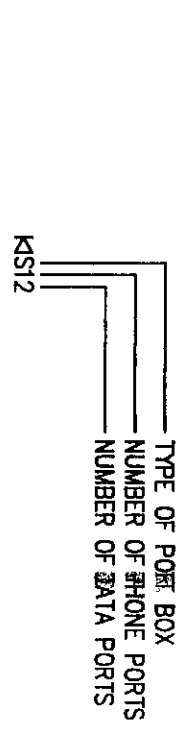


PORT BOX TYPES:

- S = SINGLE GANG MOUNTED 48" AFF
- W = SINGLE GANG MOUNTED 48" AFF
- R = RACKWAY PLATE
- O = OLD BOX MOUNTED 16" AFF
- C = COILED CABLE IN CEILING FOR FUTURE USE

OTHER SYMBOLS

- [Symbol] = NEW VIDEO MONITOR
- [Symbol] = NEW RACKWAY
- [Symbol] = NEW CEILING SPEAKER
- [Symbol] = NEW WALL SPEAKER
- [Symbol] = CABLE TRAY PROVIDED BY DIVISION 16
- [Symbol] = SEE "T" SERIES FOR MORE DETAIL

KEY PLAN:

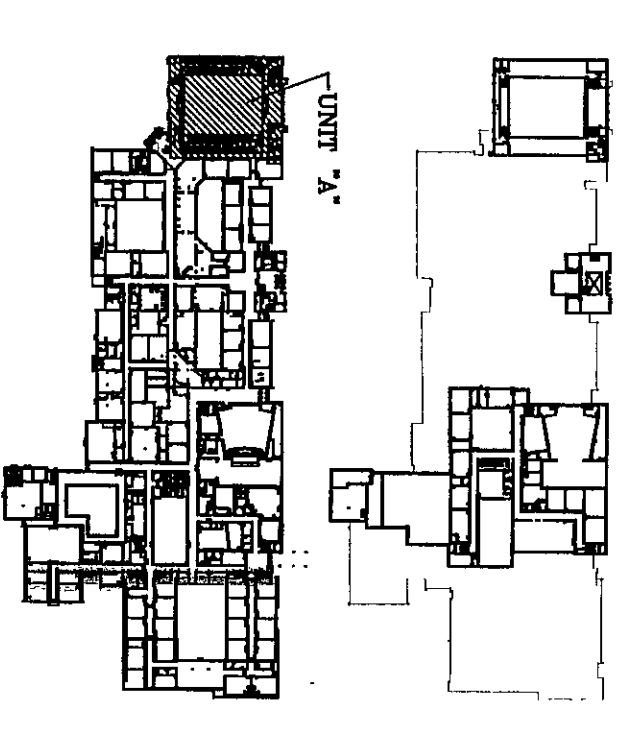

NORTH
SCALE: NTS

D & A
Technology Design Consultants
16618 East 196 th Street
Noblesville IN 46060-9530
765/534-5152
D & A INCORPORATED

VEAZEY PARROTT DURKIN & SHOULDERS
ARCHITECTS
ENGINEERS
PLANNERS

6000 Lincoln Ave. S.E.
Indianapolis, IN 46216

TRI ELECTRONICS
6231 Colimet Avenue
P.O. Box 4310
Hommond IN 46324
(219) 931-6850 (312) 862-4998
(800) 722-6793
Fax: (219) 933-3545

DESIGN BY: DRAWING NO: TS 1.1