


1 FLOOR PLAN
SCALE: 1/8"=1'-0"
UNIT C

**TRI ELECTRONICS**

6231 Calumet Avenue
P.O. Box 4310 46324
Hammond, IN
(219) 931-6850 (312) 862-4998
1 (800) 722-6793
Fax: (219) 933-3545

CHESTERSTON MIDDLE SCHOOL
TECHNOLOGY FLOOR PLAN UNIT "C"

 
SCALE: NONE
DATE: 8/27/02
DRAWN BY: A.O.
CHECKED BY: A.O.
DESIGN BY: TS 1.3


**VEAZEY
PARROTT
DURKIN &
SHOULDERS**

ARCHITECTS
ENGINEERS
PLANNERS


2005 University Way S. Ste.
Suite 1100
Indianapolis, IN 46204

D & A
INC. A
Technology Design Consultants
16618 East 196 th Street
Noblesville IN 46060-9530
765/534-5152
D & A INCORPORATED



NORTH
SCALE: NTS

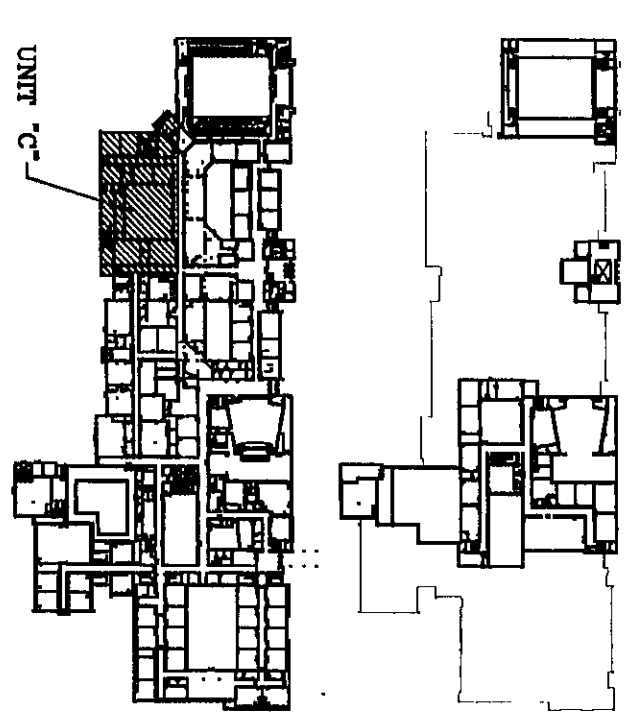
UNIT "C"


KEY PLAN:

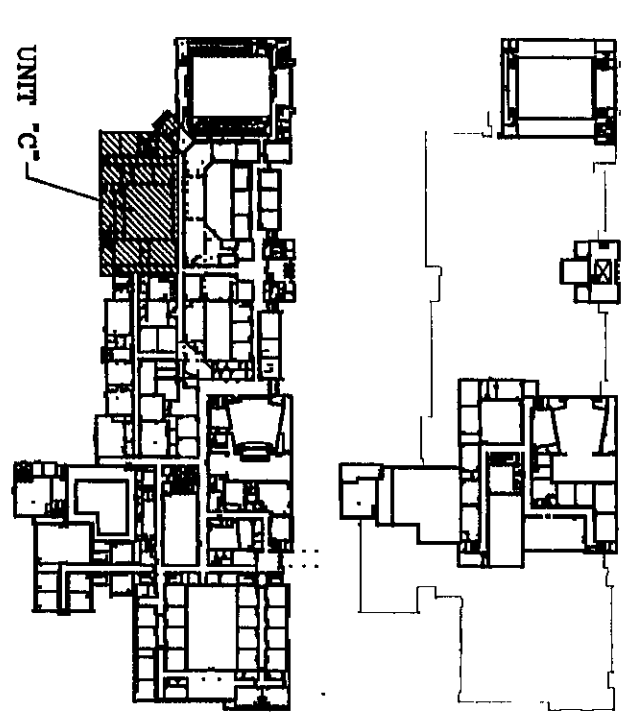
UNIT "C"


OTHER SYMBOLS:

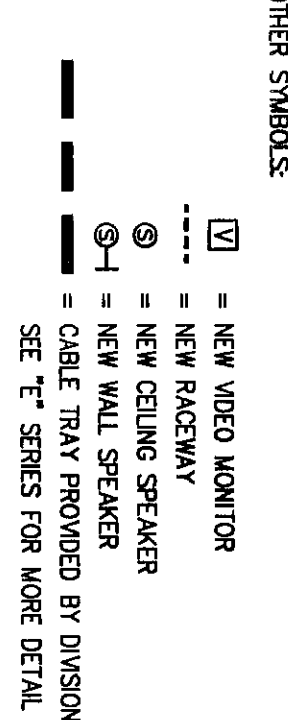

PORT BOX TYPES:

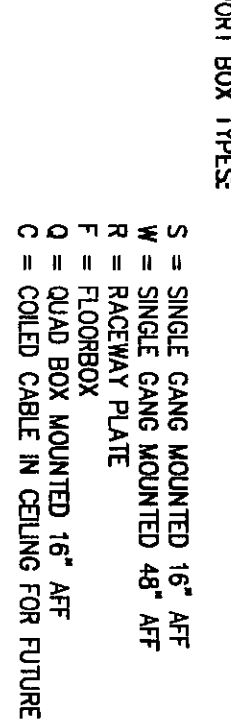

PORT DESIGNATIONS:

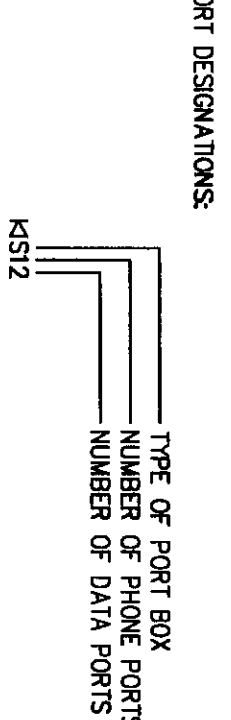

SYMBOL LEGEND

