


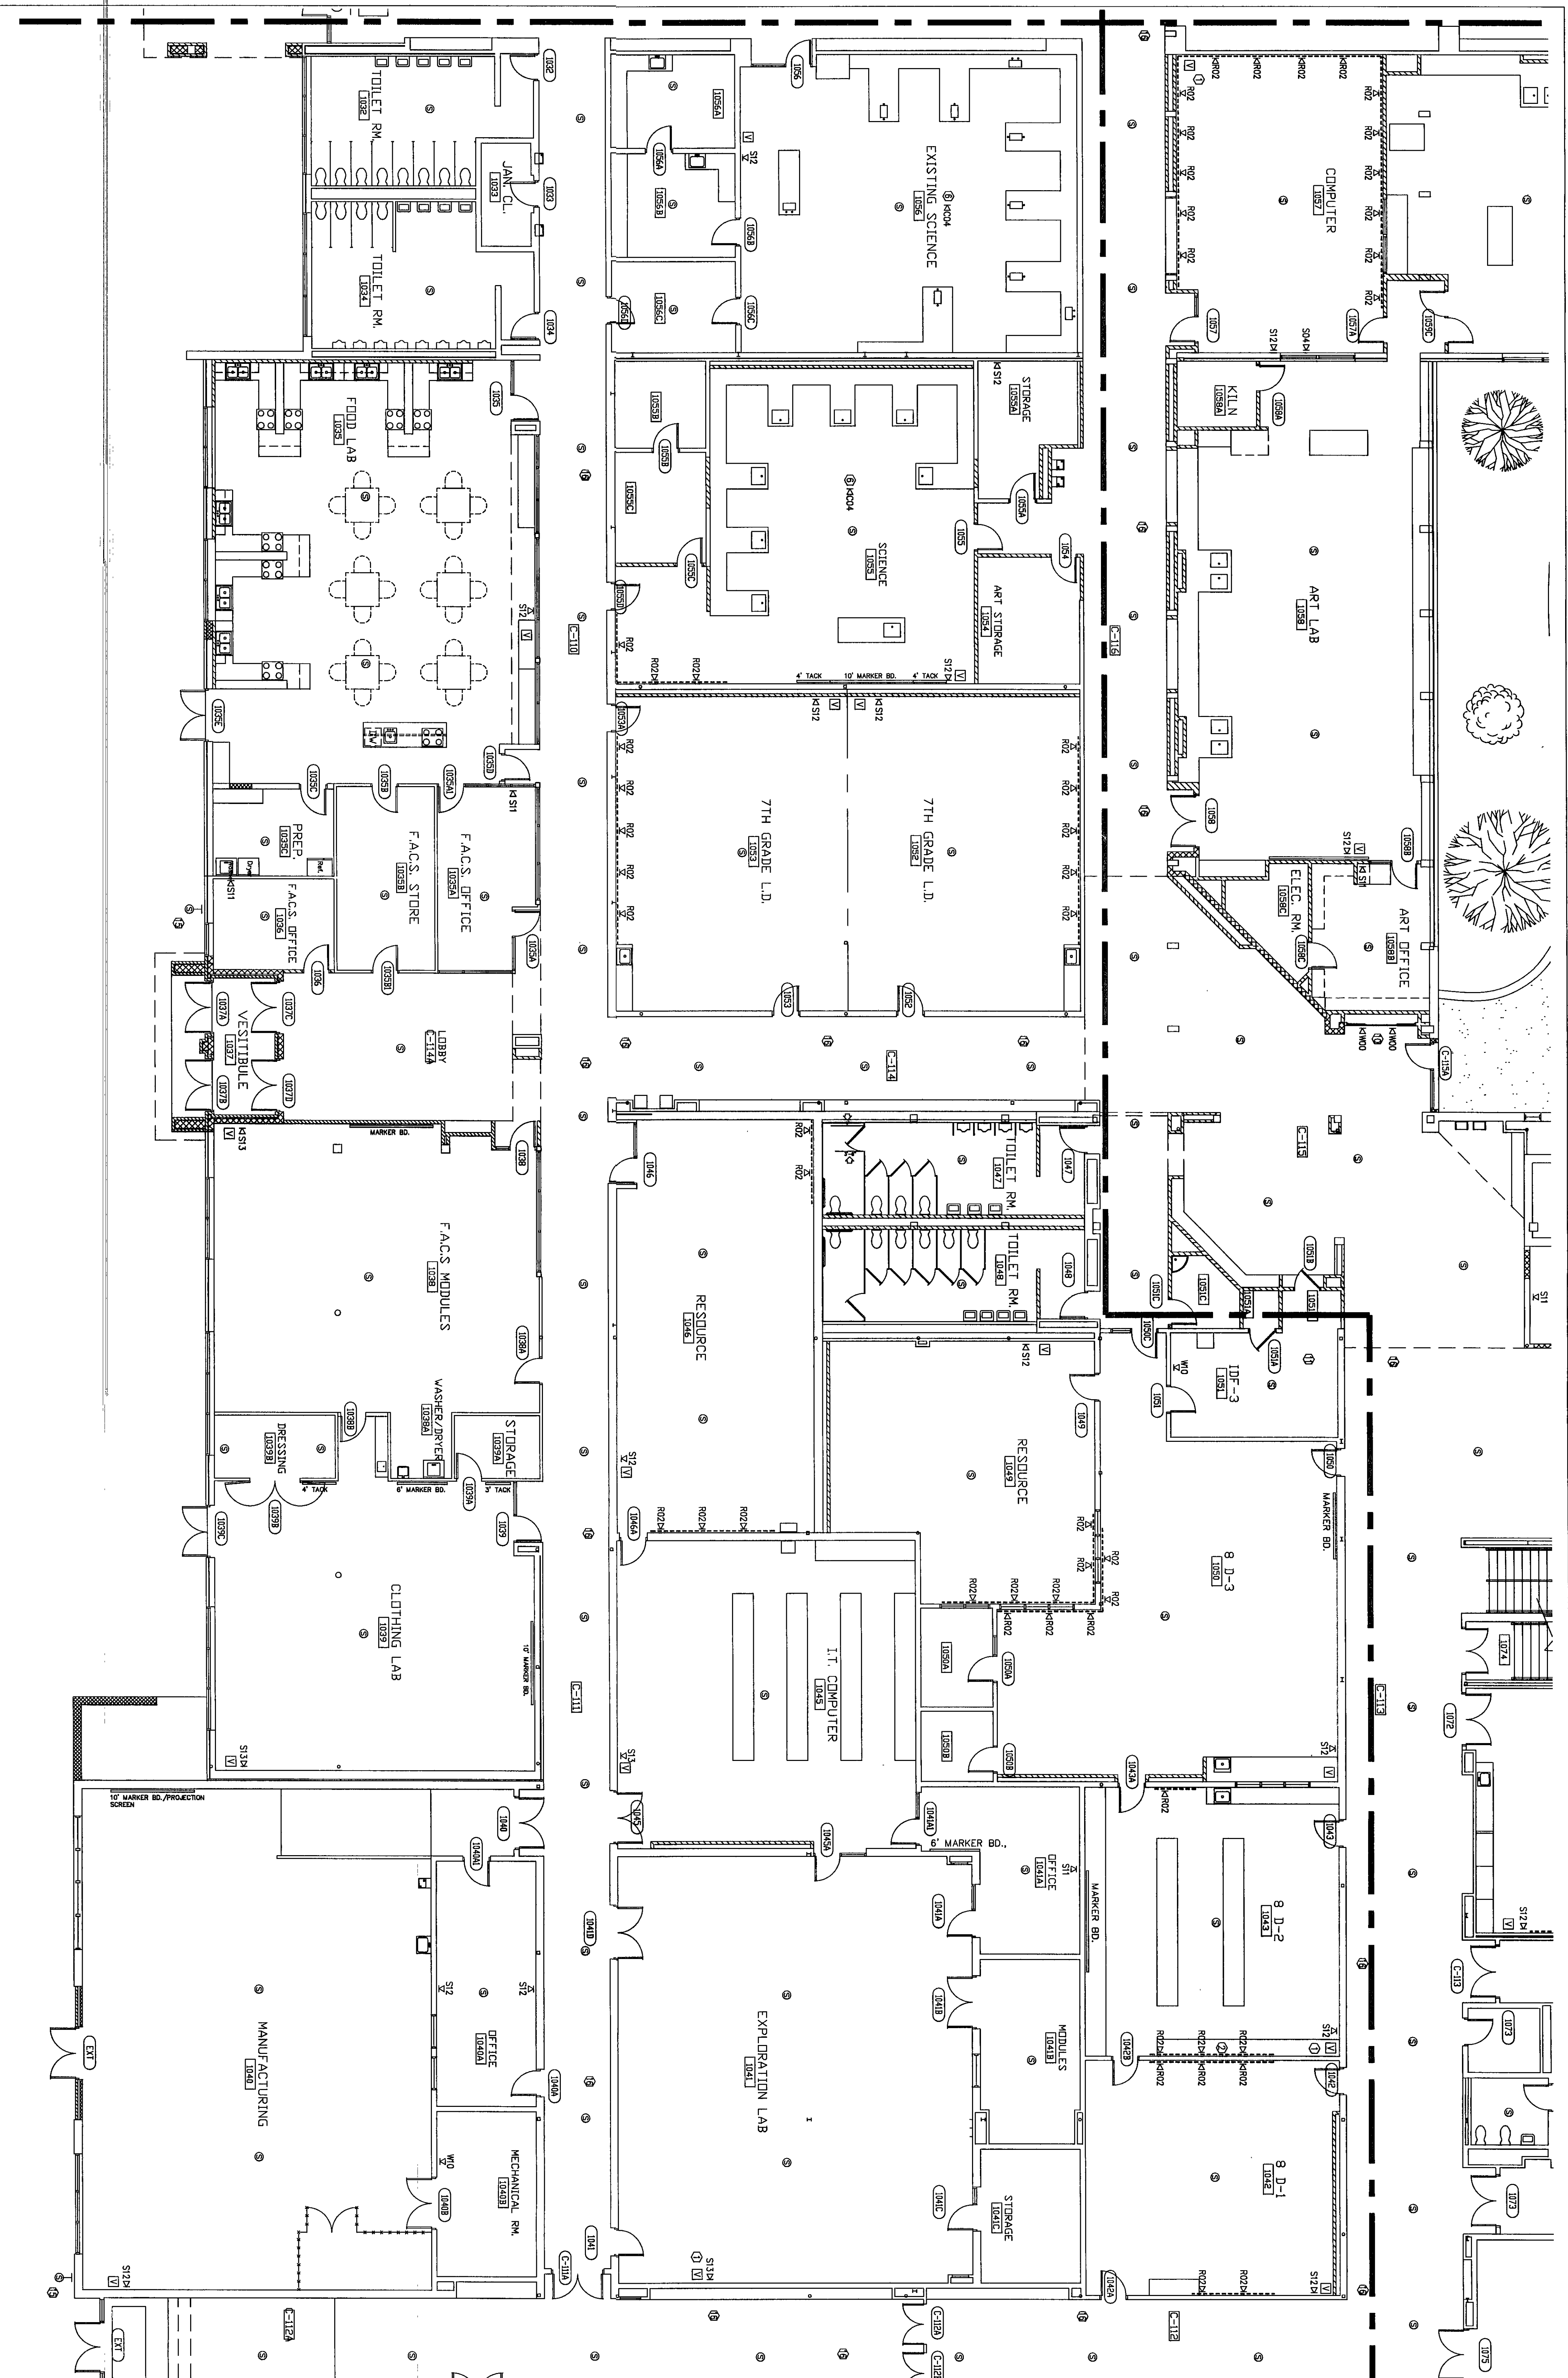

1 FLOOR PLAN
SCALE: 1/8"=1'-0"
UNIT: E

TRI ELECTRONICS

6231 Calumet Avenue
P.O. Box 4310
Hommond, IN 46324
(219) 931-6850 (312) 862-4998
1 (800) 722-6793
Fax: (219) 933-3545

CHESTERSTON MIDDLE SCHOOL
TECHNOLOGY FLOOR PLAN UNIT "E"

SCALE: NONE
DATE: 8/27/02
DRAWN BY: A.O.
CHECKED BY: A.O.
DESIGN BY:

9/20/02-56


**VEAZEY
PARROTT
DURKIN &
SHOULDERS**

ARCHITECTS
ENGINEERS
PLANNERS

2000 Technology Park, S.W.
Atlanta, Georgia 30336
Telephone: 404.525.1000

D & A
INC./A

Technology Design Consultants
16618 East 196 th Street
Noblesville IN 46060-9530
765/534-5152
D & A INCORPORATED

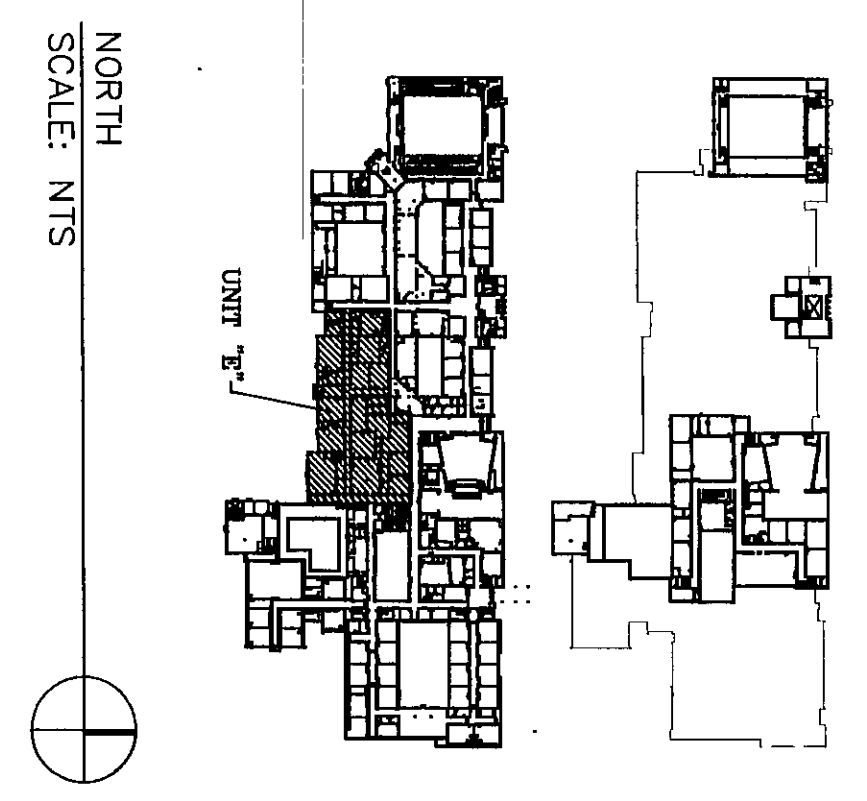

KEY PLAN:

- OTHER SYMBOLS:
- NEW VIDEO MONITOR
 - NEW RACKWAY
 - NEW CEILING SPEAKER
 - NEW WALL SPEAKER
 - CABLE TRAY PROVIDED BY DIVISION 16
 - SEE 'E' SERIES FOR MORE DETAIL

- PORT BOX TYPES:
- S - SINGLE GANG MOUNTED 16" AFF
 - W - SINGLE GANG MOUNTED 48" AFF
 - R - RACKWAY PLATE
 - Q - QUAD BOX MOUNTED 15" AFF
 - C - COILED CABLE IN CEILING FOR FUTURE USE

SYMBOL LEGEND

PORT DESIGNATIONS:	TYPE OF PORT BOX	NUMBER OF PHONE PORTS	NUMBER OF DATA PORTS
KS12			

- REFERENCE NOTES:
1. (1) 27" MULTI-MEDIA MONITOR & (1) 5-WAY VCR IN CEILING MOUNT BRACKET. RACKWAY PROVIDED BY DIVISION 16 CONTRACTOR. TYPICAL AS INDICATED.
 2. 30" VCR MOUNTED AT 36" TO BOTTOM OF BRACKET.
 3. 30" VCR MOUNTED AT 36" TO BOTTOM OF BRACKET.
 4. 30" VCR MOUNTED AT 36" TO BOTTOM OF BRACKET.
 5. 30" VCR MOUNTED AT 36" TO BOTTOM OF BRACKET.
 6. 30" VCR MOUNTED AT 36" TO BOTTOM OF BRACKET.
 7. 30" VCR MOUNTED AT 36" TO BOTTOM OF BRACKET.
 8. 30" VCR MOUNTED AT 36" TO BOTTOM OF BRACKET.
 9. 30" VCR MOUNTED AT 36" TO BOTTOM OF BRACKET.
 10. 30" VCR MOUNTED AT 36" TO BOTTOM OF BRACKET.
 11. 30" VCR MOUNTED AT 36" TO BOTTOM OF BRACKET.
 12. 30" VCR MOUNTED AT 36" TO BOTTOM OF BRACKET.
 13. 30" VCR MOUNTED AT 36" TO BOTTOM OF BRACKET.
 14. 30" VCR MOUNTED AT 36" TO BOTTOM OF BRACKET.
 15. 30" VCR MOUNTED AT 36" TO BOTTOM OF BRACKET.
 16. 30" VCR MOUNTED AT 36" TO BOTTOM OF BRACKET.
 17. 30" VCR MOUNTED AT 36" TO BOTTOM OF BRACKET.
 18. 30" VCR MOUNTED AT 36" TO BOTTOM OF BRACKET.
 19. 30" VCR MOUNTED AT 36" TO BOTTOM OF BRACKET.
 20. 30" VCR MOUNTED AT 36" TO BOTTOM OF BRACKET.
 21. 30" VCR MOUNTED AT 36" TO BOTTOM OF BRACKET.