

1. TRUCK FOR ALL CLOSURES
2. REVERS (PATE/PARTS) IN BACKWAY PROVIDED BY
3. NO VOR. MOUNTED AT 8" TO BOTTOM OF BRACKET.
4. SEE TS-5(10) FOR ADDITIONAL INFORMATION.
5. NOT USED
6. CABLE TRAY SHOWN FOR REFERENCE ONLY.
7. CABLE TRAY SHOWN FOR REFERENCE ONLY.
8. CABLE TRAY SHOWN FOR REFERENCE ONLY.
9. CABLE TRAY SHOWN FOR REFERENCE ONLY.
10. CABLE TRAY SHOWN FOR REFERENCE ONLY.
11. CABLE TRAY SHOWN FOR REFERENCE ONLY.
12. CABLE TRAY SHOWN FOR REFERENCE ONLY.
13. CABLE TRAY SHOWN FOR REFERENCE ONLY.
14. CABLE TRAY SHOWN FOR REFERENCE ONLY.
15. CABLE TRAY SHOWN FOR REFERENCE ONLY.
16. CABLE TRAY SHOWN FOR REFERENCE ONLY.
17. CABLE TRAY SHOWN FOR REFERENCE ONLY.
18. CABLE TRAY SHOWN FOR REFERENCE ONLY.
19. CABLE TRAY SHOWN FOR REFERENCE ONLY.
20. CABLE TRAY SHOWN FOR REFERENCE ONLY.
21. CABLE TRAY SHOWN FOR REFERENCE ONLY.


SYMBOL LEGEND

PORT DESIGNATIONS:
TYPE OF PORT BOX
NUMBER OF PHONE PORTS
NUMBER OF DATA PORTS

PORT BOX TYPES:
S = SINGLE CORD MOUNTED 18" AFF
R = RACK MOUNTED 18" AFF
F = FLOORBOX MOUNTED 18" AFF
C = CABLE TRAY MOUNTED 18" AFF
SEE "T" SERIES FOR MORE DETAIL

OTHER SYMBOLS:
[] = NEW WOOD MONITOR
[] = NEW PRACTICE
[] = NEW WALL SPEAKER
[] = NEW WALL SPEAKER
[] = CABLE TRAY PROVIDED BY DIVISION 16
SEE "T" SERIES FOR MORE DETAIL

KEY PLAN:

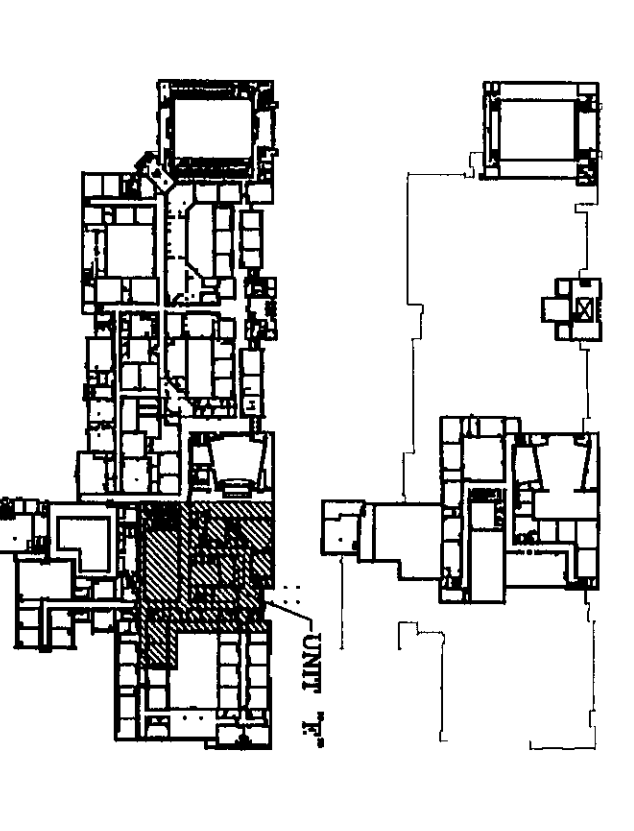


NORTH
SCALE: NTS

D & A
Technology Design Consultants
16618 East 196 th Street
Noblesville IN 46060-9530
765/534-5152
D & A INCORPORATED

**VEAZEY
PARROTT
DURKIN &
SHOULDERS**
ARCHITECTS
ENGINEERS
PLANNERS
3000 Prosperity Ave. S.W.
Indianapolis, IN 46202

TRI ELECTRONICS
6231 Calumet Avenue
P.O. Box 4310
Hammond, IN 46324
(219) 931-6850 (312) 862-4998
1 (800) 722-6793
Fax: (219) 933-3545

CHESTERTON MIDDLE SCHOOL
TECHNOLOGY FLOOR PLAN UNIT "F"
SCALE: NONE
DATE: 8/27/02
DRAWN BY: A.O.
CHECKED BY: A.O.
DESIGN BY: TS 1.6

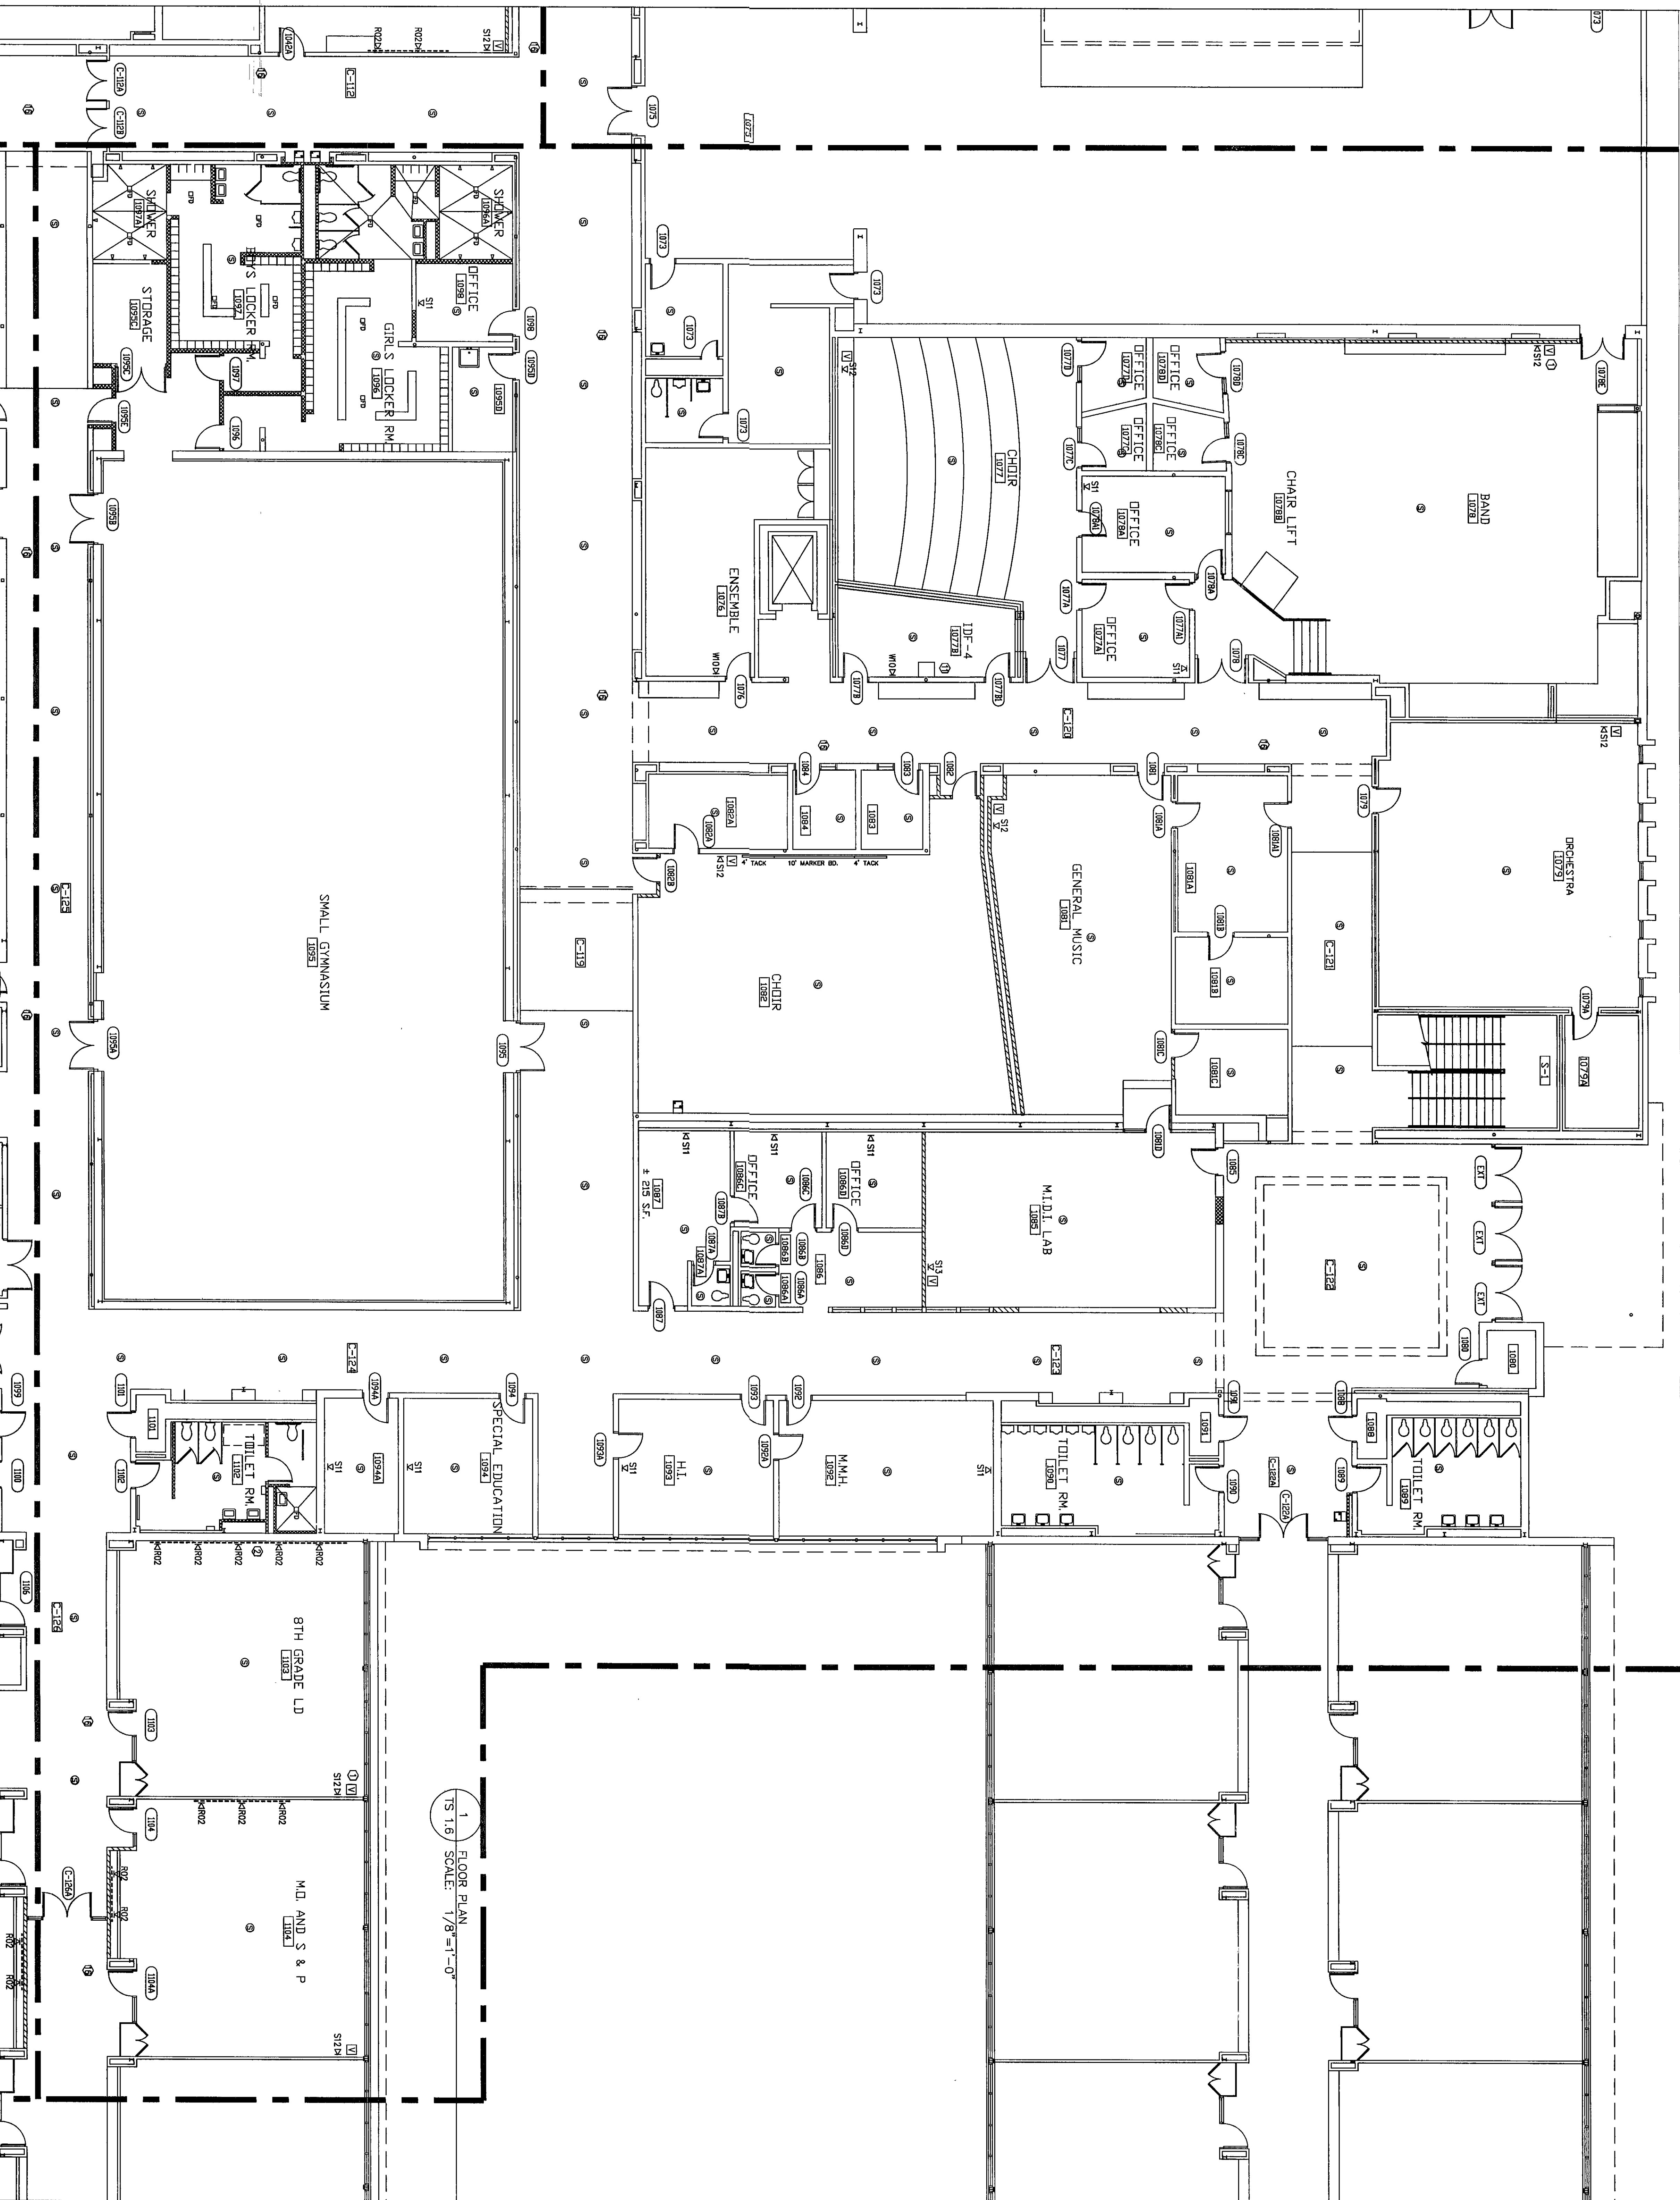

1. FLOOR PLAN
TS 1.6 SCALE: 1/8"=1'-0"