

REFERENCED NOTES

1. TYPICAL FOR ALL CLASSROOMS
2. TYPICAL FOR ALL CLASSROOMS
3. TYPICAL FOR ALL CLASSROOMS
4. TYPICAL FOR ALL CLASSROOMS
5. TYPICAL FOR ALL CLASSROOMS
6. TYPICAL FOR ALL CLASSROOMS
7. TYPICAL FOR ALL CLASSROOMS
8. TYPICAL FOR ALL CLASSROOMS
9. TYPICAL FOR ALL CLASSROOMS
10. TYPICAL FOR ALL CLASSROOMS
11. TYPICAL FOR ALL CLASSROOMS
12. TYPICAL FOR ALL CLASSROOMS
13. TYPICAL FOR ALL CLASSROOMS
14. TYPICAL FOR ALL CLASSROOMS
15. TYPICAL FOR ALL CLASSROOMS
16. TYPICAL FOR ALL CLASSROOMS
17. TYPICAL FOR ALL CLASSROOMS
18. TYPICAL FOR ALL CLASSROOMS
19. TYPICAL FOR ALL CLASSROOMS
20. TYPICAL FOR ALL CLASSROOMS
21. TYPICAL FOR ALL CLASSROOMS

SYMBOL LEGEND

PORT DESIGNATIONS

TYPE OF PORT BOX

NUMBER OF DATA PORTS

KS12

PORT BOX TYPES

S = SINGLE GANG MOUNTED 16" AFF

W = SINGLE GANG MOUNTED 48" AFF

R = RACEWAY PLATE

Q = QUAD BOX MOUNTED 16" AFF

C = COULD CABLE IN CEILING FOR FUTURE USE

OTHER SYMBOLS

NEW VIDEO MONITOR

NEW RACEWAY


NEW CEILING SPEAKER

NEW WALL SPEAKER

CABLE TRAY PROVIDED BY DIVISION 16

SEE "E" SERIES FOR MORE DETAIL

KEY PLAN:

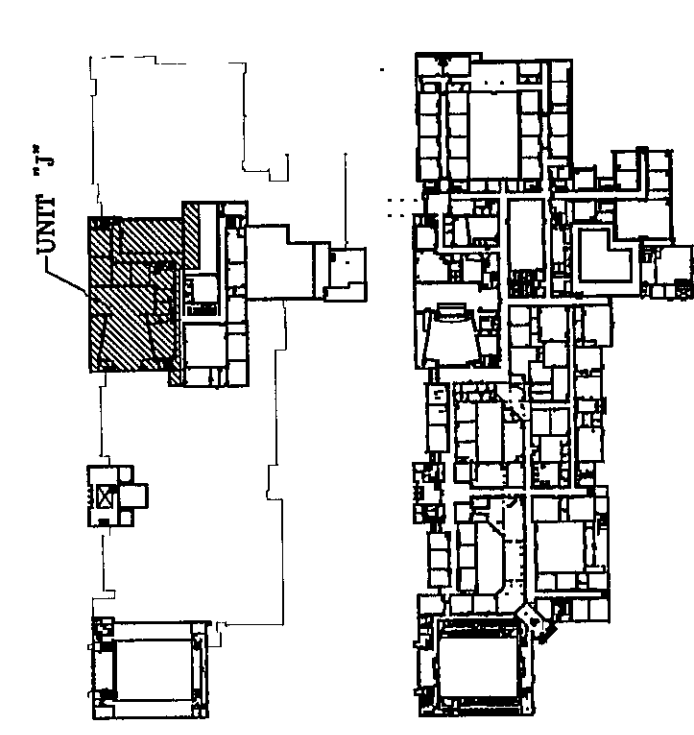

NORTH

SCALE: NTS

D S & INC

Technology Design Consultants

16618 East 196 th Street

Noblesville IN 46060-9530

765/534-5152

D S & INCORPORATED

ARCHITECTS

ENGINEERS

PLANNERS

VEAZEY

PARROTT

DURKIN

SHOULDERS

8000 Project Ave S.W.

Suite 110

Indianapolis, IN 46240

TRI ELECTRONICS

6231 Calumet Avenue

P.O. Box 4310

Hammond, IN 46324

(219) 931-6850 (312) 862-4998

1 (800) 722-6793

Fax: (219) 933-3545

CHESTERTON MIDDLE SCHOOL

CHESTERTON INDIANA

TECHNOLOGY FLOOR PLAN UNIT "J"

SCALE: NONE

DATE: 8/27/02

DRAWN BY: A.O.

CHECKED BY: A.O.

DESIGN NO: TS 2.2

1 FLOOR PLAN

SCALE: 1/8" = 1'-0"

UNIT J

