


DEMOLITION GENERAL NOTES

ITEMS TO BE REMOVED INDICATED BY DASHED LINES.
CONTRACTOR TO PROVIDE TEMPORARY LIGHTING AS NEEDED.
STRUCTURE EXISTING DOORS, FRAMES, AND HARDWARE. TEMPORARY STORAGE IS PROVIDED FOR THE EXISTING DOORS AND HARDWARE FOR FUTURE REINSTALLATION.
DISCONNECT AND TEMPORARILY STORE EXISTING ELECTRICAL EQUIPMENT IN WALLS AND CEILING SPACES REMOVED. THIS INCLUDES, BUT NOT LIMITED TO, REFRIGERATORS, FREEZERS, AIR CONDITIONERS, AND OTHER APPLIANCES. EXISTING ELECTRICAL CONDUIT, EXTEND ALL CONDUIT AND WIRE AS NEEDED. REPLACE ALL EXISTING DEVICES THAT ARE DAMAGED DURING DEMOLITION. DEVICES TO BE REMOVED TO MATCH EXISTING STANDARD ON SITE.

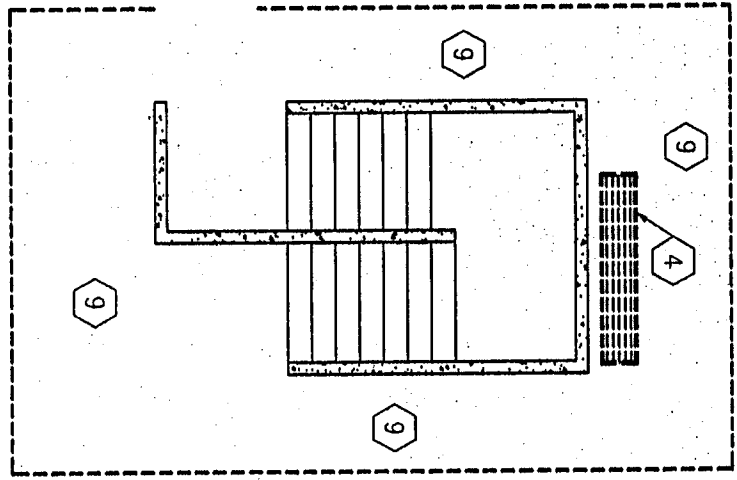


DEMOLITION PLAN KEY NOTES

- 1 REMOVE AND PROTECT FLOORING, EXTERIOR, INTERIOR, DISPERGERS AND TOILET PARTITIONS.
- 2 REMOVE AND PROTECT INTERIOR DOORS AND HARDWARE.
- 3 REMOVE AND PROTECT ALL CASEWORK, COUNTERTOPS AND DISPLAY CASES IN THE EXISTING CONCESSION STAND.
- 4 REMOVE AND PROTECT EXTERIOR BENCH EAST OF STAIR TOWER ON THE SOUTH SIDE OF STADIUM.
- 5 REMOVE AND PROTECT EXISTING LIGHT FIXTURES AND EXHAUST FANS.
- 6 REMOVE CEILING AND ASSOCIATED STRUCTURE IN ITS ENTIRETY. CONTRACTOR TO DISPOSE OF DEBRIS OFF SITE.
- 7 REMOVE EXISTING CHAIR WALLS, DOOR FRAMES AND FLOOR SLABS. CASE MUST BE TAKEN TO PROTECT ALL FLOORING IN BOTH WALLS AND IN/UNDER FLOOR SLABS FOR FUTURE USE.
- 8 PROVIDE PROTECTION FOR EXISTING WATER MAIN AND KEYS FROM DEMOLITION WORK AND TEMPERATURE CHANGES THAT MAY CAUSE FREEZING.
- 9 REMOVE EXISTING SIDEWALK AROUND STAIR TOWER (SOUTH OF STADIUM) TO THE NEAREST CONTROL JUNT. CONTRACTOR TO DISPOSE OF DEBRIS OFF SITE.

DEMOLITION PLAN

SCALE 1/8" = 1'-0"

(ON SITE STORAGE)

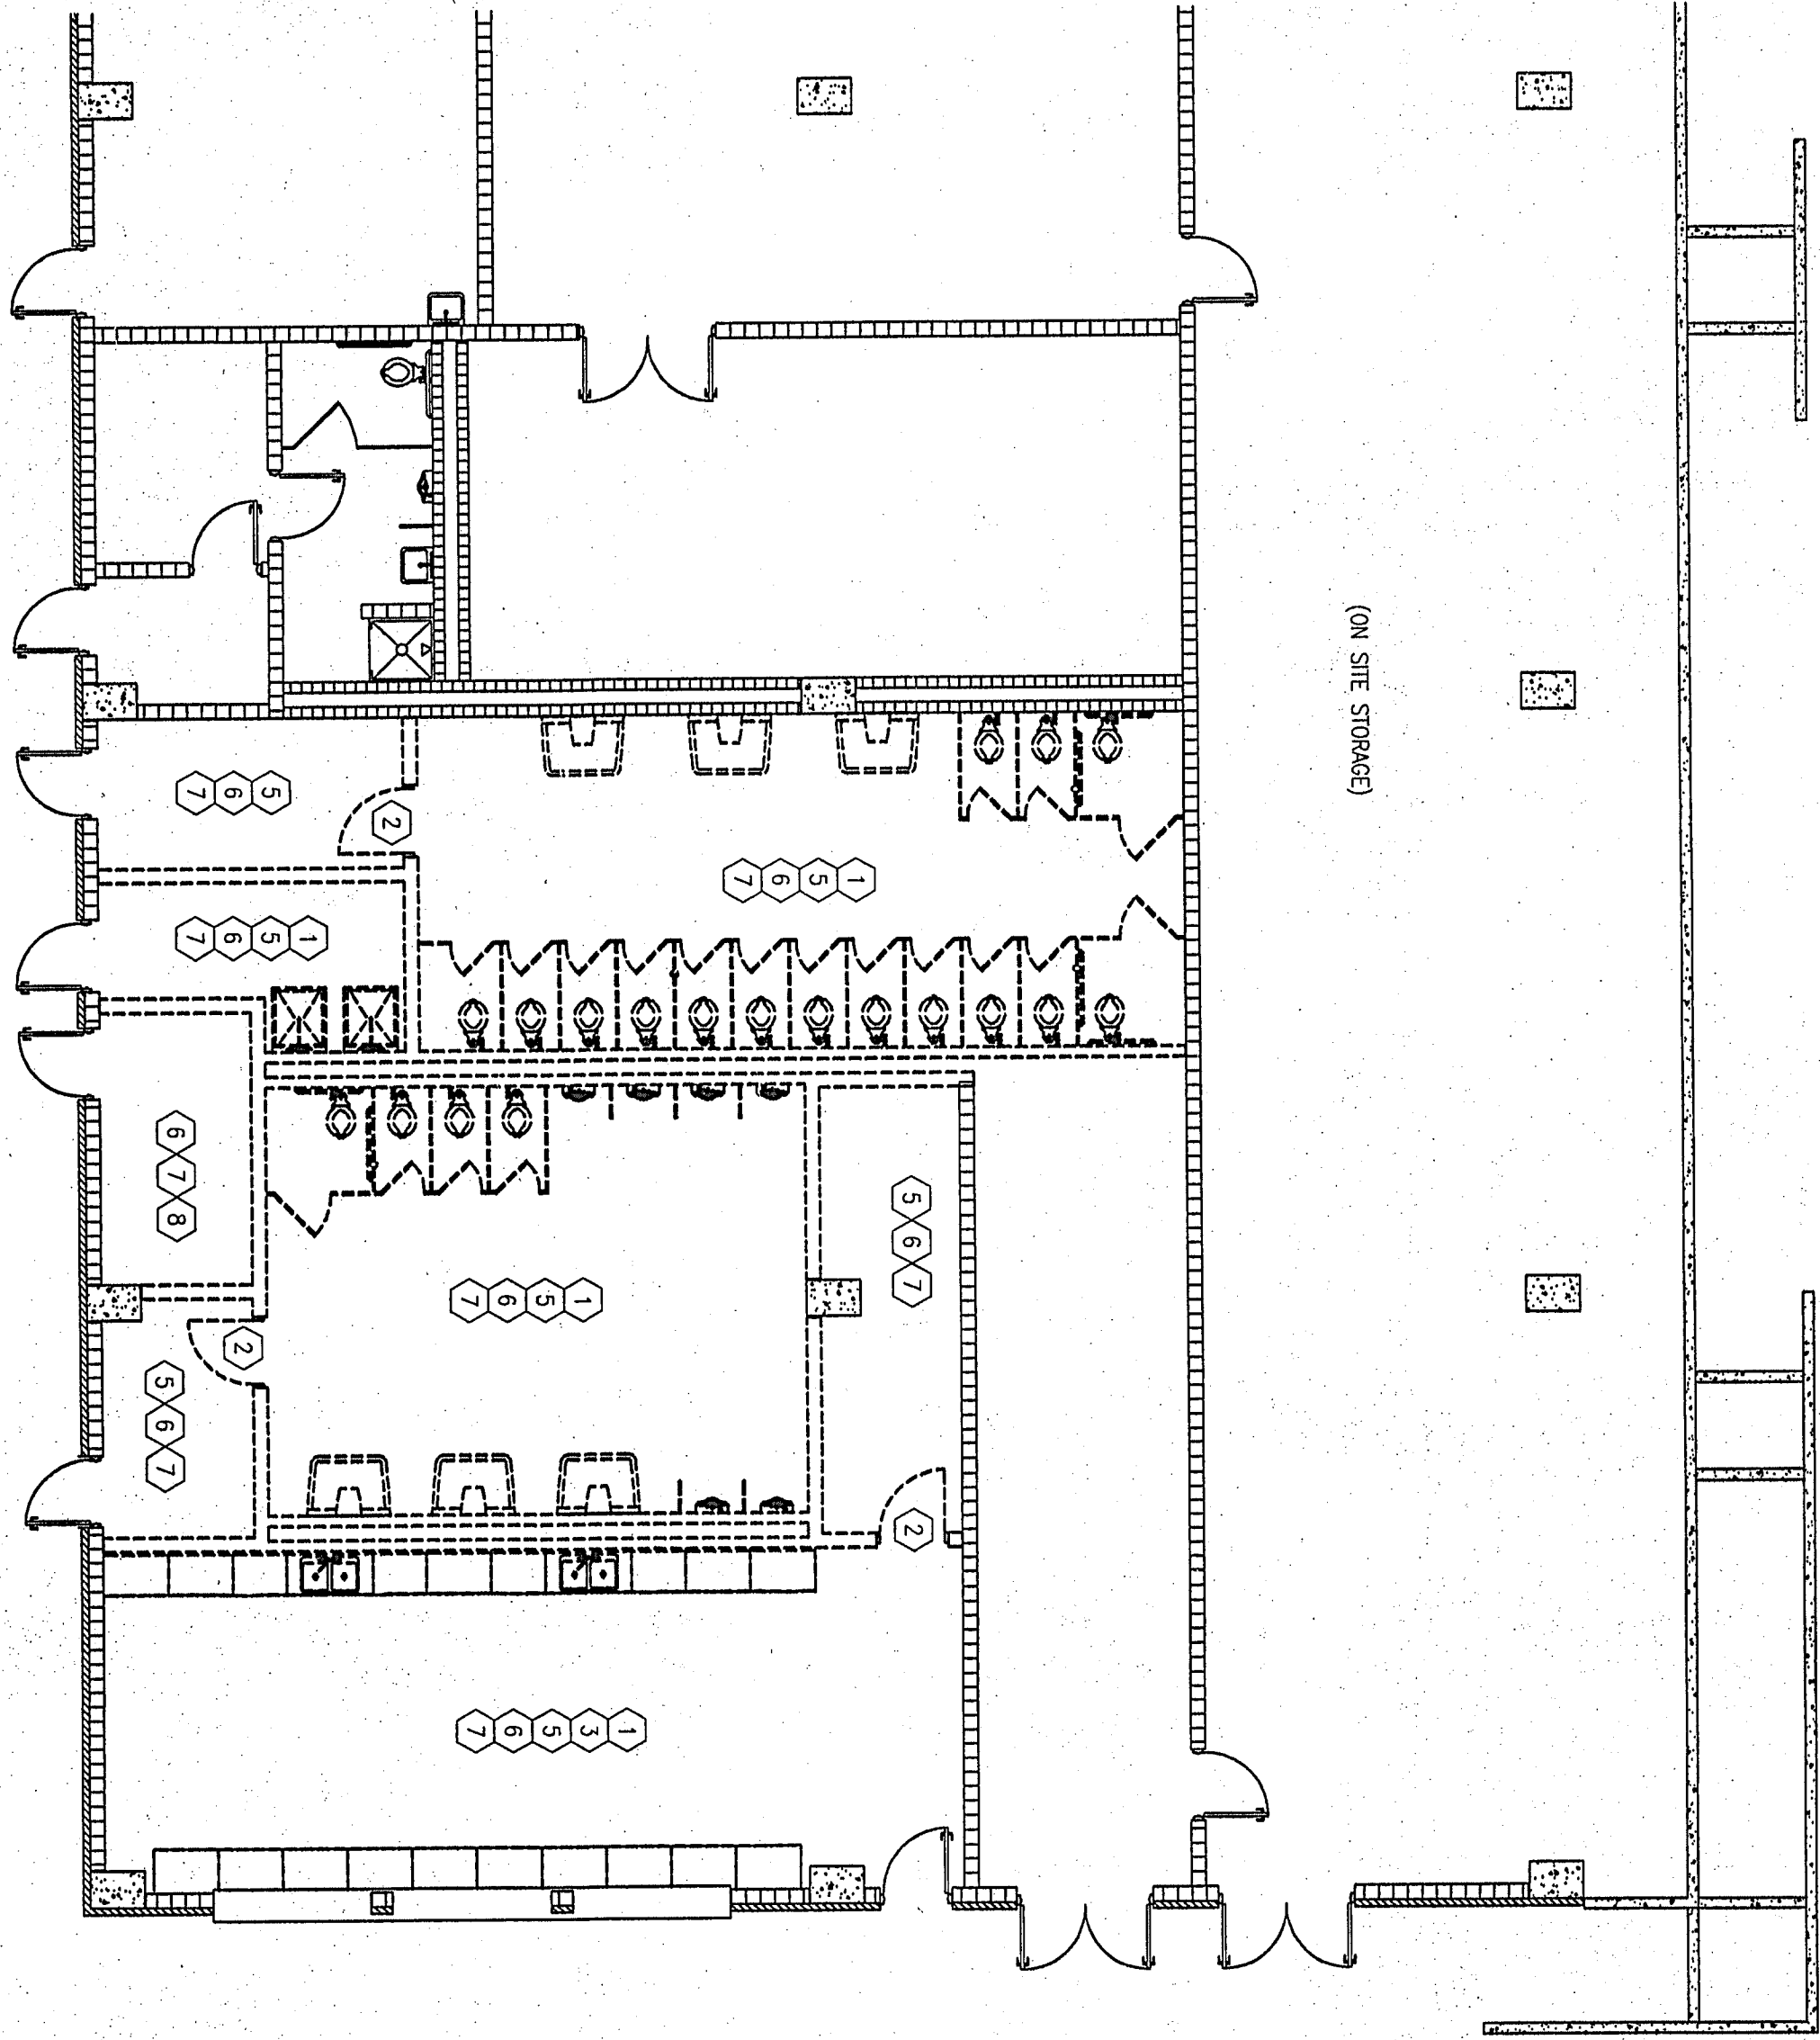


FLOOR PLAN KEY NOTES

- 1 PROVIDE 4" CONCRETE FLOOR SLAB TO SLOPE TO EXISTING FLOOR DRAIN. REFER TO SPECIFICATIONS.
- 2 PROVIDE 3/4" @ 16" O.C. METAL STUD PARTITION WALLS WITH FRP PANELS AND ABUSE RESISTANT GYPSUM BOARD ON EXPOSED SIDES. WALLS TO BE 6" ABOVE CEILING. PROVIDE ACoustical BATT INSULATION.
- 3 PROVIDE 3/4" @ 16" O.C. METAL STUD PARTITION WALLS WITH FRP PANELS AND ABUSE RESISTANT GYPSUM BOARD ON EXPOSED SIDES TO 6" ABOVE CEILING. WALLS TO CONTINUE TO STRUCTURE ABOVE. ABOVE CEILING FRP PANELS ARE NOT REQUIRED WITH GYPSUM WALL BOARD ON ONE SIDE ONLY. PROVIDE ACoustical BATT INSULATION.
- 4 PROVIDE CEILING GRID AND ACoustical CEILING TILE. CEILING FRAMES AND ACoustical CEILING TILE. REMOVE EXISTING LIGHT FIXTURES AND EXHAUST FANS.
- 5 REMOVE NEW YELLOW METAL DOOR FRAMES FOR EXISTING DOORS AND HARDWARE.
- 6 PROVIDE NEW ALUMINUM STAIR. REFER TO DETAIL 1-A.1.1 AND SPECIFICATIONS.
- 7 PROVIDE NEW CONCRETE SIDEWALK AROUND STAIR TOWER (SOUTH OF EXISTING STADIUM). REINSTALL BENCH.
- 8 REINSTALL PREVIOUSLY REMOVED EXISTING PLUMBING FIXTURES, REPAIR AND REINSTALL. PROVIDE NEW LOCATIONS OF FIXTURES AND PARTITIONS.
- 9 REINSTALL PREVIOUSLY REMOVED EXISTING CASEWORK, COUNTERTOPS AND DISPLAY CASES.
- 10 REPAIR EXISTING CHAIR WALLS @ LOCATIONS DISTURBED BY REMOVAL OF EXISTING CHAIR WALLS.
- 11 REPAIR EXISTING CHAIR WALLS @ LOCATIONS DISTURBED BY REMOVAL OF EXISTING CHAIR WALLS.


FLOOR PLAN

SCALE 1/8" = 1'-0"

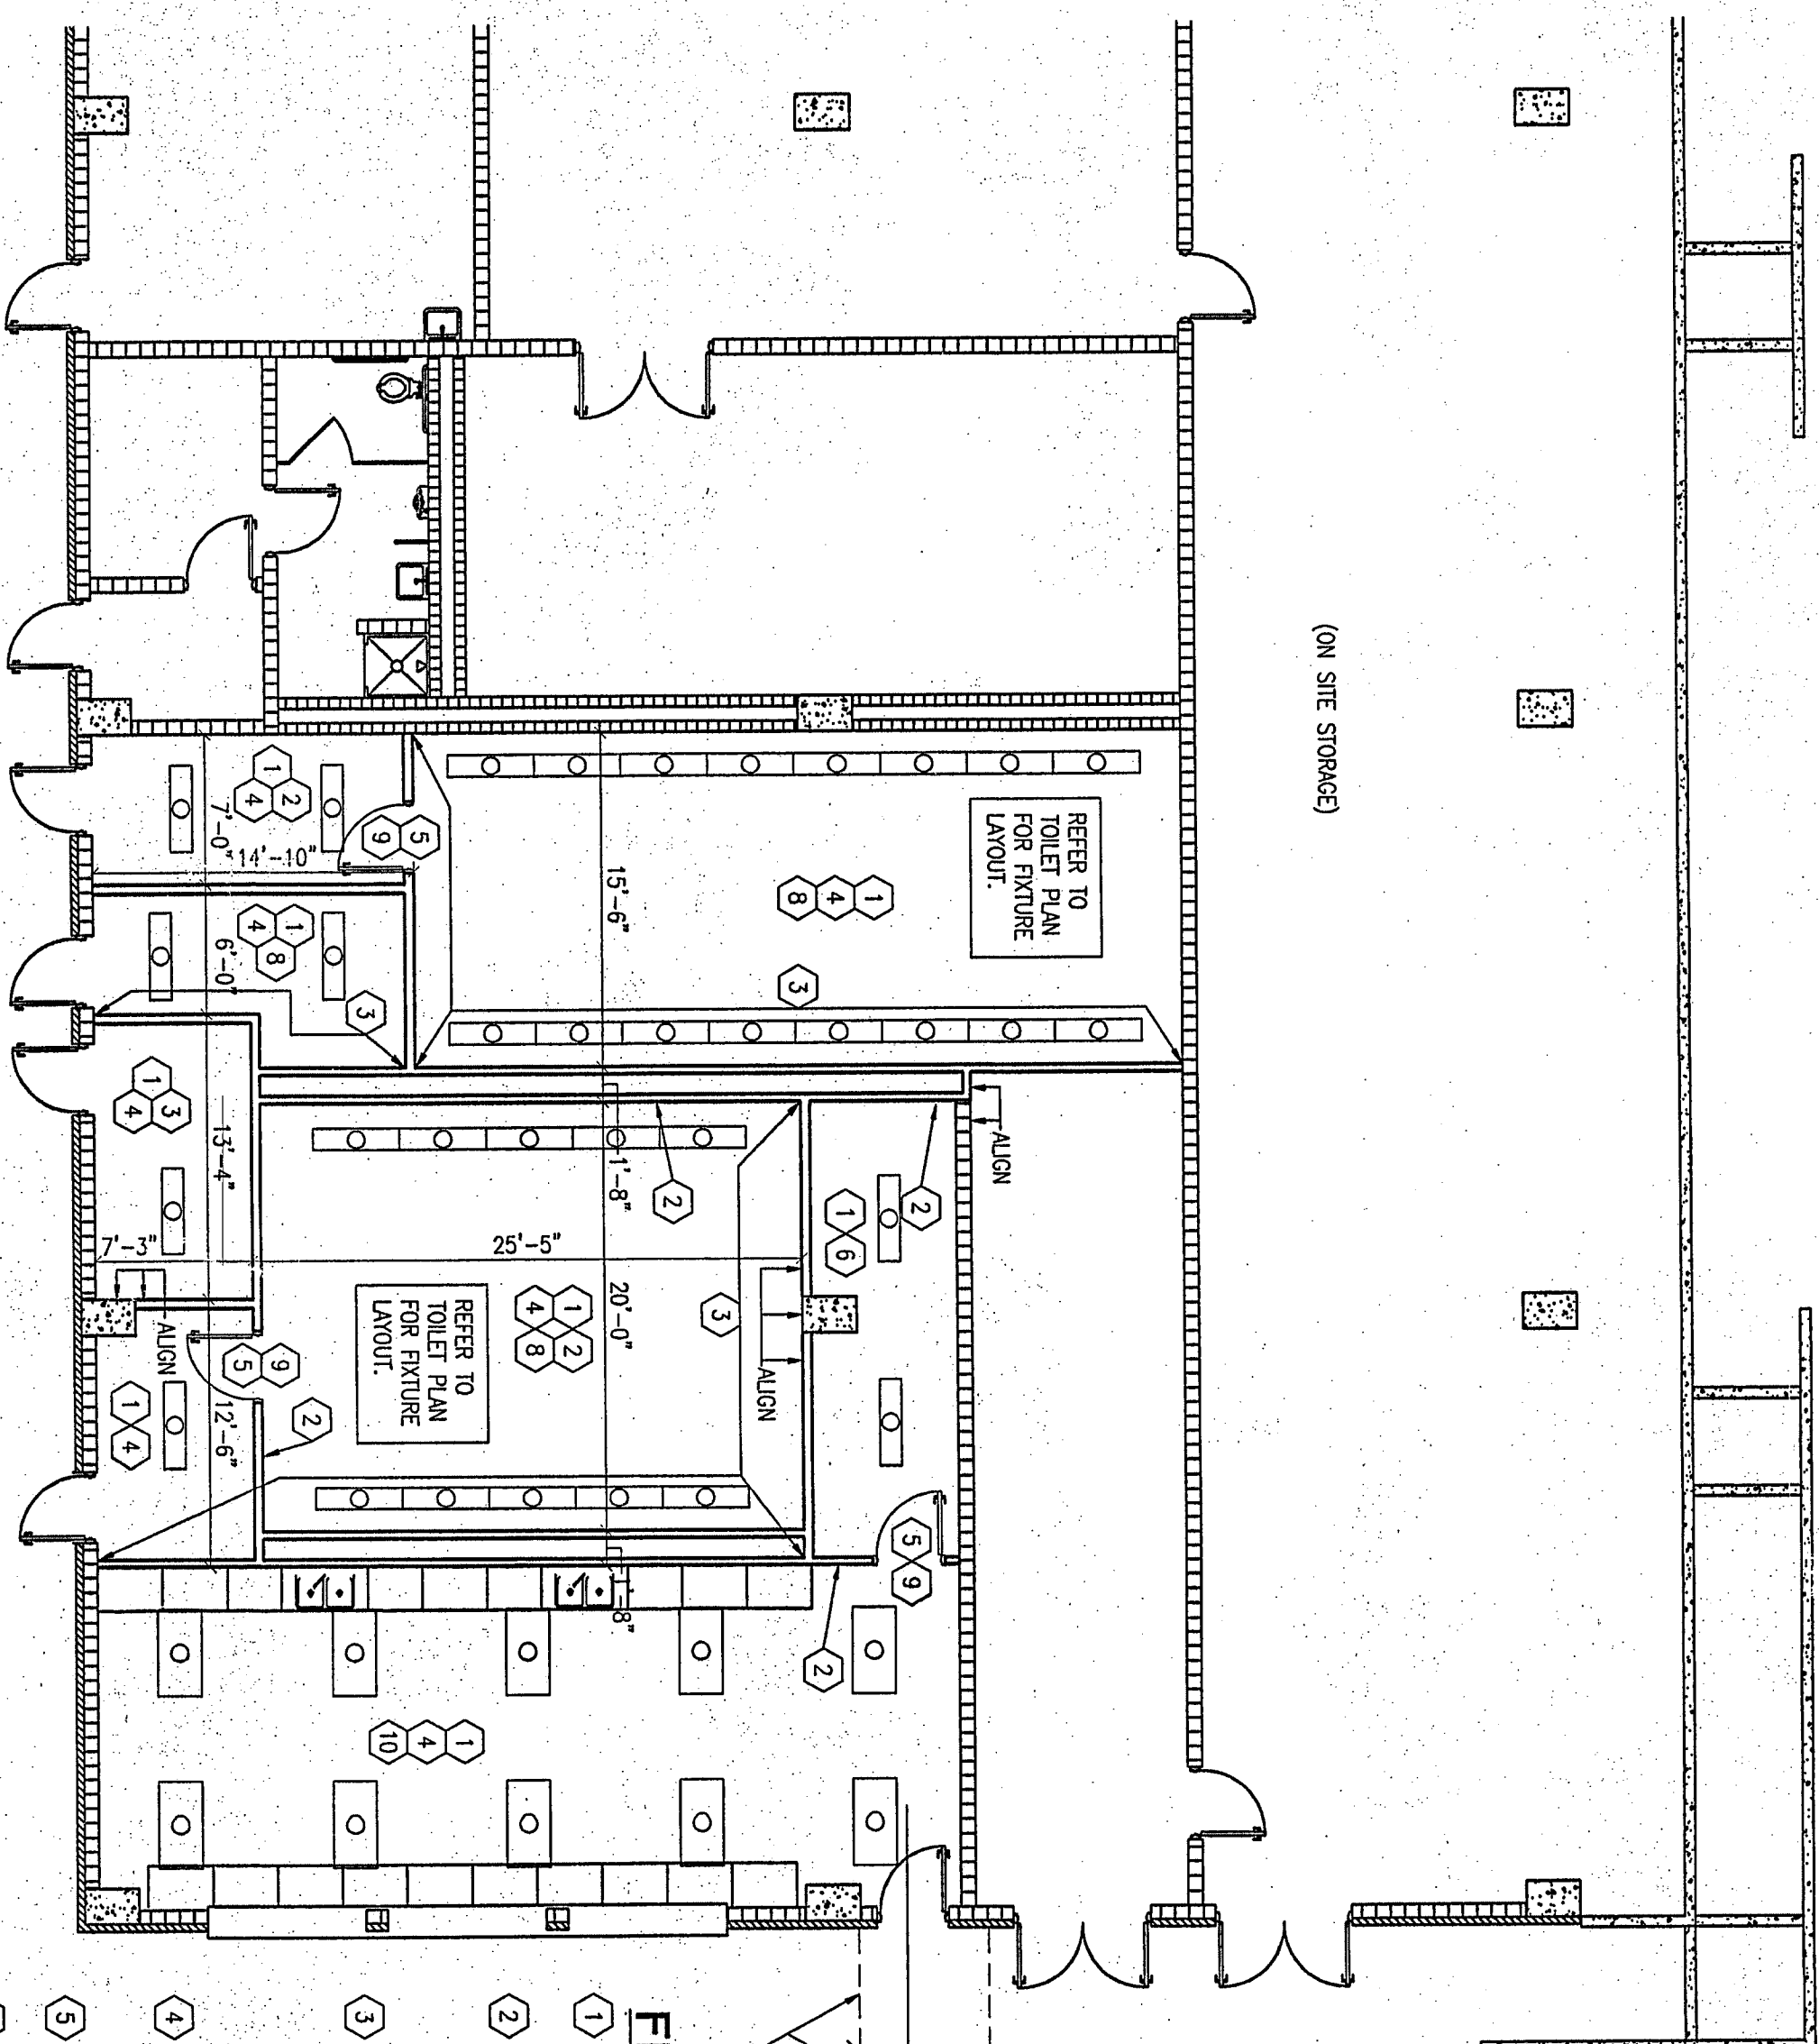


TOILET ROOM PLAN

SCALE 1/4" = 1'-0"

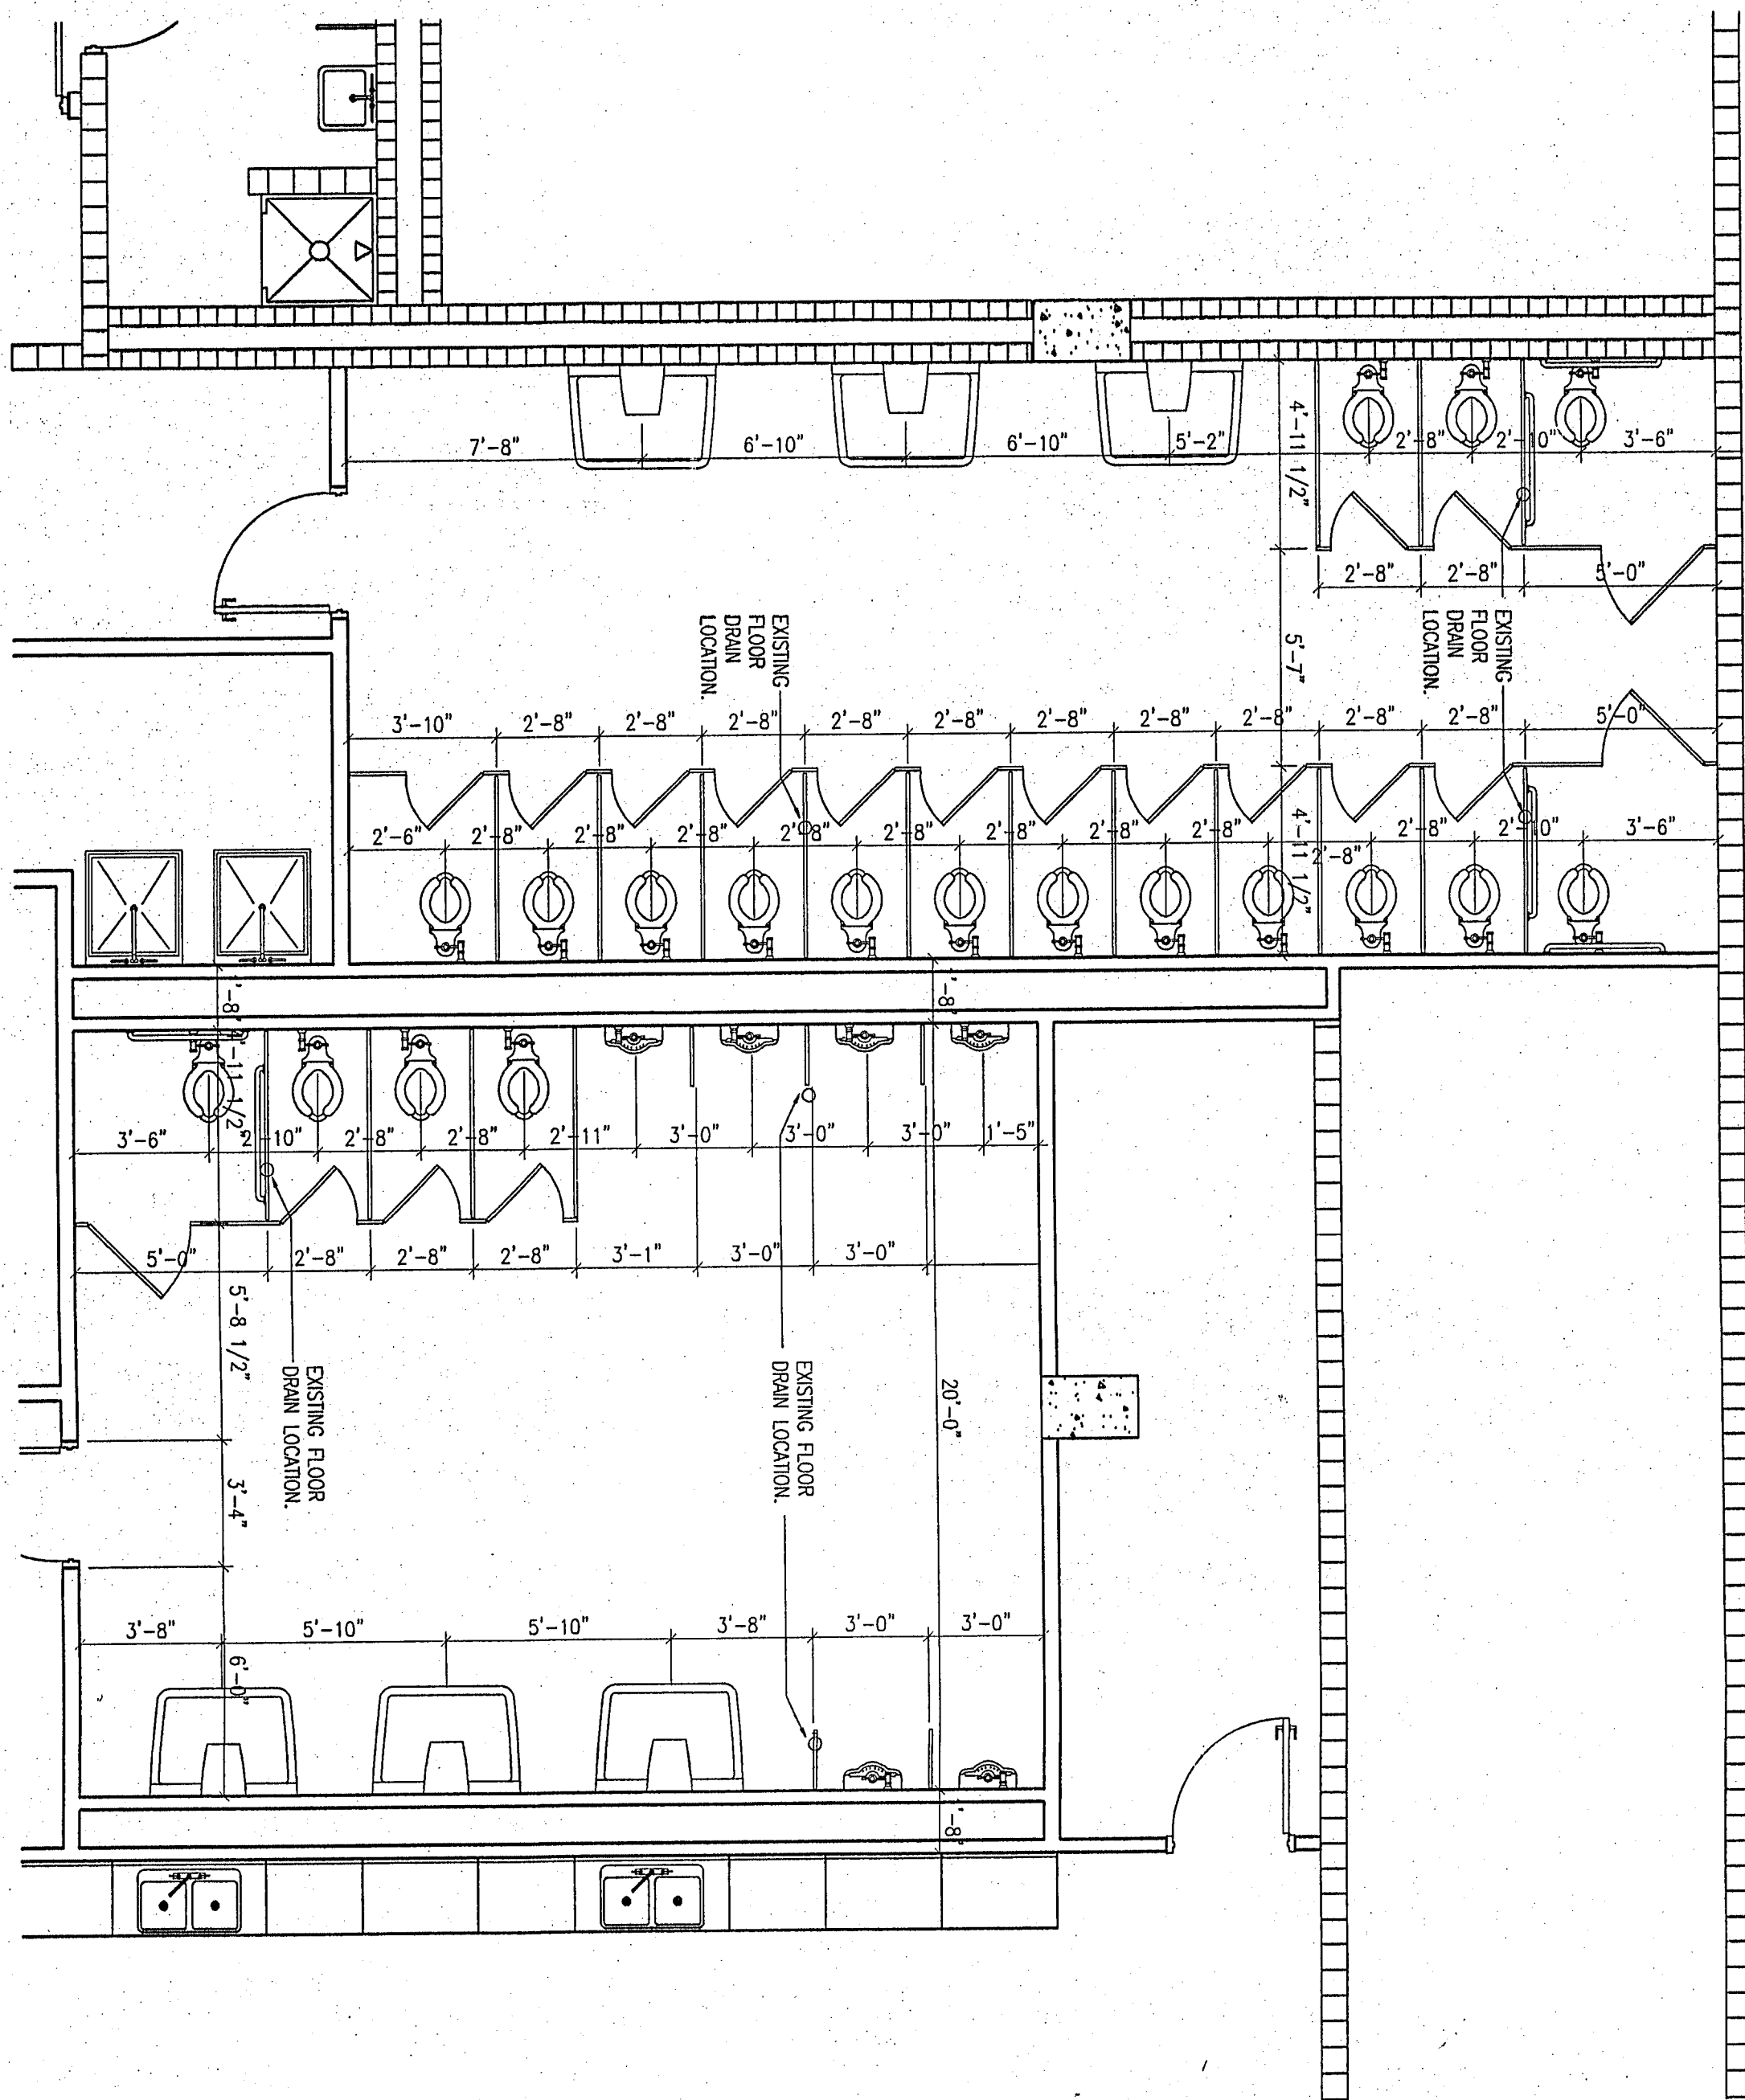


DETAIL A

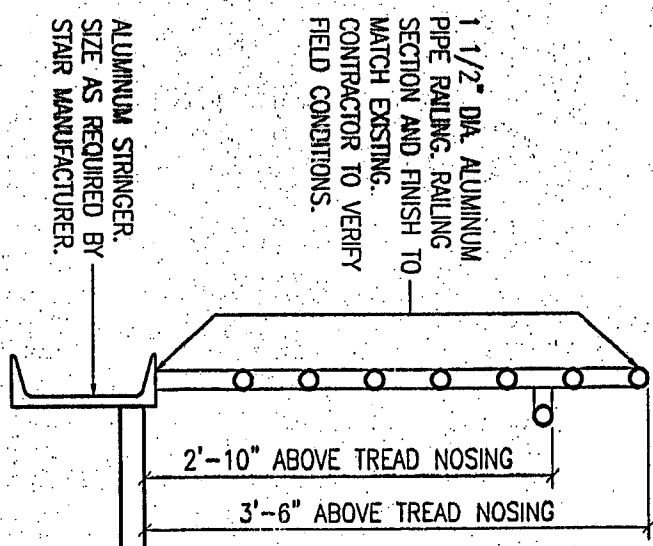

STAIR SECTION

SCALE 3/4" = 1'-0"

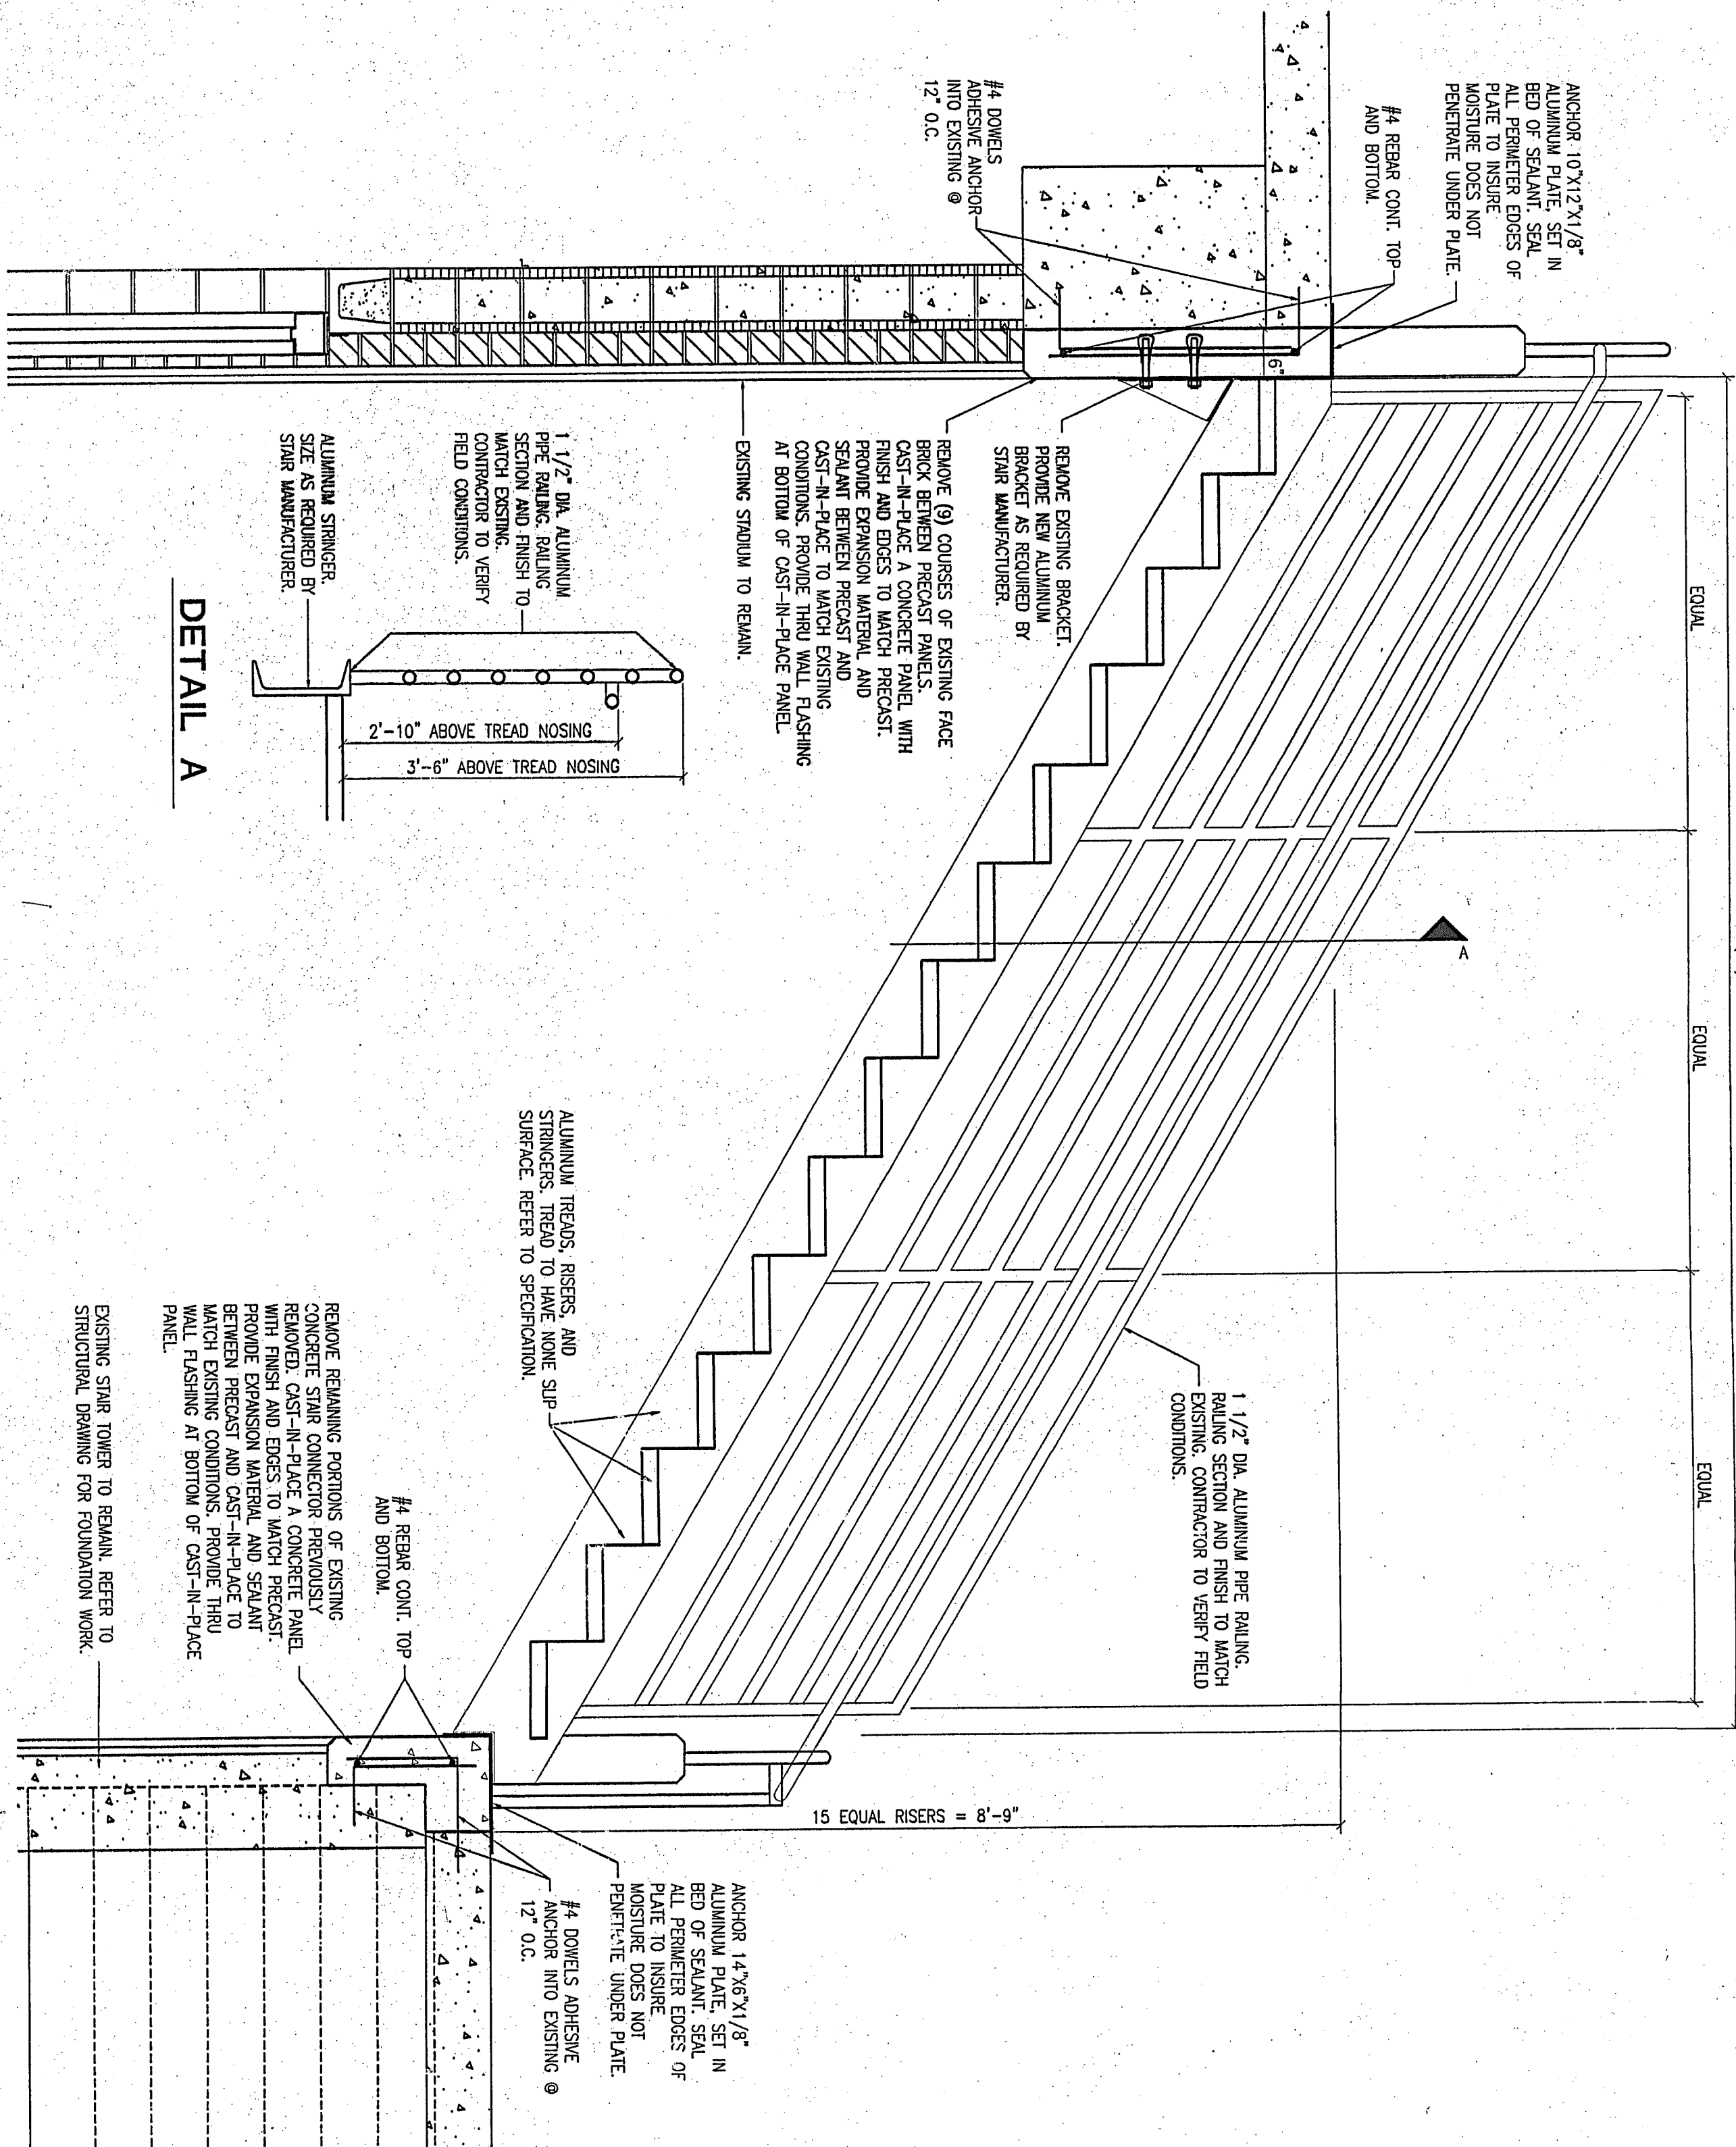


03-A-01

STADIUM RENOVATION

DRAWN BY: LEC COMM. NO.: 95067.04
CHECKED BY: DW DATE: FEBRUARY 21, 2003

A1.1

REVISIONS NO. DATE

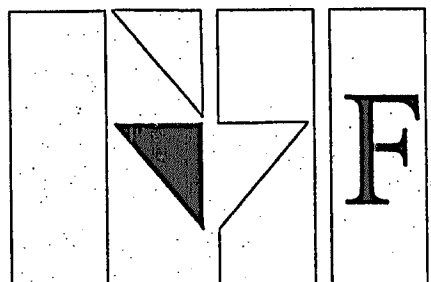

Fanning/Howey Associates, Inc.
Architects Engineers Consultants

REMODELING OF FOOTBALL STADIUM
CHESTERTON HIGH SCHOOL
FOR THE
DUNELAND SCHOOL CORPORATION
CHESTERTON, INDIANA

COPYRIGHT 2003 BY FANNING/HOWEY ASSOCIATES, INC.

