


CCTV SYSTEM FOR:  
**DUNELAND SCHOOL CORPORATION**


CHESTERTON MIDDLE SCHOOL  
CHESTERTON, INDIANA

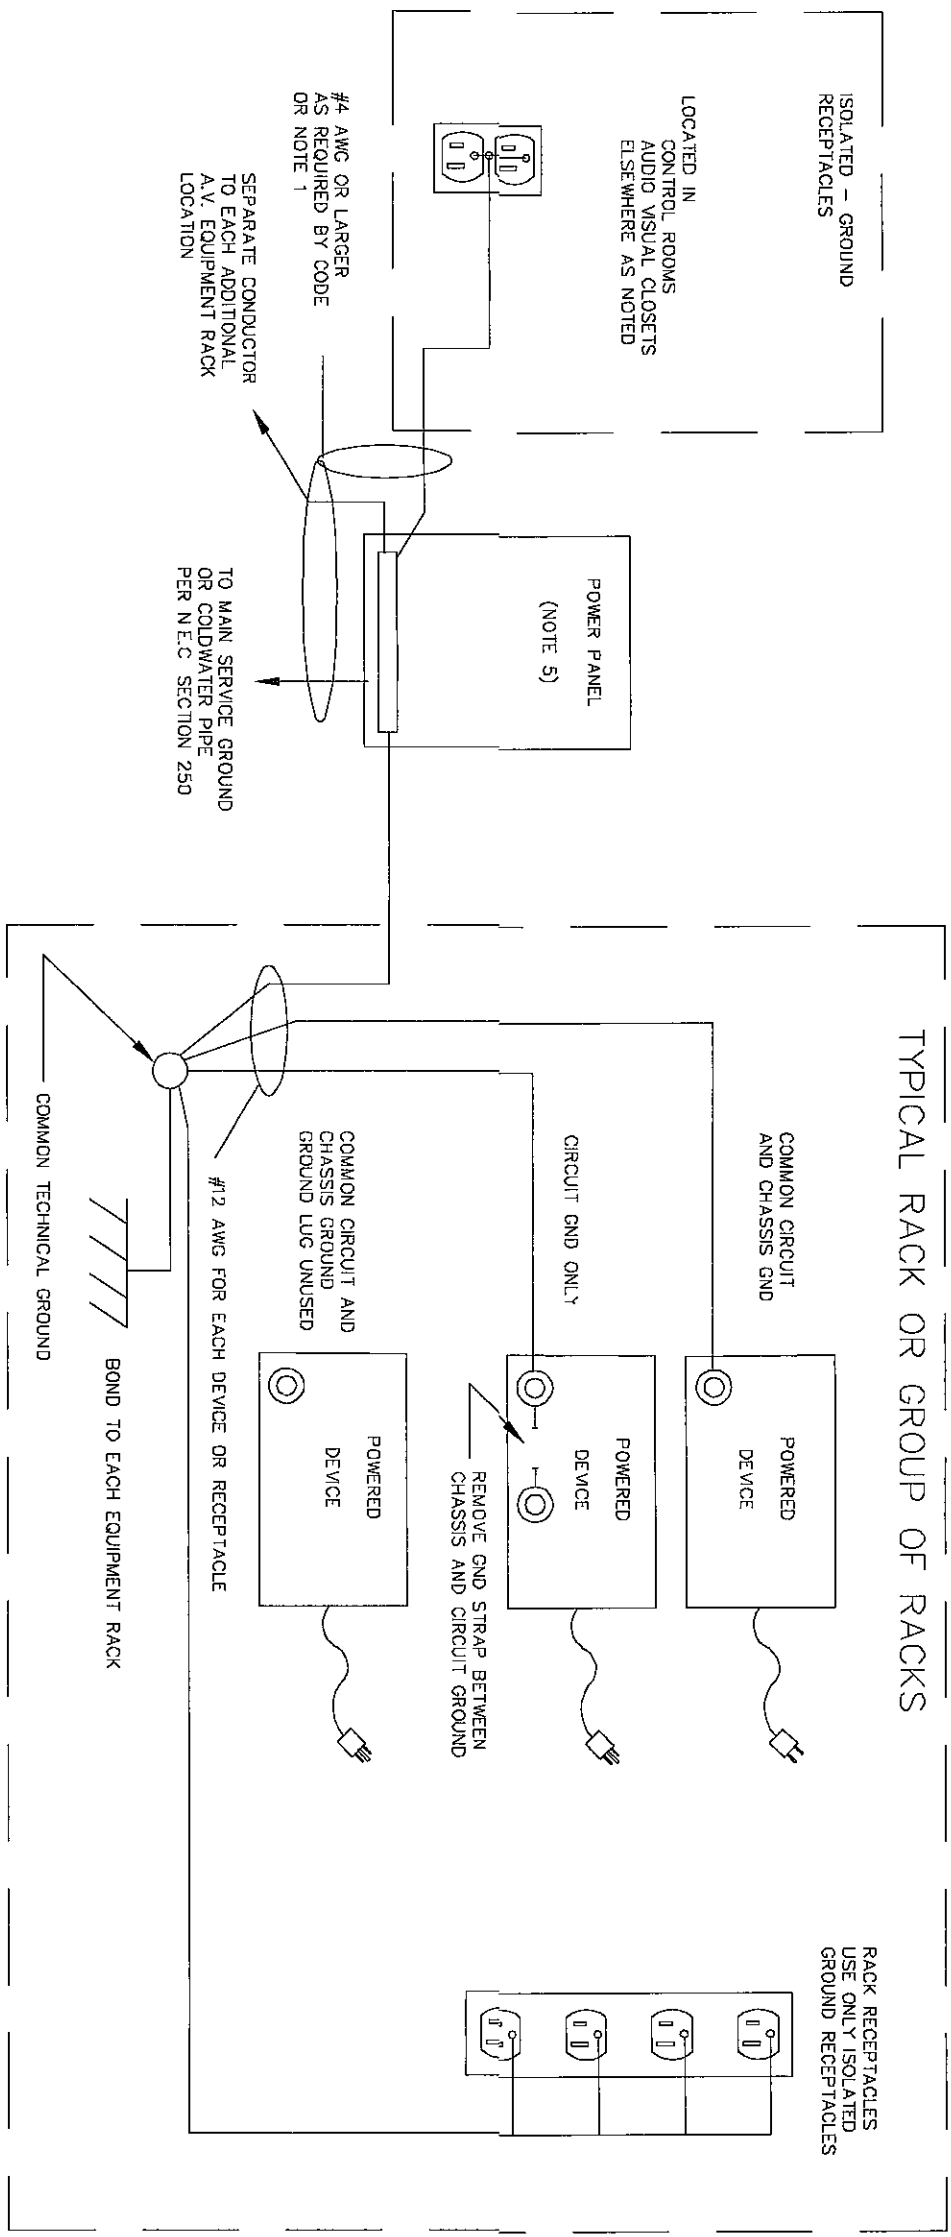

- NOTES
1. SEE TECHNICAL DRAWING TO PROVIDE MAX. 0.1 OHM RESISTANCE BETWEEN RACK COMMON GROUND POINT AND BUILDING GROUND POINT.
  2. SEE NOTE 1. ALL SIGNAL AND POWER CABLES SHALL BE GROUNDED TO THE COMMON GROUND BUS AT EACH END.
  3. POWER PANEL SHALL BE GROUNDED TO THE COMMON GROUND BUS AT EACH END.
  4. SEE TECHNICAL DRAWING FOR SIGNAL AND POWER CABLE GROUNDING REQUIREMENTS.
  5. SEE TECHNICAL DRAWING FOR SIGNAL AND POWER CABLE GROUNDING REQUIREMENTS.

1  
TO 0  
SCALE: NTS

GENERAL

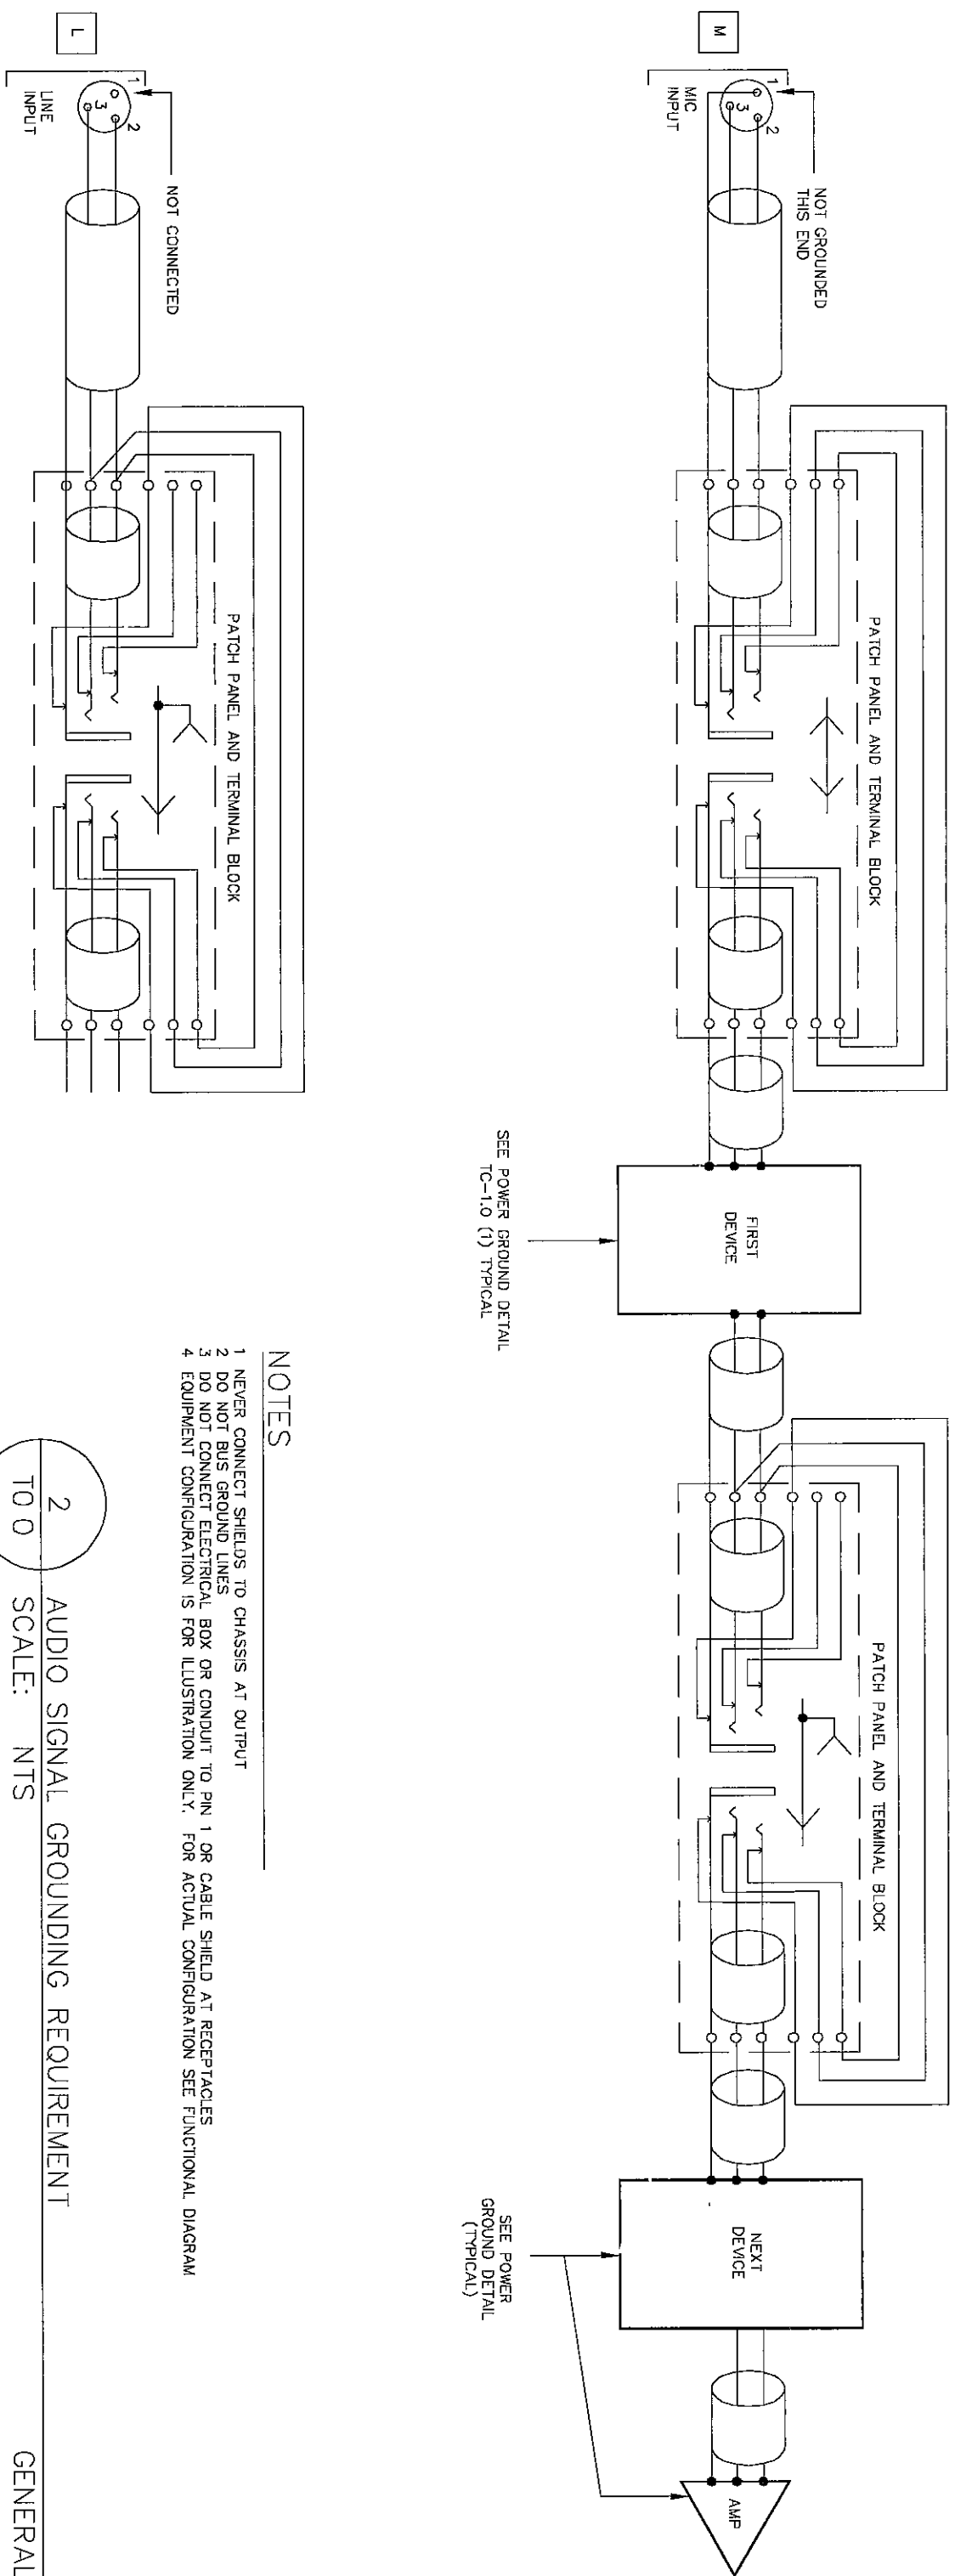

- NOTES
1. SEE NOTE 1. ALL SIGNAL AND POWER CABLES SHALL BE GROUNDED TO THE COMMON GROUND BUS AT EACH END.
  2. SEE NOTE 1. ALL SIGNAL AND POWER CABLES SHALL BE GROUNDED TO THE COMMON GROUND BUS AT EACH END.
  3. SEE NOTE 1. ALL SIGNAL AND POWER CABLES SHALL BE GROUNDED TO THE COMMON GROUND BUS AT EACH END.
  4. SEE NOTE 1. ALL SIGNAL AND POWER CABLES SHALL BE GROUNDED TO THE COMMON GROUND BUS AT EACH END.
  5. SEE NOTE 1. ALL SIGNAL AND POWER CABLES SHALL BE GROUNDED TO THE COMMON GROUND BUS AT EACH END.

2  
TO 0  
SCALE: NTS

GENERAL

DRAWING INDEX:

TECHNOLOGY SYSTEMS:

TO 0	TITLE, GROUNDING STANDARDS, AND LEGEND
T1.1	FIRST FLOOR CCTV OVERALL PLAN
T1.2	SECOND FLOOR CCTV OVERALL PLAN
T2.1	CCTV FIRST FLOOR PLAN (UNIT "A")
T2.2	CCTV FIRST FLOOR PLAN (UNIT "B")
T2.3	CCTV FIRST FLOOR PLAN (UNIT "C")
T2.4	CCTV FIRST FLOOR PLAN (UNIT "D")
T2.5	CCTV FIRST FLOOR PLAN (UNIT "E")
T2.6	CCTV FIRST FLOOR PLAN (UNIT "F")
T2.7	CCTV FIRST FLOOR PLAN (UNIT "G")
T2.8	CCTV FIRST FLOOR PLAN (UNIT "H")
T3.1	CCTV SECOND FLOOR PLAN (UNIT "J")
T3.2	CCTV SECOND FLOOR PLAN (UNIT "K")
T4.1	CCTV IDF FLOOR PLANS
T5.1	CCTV DETAILS
T5.2	CCTV SYSTEM DIAGRAM

SYMBOL LEGEND

- CCTV SECURITY CAMERA - EXTERNAL WEATHERPROOF HOUSING.
- CCTV SECURITY CAMERA - INTERNAL DOME TYPE
- CCTV SECURITY CAMERA - PTZ WEATHERPROOF EXTERNAL HOUSING
- 22" X 26.5" AV EQUIPMENT RACK WITH 4" PVC CONDUIT FROM TOP THRU CEILING WITH BUSHING.

3  
TO 0  
SCALE: NTS

GENERAL