



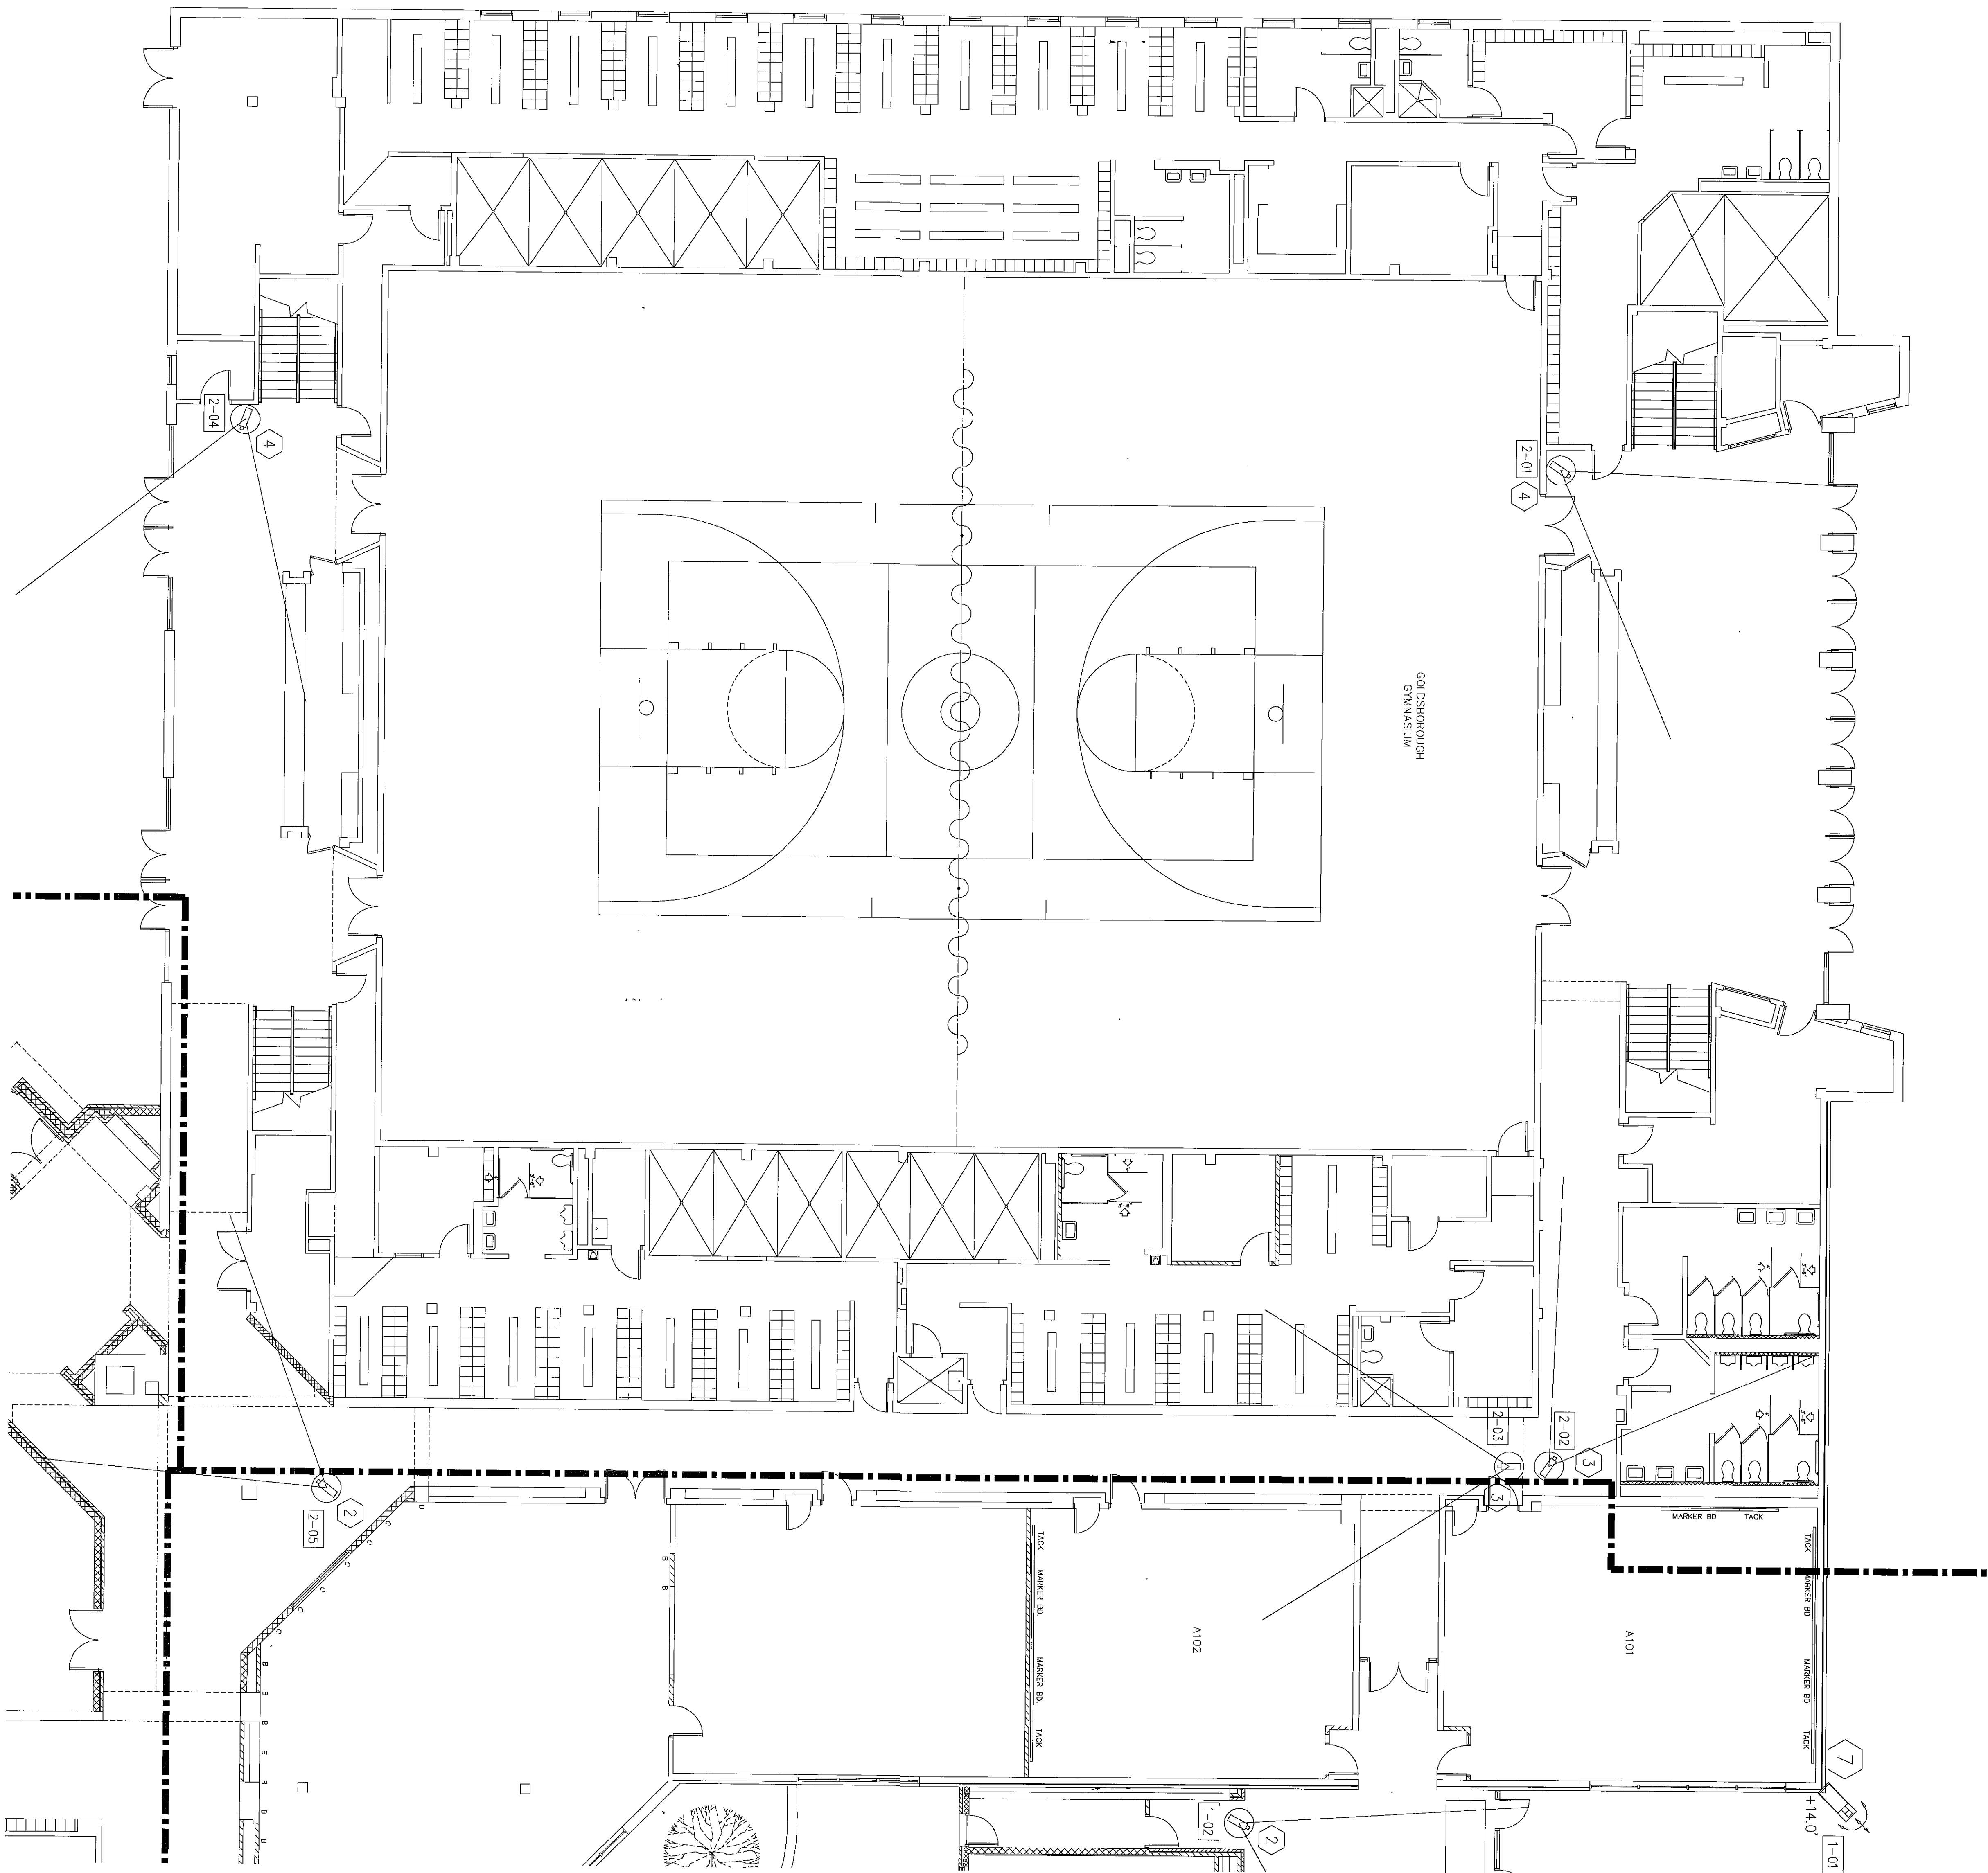

1 FLOOR PLAN
T2.1
SCALE: 1/32"=1'-0"
FIRST FLOOR - UNIT A

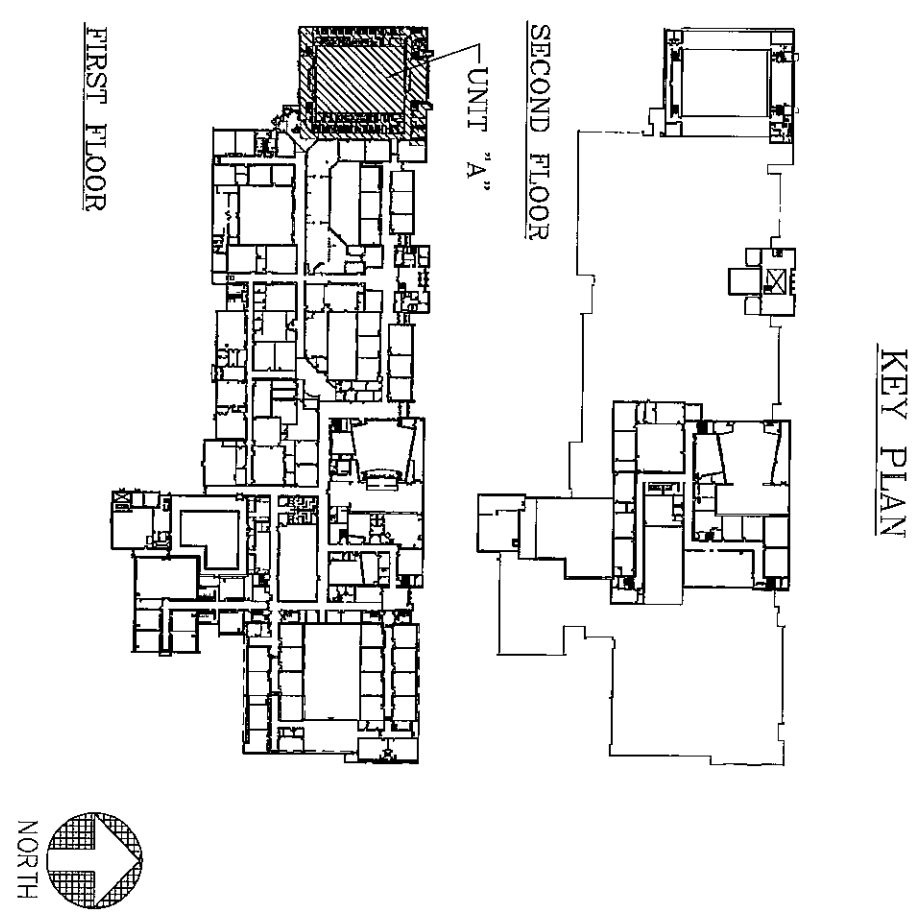

KEY PLAN

- SYMBOLS/LEGEND**
- GENERAL NOTES**
1. ROUTE COAX CABLES (PENUM 6 TYPE) TO EQUIPMENT ROOM (ER), TERMINATE BOTH ENDS AND TEST.
 2. ROUTE POWER CABLE (PENUM 6 TYPE) TO EQUIPMENT ROOM (ER), TERMINATE BOTH ENDS AND TEST.
 3. ROUTE DATA CABLE (RS-485) FOR OUTDOOR PA/ZOOM CAMERAS PER MFG. REQUIREMENTS TO EQUIPMENT ROOM (ER) AS SHOWN IN DRAWING 4.1 (1).
 4. ROUTE COAX AND POWER CABLES IN EXISTING TELECOMMUNICATION TRAYS WHERE POSSIBLE.
 5. REFERENCED NOTES BELOW ARE NOT NECESSARILY USED ON EVERY DRAWING.
- REFERENCED NOTES**
1. EXISTING TRAY SYSTEM
 2. INDOOR CAMERA, WV-CW1744F MOUNTED IN DROP CEILING, SEE DRAWING 5.1 (4).
 3. INDOOR CAMERA, WV-2245F, MOUNTED IN DROP CEILING, SEE DRAWING 5.1 (4).
 4. INDOOR CAMERA, WV-CW1744S MOUNTED ON WALL, SEE DRAWING 5.1 (3).
 5. INDOOR CAMERA, WV-CW1744S MOUNTED ON WALL, SEE DRAWING 5.1 (3).
 6. OUTDOOR FIXED CAMERA, WV-CW1744 MOUNTED AS SHOWN ON DRAWING 5.1 (3).
 7. OUTDOOR PAN & TILT/ZOOM CAMERA, WV-CW1744 MOUNTED AS SHOWN ON DRAWING 5.1 (2).

DSA, Inc.
Technology Design Consultants
16618 East 196 th Street
Noblesville IN 46060-9530
(765) 534-5152

PROJECT: 04-1033
DRAWN BY: RJJ
CHECKED BY: LMD
SCALE: 1/8"=1'-0"
DATE: 04.28.2005

DUNELAND SCHOOL CORPORATION
CHESTERTON MIDDLE SCHOOL
CHESTERTON, INDIANA
CCTV SYSTEM

REVISIONS/DATE
1. 11/16/05 AS-BUILDS

DRAWING NUMBER

T2.1

2005-11-03