



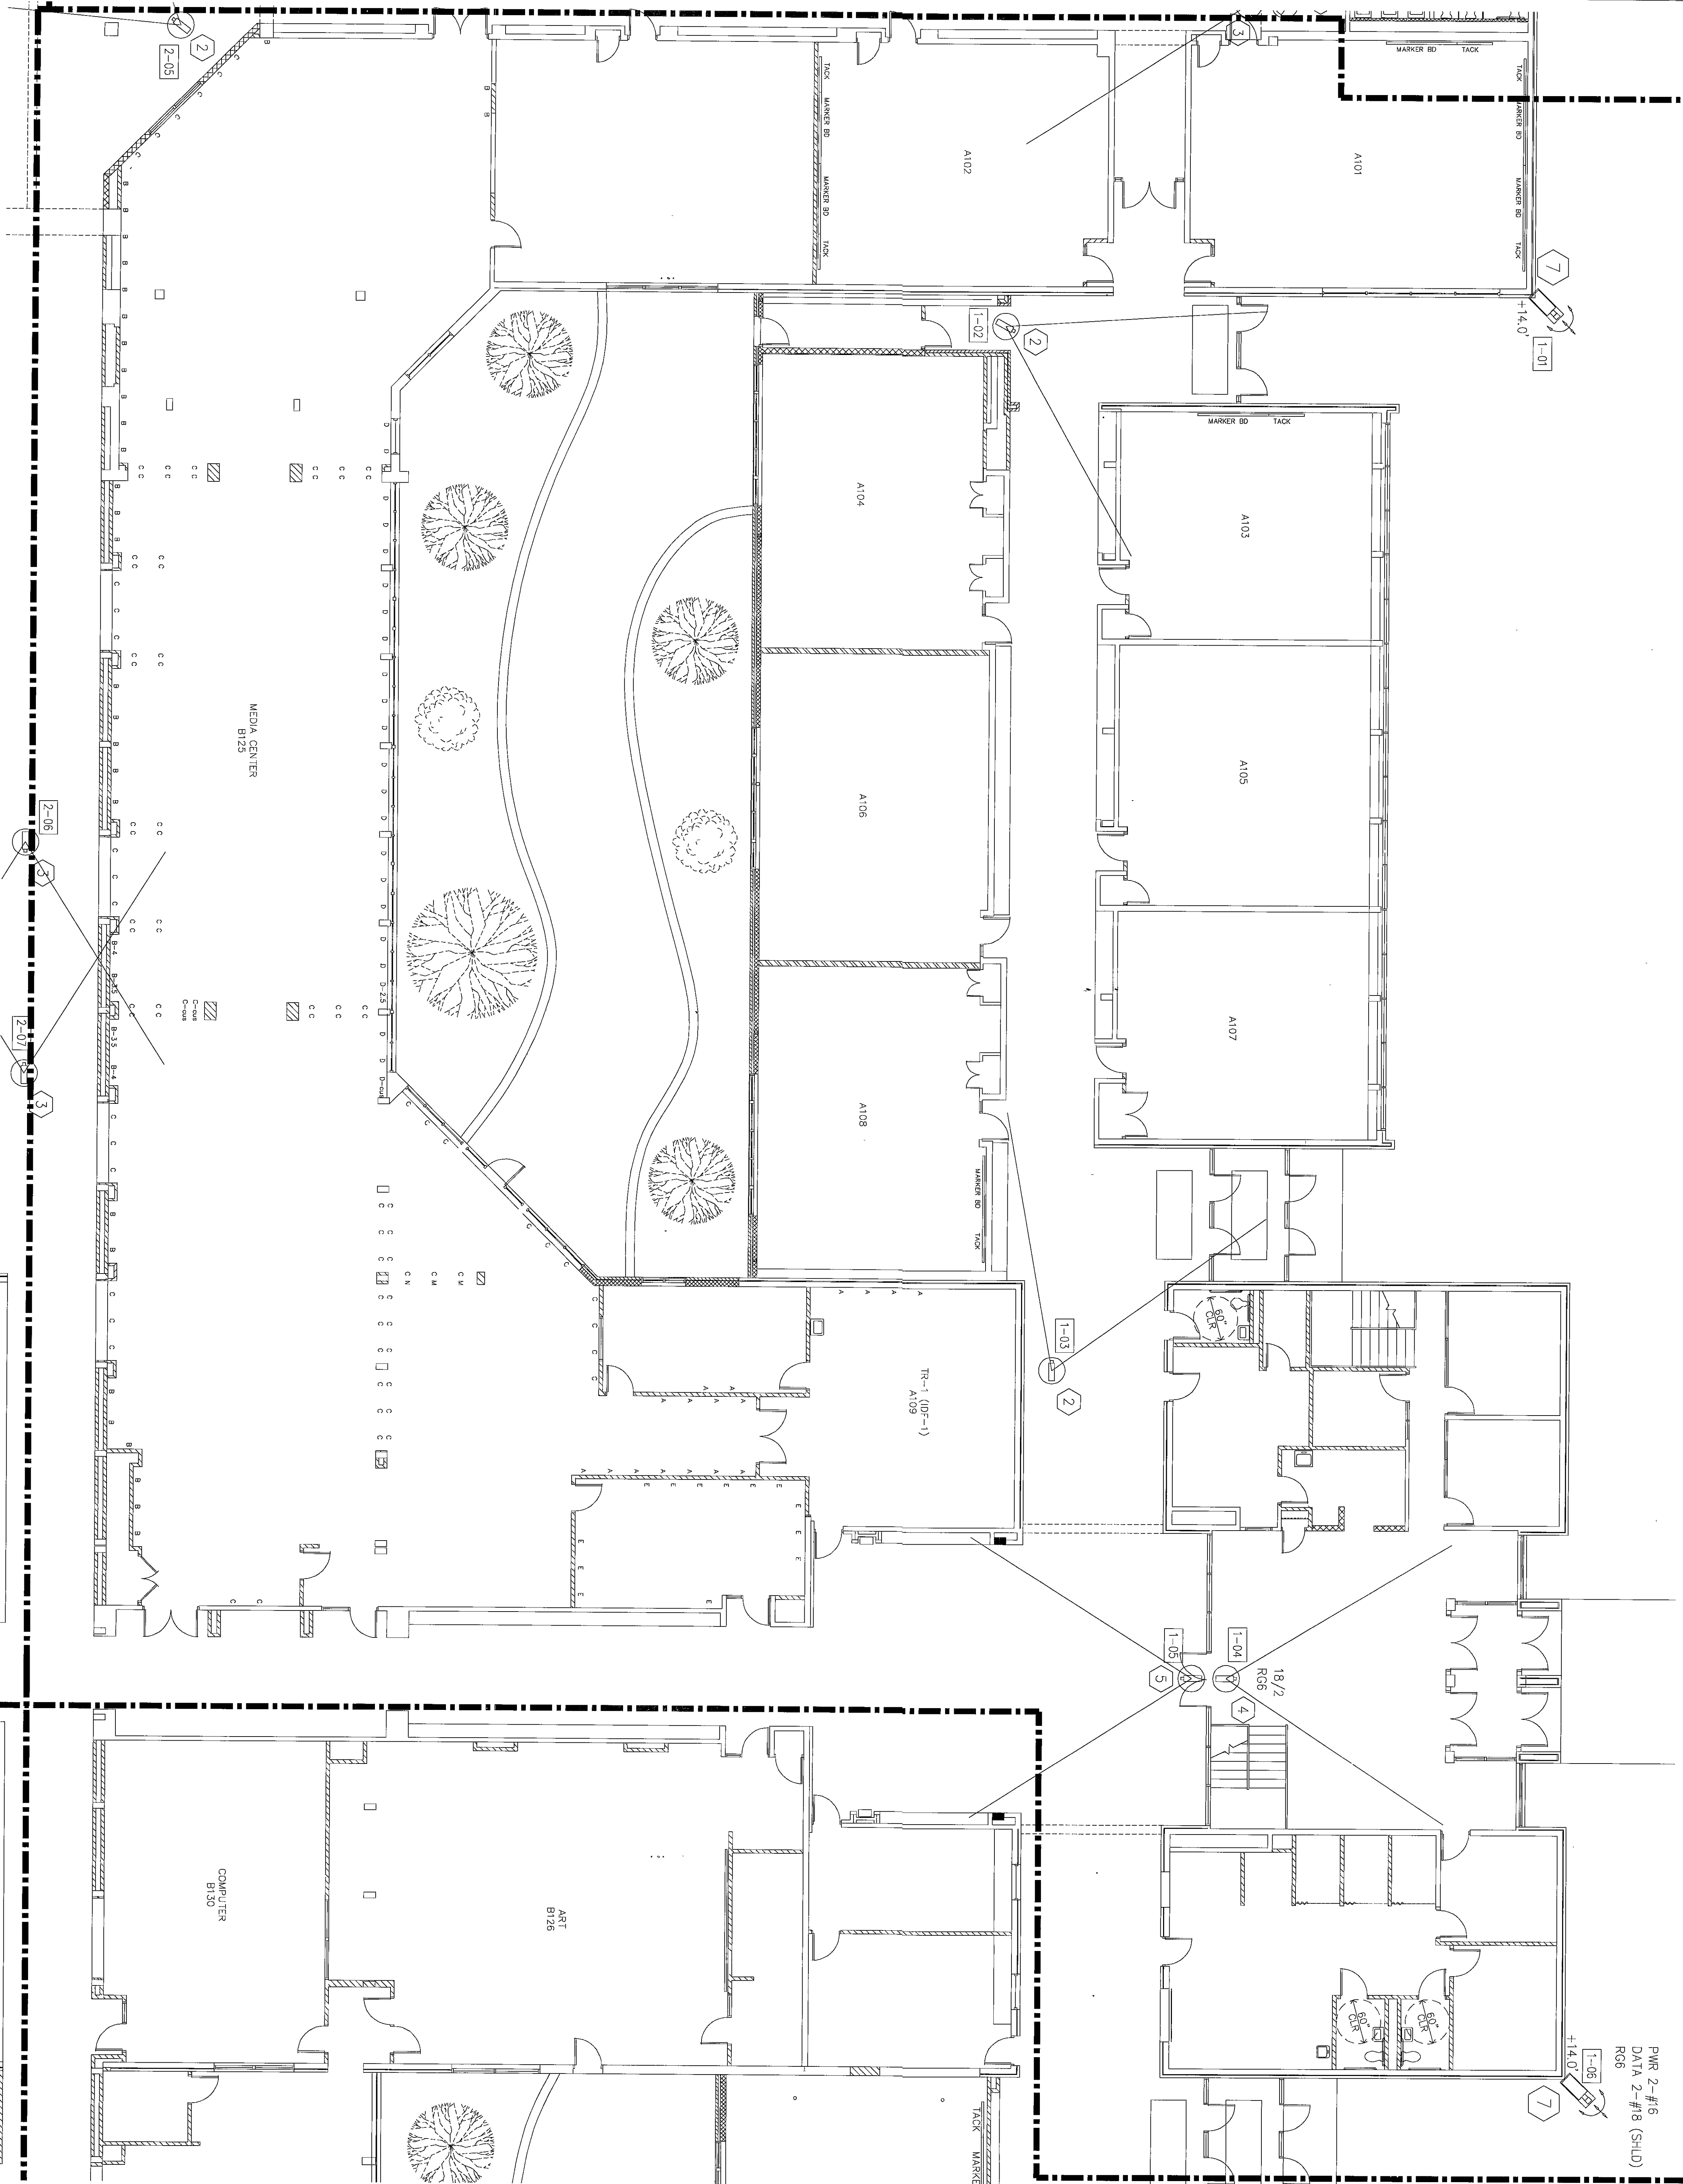

1. FLOOR PLAN - UNIT "B"
T2.2 SCALE: 1/8"=1'-0"
FIRST FLOOR

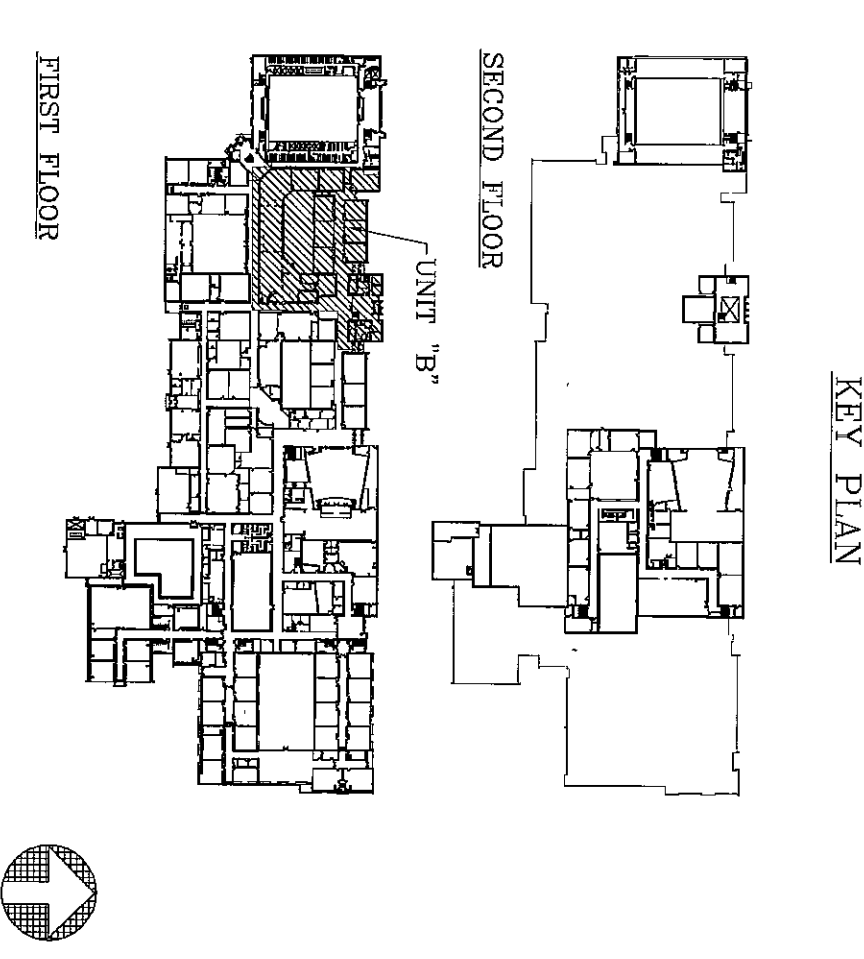

- SYMBOLS/LEGEND**
- 1.01 - CAMERA IDENTIFICATION NUMBER
- GENERAL NOTES**
1. ROUTE COAX CABLES (GENIUM RG-6 1795) TO EQUIPMENT ROOM (ER). TERMINATE BOTH ENDS AND TEST.
 2. ROUTE POWER CABLE (GENIUM SEE PER MFC REQUIREMENTS) TO EQUIPMENT ROOM (ER) OR TELECOMMUNICATION ROOM (TR) AS SHOWN IN DRAWING 4.1 (1) OUTDOOR CABLES TO HAVE A SEPARATE POWER RUN FOR THE HEATER.
 3. ROUTE DATA CABLE (RS-485) FOR OUTDOOR PAY/ZOOM CAMERAS PER MFC REQUIREMENTS TO EQUIPMENT ROOM (ER) AS SHOWN IN DRAWING 4.1 (1).
 4. ROUTE COAX AND POWER CABLES IN EXISTING TELECOMMUNICATION TRANS WHERE POSSIBLE.
 5. REFERENCED NOTES BELOW ARE NOT NECESSARILY USED ON EVERY DRAWING.
- REFERENCED NOTES**
1. EXISTING TRAY SYSTEM
 2. INDOOR CAMERA, W-CW-744F MOUNTED IN DROP CEILING. SEE DRAWING 5.1 (4).
 3. INDOOR CAMERA, W-2245F MOUNTED IN DROP CEILING. SEE DRAWING 5.1 (4).
 4. INDOOR CAMERA, W-CW-744S MOUNTED ON WALL. SEE DRAWING 5.1 (3).
 5. INDOOR CAMERA, W-CW-2245F MOUNTED ON WALL. SEE DRAWING 5.1 (3).
 6. OUTDOOR FIXED CAMERA, W-CW-377A MOUNTED AS SHOWN ON DRAWING 5.1 (6).
 7. OUTDOOR PAN & TILT/ZOOM CAMERA, W-CW-884A MOUNTED AS SHOWN ON DRAWING 5.1 (2).

9000-T6-04