



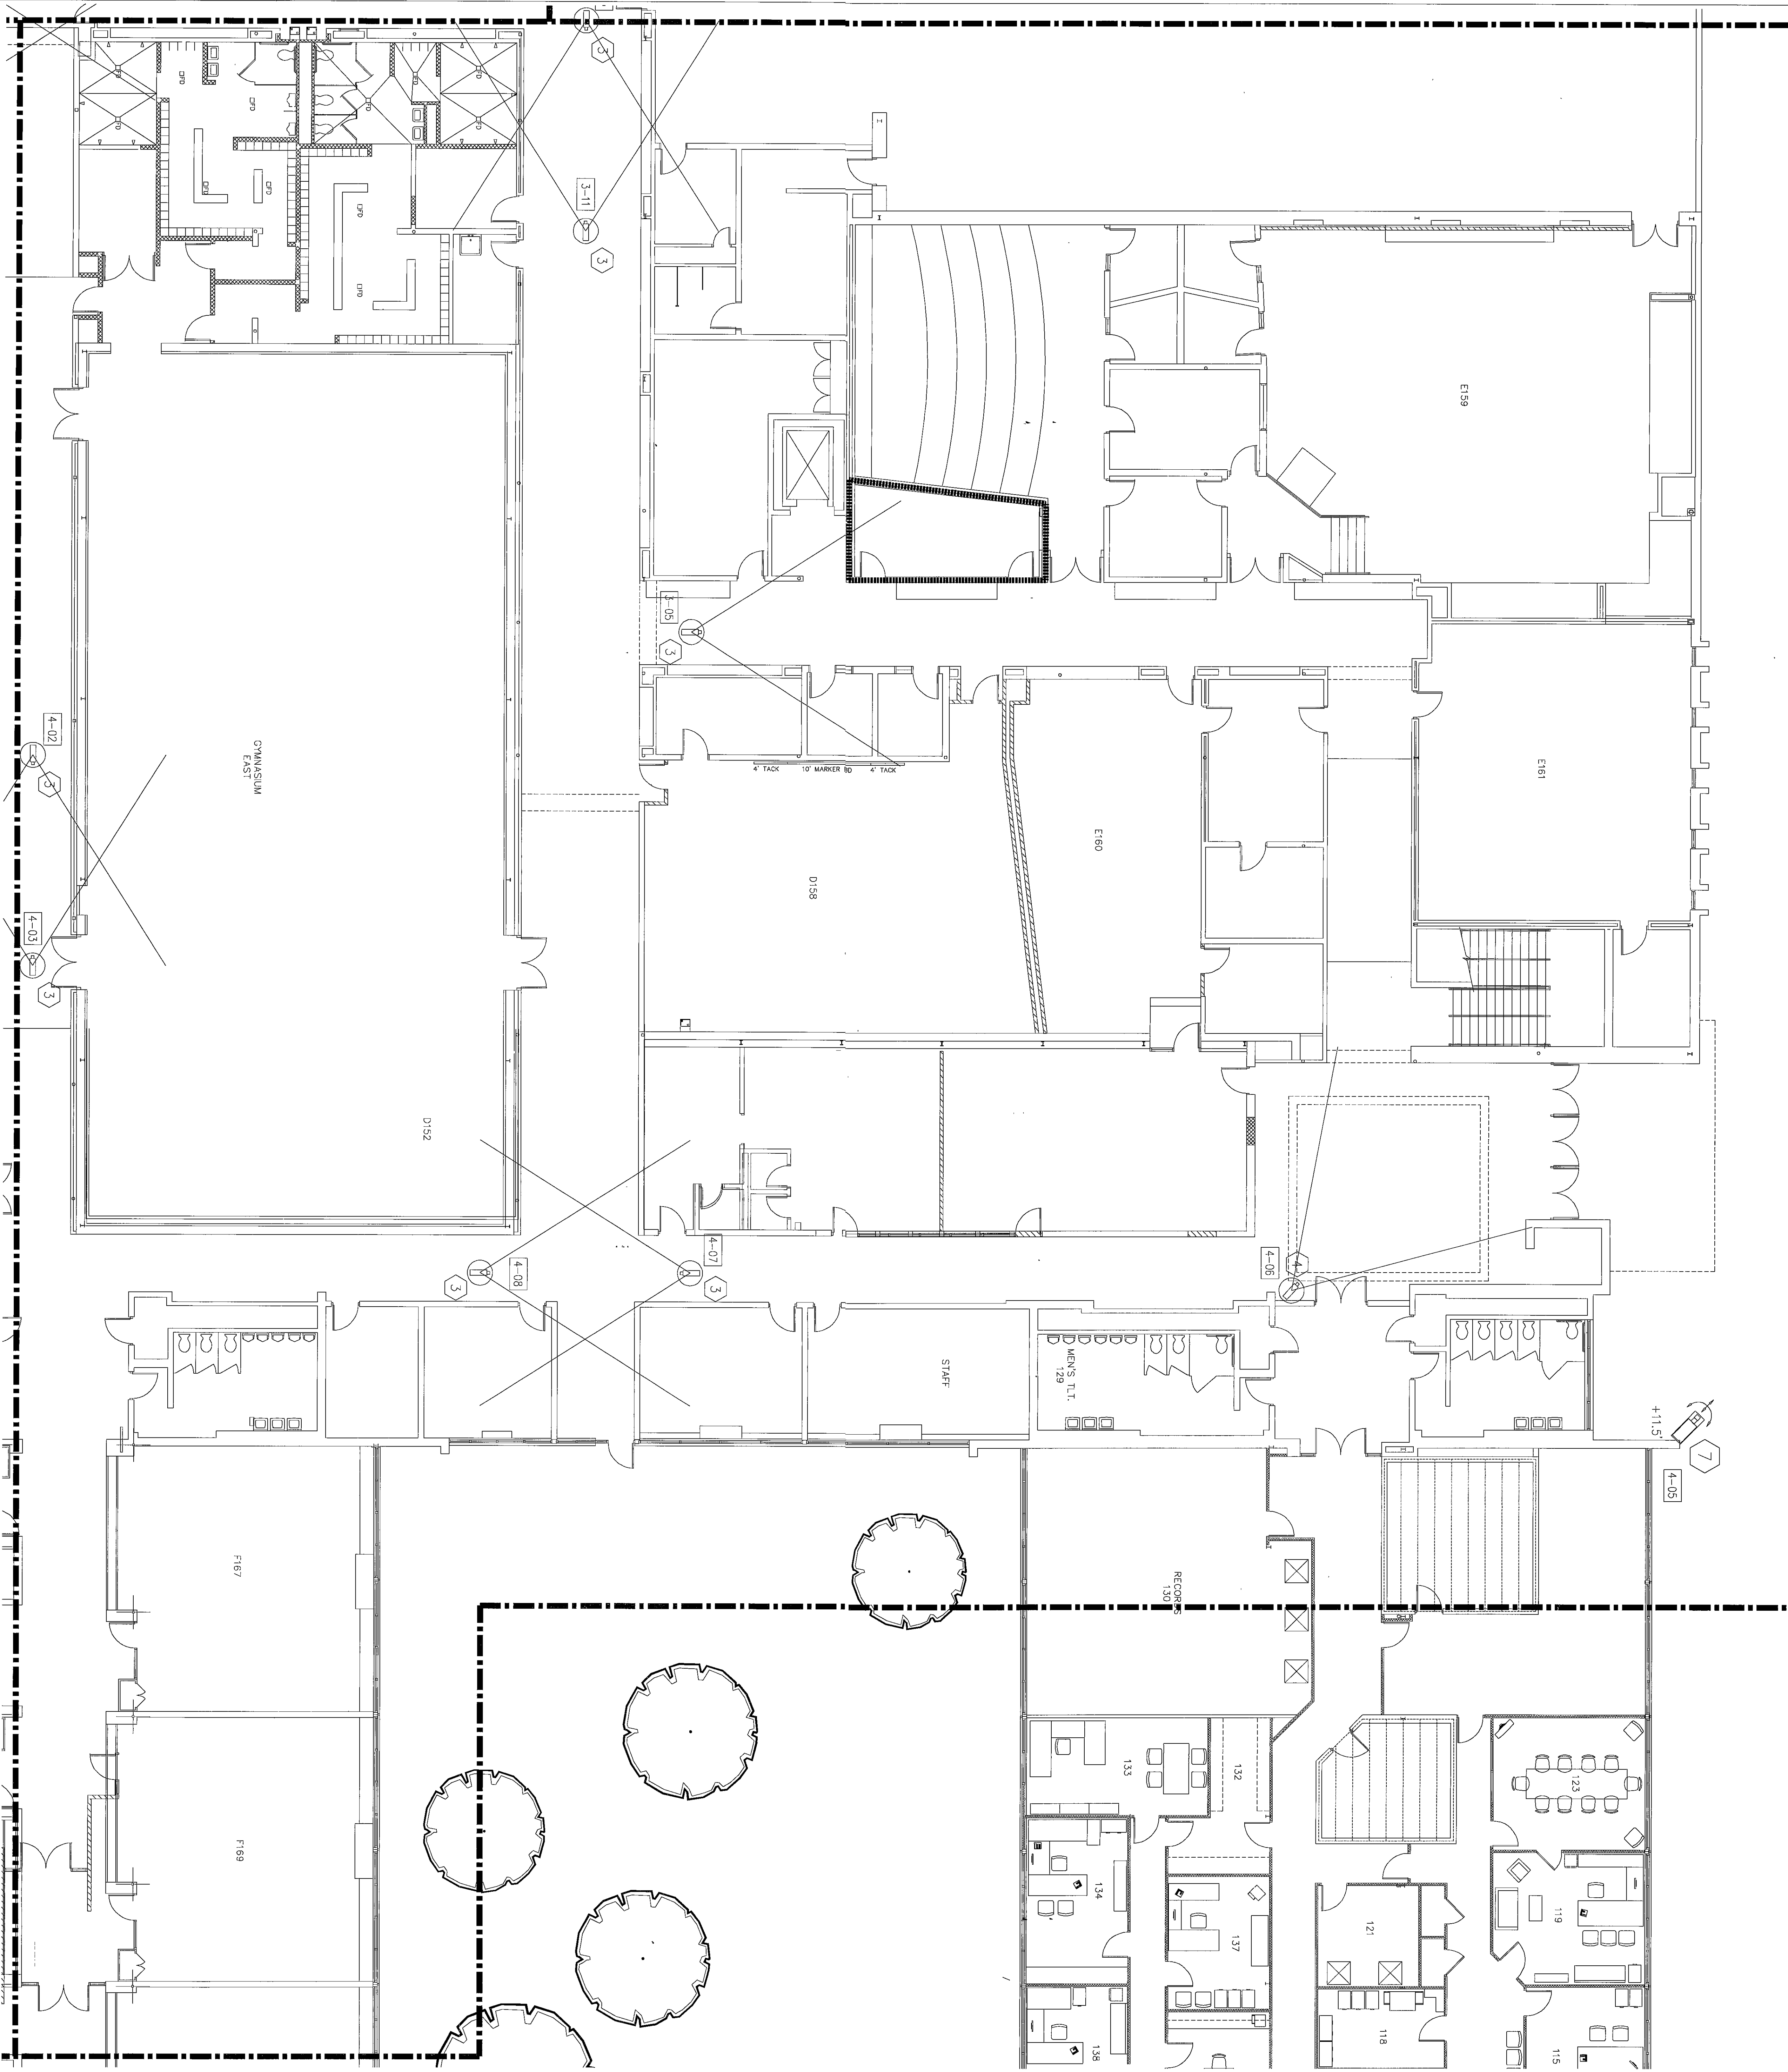

1 FLOOR PLAN - UNIT "F"
T2B SCALE: 1/8"=1'-0"
FIRST FLOOR

- SYMBOLS/LEGEND**
- 1. IF 1 - CAMERA IDENTIFICATION NUMBER**
- GENERAL NOTES**
1. ROUTE COAX CABLES (P/ENUM RC-6 TYPE) TO EQUIPMENT ROOM (ER), TERMINATE BOTH ENDS AND TEST.
 2. ROUTE POWER CABLE (P/ENUM, SIZE PER MFG. REQUIREMENTS) TO EQUIPMENT ROOM (ER) OR TELECOMMUNICATION ROOM (TR) AS SHOWN IN DRAWING 4.1 (1). OUTDOOR CAMERAS TO HAVE A SEPARATE POWER RUN FOR THE FEEDER.
 3. ROUTE DATA CABLE (RS-485) FOR OUTDOOR PAN/TILT/ZOOM CAMERAS PER MFG. REQUIREMENTS TO EQUIPMENT ROOM (ER) AS SHOWN IN DRAWING 4.1 (1).
 4. ROUTE COAX AND POWER CABLES IN EXISTING TELECOMMUNICATION TRAYS WHERE POSSIBLE.
 5. REFERENCED NOTES BELOW ARE NOT NECESSARILY USED ON EVERY DRAWING.
- REFERENCED NOTES**
1. EXISTING TRAY SYSTEM
 2. INDOOR CAMERA, WI-CW774AF MOUNTED IN DROP CEILING, SEE DRAWING 5.1 (4).
 3. INDOOR CAMERA, WI-224CF, MOUNTED IN DROP CEILING, SEE DRAWING 5.1 (4).
 4. INDOOR CAMERA, WI-CW774AS MOUNTED ON WALL, SEE DRAWING 5.1 (3).
 5. INDOOR CAMERA, WI-CW24CF MOUNTED ON WALL, SEE DRAWING 5.1 (3).
 6. OUTDOOR FIXED CAMERA, WI-CW574 MOUNTED AS SHOWN ON DRAWING 5.1 (6).
 7. OUTDOOR PAN & TILT/ZOOM CAMERA, WI-CW-6624 MOUNTED AS SHOWN ON DRAWING 5.1 (2).

KEY PLAN

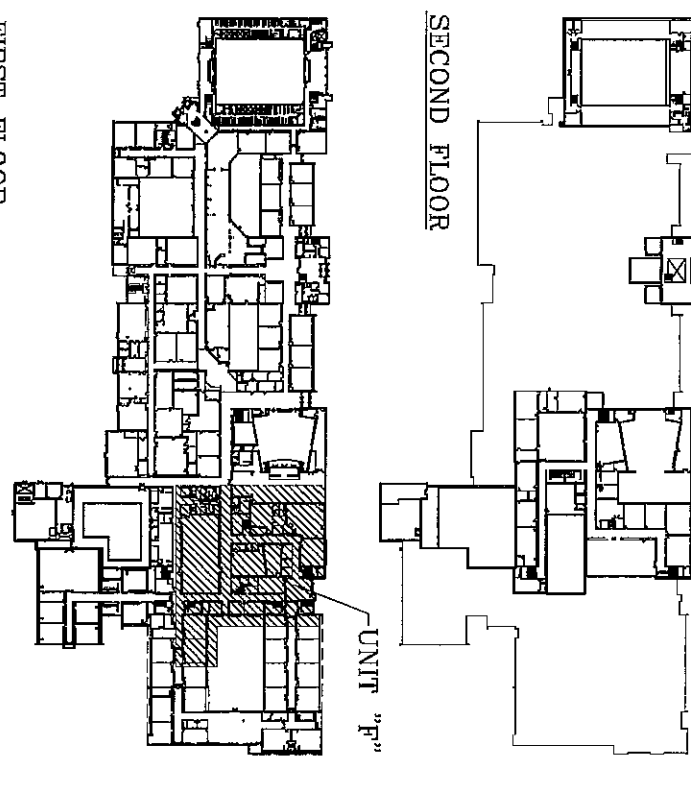

2005-12-08
NORTH
DRAFT FLOOR