



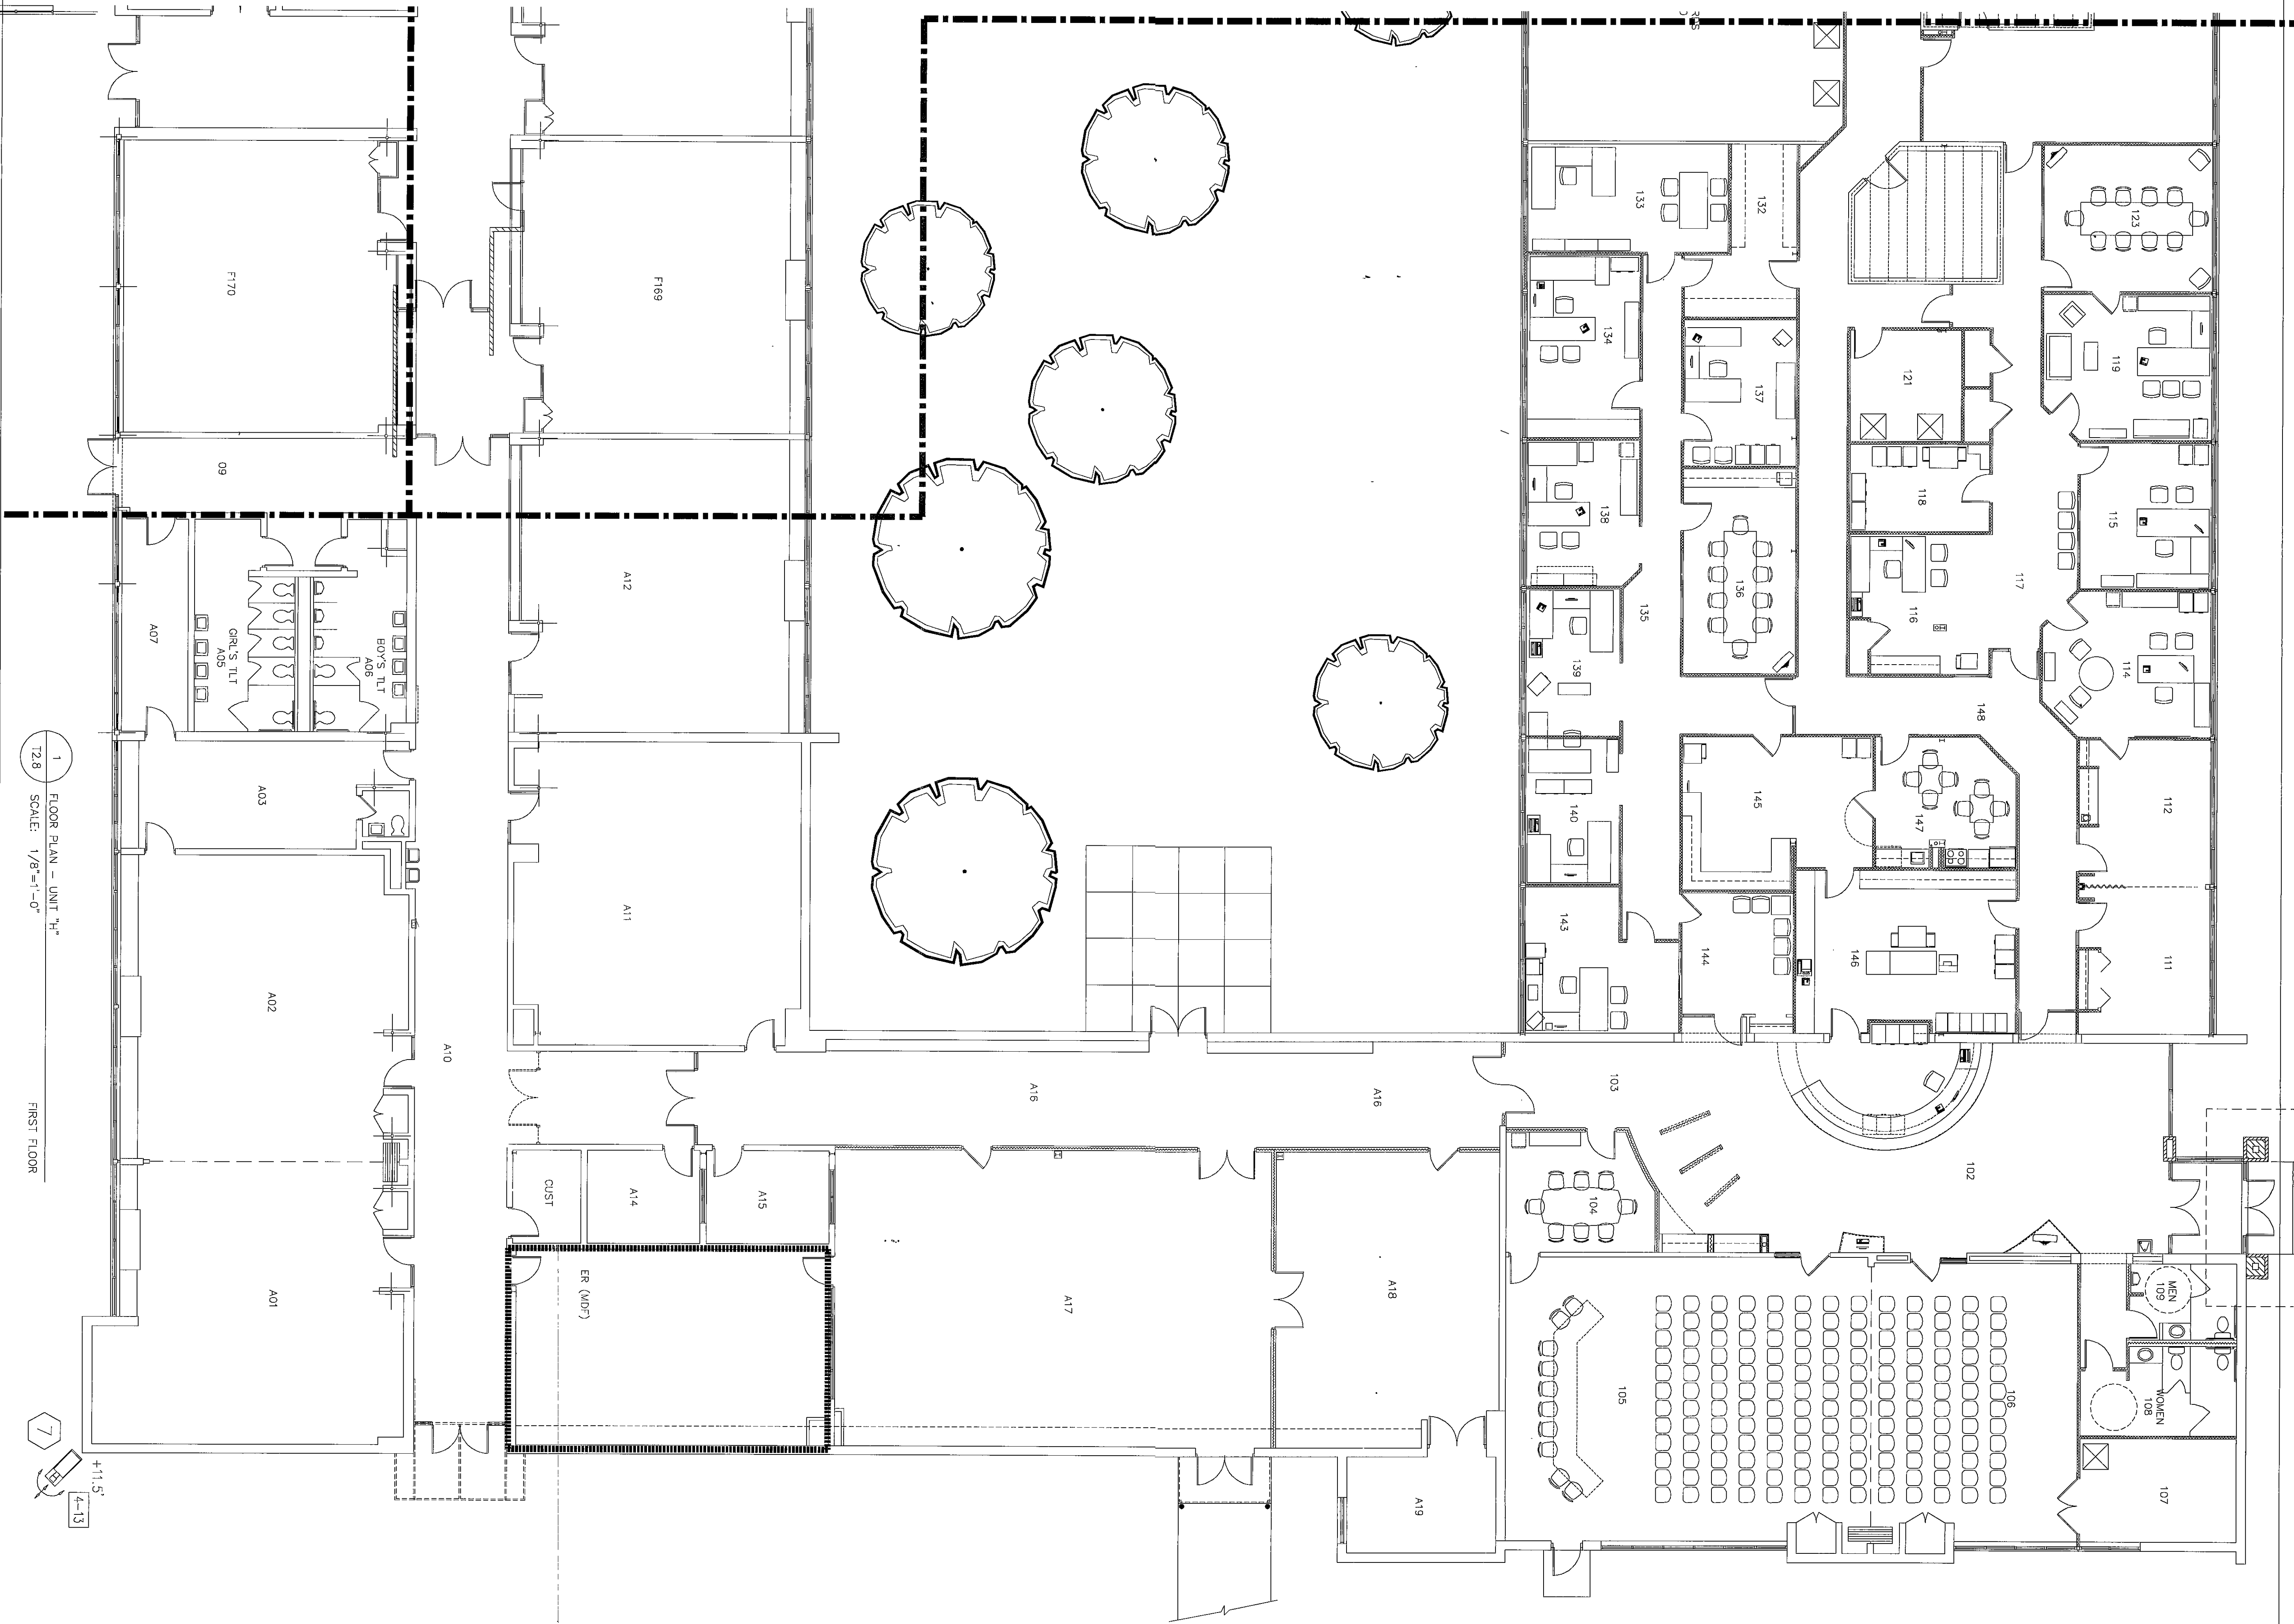

1 FLOOR PLAN - UNIT "H"
T2.8 SCALE: 1/8"=1'-0"
FIRST FLOOR

7
+11.5'
4-13

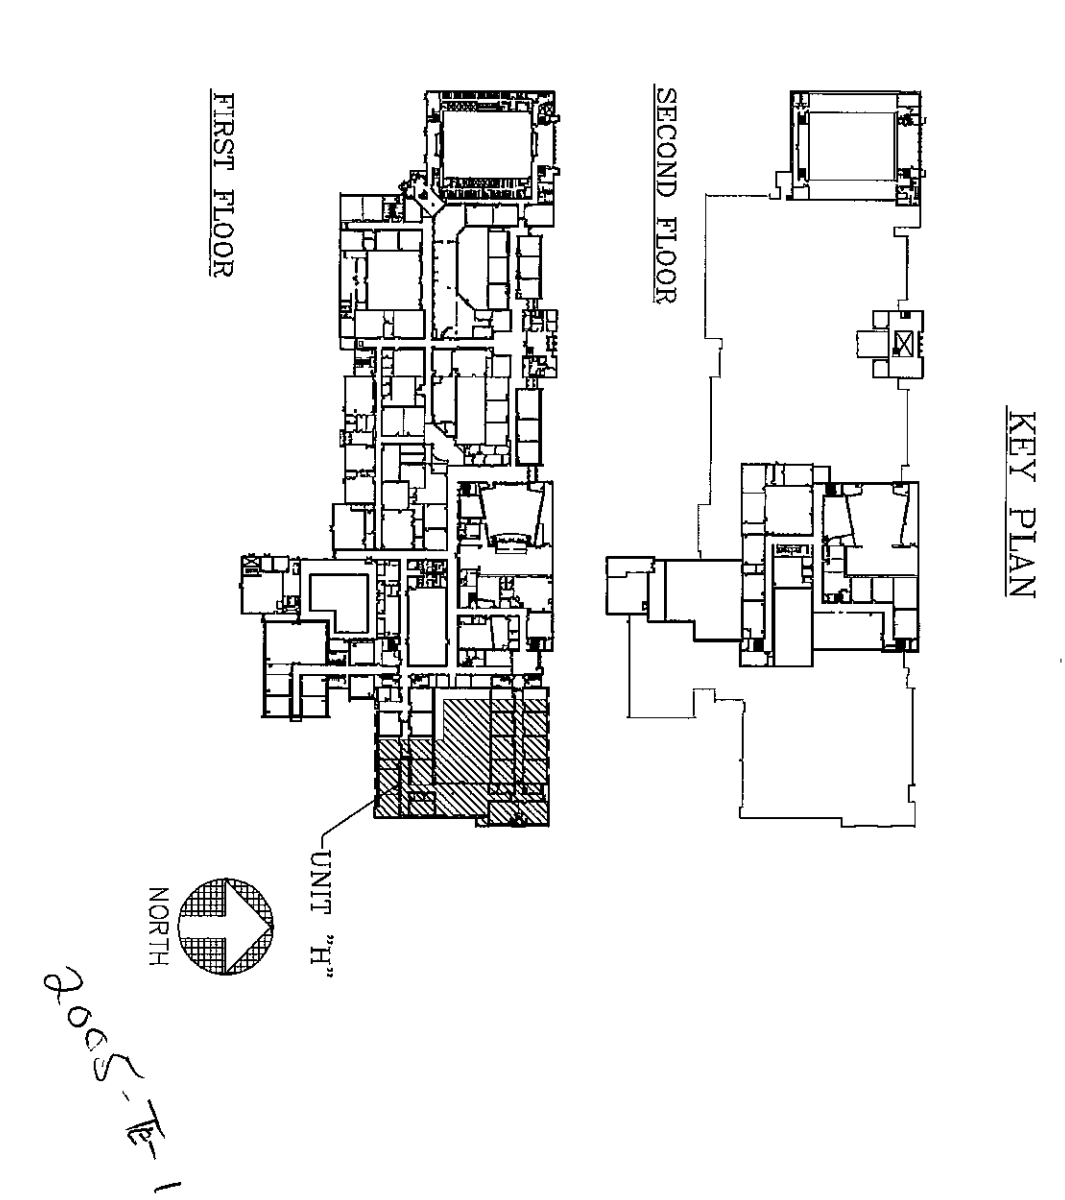

80° 55' E 10'

- SYMBOLS/LEGEND**
- GENERAL NOTES**
1. ROUTE COAX CABLES (PUSHING RG-6 TYPE) TO EQUIPMENT ROOM (ER), TERMINATE BOTH ENDS AND TEST.
 2. ROUTE POWER CABLE (RERUN, SIZE PER MFG. REQUIREMENTS) TO EQUIPMENT ROOM (ER) TO HAVE A SEPARATE POWER RUN FOR THE HEATER.
 3. ROUTE DATA CABLE (RS-485) FOR OUTDOOR PAN/TILT/ZOOM CAMERAS PER MFG. REQUIREMENTS TO EQUIPMENT ROOM (ER) AS SHOWN IN DRAWING 5.1 (7).
 4. ROUTE COAX AND POWER CABLES IN EXISTING TELECOMMUNICATION TRAYS WHERE POSSIBLE.
 5. REFERENCED NOTES BELOW ARE NOT NECESSARILY USED ON EVERY DRAWING.
- REFERENCED NOTES**
1. EXISTING TRAY SYSTEM
 2. INDOOR CAMERA, WI-CW774AF MOUNTED IN DROP CEILING. SEE DRAWING 5.1 (4).
 3. INDOOR CAMERA, WI-2240F, MOUNTED IN DROP CEILING. SEE DRAWING 5.1 (4).
 4. INDOOR CAMERA, WI-CW774AS MOUNTED ON WALL. SEE DRAWING 5.1 (3).
 5. INDOOR CAMERA, WI-CW2240F MOUNTED ON WALL. SEE DRAWING 5.1 (3).
 6. OUTDOOR FIXED CAMERA, WI-CW37A MOUNTED AS SHOWN ON DRAWING 5.1 (6).
 7. OUTDOOR PAN & TILT/ZOOM CAMERA, WI-CW-854A MOUNTED AS SHOWN ON DRAWING 5.1 (2).