




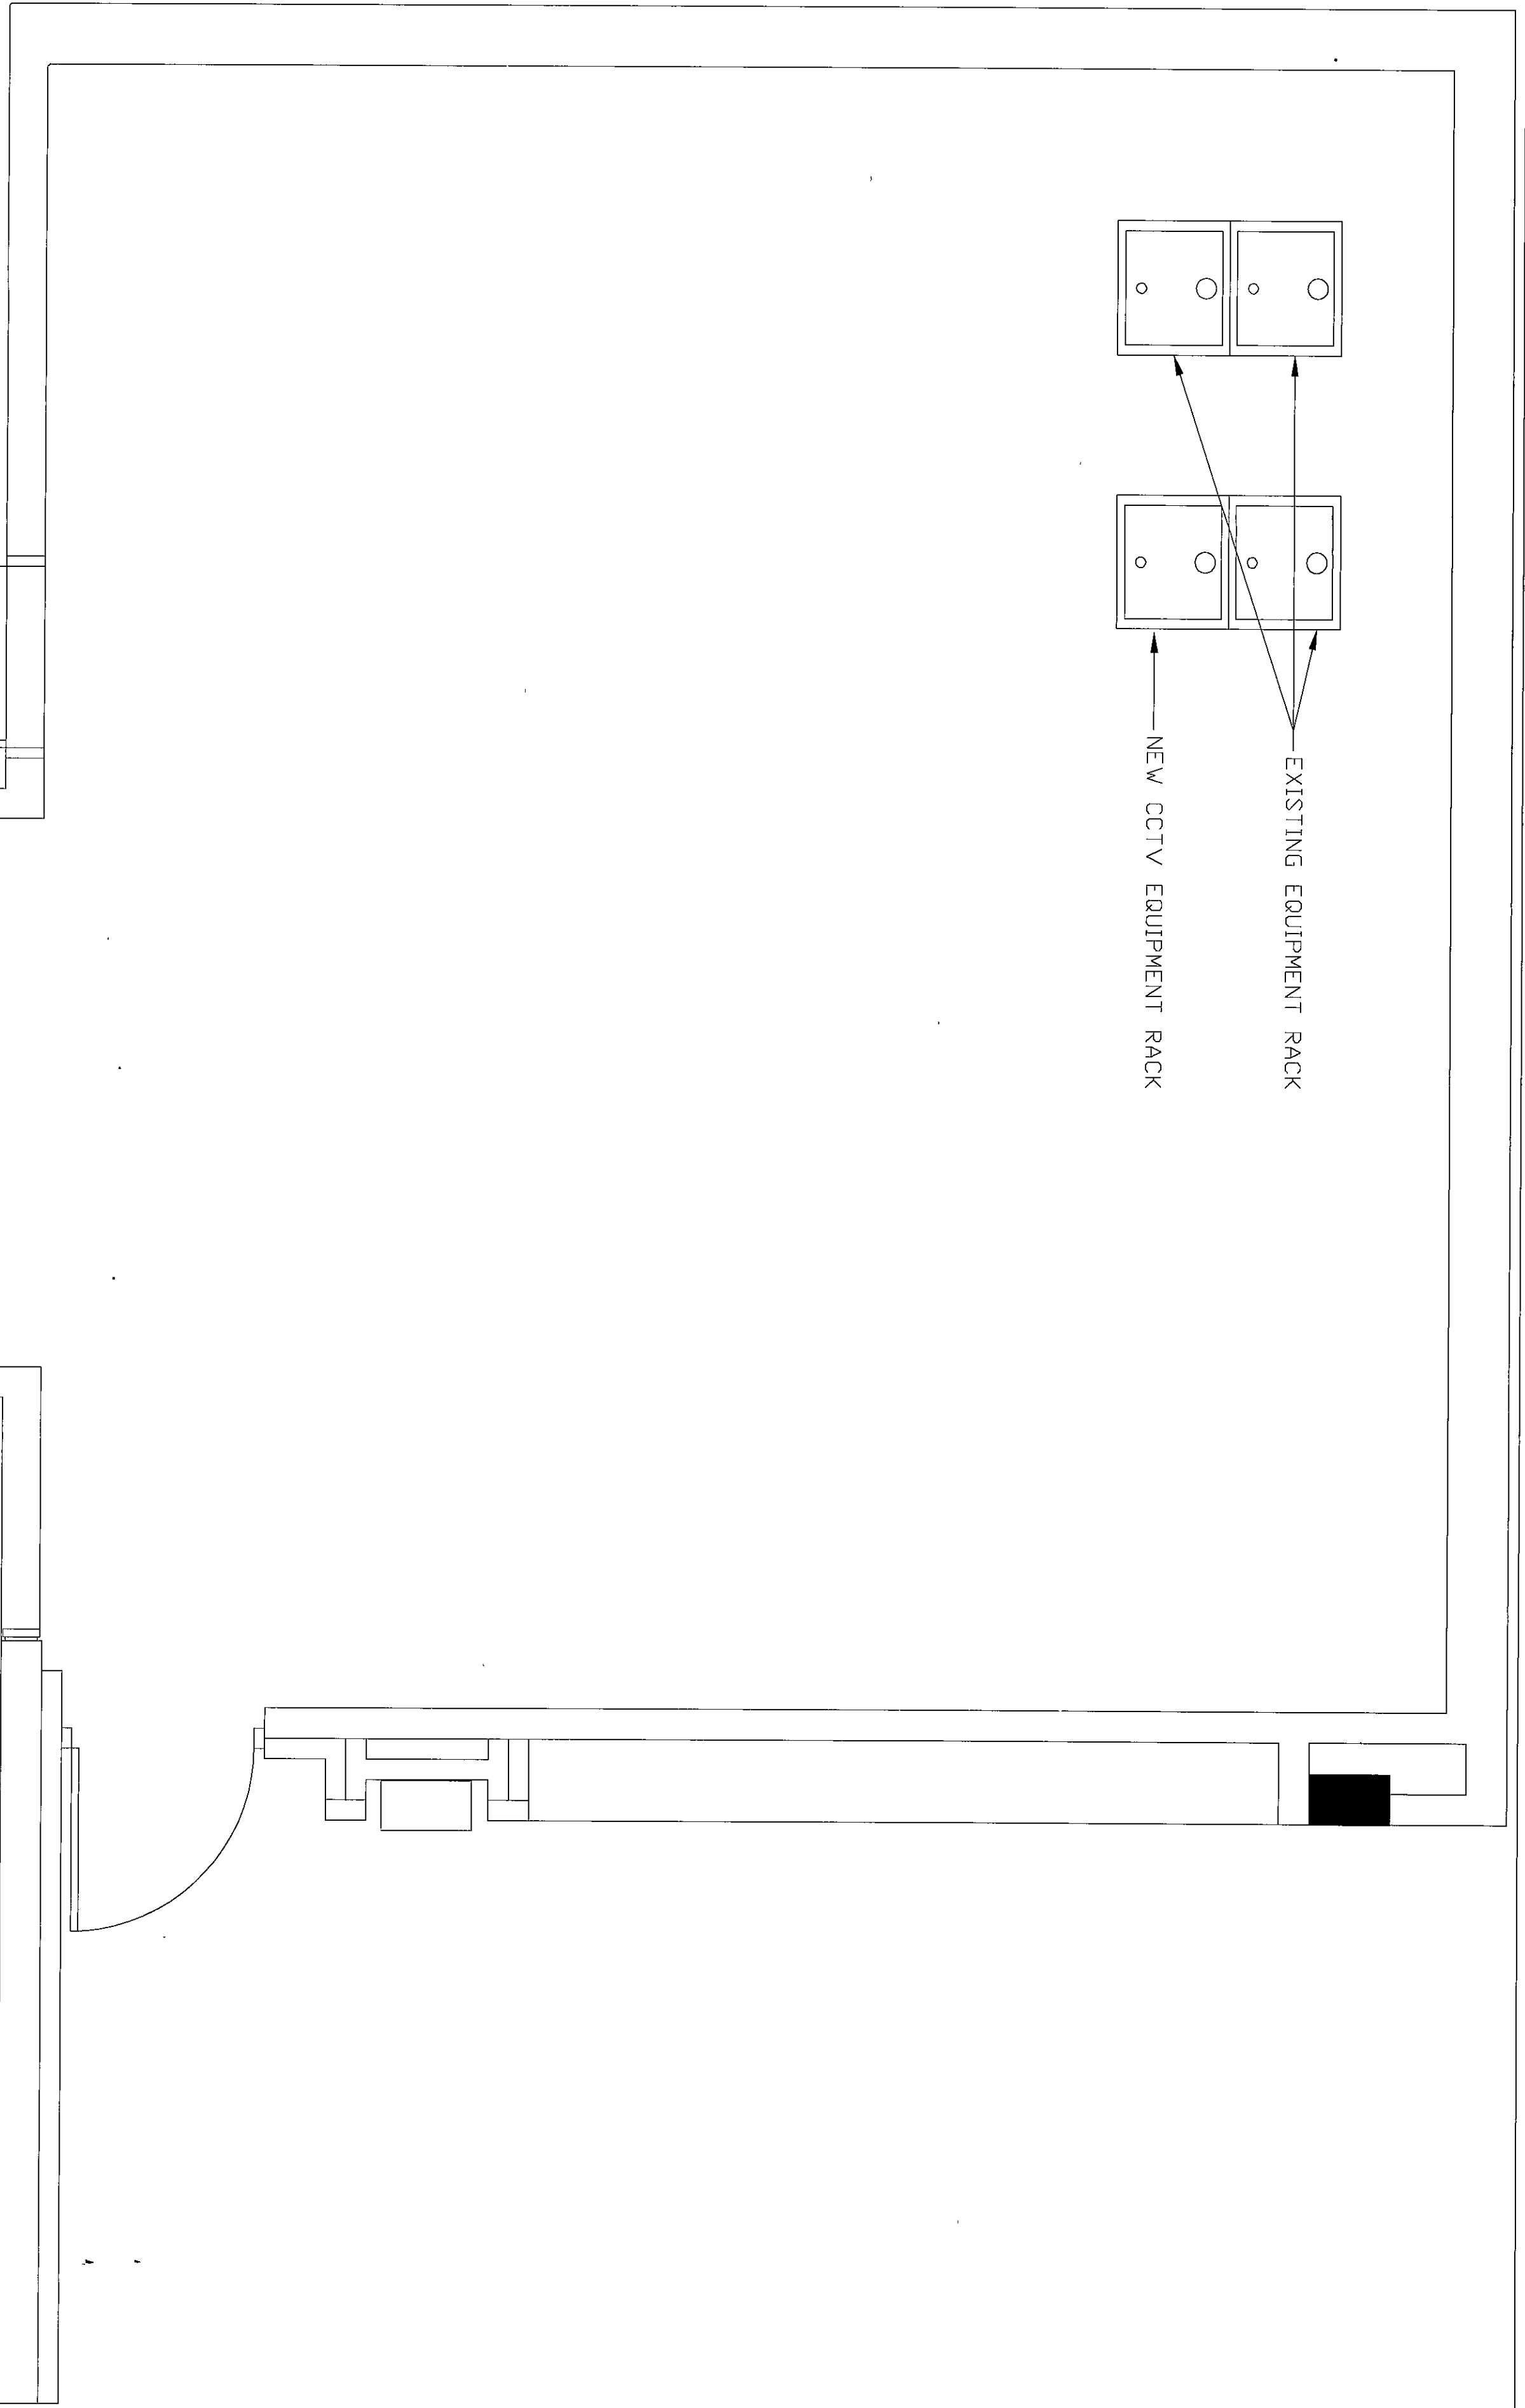


1 IDF #1 FLOOR PLAN
T4.1 SCALE: 1/2"=1'-0"
ROOM A109

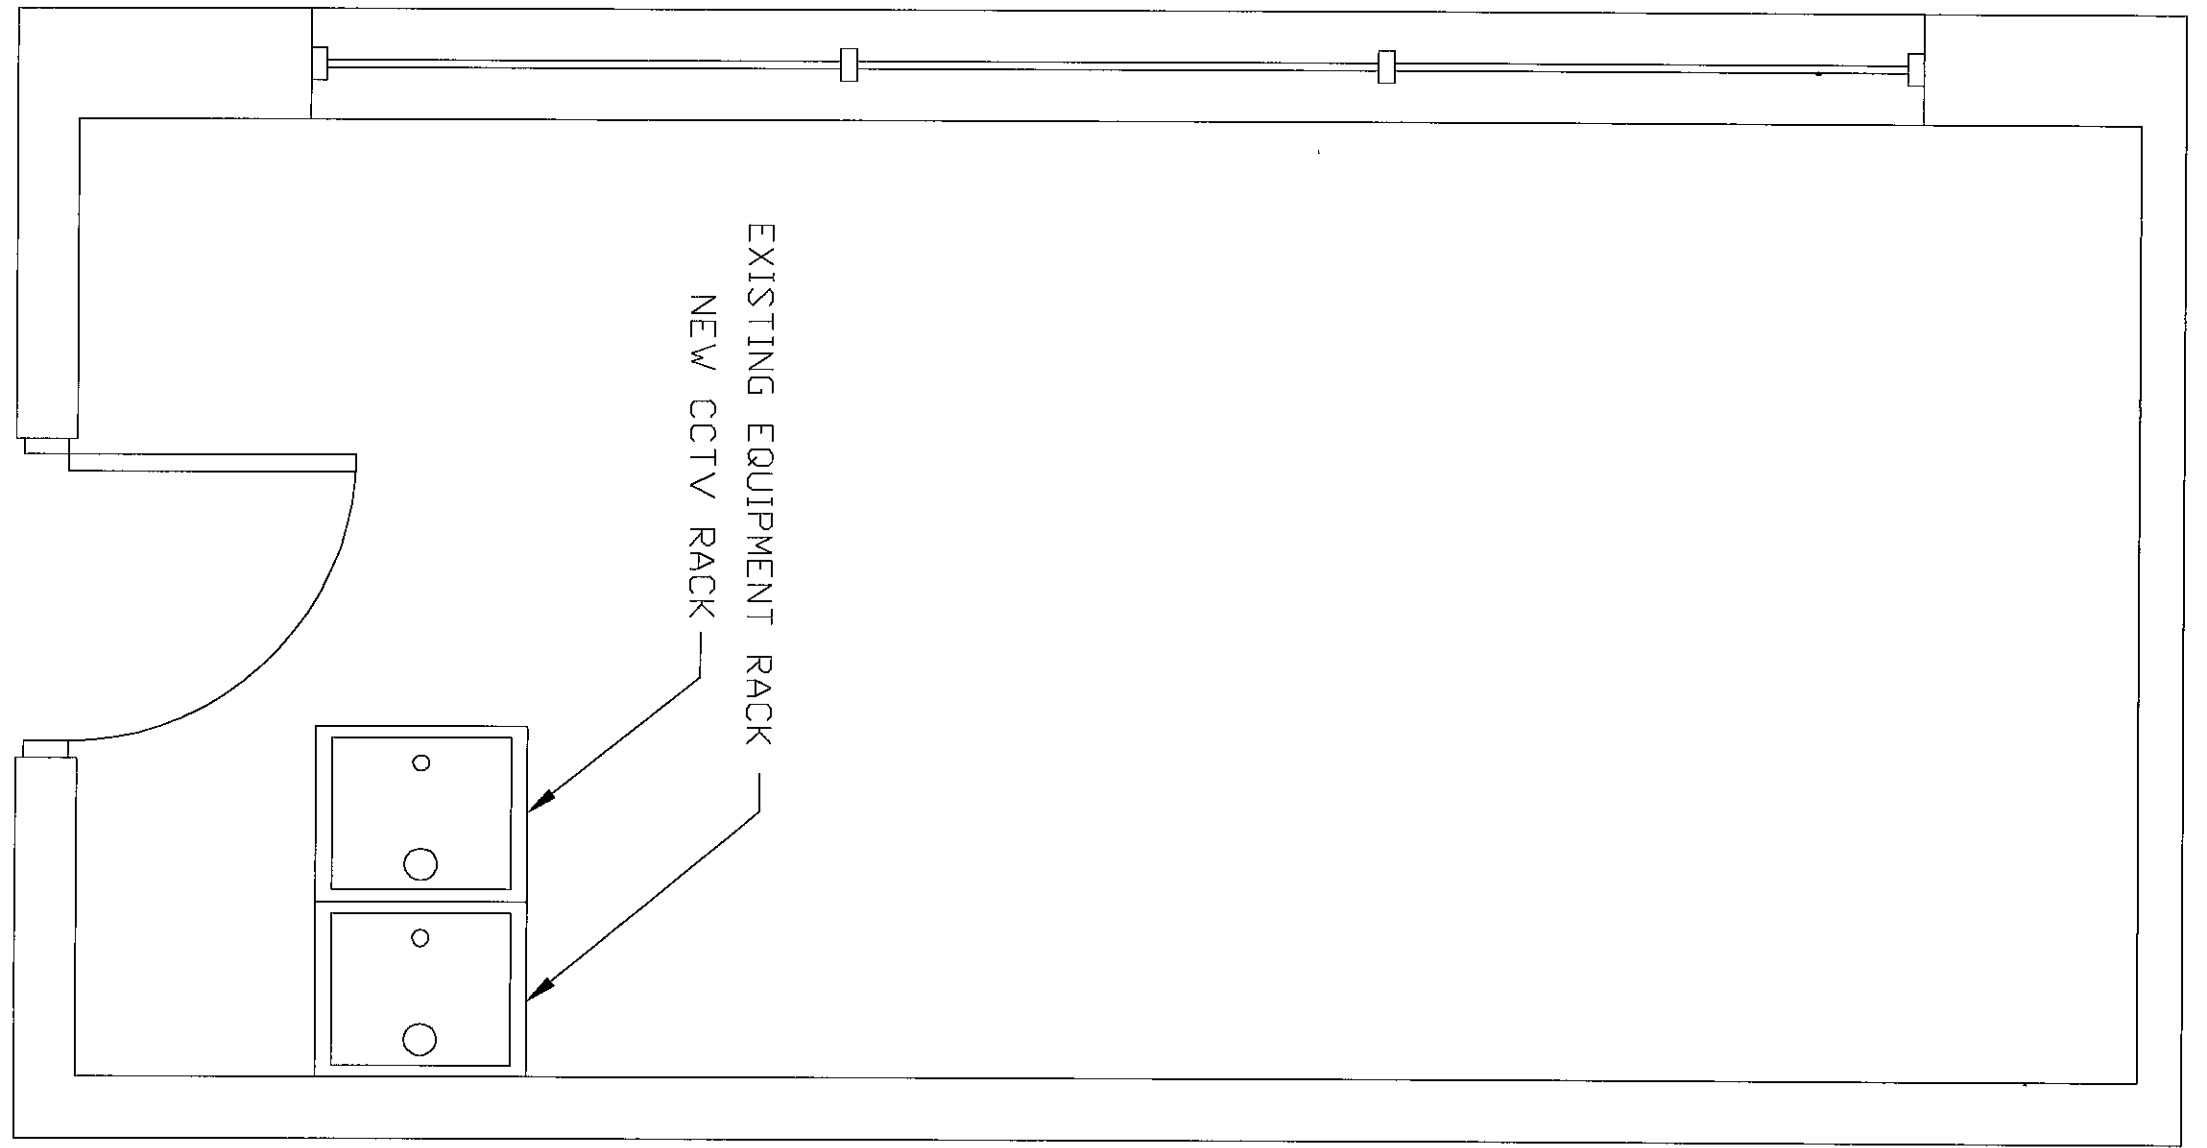


2 IDF #2 FLOOR PLAN
T4.1 SCALE: NTS
ROOM 119A

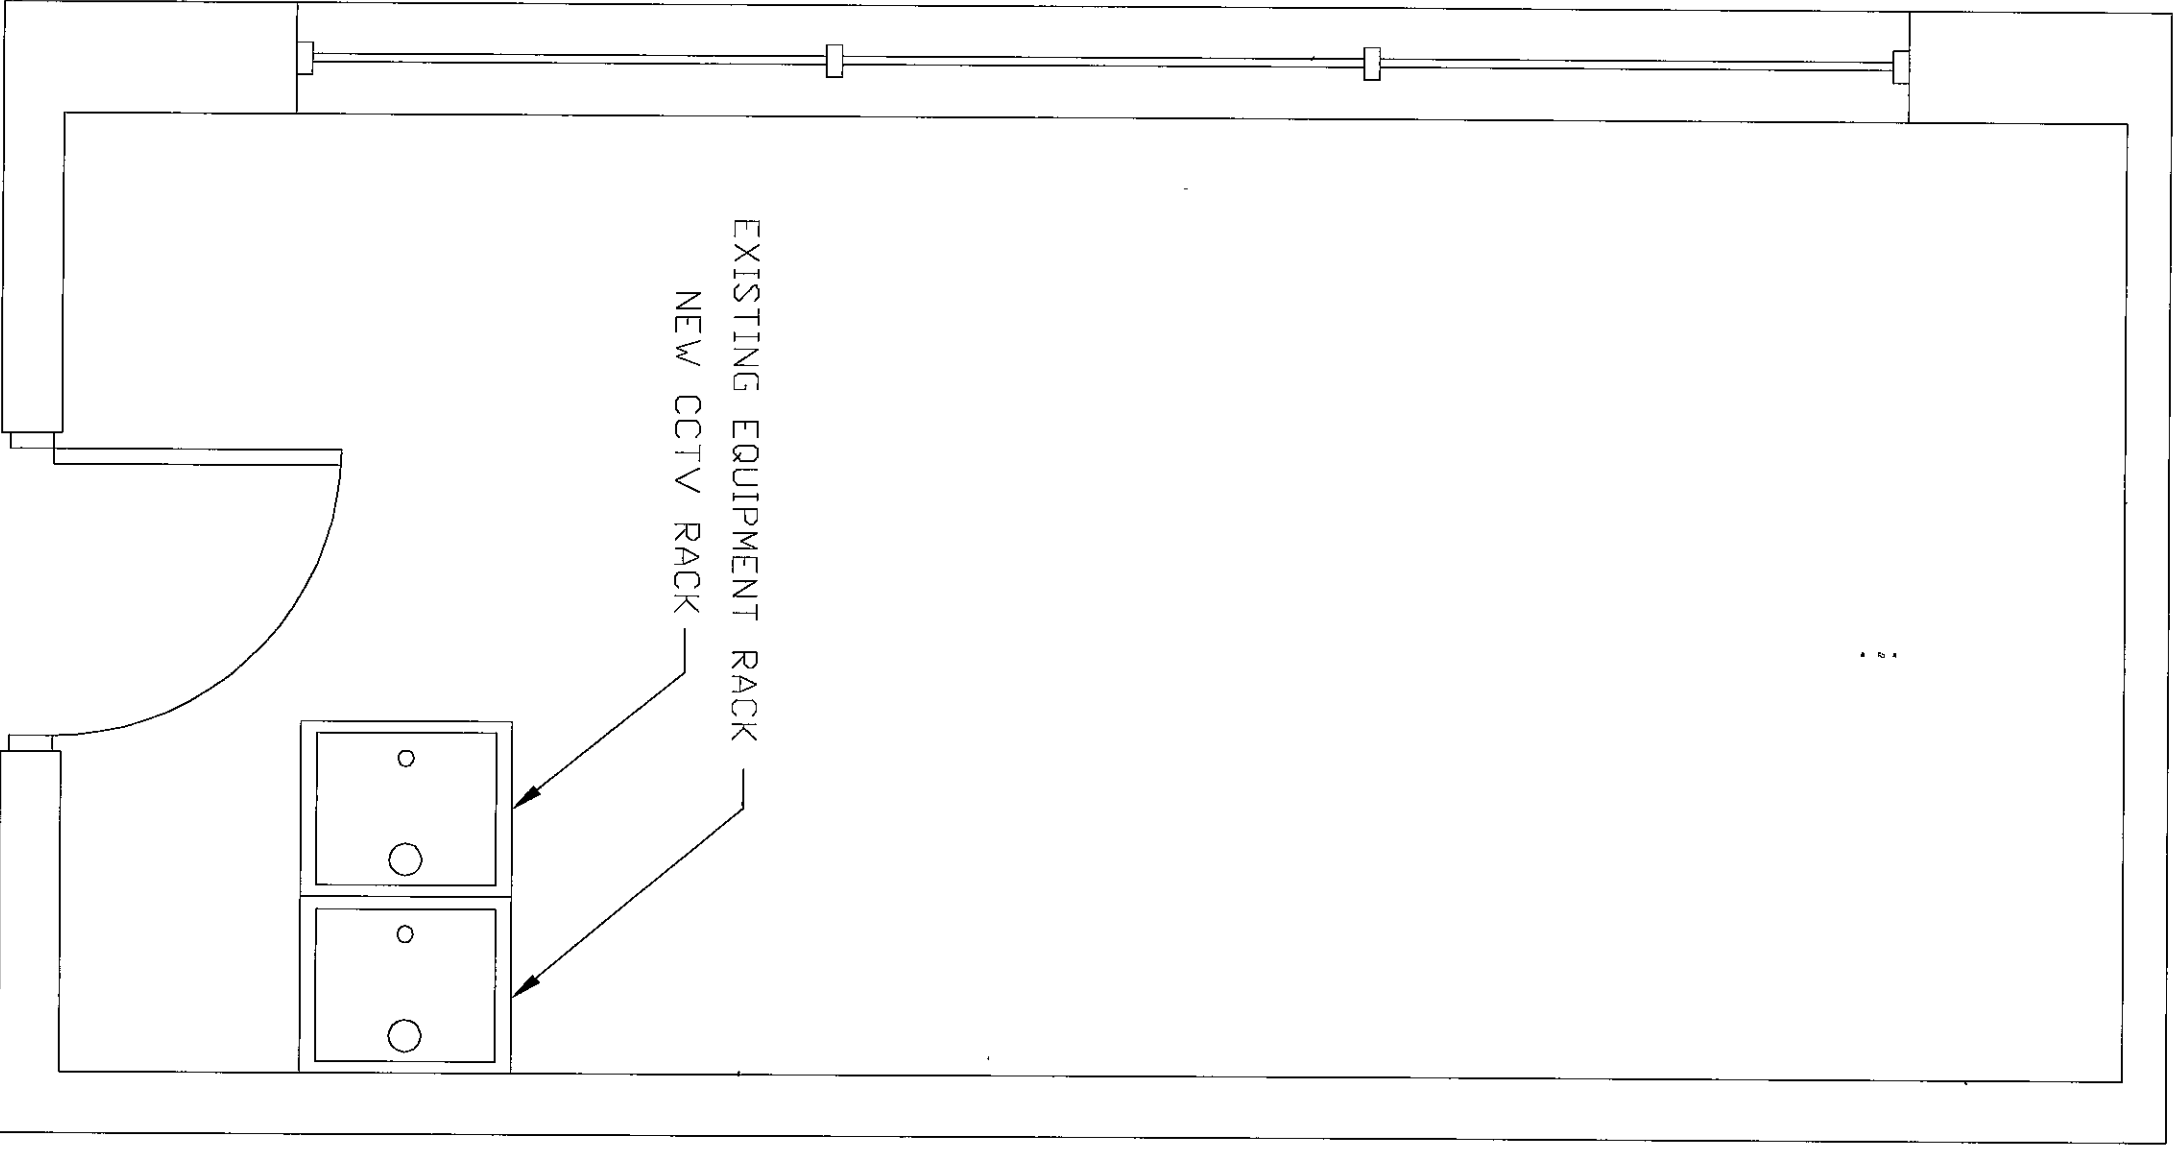

3 IDF #3 FLOOR PLAN
T4.1 SCALE: NTS
ROOM B138

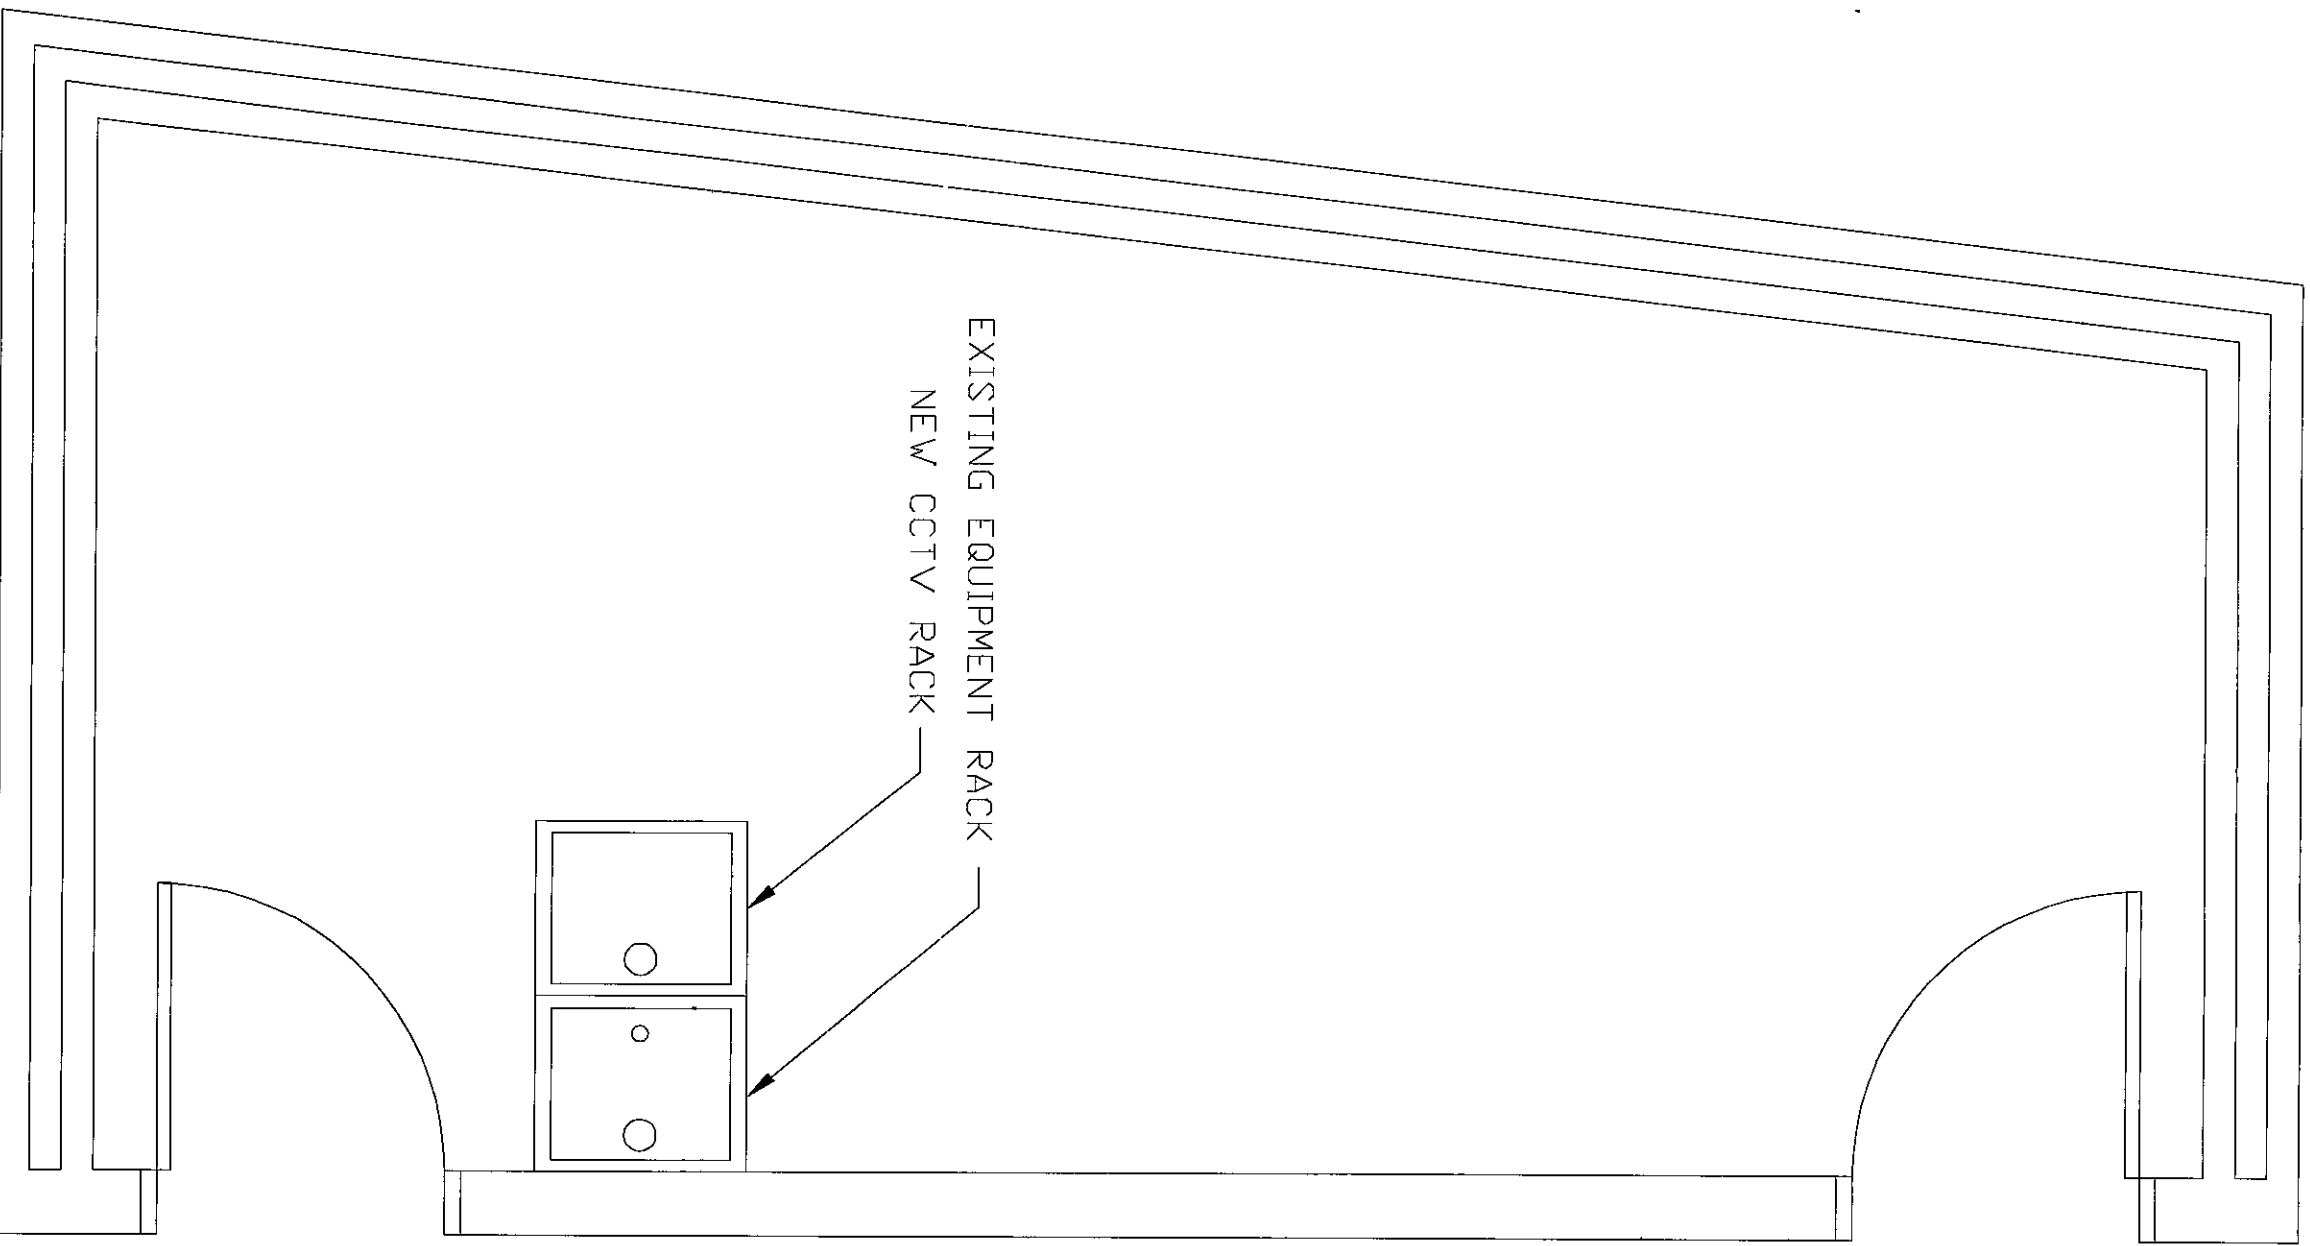

4 IDF #4 FLOOR PLAN
T4.1 SCALE: NTS
ROOM E155

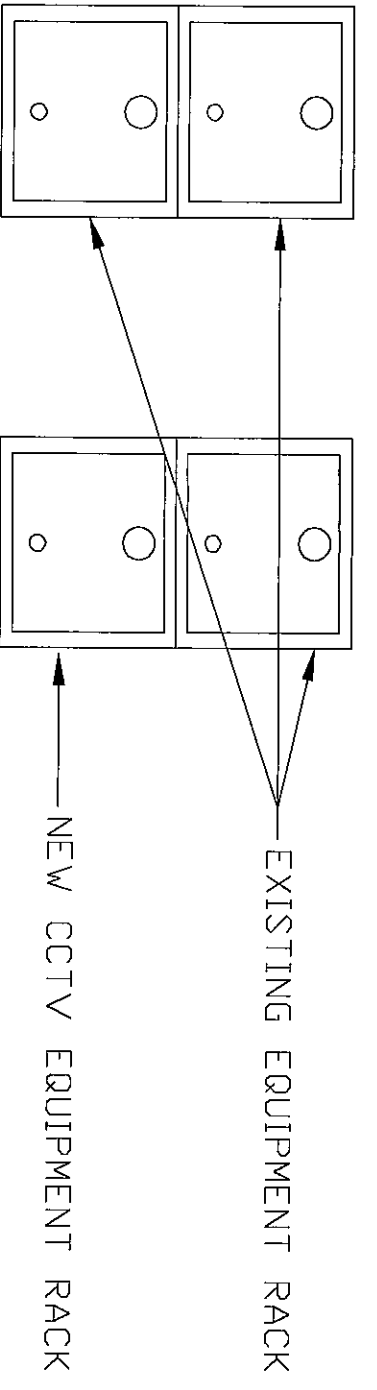

EXISTING EQUIPMENT RACK
NEW CCTV RACK

EXISTING EQUIPMENT RACK
NEW CCTV RACK

EXISTING EQUIPMENT RACK
NEW CCTV RACK

DSA Inc.
Technology Design Consultants
16618 East 196 th Street
Noblesville IN 46060-9530
(765) 534-5152

PROJECT: 04-1033
DRAWN BY: RJJ
CHECKED BY: LMD
SCALE: 1/8"=1'-0"
DATE: 04.28.2005

DUNELAND SCHOOL CORPORATION
CHESTERTON MIDDLE SCHOOL
CHESTERTON, INDIANA
CCTV SYSTEM

REVISIONS/DATE
1. 11/16/05 AS-BUILDS

DRAWING NUMBER
T4.1

3008-10-13