


- GENERAL NOTES:
1. ALL CONDUIT, CABLES, DIAL, COMPONENT RACKS, CABLE TRAY PROVIDED BY DIVISION 16, CONTRACTOR. SHOWN IN DRAWINGS FOR REFERENCE ONLY.

- REFERENCED NOTES:
1. SEE TS-5.0(2) TYPICAL FOR ALL CLASSROOMS. PROVIDE (1) 27" MULTI-MEDIA MONITOR & (1) 5-WAY VCR IN ALL CLASSROOMS.
 2. MOUNT DEVICES (PLATE/PERCH) IN RACKWAY PROVIDED BY DIVISION 16 CONTRACTOR. TYPICAL AS INDICATED.
 3. SEE TS-5.0(3) PROVIDE 30" MONITOR/BRACKET AND 30" VCR MONITOR/BRACKET.
 4. SEE TS-5.0(4) FOR ADDITIONAL INFORMATION.
 5. PROVIDE EQUIPMENT NUMBER OF CAT 6 CABLES AND COAX TO PROVIDE SAME SERVICE AS PRINCIPAL'S. PROVIDE 30' CABLE IN COIL IN CENTER OF SPACE.
 6. PROVIDE 30'-0" CAT6 CABLE COILED NEATLY ABOVE CEILING FOR FUTURE USE. TERMINATE OTHER END AS MONITOR/7" MULTI-MEDIA MONITOR/BRACKET ONLY. NO VCR. LOOP SIGNALS FROM PRIMARY MONITOR.
 7. PROVIDE 27" MONITOR/BRACKET ONLY. NO VCR. PROVIDE ONE (1) 7" CONNECTOR IN PLATE FOR LOCAL INPUT ONLY. NO MONITOR. NO VCR. MOUNT AT 16' HFT.
 8. SEE TS-5.1 (1) FOR ADDITIONAL INFORMATION.
 9. SEE TS-5.1 (2) FOR ADDITIONAL INFORMATION.
 10. SEE TS-5.1 (3) FOR ADDITIONAL INFORMATION.
 11. PROVIDE 30" MULTI-MEDIA MONITOR/BRACKET. NO VCR. SEE TS-5.1 (5)
 12. INTERCOM HORN SPEAKER MOUNT AT 12' AFF OR NEAR CENTER OF ROOM.
 13. PROVIDE 30" MULTI-MEDIA MONITOR/BRACKET. NO VCR. SEE TS-5.1 (5)
 14. INTERCOM HORN SPEAKER MOUNT AT 12' AFF OR NEAR CENTER OF ROOM.
 15. CABLE TRAY SHOWN FOR REFERENCE ONLY.
 16. CEILING SPEAKERS. ROUTE TO ROOM MUSE/AMPLIFIER. TYPICAL OF 16.
 17. SURFACE MOUNT AUDIOVISUAL SPEAKER.
 18. WALL MOUNT 8'x12' PROJECTION SCREEN.
 19. CEILING MOUNT L20 PROJECTOR. ROUTE CABLE TO AV EQUIPMENT RACK.
 20. AV EQUIPMENT RACK.
 21. ADDITIONAL EQUIPMENT RACK.

KEY PLAN:

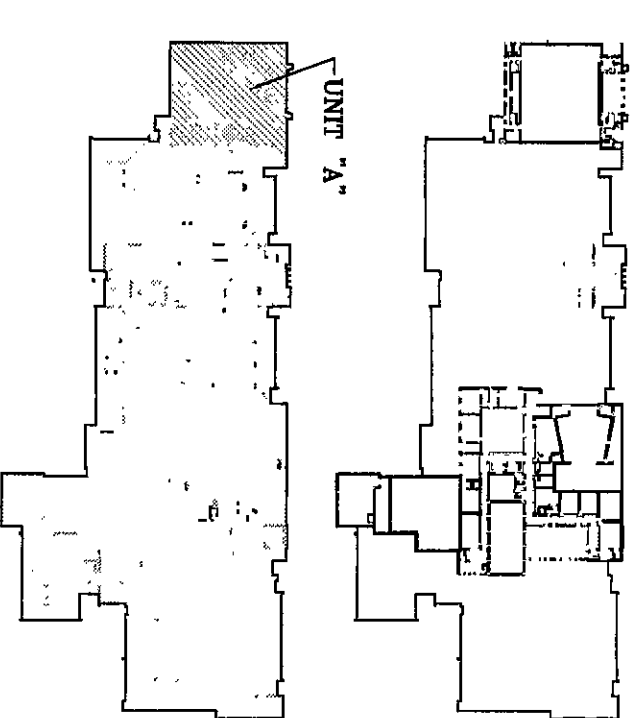

NORTH
SCALE: NTS

D S & A
Technology Design Consultants
14618 East 19th St
Indianapolis IN 46044-9530
763-344-152
D S & A ARCHITECTS

ARCHITECTS
ENGINEERS
PLANNERS

**VEAZEY
PARROTT
DURKIN
&
SHOULDERS**

RENOVATION PROJECT FOR:
**DUNELAND SCHOOL
CORPORATION**
CHESTERTON MIDDLE SCHOOL
CHESTERTON, INDIANA

Drawing Title:
**TECHNOLOGY SYSTEMS
FLOOR PLAN (UNIT A')**

Project No. 44-1024
Project Date: 6-14-2000
Drawn By: TDES
Approved By: LVD
Drawing No. 2000-TS-02
TS 1.1