


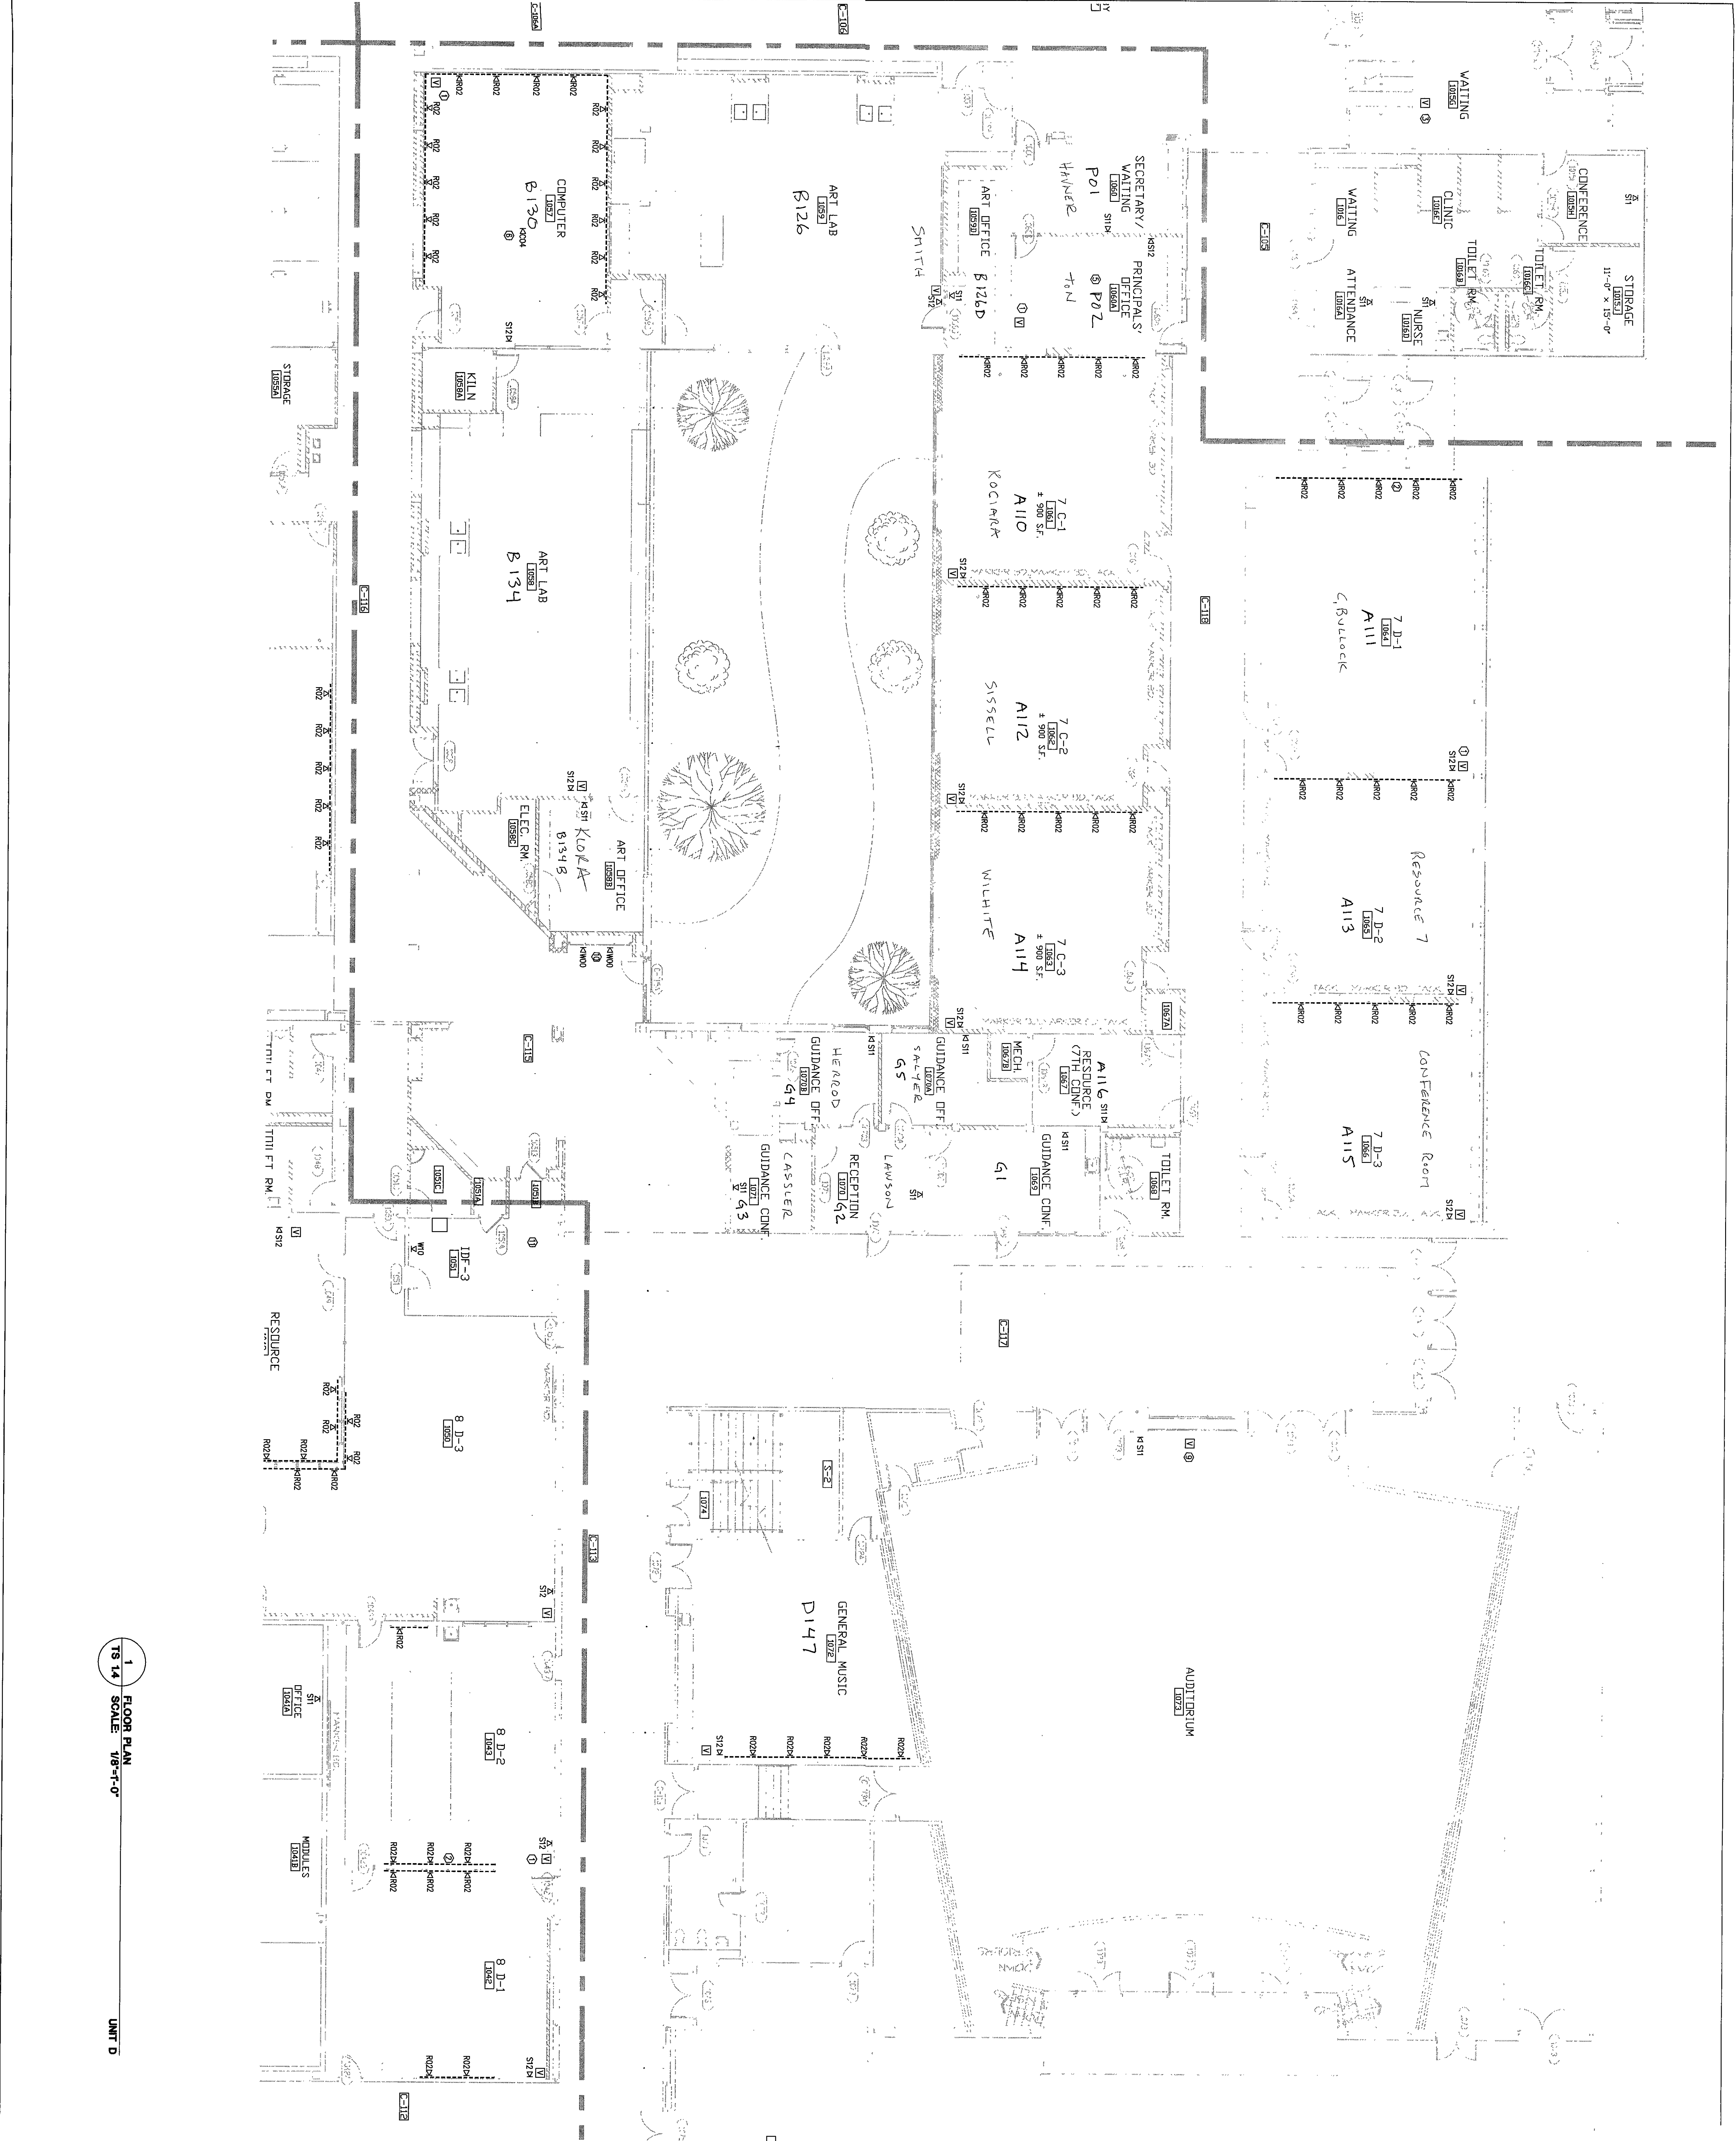

GENERAL NOTES:

- DUNELAND SCHOOL CORPORATION REQUEST FOR PROPOSAL FOR RENOVATION OF DUNELAND SCHOOL CORPORATION, 14410 East 196th Street, Indianapolis, IN 46040-9530.
- CABLE TRAY PROVIDED BY DIVISION. IS CONTRACTOR SHOWN IN DRAWINGS FOR REFERENCE ONLY.

REFERENCE NOTES:

- SEE 15-410, TYPICAL FOR ALL CLASSROOMS. PROVIDE (1) 2\"/>

KEY PLAN:

NORTH
SCALE: NTS

PROJECT INFORMATION:

**RENOVATION PROJECT FOR:
DUNELAND SCHOOL
CORPORATION
Chesterton Middle School
Chesterton, Indiana**

**ARCHITECTS
ENGINEERS
PLANNERS**

**VEAZEY
PARROTT
DURKIN &
SHOULDERS**

**3000 Parkway Way, S.W.
Buckeye, IN 46009**

**TECHNOLOGY SYSTEMS
FLOOR PLAN (UNIT D)**

Drawing Title:

Project No: 99-1024

Project Date: 6-14-2000

Drawn By: TDES

Approved By: LYD

Drawing No: TS 1.4

2000-TS-05