


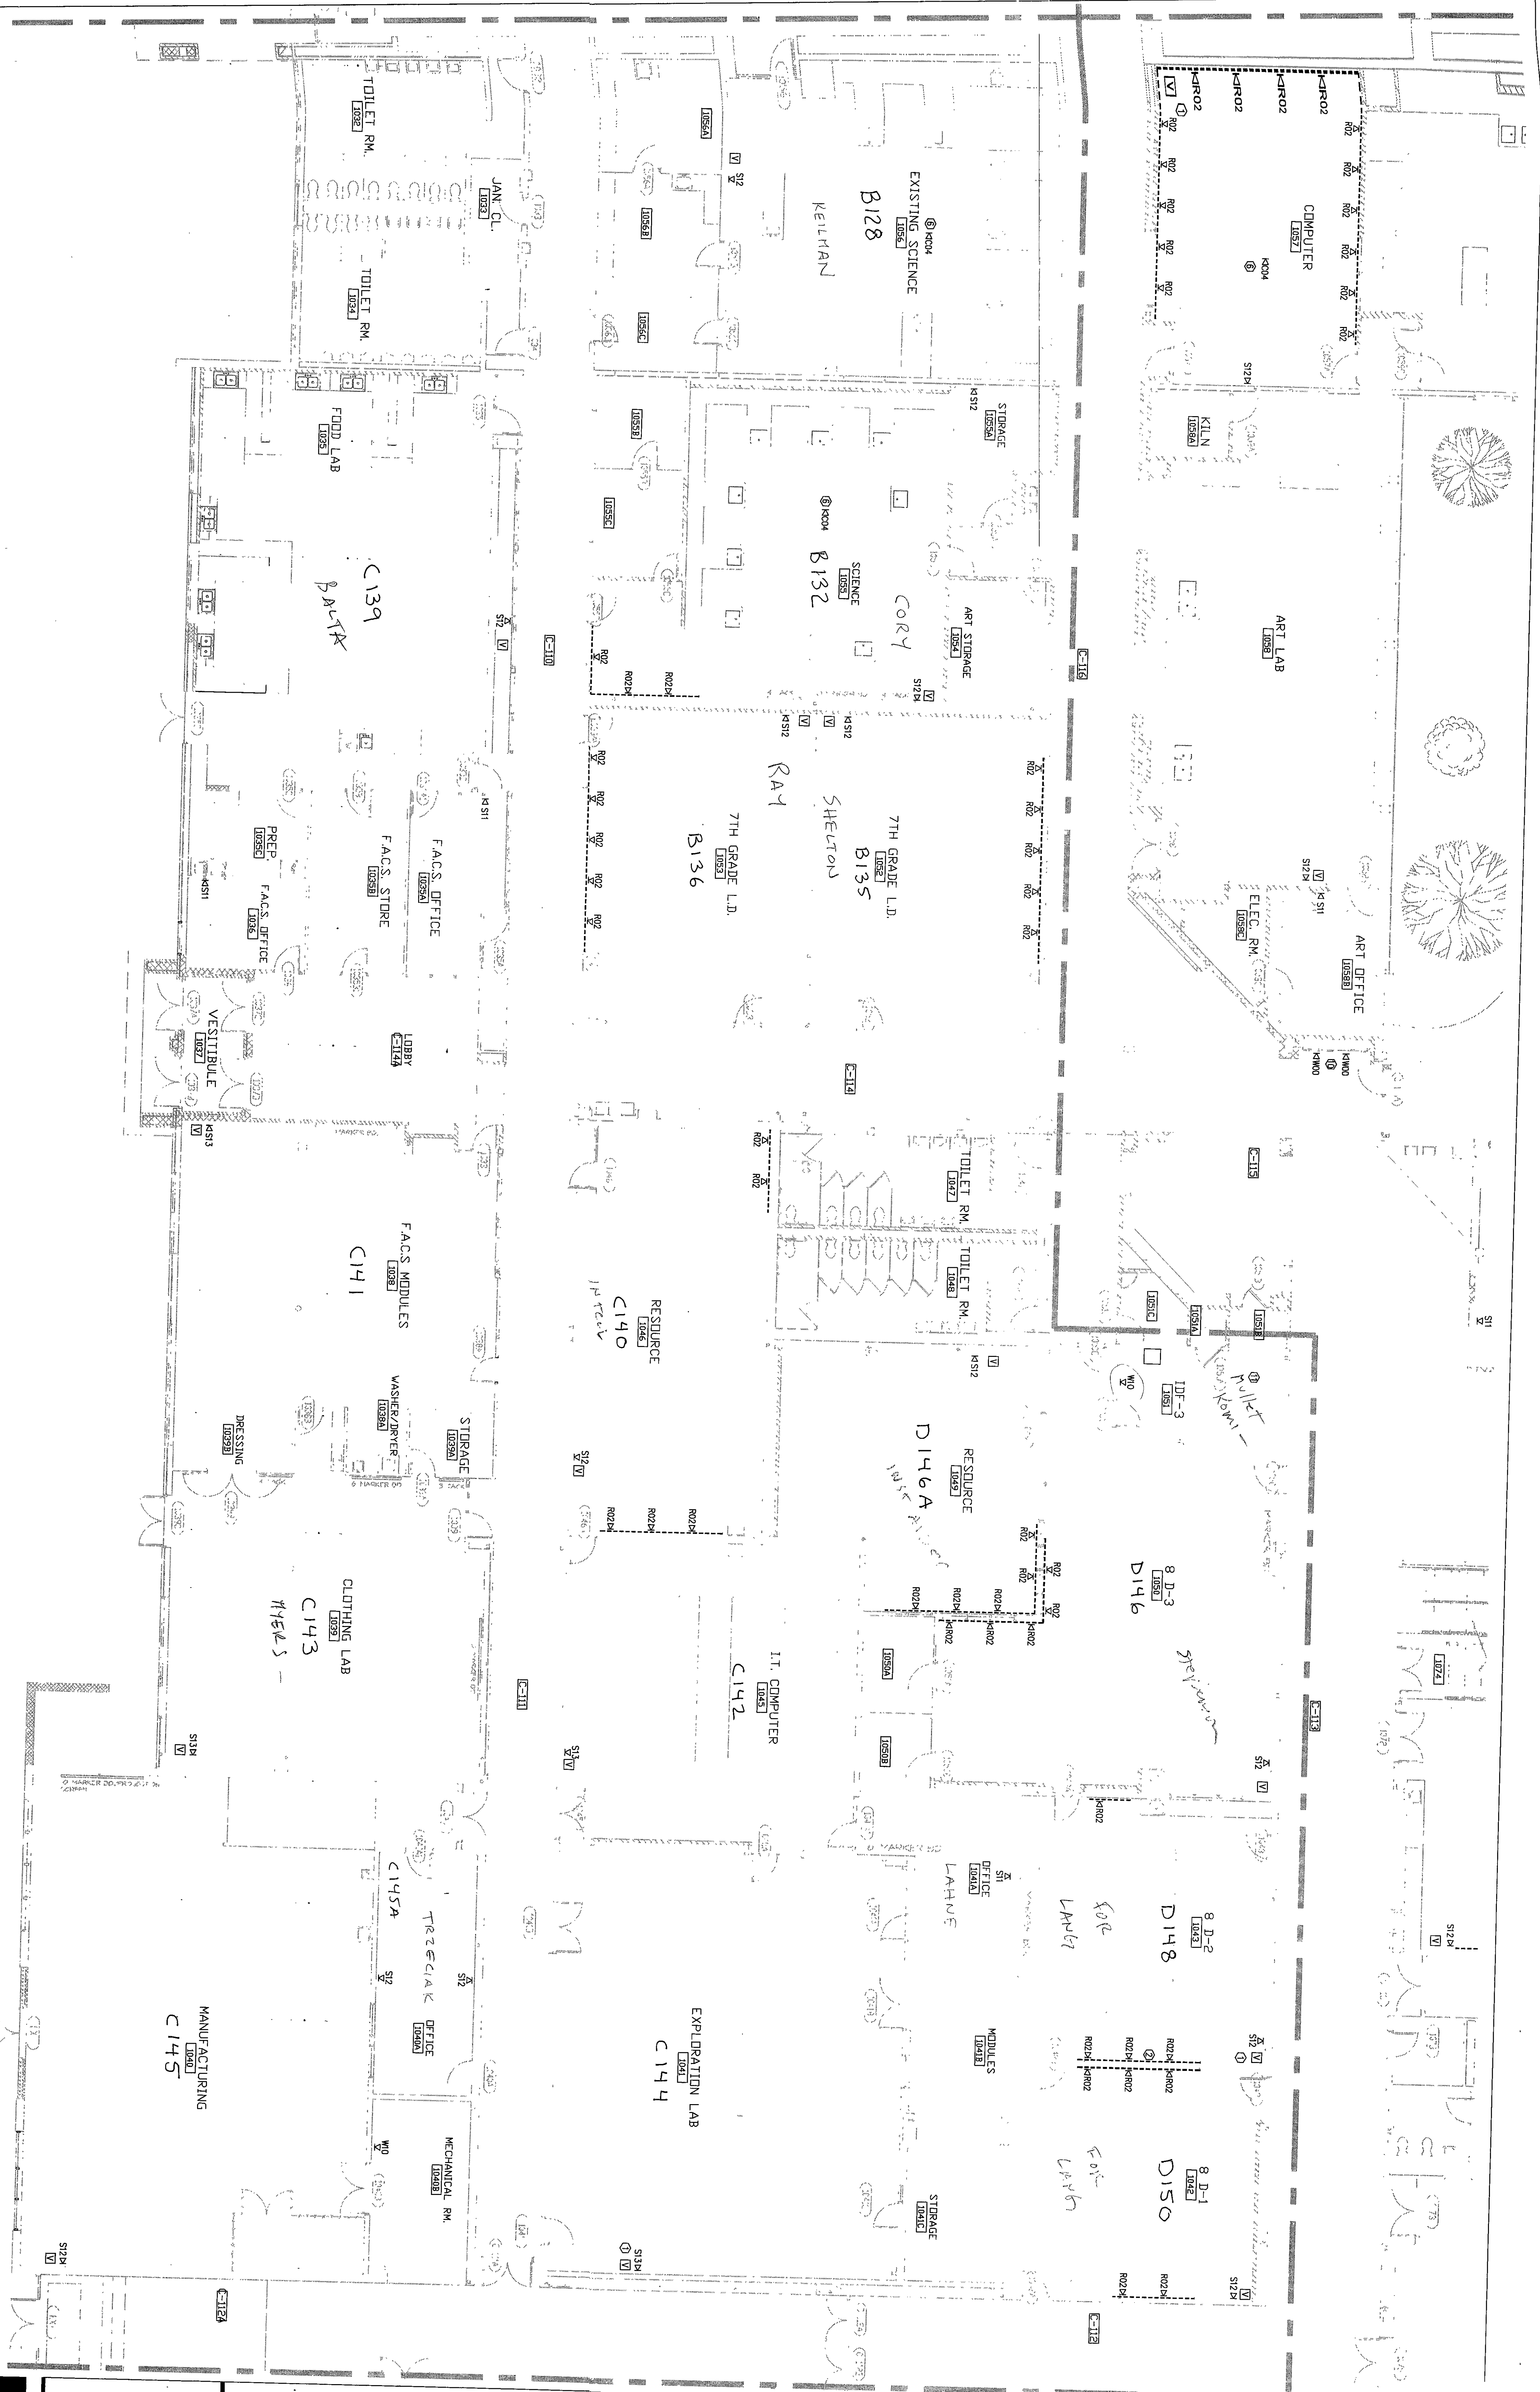


1 FLOOR PLAN SCALE: 1/8"=1'-0" UNIT: E

- GENERAL NOTES:
1. DUNELAND IS CONTRACTOR RESPONSIBLE FOR ALL CONCRETE WORK, DUAL-COMPONENT RACKS, SPOON IN DRAWINGS FOR REFERENCE ONLY.
 2. DUNELAND IS CONTRACTOR RESPONSIBLE FOR ALL CONCRETE WORK, DUAL-COMPONENT RACKS, SPOON IN DRAWINGS FOR REFERENCE ONLY.

- REFERENCE NOTES:
1. SEE TS-15(1) TYPICAL FOR ALL CLASSROOMS, PROVIDE MAIN MOUNT BRACKET, MONITOR & (1) 5-WAY VCR IN MAIN MOUNT BRACKET, PROVIDE AS INDICATED.
 2. SEE TS-15(1) TYPICAL FOR ALL CLASSROOMS, PROVIDE MAIN MOUNT BRACKET, MONITOR & (1) 5-WAY VCR IN MAIN MOUNT BRACKET, PROVIDE AS INDICATED.
 3. SEE TS-15(1) TYPICAL FOR ALL CLASSROOMS, PROVIDE MAIN MOUNT BRACKET, MONITOR & (1) 5-WAY VCR IN MAIN MOUNT BRACKET, PROVIDE AS INDICATED.
 4. SEE TS-15(1) TYPICAL FOR ALL CLASSROOMS, PROVIDE MAIN MOUNT BRACKET, MONITOR & (1) 5-WAY VCR IN MAIN MOUNT BRACKET, PROVIDE AS INDICATED.
 5. SEE TS-15(1) TYPICAL FOR ALL CLASSROOMS, PROVIDE MAIN MOUNT BRACKET, MONITOR & (1) 5-WAY VCR IN MAIN MOUNT BRACKET, PROVIDE AS INDICATED.
 6. SEE TS-15(1) TYPICAL FOR ALL CLASSROOMS, PROVIDE MAIN MOUNT BRACKET, MONITOR & (1) 5-WAY VCR IN MAIN MOUNT BRACKET, PROVIDE AS INDICATED.
 7. SEE TS-15(1) TYPICAL FOR ALL CLASSROOMS, PROVIDE MAIN MOUNT BRACKET, MONITOR & (1) 5-WAY VCR IN MAIN MOUNT BRACKET, PROVIDE AS INDICATED.
 8. SEE TS-15(1) TYPICAL FOR ALL CLASSROOMS, PROVIDE MAIN MOUNT BRACKET, MONITOR & (1) 5-WAY VCR IN MAIN MOUNT BRACKET, PROVIDE AS INDICATED.
 9. SEE TS-15(1) TYPICAL FOR ALL CLASSROOMS, PROVIDE MAIN MOUNT BRACKET, MONITOR & (1) 5-WAY VCR IN MAIN MOUNT BRACKET, PROVIDE AS INDICATED.
 10. SEE TS-15(1) TYPICAL FOR ALL CLASSROOMS, PROVIDE MAIN MOUNT BRACKET, MONITOR & (1) 5-WAY VCR IN MAIN MOUNT BRACKET, PROVIDE AS INDICATED.
 11. SEE TS-15(1) TYPICAL FOR ALL CLASSROOMS, PROVIDE MAIN MOUNT BRACKET, MONITOR & (1) 5-WAY VCR IN MAIN MOUNT BRACKET, PROVIDE AS INDICATED.
 12. SEE TS-15(1) TYPICAL FOR ALL CLASSROOMS, PROVIDE MAIN MOUNT BRACKET, MONITOR & (1) 5-WAY VCR IN MAIN MOUNT BRACKET, PROVIDE AS INDICATED.
 13. SEE TS-15(1) TYPICAL FOR ALL CLASSROOMS, PROVIDE MAIN MOUNT BRACKET, MONITOR & (1) 5-WAY VCR IN MAIN MOUNT BRACKET, PROVIDE AS INDICATED.
 14. SEE TS-15(1) TYPICAL FOR ALL CLASSROOMS, PROVIDE MAIN MOUNT BRACKET, MONITOR & (1) 5-WAY VCR IN MAIN MOUNT BRACKET, PROVIDE AS INDICATED.
 15. SEE TS-15(1) TYPICAL FOR ALL CLASSROOMS, PROVIDE MAIN MOUNT BRACKET, MONITOR & (1) 5-WAY VCR IN MAIN MOUNT BRACKET, PROVIDE AS INDICATED.
 16. SEE TS-15(1) TYPICAL FOR ALL CLASSROOMS, PROVIDE MAIN MOUNT BRACKET, MONITOR & (1) 5-WAY VCR IN MAIN MOUNT BRACKET, PROVIDE AS INDICATED.
 17. SEE TS-15(1) TYPICAL FOR ALL CLASSROOMS, PROVIDE MAIN MOUNT BRACKET, MONITOR & (1) 5-WAY VCR IN MAIN MOUNT BRACKET, PROVIDE AS INDICATED.
 18. SEE TS-15(1) TYPICAL FOR ALL CLASSROOMS, PROVIDE MAIN MOUNT BRACKET, MONITOR & (1) 5-WAY VCR IN MAIN MOUNT BRACKET, PROVIDE AS INDICATED.
 19. SEE TS-15(1) TYPICAL FOR ALL CLASSROOMS, PROVIDE MAIN MOUNT BRACKET, MONITOR & (1) 5-WAY VCR IN MAIN MOUNT BRACKET, PROVIDE AS INDICATED.
 20. SEE TS-15(1) TYPICAL FOR ALL CLASSROOMS, PROVIDE MAIN MOUNT BRACKET, MONITOR & (1) 5-WAY VCR IN MAIN MOUNT BRACKET, PROVIDE AS INDICATED.
 21. SEE TS-15(1) TYPICAL FOR ALL CLASSROOMS, PROVIDE MAIN MOUNT BRACKET, MONITOR & (1) 5-WAY VCR IN MAIN MOUNT BRACKET, PROVIDE AS INDICATED.
 22. SEE TS-15(1) TYPICAL FOR ALL CLASSROOMS, PROVIDE MAIN MOUNT BRACKET, MONITOR & (1) 5-WAY VCR IN MAIN MOUNT BRACKET, PROVIDE AS INDICATED.

KEY PLAN

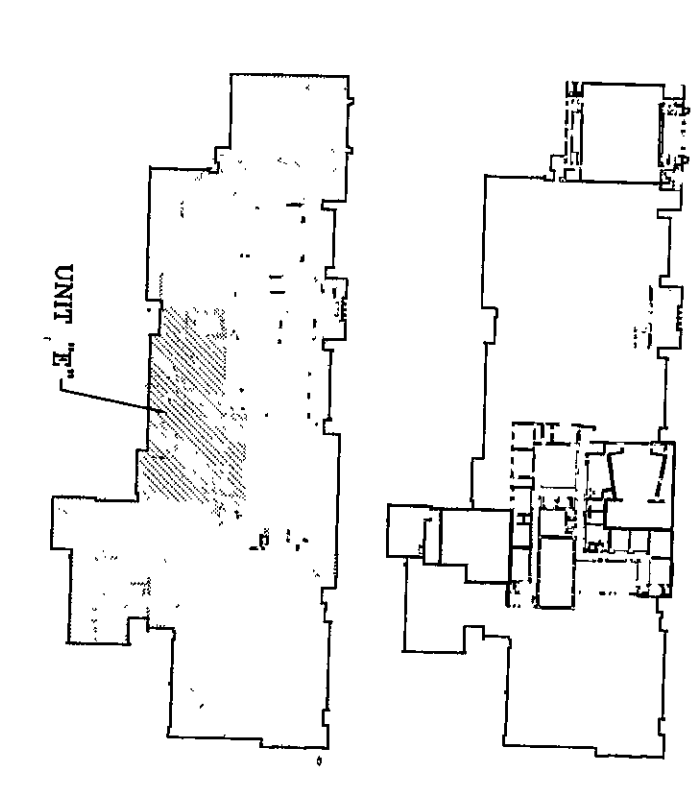

NORTH SCALE: NTS

DS&A
Technology Design Consultants
1610 East 196th Street
Mishawaka, IN 46545-0530
765/536-5552
DS&A ARCHITECTS

**VEAZEY
PARROTT
&
SHOULDERS**
ARCHITECTS
ENGINEERS
PLANNERS
1610 East 196th Street
Mishawaka, IN 46545-0530
765/536-5552

RENOVATION PROJECT FOR:
**DUNELAND SCHOOL
CORPORATION**
CHESTERTON MIDDLE SCHOOL
CHESTERTON, INDIANA

Drawing Title:
**TECHNOLOGY SYSTEMS
FLOOR PLAN (UNIT 15)**

Project No.: 99-10291
Project Date: 6-14-2000
Drawn By: TDES
Approved By: LWD
Drawing No.: TS 15