


- GENERAL NOTES:
1. ALL CONDUIT, BOXES, DUK-COMPARTMENT RACKS, CABLE TRAY PROVIDED BY DIVISION 16 CONTRACTOR. SHOWN IN DRAWINGS FOR REFERENCE ONLY.

REFERENCES NOTES

1. SEE TS-502.1, TYPICAL FOR ALL CLASSROOMS. PROVIDE (1) 7" MULTI-MEDIA MONITOR & (1) 5-WAY VCR IN MOUNTING DEVICES (PLATE/FRAMES) IN RACKS PROVIDED BY DIVISION 16 CONTRACTOR. TYPICAL AS INDICATED.
2. SEE TS-502.1, PROVIDE 30" MONITOR/BRACKET AND CABLE TRAY PROVIDED BY DIVISION 16 CONTRACTOR.
3. SEE TS-510.1 FOR ADDITIONAL INFORMATION.
4. PROVIDE EQUIPMENT NUMBER OF CAT 6 CABLES AND COAX TO PROVIDE SAME SERVICE AS PROPOSED. PROVIDE 30" CABLE IN CUL IN CENTER OF SPACE. PROVIDE 30" CABLE IN CUL IN CENTER OF SPACE. PROVIDE 30" CABLE IN CUL IN CENTER OF SPACE.
5. PROVIDE 27" MONITOR/BRACKET ONLY. NO VCR. PROVIDE 27" MONITOR/BRACKET ONLY. NO VCR. PROVIDE 27" MONITOR/BRACKET ONLY. NO VCR.
6. PROVIDE ONE (1) 7" CONNECTOR IN PLATE FOR LOCAL INPUT ONLY. NO MONITOR. NO VCR. MOUNT AT 18" AFF. PROVIDE 27" MONITOR/BRACKET ONLY. NO VCR.
7. PROVIDE 30" MULTI-MEDIA MONITOR/BRACKET. NO VCR. PROVIDE 30" MULTI-MEDIA MONITOR/BRACKET. NO VCR.
8. PROVIDE 30" MULTI-MEDIA MONITOR/BRACKET. NO VCR. PROVIDE 30" MULTI-MEDIA MONITOR/BRACKET. NO VCR.
9. PROVIDE 30" MULTI-MEDIA MONITOR/BRACKET. NO VCR. PROVIDE 30" MULTI-MEDIA MONITOR/BRACKET. NO VCR.
10. PROVIDE 30" MULTI-MEDIA MONITOR/BRACKET. NO VCR. PROVIDE 30" MULTI-MEDIA MONITOR/BRACKET. NO VCR.
11. PROVIDE 30" MULTI-MEDIA MONITOR/BRACKET. NO VCR. PROVIDE 30" MULTI-MEDIA MONITOR/BRACKET. NO VCR.
12. PROVIDE 30" MULTI-MEDIA MONITOR/BRACKET. NO VCR. PROVIDE 30" MULTI-MEDIA MONITOR/BRACKET. NO VCR.
13. PROVIDE 30" MULTI-MEDIA MONITOR/BRACKET. NO VCR. PROVIDE 30" MULTI-MEDIA MONITOR/BRACKET. NO VCR.
14. PROVIDE 30" MULTI-MEDIA MONITOR/BRACKET. NO VCR. PROVIDE 30" MULTI-MEDIA MONITOR/BRACKET. NO VCR.
15. PROVIDE 30" MULTI-MEDIA MONITOR/BRACKET. NO VCR. PROVIDE 30" MULTI-MEDIA MONITOR/BRACKET. NO VCR.
16. PROVIDE 30" MULTI-MEDIA MONITOR/BRACKET. NO VCR. PROVIDE 30" MULTI-MEDIA MONITOR/BRACKET. NO VCR.
17. PROVIDE 30" MULTI-MEDIA MONITOR/BRACKET. NO VCR. PROVIDE 30" MULTI-MEDIA MONITOR/BRACKET. NO VCR.
18. PROVIDE 30" MULTI-MEDIA MONITOR/BRACKET. NO VCR. PROVIDE 30" MULTI-MEDIA MONITOR/BRACKET. NO VCR.
19. PROVIDE 30" MULTI-MEDIA MONITOR/BRACKET. NO VCR. PROVIDE 30" MULTI-MEDIA MONITOR/BRACKET. NO VCR.
20. PROVIDE 30" MULTI-MEDIA MONITOR/BRACKET. NO VCR. PROVIDE 30" MULTI-MEDIA MONITOR/BRACKET. NO VCR.
21. PROVIDE 30" MULTI-MEDIA MONITOR/BRACKET. NO VCR. PROVIDE 30" MULTI-MEDIA MONITOR/BRACKET. NO VCR.

KEY PLAN

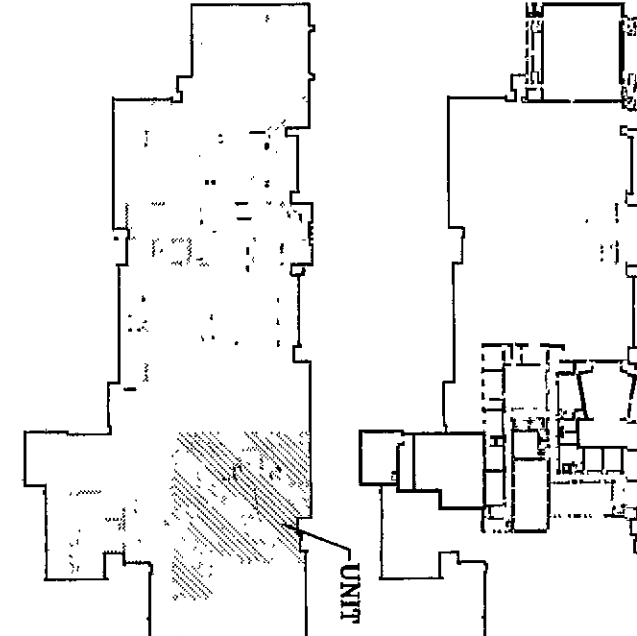

NORTH
SCALE: NTS

D S & A
Technology Design Consultants
14418 East 196th Street
Mukwonago, IL 60060-9500
765.934.5122
D S & A ARCHITECTS

ARCHITECTS
ENGINEERS
PLANNERS

**VEAZEY
PARROTT
DURKIN &
SHOULDERS**

RENOVATION PROJECT FOR:
**DUNELAND SCHOOL
CORPORATION**
OCESTION MIDDLE SCHOOL
OCESTION, INDIANA

Drawing Title:
**TECHNOLOGY SYSTEMS
FLOOR PLAN (UNIT 7)**

Project No.: 99-1024
Project Date: 6-14-2000
Drawn By: TDES
Approved By: LWD
Drawing No.: 2000-TS-01
TS 1.6