


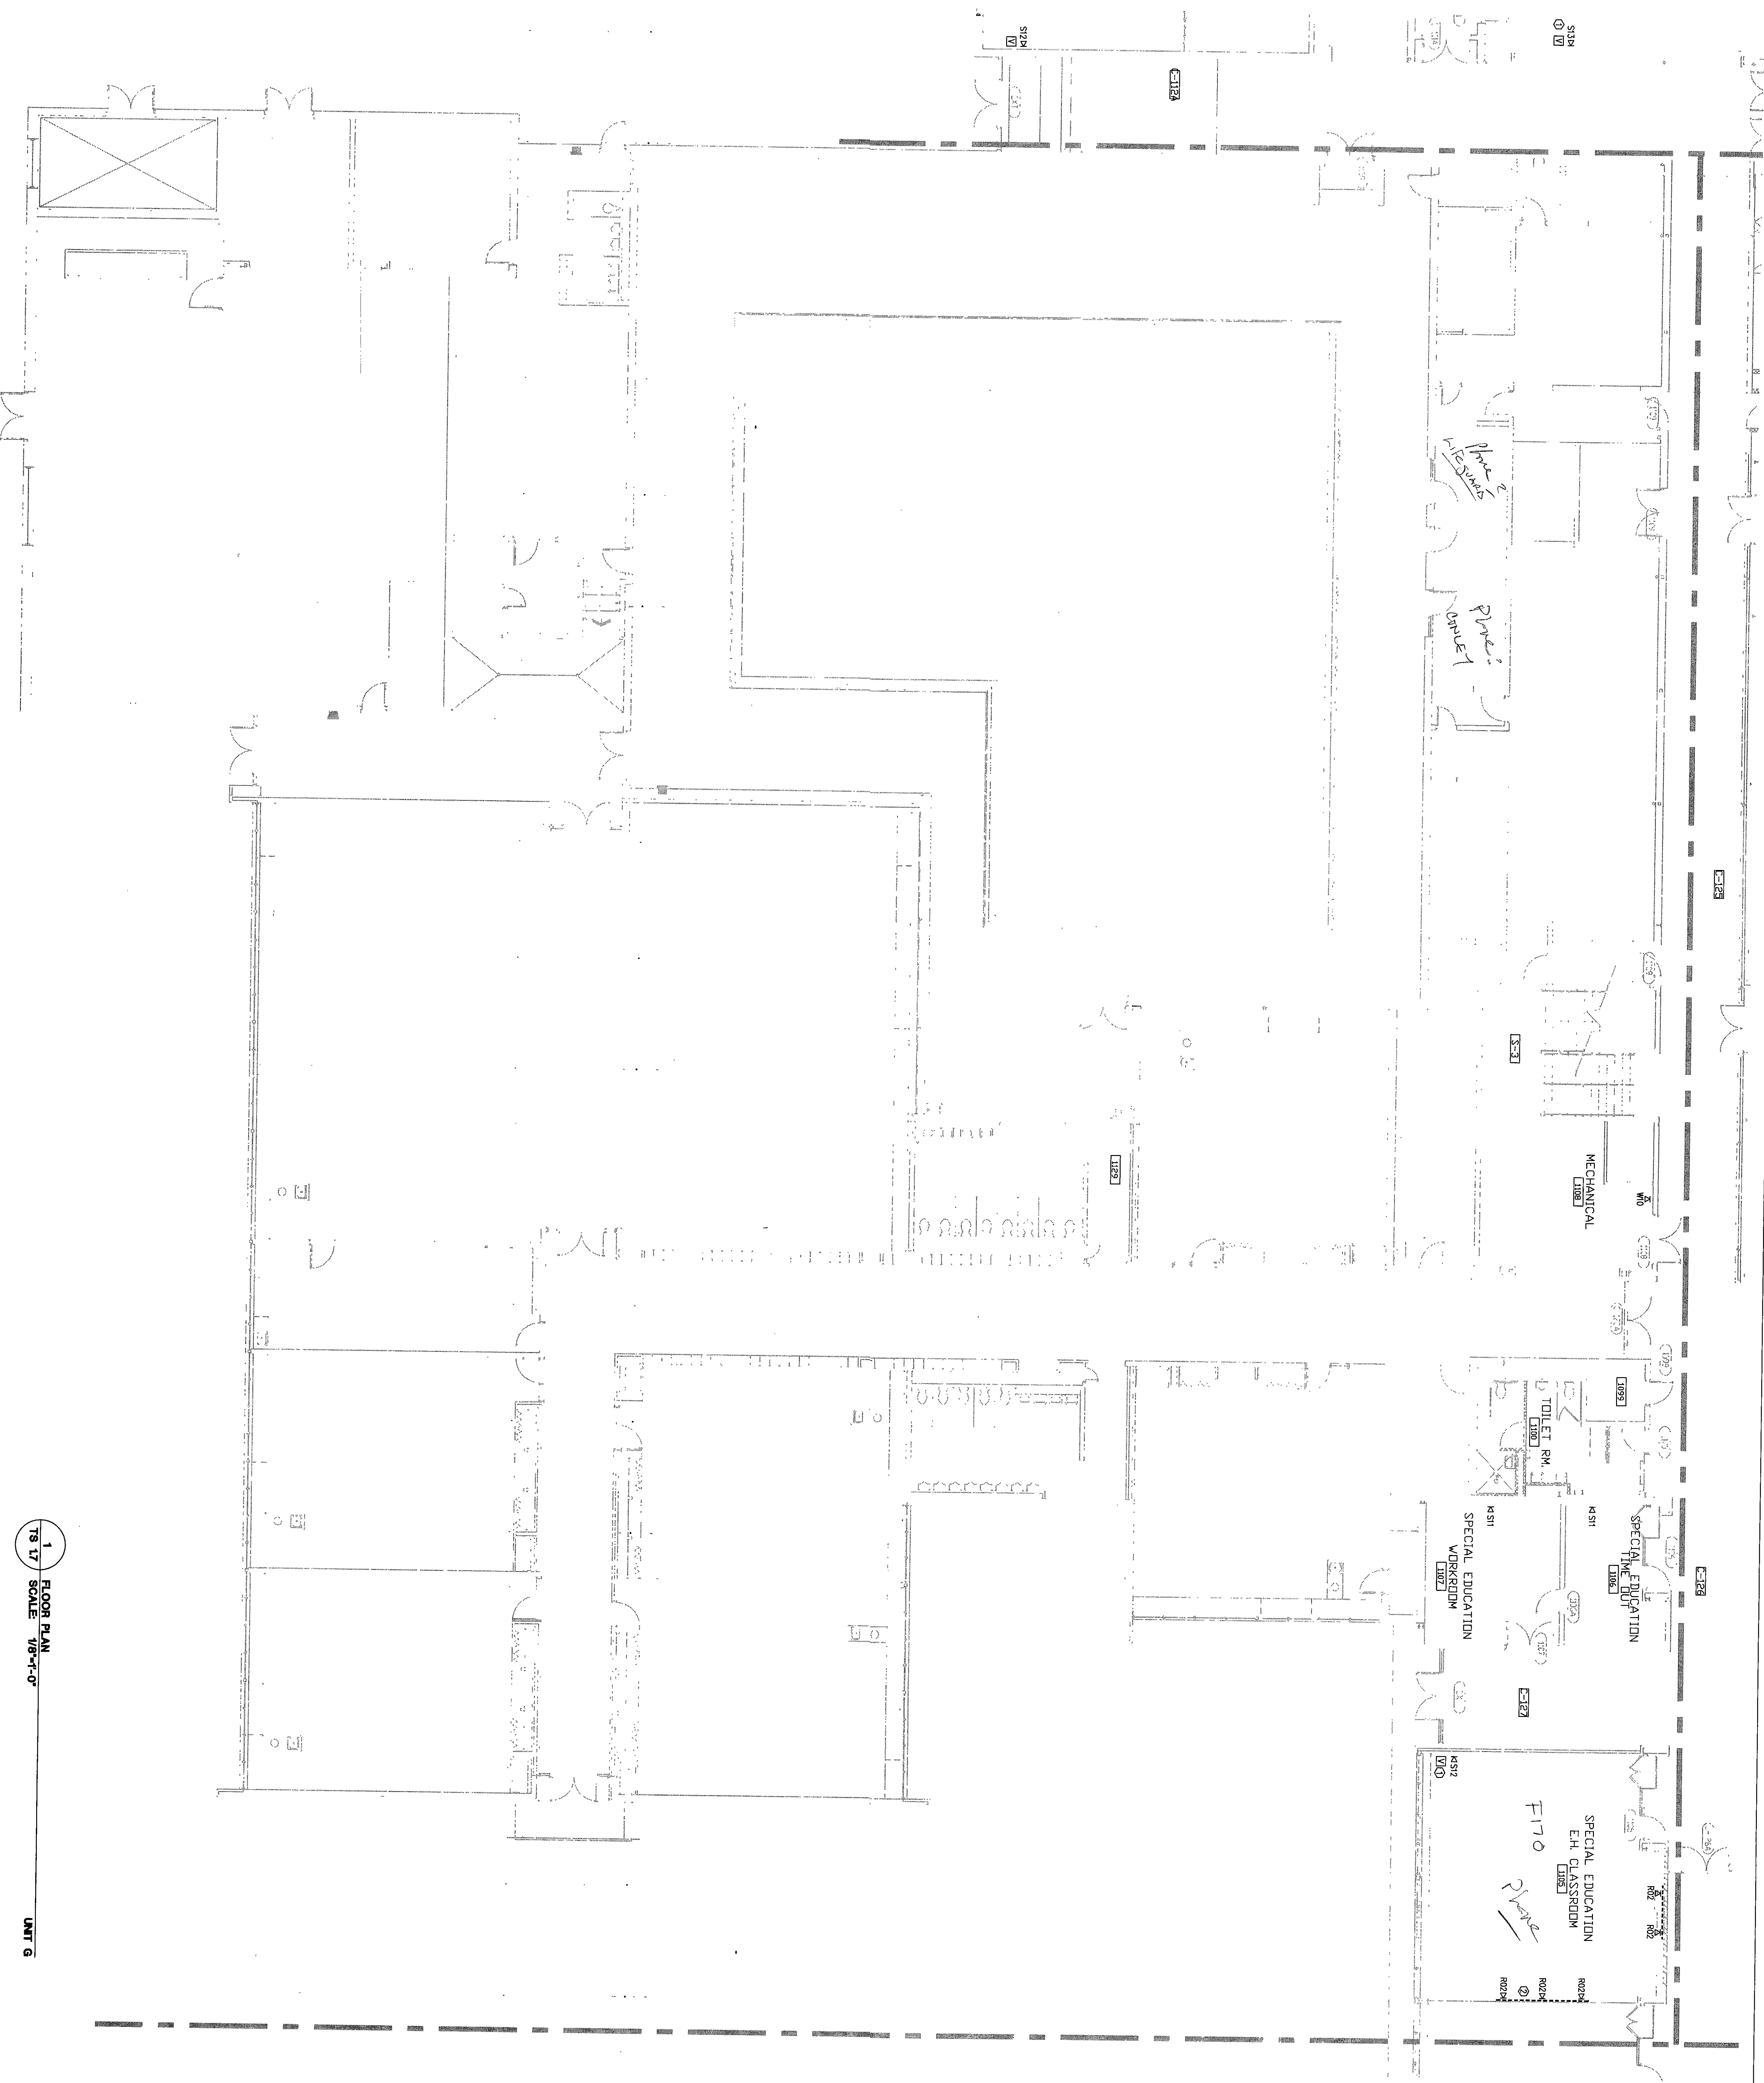


GENERAL NOTES:

1. DIVISION 16 CONTRACTOR RESPONSIBLE FOR CABLE TRAY, BUNDLES, CONDUIT, AND RACKS.
2. CABLE TRAY, BUNDLES, CONDUIT, AND RACKS SHOWN IN DRAWINGS FOR REFERENCE ONLY.

REFERENCED NOTES:

1. SEE TS-5-501 (1) FOR ALL DISCREPANCIES, PROVIDE (1) 27" MULTI-MEDIA MONITOR & (1) 5-MIN VCR IN WALL MOUNT BRACKET.
2. PROVIDE (1) 27" MULTI-MEDIA MONITOR & (1) 5-MIN VCR IN WALL MOUNT BRACKET. PROVIDE (1) 27" MULTI-MEDIA MONITOR & (1) 5-MIN VCR IN WALL MOUNT BRACKET.
3. SEE TS-5-503 (1) PROVIDE (1) 27" MULTI-MEDIA MONITOR & (1) 5-MIN VCR IN WALL MOUNT BRACKET. PROVIDE (1) 27" MULTI-MEDIA MONITOR & (1) 5-MIN VCR IN WALL MOUNT BRACKET.
4. SEE TS-5-510 (1) PROVIDE (1) 27" MULTI-MEDIA MONITOR & (1) 5-MIN VCR IN WALL MOUNT BRACKET. PROVIDE (1) 27" MULTI-MEDIA MONITOR & (1) 5-MIN VCR IN WALL MOUNT BRACKET.
5. PROVIDE (1) 27" MULTI-MEDIA MONITOR & (1) 5-MIN VCR IN WALL MOUNT BRACKET. PROVIDE (1) 27" MULTI-MEDIA MONITOR & (1) 5-MIN VCR IN WALL MOUNT BRACKET.
6. PROVIDE (1) 27" MULTI-MEDIA MONITOR & (1) 5-MIN VCR IN WALL MOUNT BRACKET. PROVIDE (1) 27" MULTI-MEDIA MONITOR & (1) 5-MIN VCR IN WALL MOUNT BRACKET.
7. PROVIDE (1) 27" MULTI-MEDIA MONITOR & (1) 5-MIN VCR IN WALL MOUNT BRACKET. PROVIDE (1) 27" MULTI-MEDIA MONITOR & (1) 5-MIN VCR IN WALL MOUNT BRACKET.
8. PROVIDE (1) 27" MULTI-MEDIA MONITOR & (1) 5-MIN VCR IN WALL MOUNT BRACKET. PROVIDE (1) 27" MULTI-MEDIA MONITOR & (1) 5-MIN VCR IN WALL MOUNT BRACKET.
9. PROVIDE (1) 27" MULTI-MEDIA MONITOR & (1) 5-MIN VCR IN WALL MOUNT BRACKET. PROVIDE (1) 27" MULTI-MEDIA MONITOR & (1) 5-MIN VCR IN WALL MOUNT BRACKET.
10. PROVIDE (1) 27" MULTI-MEDIA MONITOR & (1) 5-MIN VCR IN WALL MOUNT BRACKET. PROVIDE (1) 27" MULTI-MEDIA MONITOR & (1) 5-MIN VCR IN WALL MOUNT BRACKET.
11. PROVIDE (1) 27" MULTI-MEDIA MONITOR & (1) 5-MIN VCR IN WALL MOUNT BRACKET. PROVIDE (1) 27" MULTI-MEDIA MONITOR & (1) 5-MIN VCR IN WALL MOUNT BRACKET.
12. PROVIDE (1) 27" MULTI-MEDIA MONITOR & (1) 5-MIN VCR IN WALL MOUNT BRACKET. PROVIDE (1) 27" MULTI-MEDIA MONITOR & (1) 5-MIN VCR IN WALL MOUNT BRACKET.
13. PROVIDE (1) 27" MULTI-MEDIA MONITOR & (1) 5-MIN VCR IN WALL MOUNT BRACKET. PROVIDE (1) 27" MULTI-MEDIA MONITOR & (1) 5-MIN VCR IN WALL MOUNT BRACKET.
14. PROVIDE (1) 27" MULTI-MEDIA MONITOR & (1) 5-MIN VCR IN WALL MOUNT BRACKET. PROVIDE (1) 27" MULTI-MEDIA MONITOR & (1) 5-MIN VCR IN WALL MOUNT BRACKET.
15. PROVIDE (1) 27" MULTI-MEDIA MONITOR & (1) 5-MIN VCR IN WALL MOUNT BRACKET. PROVIDE (1) 27" MULTI-MEDIA MONITOR & (1) 5-MIN VCR IN WALL MOUNT BRACKET.
16. PROVIDE (1) 27" MULTI-MEDIA MONITOR & (1) 5-MIN VCR IN WALL MOUNT BRACKET. PROVIDE (1) 27" MULTI-MEDIA MONITOR & (1) 5-MIN VCR IN WALL MOUNT BRACKET.
17. PROVIDE (1) 27" MULTI-MEDIA MONITOR & (1) 5-MIN VCR IN WALL MOUNT BRACKET. PROVIDE (1) 27" MULTI-MEDIA MONITOR & (1) 5-MIN VCR IN WALL MOUNT BRACKET.
18. PROVIDE (1) 27" MULTI-MEDIA MONITOR & (1) 5-MIN VCR IN WALL MOUNT BRACKET. PROVIDE (1) 27" MULTI-MEDIA MONITOR & (1) 5-MIN VCR IN WALL MOUNT BRACKET.
19. PROVIDE (1) 27" MULTI-MEDIA MONITOR & (1) 5-MIN VCR IN WALL MOUNT BRACKET. PROVIDE (1) 27" MULTI-MEDIA MONITOR & (1) 5-MIN VCR IN WALL MOUNT BRACKET.
20. PROVIDE (1) 27" MULTI-MEDIA MONITOR & (1) 5-MIN VCR IN WALL MOUNT BRACKET. PROVIDE (1) 27" MULTI-MEDIA MONITOR & (1) 5-MIN VCR IN WALL MOUNT BRACKET.
21. PROVIDE (1) 27" MULTI-MEDIA MONITOR & (1) 5-MIN VCR IN WALL MOUNT BRACKET. PROVIDE (1) 27" MULTI-MEDIA MONITOR & (1) 5-MIN VCR IN WALL MOUNT BRACKET.

KEY PLAN:

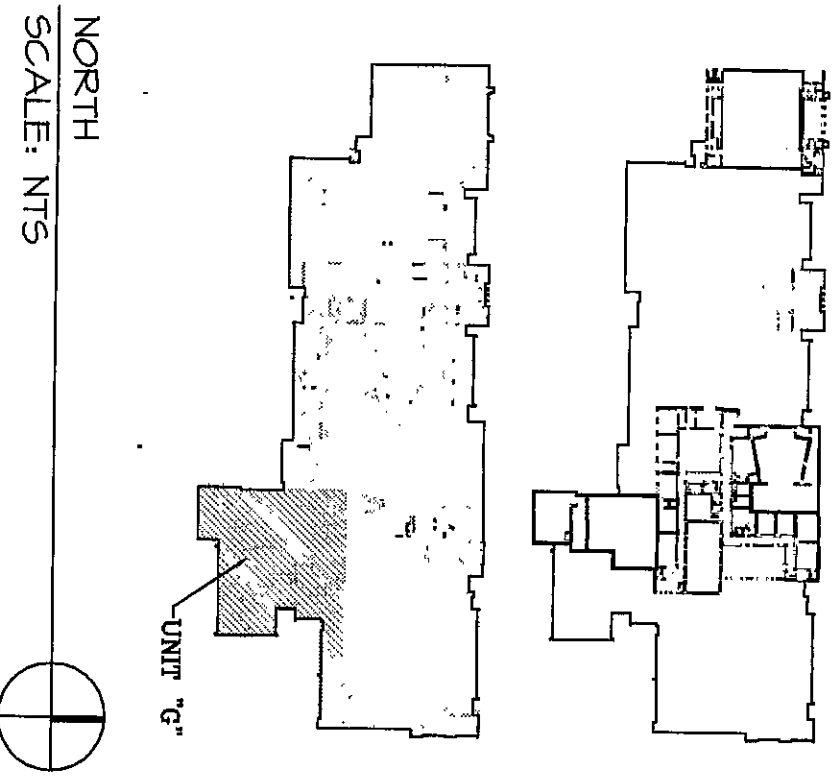

DS&A INC.
Technology Design Consultants
1640 East 196th Street
Indianapolis, IN 46040-9530
765-534-5152
D&A ARCHITECTS

ARCHITECTS
ENGINEERS
PLANNERS

**VEAZEY
PARROTT
DURKIN
&
SHOULDERS**

2800 Priority Way S.W.
Indianapolis, IN 46040

**RENOVATION PROJECT FOR:
DUNELAND SCHOOL
CORPORATION
CHESTERTON, INDIANA**

**TECHNOLOGY SYSTEMS
FLOOR PLAN (UNIT G)**

Project No. 99-1029
Project Date: 6-14-2000
Drawn By: TDES
Approved By: LMD
Drawing No. 2000-TS-05

1 FLOOR PLAN
SCALE 1/8"=1'-0"

UNIT G

2000-TS-05

TS 17