


- GENERAL NOTES:
1. SEE DIVISION 16 FOR ALL CLASSROOMS. PROVIDE (1) 27" MULTI-MEDIA MONITOR & (1) 5-WAY VHS IN MONITOR STANDS. DIVISION 16 CONTRACTOR.
 2. CABLE TRAY PROVIDED BY DIVISION 16 CONTRACTOR. SHOWN IN DRAWINGS FOR REFERENCE ONLY.

- REFERENCED NOTES:
1. SEE TS-5-102.1. TYPICAL FOR ALL CLASSROOMS. PROVIDE (1) 27" MULTI-MEDIA MONITOR & (1) 5-WAY VHS IN MONITOR STANDS. DIVISION 16 CONTRACTOR.
 2. MONITOR STANDS (PLATE/PARTS) IN RACKWAY PROVIDED BY DIVISION 16 CONTRACTOR. TYPICAL AS INDICATED.
 3. SEE TS-5-102.1. PROVIDE 36" MONITOR/BROCKET AND 36" CABLE IN CABLE IN CENTER OF SPACE.
 4. PROVIDE EQUIVALENT NUMBER OF CAT 6 CABLES AND COAX TO PROVIDE SAME SERVICE AS PRICED IN (S) PROVIDE 36" CABLE IN CABLE IN CENTER OF SPACE.
 5. PROVIDE 36" CABLE COILED NEATLY ABOVE CEILING FOR FUTURE USE. TERMINATE OTHER END AT 18" / 12" AND USE IN WALL.
 6. PROVIDE 27" MONITOR/BROCKET ONLY. NO VCR. PROVIDE ONE (1) 1" CONNECTOR IN PLATE FOR LOCAL INPUT ONLY. NO MONITOR. NO VCR. MOUNT AT 18" / 12" PAY TELEPHONE LOCATION.
 7. SEE TS-5-11 (4) FOR ADDITIONAL INFORMATION.
 8. PROVIDE 36" MONITOR/BROCKET ONLY. NO VCR. PROVIDE ONE (1) 1" CONNECTOR IN PLATE FOR LOCAL INPUT ONLY. NO MONITOR. NO VCR. MOUNT AT 18" / 12" PAY TELEPHONE LOCATION.
 9. PROVIDE 36" MONITOR/BROCKET ONLY. NO VCR. PROVIDE ONE (1) 1" CONNECTOR IN PLATE FOR LOCAL INPUT ONLY. NO MONITOR. NO VCR. MOUNT AT 18" / 12" PAY TELEPHONE LOCATION.
 10. PROVIDE 36" MONITOR/BROCKET ONLY. NO VCR. PROVIDE ONE (1) 1" CONNECTOR IN PLATE FOR LOCAL INPUT ONLY. NO MONITOR. NO VCR. MOUNT AT 18" / 12" PAY TELEPHONE LOCATION.
 11. PROVIDE 36" MONITOR/BROCKET ONLY. NO VCR. PROVIDE ONE (1) 1" CONNECTOR IN PLATE FOR LOCAL INPUT ONLY. NO MONITOR. NO VCR. MOUNT AT 18" / 12" PAY TELEPHONE LOCATION.
 12. PROVIDE 36" MONITOR/BROCKET ONLY. NO VCR. PROVIDE ONE (1) 1" CONNECTOR IN PLATE FOR LOCAL INPUT ONLY. NO MONITOR. NO VCR. MOUNT AT 18" / 12" PAY TELEPHONE LOCATION.
 13. PROVIDE 36" MONITOR/BROCKET ONLY. NO VCR. PROVIDE ONE (1) 1" CONNECTOR IN PLATE FOR LOCAL INPUT ONLY. NO MONITOR. NO VCR. MOUNT AT 18" / 12" PAY TELEPHONE LOCATION.
 14. PROVIDE 36" MONITOR/BROCKET ONLY. NO VCR. PROVIDE ONE (1) 1" CONNECTOR IN PLATE FOR LOCAL INPUT ONLY. NO MONITOR. NO VCR. MOUNT AT 18" / 12" PAY TELEPHONE LOCATION.
 15. PROVIDE 36" MONITOR/BROCKET ONLY. NO VCR. PROVIDE ONE (1) 1" CONNECTOR IN PLATE FOR LOCAL INPUT ONLY. NO MONITOR. NO VCR. MOUNT AT 18" / 12" PAY TELEPHONE LOCATION.
 16. PROVIDE 36" MONITOR/BROCKET ONLY. NO VCR. PROVIDE ONE (1) 1" CONNECTOR IN PLATE FOR LOCAL INPUT ONLY. NO MONITOR. NO VCR. MOUNT AT 18" / 12" PAY TELEPHONE LOCATION.
 17. PROVIDE 36" MONITOR/BROCKET ONLY. NO VCR. PROVIDE ONE (1) 1" CONNECTOR IN PLATE FOR LOCAL INPUT ONLY. NO MONITOR. NO VCR. MOUNT AT 18" / 12" PAY TELEPHONE LOCATION.
 18. PROVIDE 36" MONITOR/BROCKET ONLY. NO VCR. PROVIDE ONE (1) 1" CONNECTOR IN PLATE FOR LOCAL INPUT ONLY. NO MONITOR. NO VCR. MOUNT AT 18" / 12" PAY TELEPHONE LOCATION.
 19. PROVIDE 36" MONITOR/BROCKET ONLY. NO VCR. PROVIDE ONE (1) 1" CONNECTOR IN PLATE FOR LOCAL INPUT ONLY. NO MONITOR. NO VCR. MOUNT AT 18" / 12" PAY TELEPHONE LOCATION.
 20. PROVIDE 36" MONITOR/BROCKET ONLY. NO VCR. PROVIDE ONE (1) 1" CONNECTOR IN PLATE FOR LOCAL INPUT ONLY. NO MONITOR. NO VCR. MOUNT AT 18" / 12" PAY TELEPHONE LOCATION.
 21. PROVIDE 36" MONITOR/BROCKET ONLY. NO VCR. PROVIDE ONE (1) 1" CONNECTOR IN PLATE FOR LOCAL INPUT ONLY. NO MONITOR. NO VCR. MOUNT AT 18" / 12" PAY TELEPHONE LOCATION.
 22. PROVIDE 36" MONITOR/BROCKET ONLY. NO VCR. PROVIDE ONE (1) 1" CONNECTOR IN PLATE FOR LOCAL INPUT ONLY. NO MONITOR. NO VCR. MOUNT AT 18" / 12" PAY TELEPHONE LOCATION.

KEY PLAN:

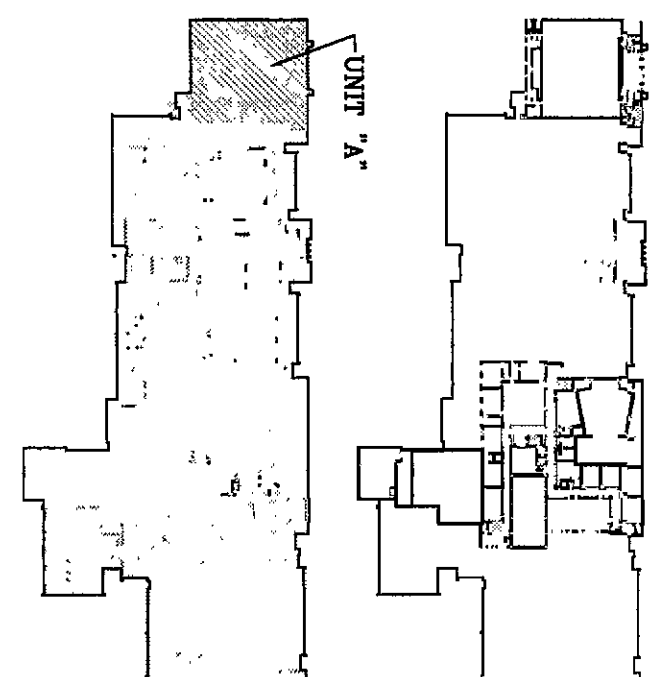

NORTH
SCALE: NTS

D S & A INC.
Technology Design Consultants
16416 East 196th Street
Mokena, IL 60449-1530
708.594-5152
D S & A ARCHITECTS

ARCHITECTS
ENGINEERS
PLANNERS

**VEAZEY
PARROTT
DURKIN
&
SHOULDERS**

RENOVATION PROJECT FOR:
**DUNELAND SCHOOL
CORPORATION**
CHESTERTON MIDDLE SCHOOL
CHESTERTON, INDIANA

Drawing Title:		TECHNOLOGY SYSTEMS REFLECTED CEILING PLAN (UNIT A*)	
Project No.:	94-1024	Project Date:	6-14-2000
Drawn By:	TDES	Approved By:	LMD
Drawing No.:	TS 3.1		