

1 DIVISION 16 CONTRACTOR RESPONSIBLE FOR ALL CONDUIT, BOXES, DUAL-COMPARTMENT RACEWAYS, CABLE TRAY PROVIDED BY DIVISION 16 CONTRACTOR. SHOWN IN DRAWINGS FOR REFERENCE ONLY.

[illegible]


ARCHITECTS
ENGINEERS
PLANNERS

3850 Priority Way S. E.

Project No: 44-1024

2000-TS-13

Drawn By:	TDES
Approved By:	LMD
Drawing No:	TS 3.3

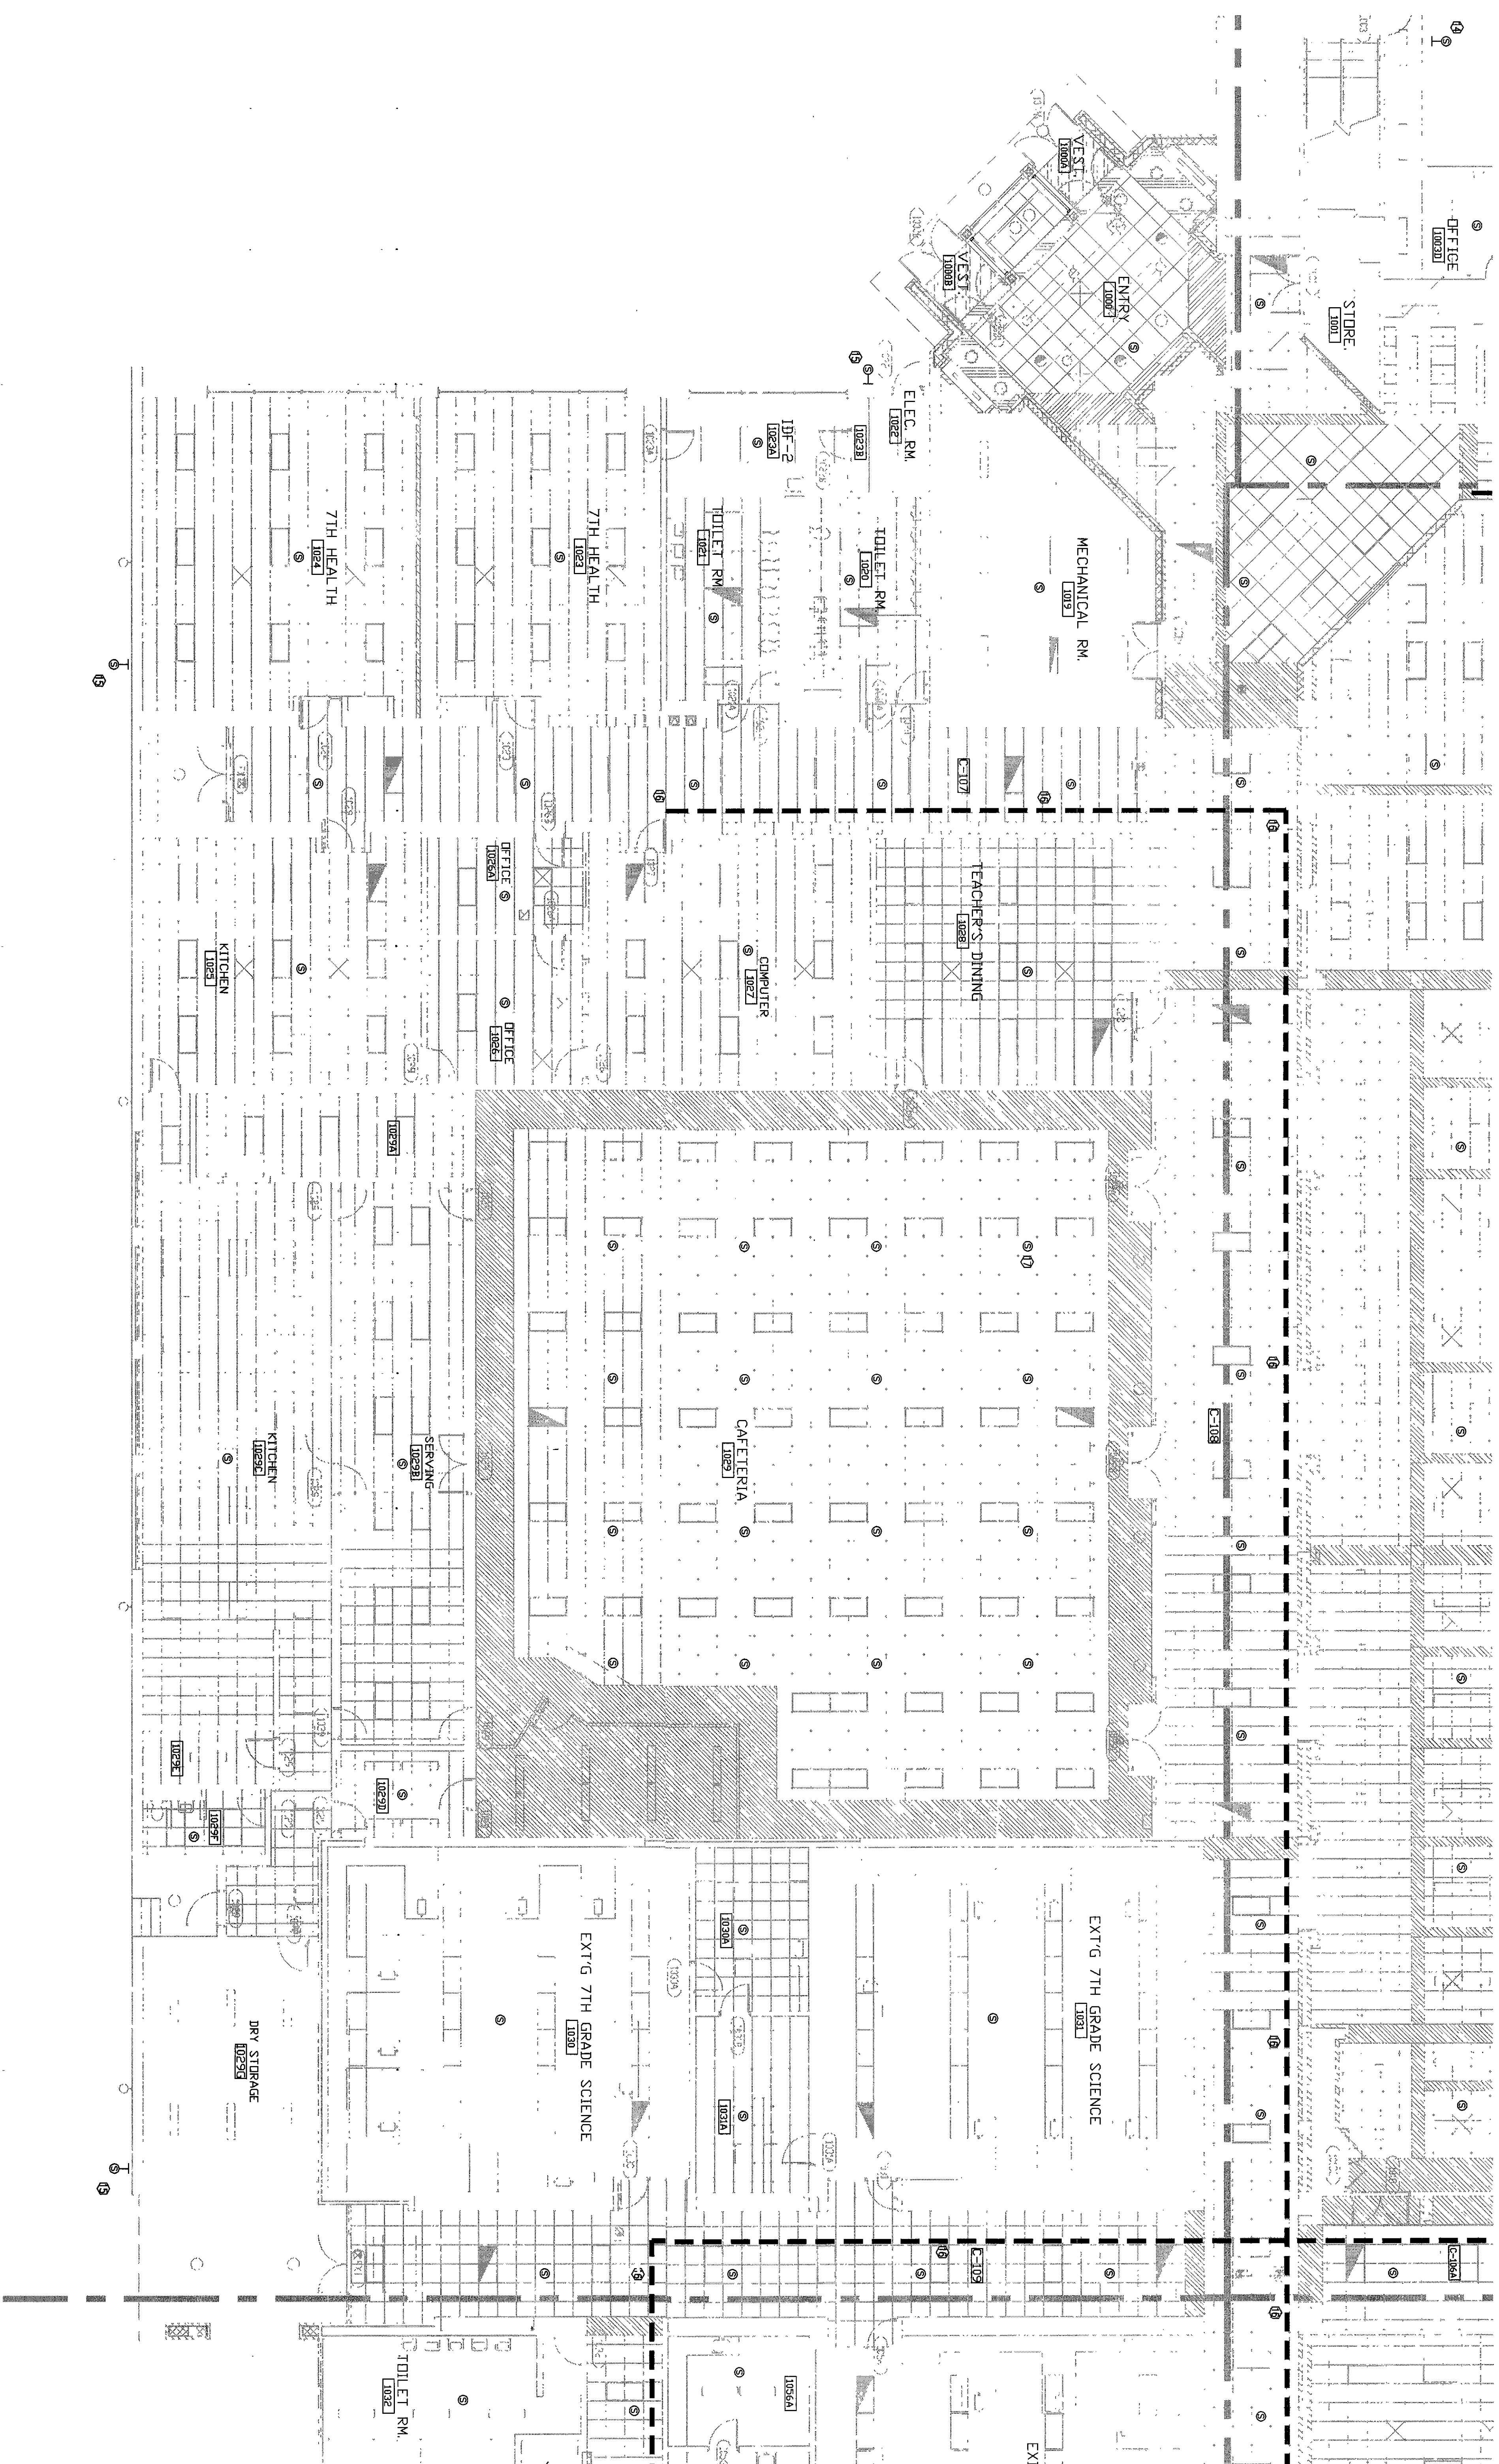

1 REFLECTED CEILING PLAN
TS 3.3 SCALE: 1/8"=1'-0"

UNIT 1