


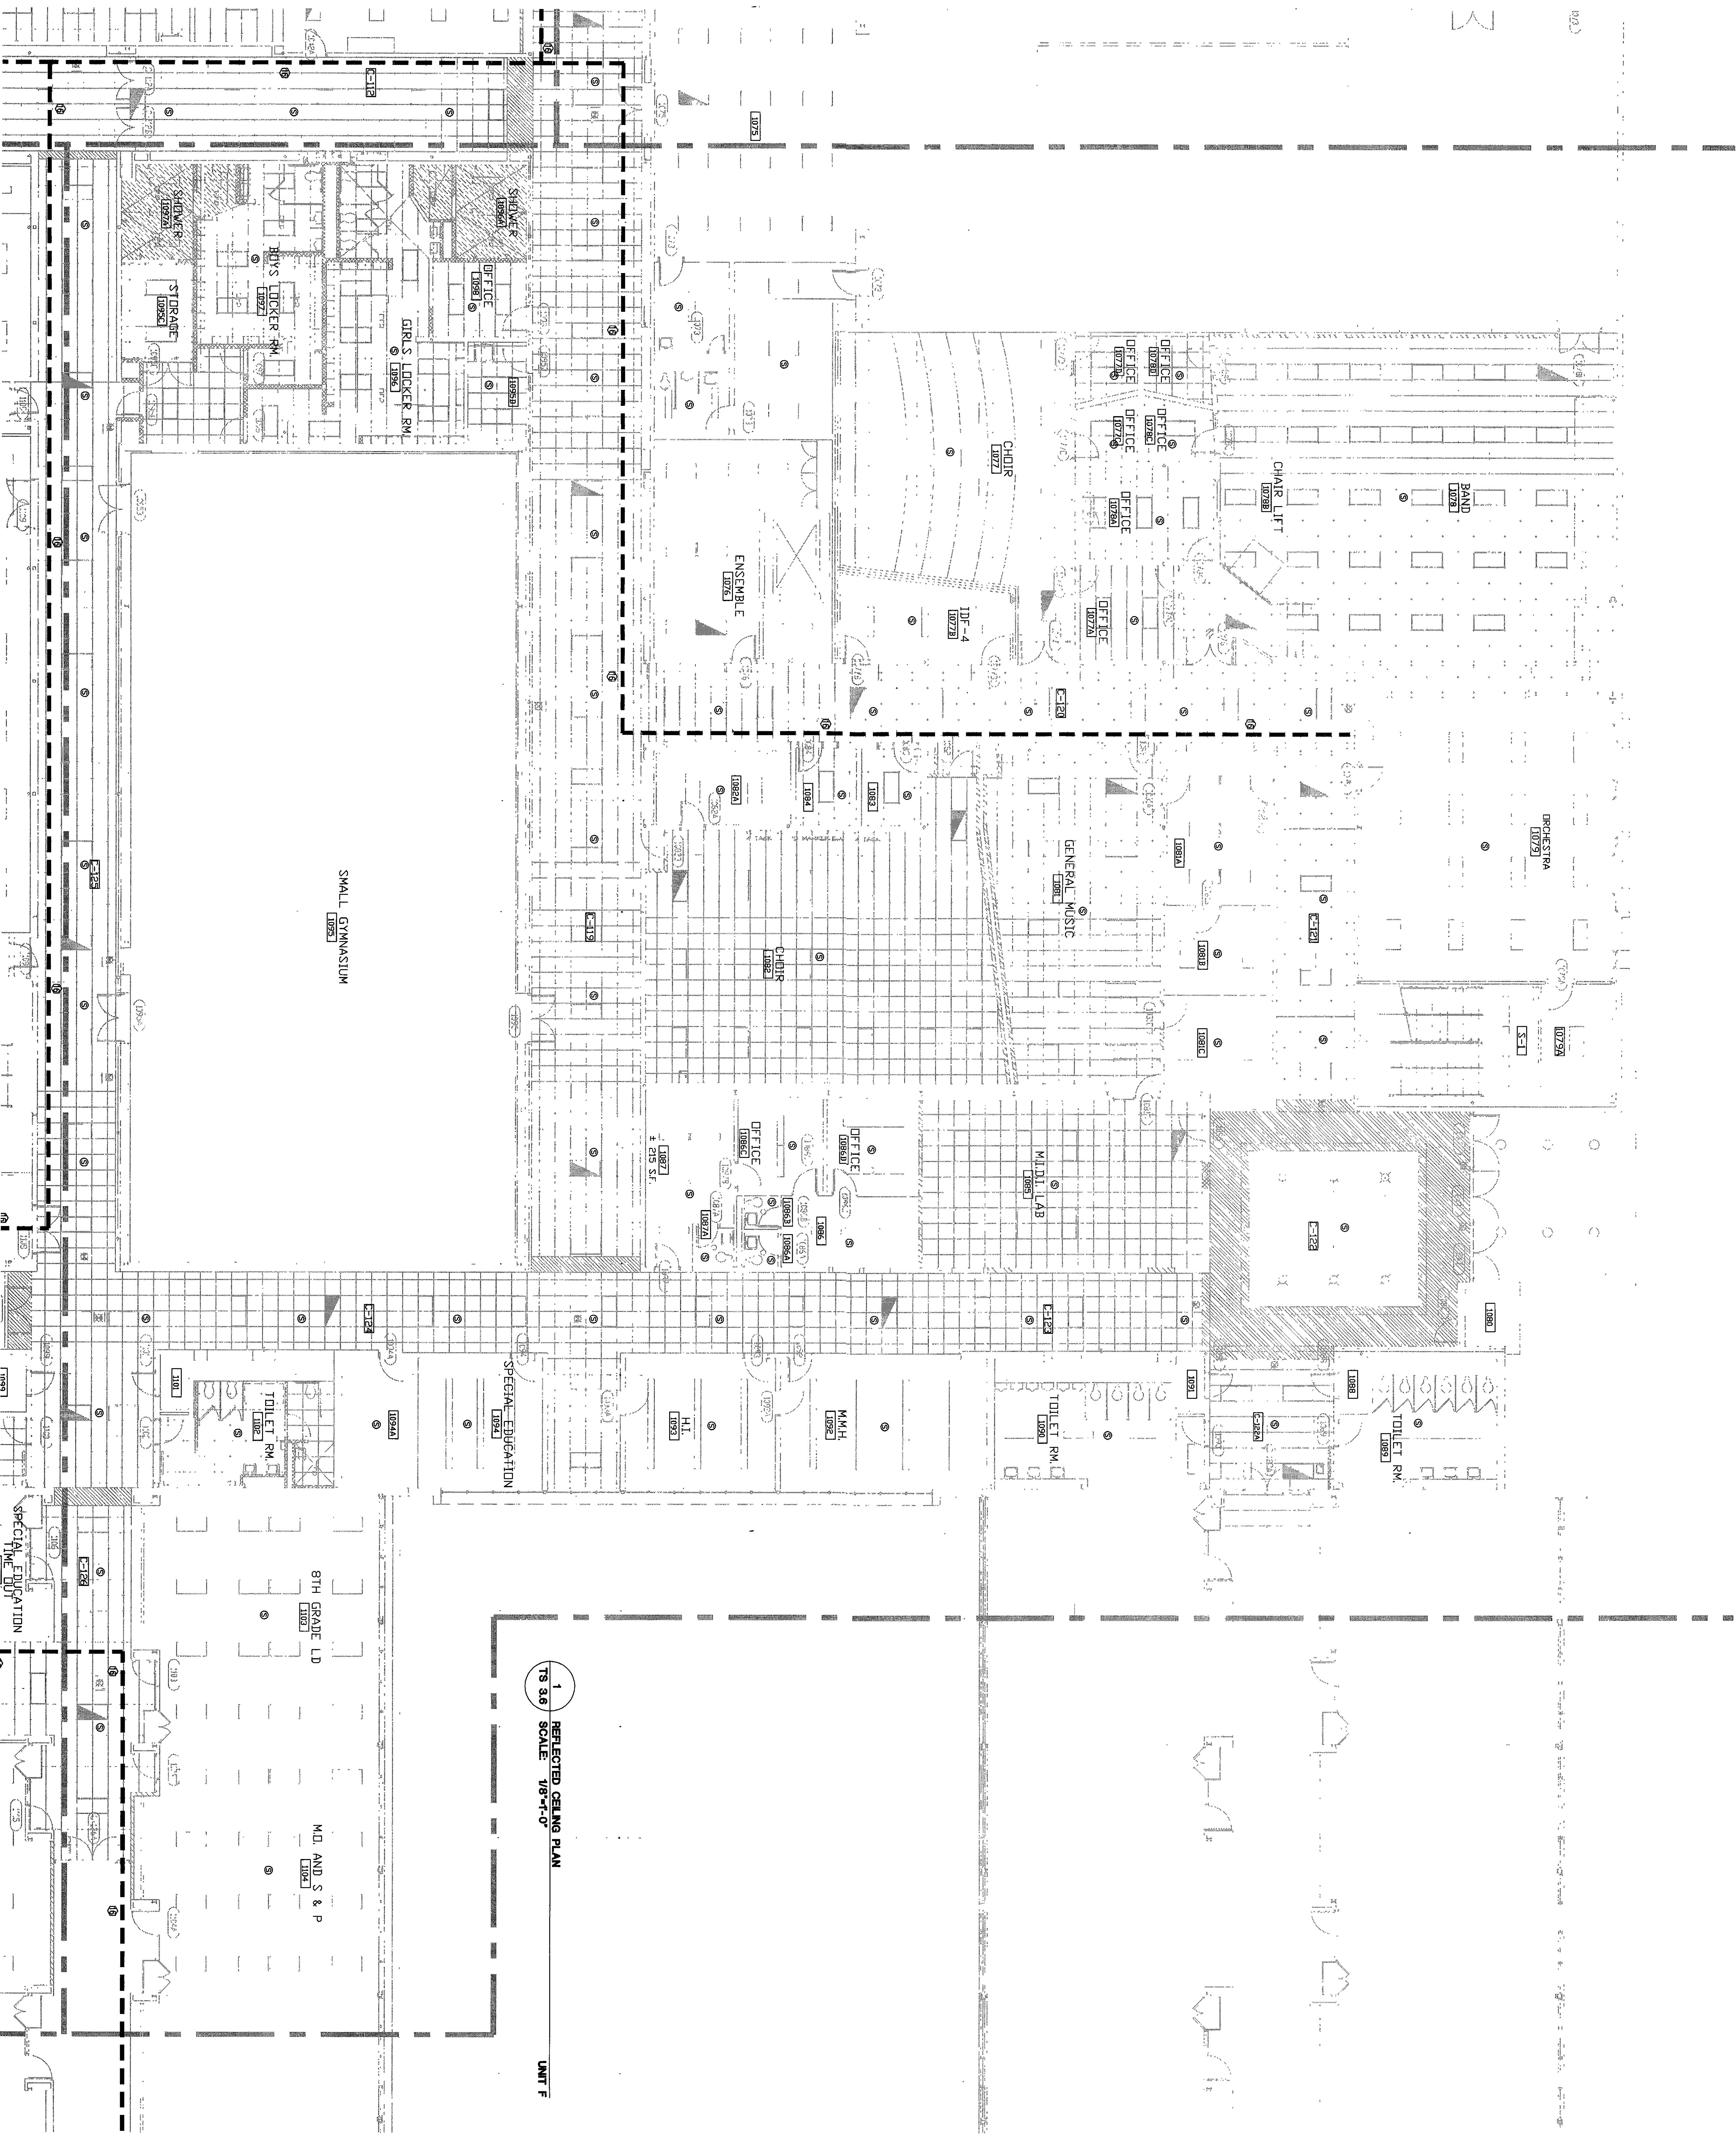

1 REFLECTED CEILING PLAN
TS 3.6 SCALE: 1/8"=1'-0"


UNIT F

- GENERAL NOTES:
1. DIVISION IS CONTRACTOR RESPONSIBLE FOR ALL CONDUIT, BOXES, DUAL-COMPARTMENT RACEWAYS, CABLE TRAY PROVIDED BY DIVISION IS CONTRACTOR.
 2. SHOWN IN DRAWINGS FOR INFORMATION ONLY.

REFERENCED NOTES

1. SEE TS-5.0(2) TYPICAL FOR ALL CLASSROOMS. PROVIDE WALL MOUNT BRACKET.
2. MOUNT DEVICES (PLATE/PLATE) IN RACKWAY PROVIDED BY DIVISION. PROVIDE 1" PORT AND PLATE FOR PRIVATE/PRIVATE MONITOR. PROVIDE NO MONITOR. PROVIDE NO VES. MOUNT AT 8" TO BOTTOM OF BRACKET.
3. SEE TS-5.1(3) FOR ADDITIONAL INFORMATION.
4. PROVIDE EQUIVALENT NUMBER OF CAT 6 CABLES AND OFFICE DIRECTLY ABOVE 100% (SPACE NOT SHOWN). PROVIDE 30' CABLE IN DOL IN CENTER OF SPACE. PROVIDE 30' CAT 6 CABLE BOXED NEARLY ABOVE AT WIRE/USE AND LABEL CABLE.
5. PROVIDE 27' MULTI-MEDIA MONITOR/BACKET ONLY. NO VES. LOOP SIGNALS FROM PRIMARY MONITOR.
6. PROVIDE ONE (1) T. CONNECTOR IN PLATE FOR LOCAL MONITOR. PROVIDE NO VES. MOUNT AT 10" TO 15" FROM BOTTOM OF BRACKET.
7. SEE TS-5.1 (4) FOR ADDITIONAL INFORMATION.
8. PROVIDE (1) T. PORT AND PLATE FOR PRIVATE/PRIVATE MONITOR. PROVIDE NO MONITOR. PROVIDE NO VES.
9. SEE TS-5.1 (5) FOR ADDITIONAL INFORMATION.
10. INTERCOM HORN SPEAKER MOUNT AT 17' AFF OR NEAR CEILING.
11. CABLE TRAY SHOWN FOR REFERENCE ONLY.
12. CABLE TRAY SHOWN FOR REFERENCE ONLY.
13. CABLE TRAY SHOWN FOR REFERENCE ONLY.
14. CABLE TRAY SHOWN FOR REFERENCE ONLY.
15. CABLE TRAY SHOWN FOR REFERENCE ONLY.
16. CABLE TRAY SHOWN FOR REFERENCE ONLY.
17. CABLE TRAY SHOWN FOR REFERENCE ONLY.
18. SURFACE MOUNT AUDIOVISUAL SPEAKER.
19. WALL MOUNT 9"X12" PROJECTION SCREEN.
20. CEILING MOUNTED PROJECTOR. ROUTE CABLE TO AV EQUIPMENT RACK.
21. AUDIOVISUAL EQUIPMENT RACK.

KEY PLAN:

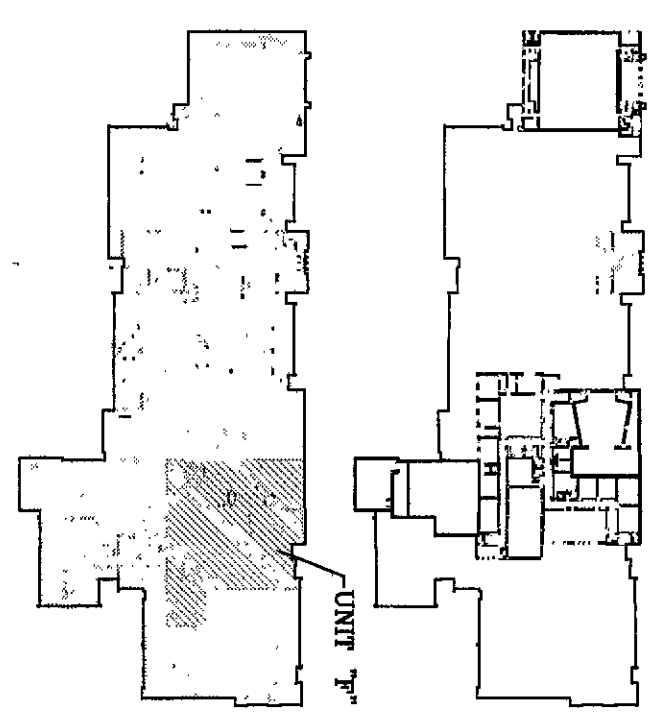

NORTH
SCALE: NTS

D S & A
Technology Design Consultants
14418 East 196th Street
Northwest, MN 55446-9520
763.534.5152
D S & A ARCHITECTS

**VEAZEY
PARROTT
&
SHOULDERS**
ARCHITECTS
ENGINEERS
PLANNERS
3800 Parkway West, Suite 110
Shawnee, MO 64060

RENOVATION PROJECT FOR:
**DUNELAND SCHOOL
CORPORATION**
CHESTERTON, INDIANA

Drawing Title:
**TECHNOLOGY SYSTEMS REFLECTED
CEILING PLAN (UNIT F)**

Project No.: 94-1024
Project Date: 6-14-2000
Drawn By: TDES
Approved By: LVP

Drawing No.:
TS 3.6