



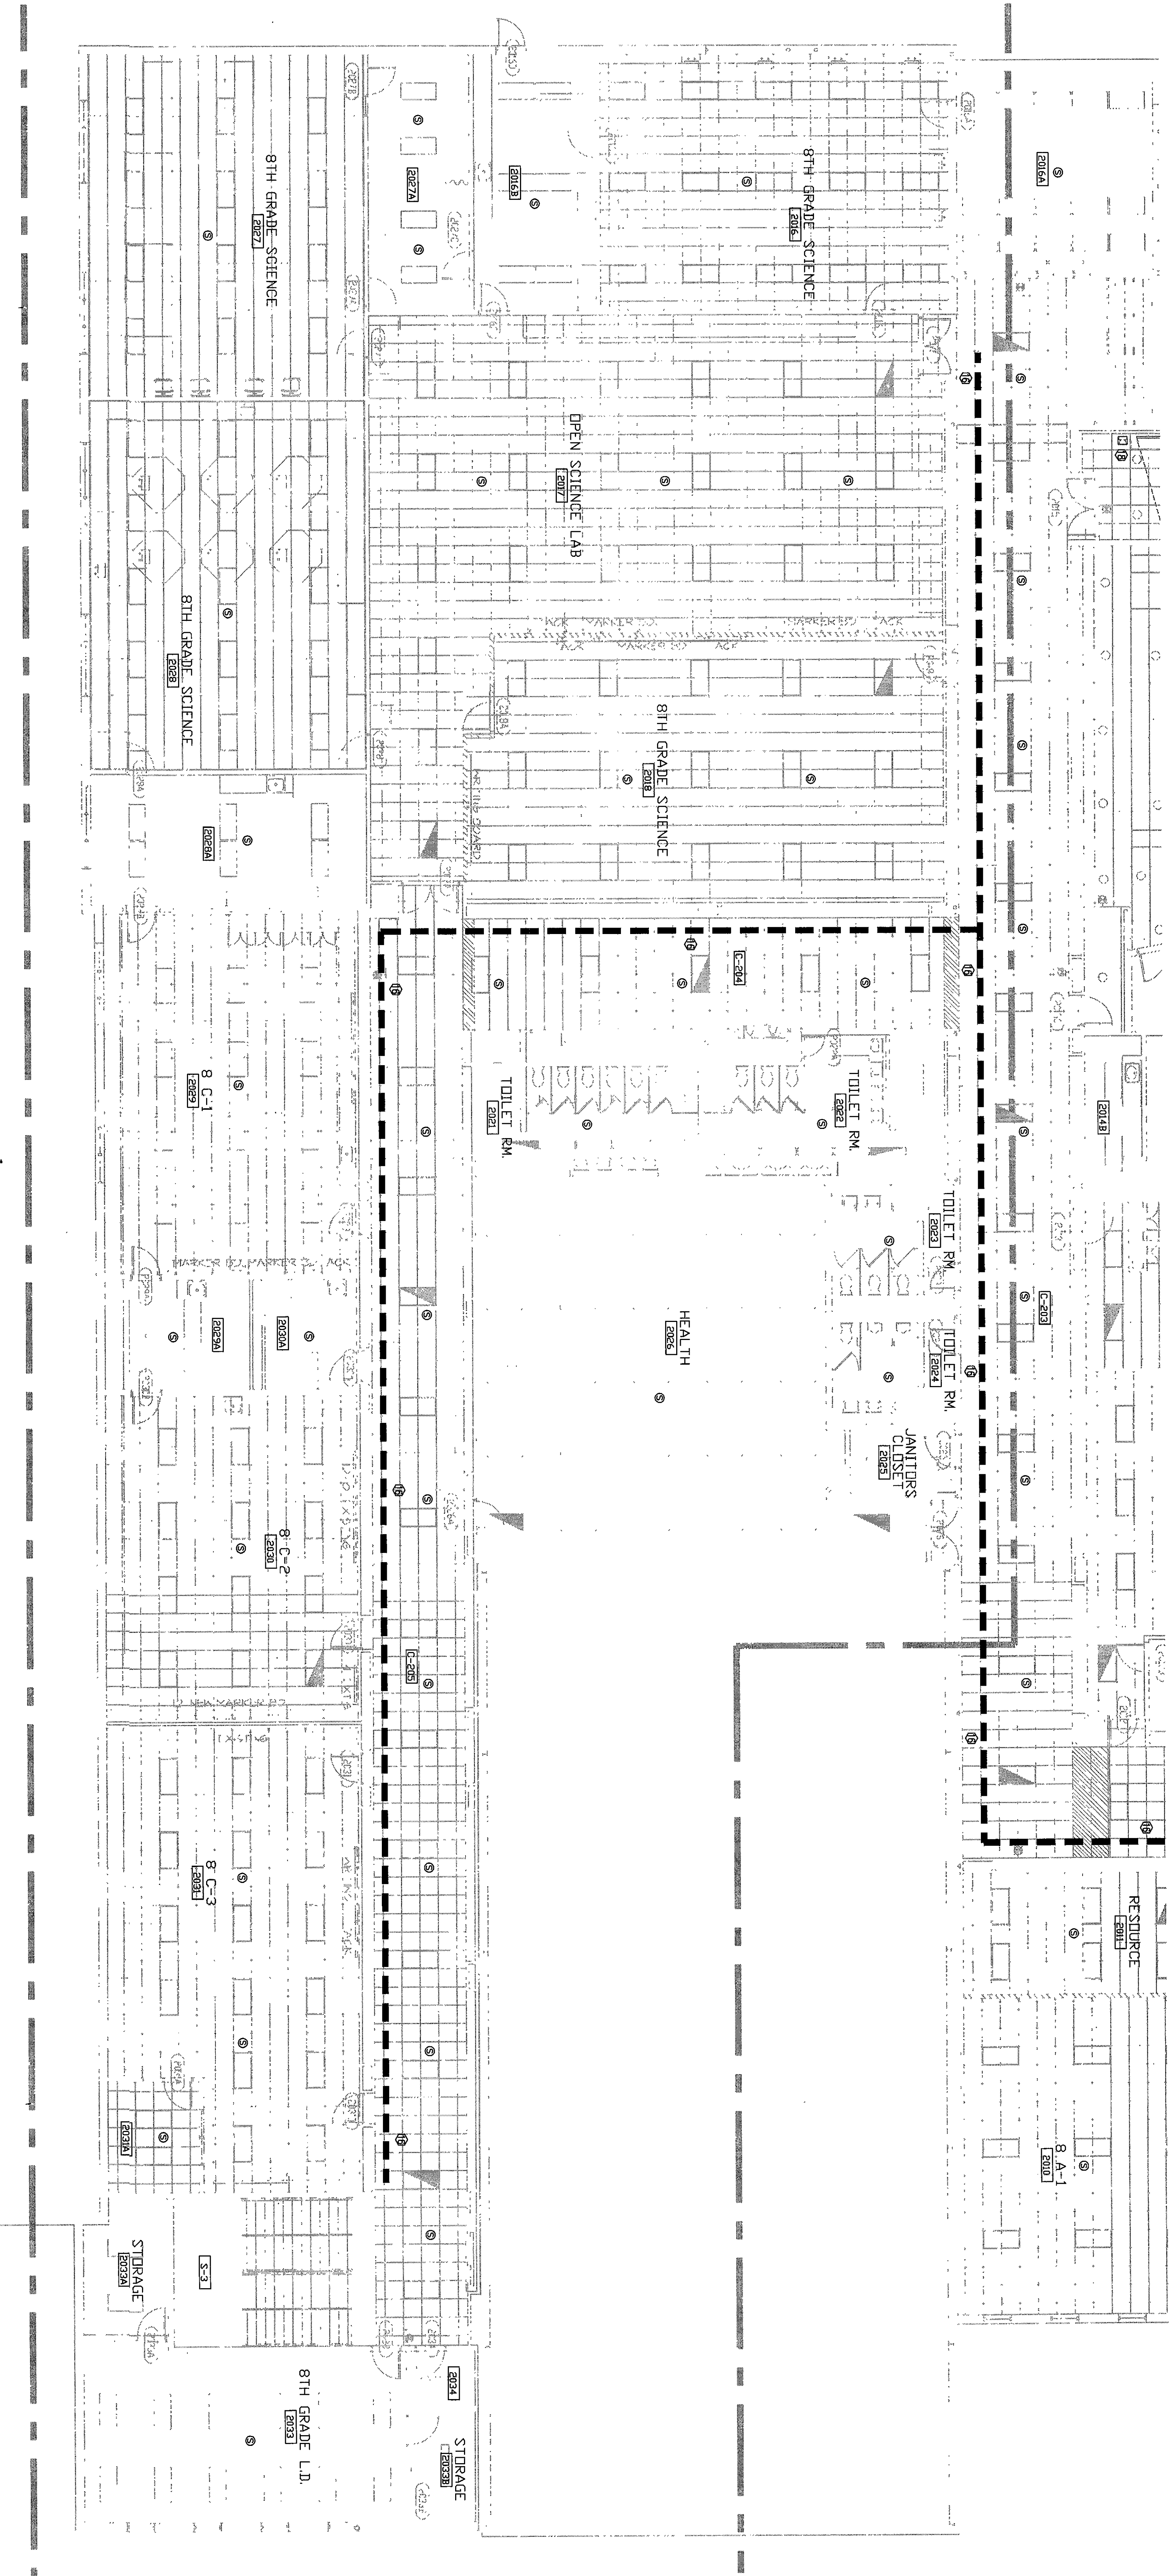

1 REFLECTED CEILING PLAN
TS 4.1 SCALE: 1/8"=1'-0"

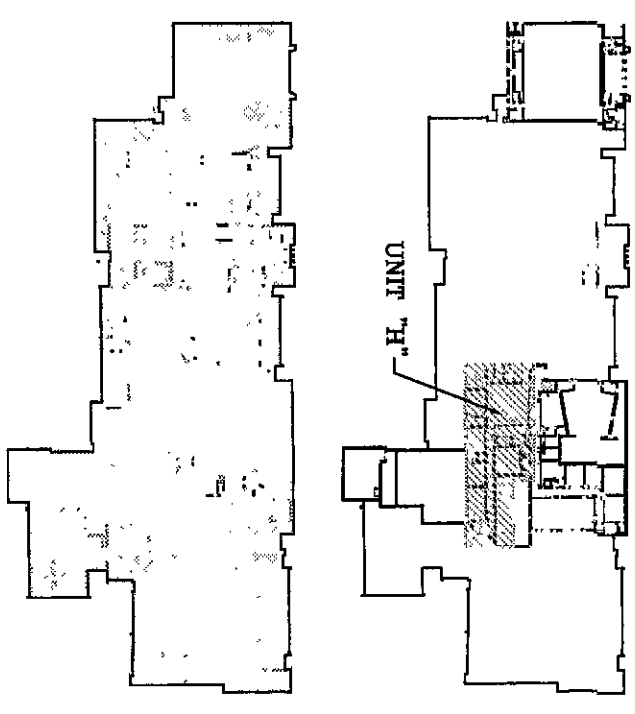

KEY PLAN:

- GENERAL NOTES:
1. DIVISION IS CONTRACTOR RESPONSIBLE FOR ALL CONDUIT, DUCTS, DRAIN-COMPARTMENT RACKINGS, CABLE TRAY PROVIDED BY DIVISION IS CONTRACTOR. SHOWN IN DRAWINGS FOR REFERENCE ONLY.
- REFERENCES NOTES:
1. SEE TS-500 TYPICAL FOR ALL CLASSROOMS. PROVIDE (1) 27" MULTI-MEDIA MONITOR & (1) 5-WAY VCR IN CLASSROOMS.
 2. MOUNT DEVICES (PLATE/PORT) IN RACKING PROVIDED BY DIVISION IS CONTRACTOR. TYPICAL AS NOTICED, AND NO VCR MOUNT AT 5' TO BOTTOM OF BRACKET.
 3. SEE TS-510 FOR ADDITIONAL INFORMATION.
 4. PROVIDE EQUIPMENT NUMBER OF CAT 6 CABLES AND COAX TO PROVIDE SAME SERVICE AS PRIMARY CABLES. PROVIDE 30' OF CABLE IN COIL IN CENTER OF SPACE.
 5. PROVIDE 30' OF DATA CABLE COILED NEATLY ABOVE CEILING FOR FUTURE USE. EXEMPT OTHER SDI.
 6. PROVIDE 27" MULTI-MEDIA MONITOR/BRACKET ONLY. NO VCR. LOOP SIGNALS FROM PRIMARY MONITOR.
 7. PROVIDE 27" MONITOR/BRACKET ONLY. NO VCR.
 8. PROVIDE ONE (1) 7" CONNECTOR IN PLATE FOR LOCAL VIDEO OUT. NO MONITOR. NO VCR. MOUNT AT 10' HGT.
 9. PROVIDE TELEPHONE LOCATION INFORMATION.
 10. PROVIDE (1) 17" PORT AND PLATE FOR PORTABLE/FUTURE MONITOR. PROVIDE NO MONITOR. PROVIDE NO VCR.
 11. PROVIDE 36" MULTI-MEDIA MONITOR/BRACKET. NO VCR. SEE TS-51 (5).
 12. PROVIDE 36" MULTI-MEDIA MONITOR/BRACKET. NO VCR. SEE TS-51 (5).
 13. INTERCOM HORN SPEAKER MOUNT AT 12' HGT OR NEAR CEILING. CABLE TRAY SHOWN FOR REFERENCE ONLY.
 14. CEILING SPEAKERS: ROUTE TO ROOM MGMT/MANAGER TYPICAL OF 18.
 15. SURFACE MOUNT AUDIOVISUAL SPEAKER.
 16. WALL MOUNT 9x12 PROJECTION SCREEN.
 17. CEILING MOUNT LCD PROJECTOR. ROUTE CABLE TO AV ADDITIONAL EQUIPMENT RACK.

NORTH
SCALE: NTS

D S & A INC.
Technology Design Consultants
16616 East 196th Street
Noblesville, IN 46060-9530
765-334-5152
D S & A ARCHITECTS

**VEAZEY
PARROTT
DURKIN
&
SHOULDERS**
ARCHITECTS
ENGINEERS
PLANNERS

REVOLUTION PROJECT FOR:
DUNELAND SCHOOL
CORPORATION
CHESTERTON MIDDLE SCHOOL
CHESTERTON, INDIANA

Drawing Title:
**TECHNOLOGY SYSTEMS REFLECTED
CEILING PLAN (UNIT 4.1)**

Project No.:	94-1024
Project Date:	6-14-2000
Drawn By:	TDES
Approved By:	LVD
Drawing No.:	TS 4.1

2000-LS-10A