




1 REFLECTED CEILING PLAN
TS 4.2 SCALE: 1/8"=1'-0"

UNIT J

- GENERAL NOTES:
1. DIVISION 18 CONTRACTOR RESPONSIBLE FOR ALL CONDUIT, BOXES, DATA-COMPARISON, CABLES, AND TERMINALS. PROVIDE ALL NECESSARY MATERIALS AND LABOR FOR THE ENTIRE PROJECT.
 2. SHOW IN DRAWINGS FOR REFERENCE ONLY.

- REFERENCED NOTES:
1. SEE TS-4.02, TYPICAL FOR ALL CLASSROOMS. PROVIDE (1) 27" MULTI-MEDIA MONITOR & (1) 5-WAY VCR IN WALL MOUNT BRACKET.
 2. PROVIDE (1) 27" MONITOR/BRACKET IN PASSAGE PROVIDED BY DIVISION 18. PROVIDE TYPICAL AS INDICATED AND NO VCR MOUNT AT 8" TO BOTTOM OF BRACKET.
 3. SEE TS-4.03, PROVIDE 30" MONITOR/BRACKET AND NO VCR MOUNT AT 8" TO BOTTOM OF BRACKET.
 4. SEE TS-4.03 FOR ADDITIONAL INFORMATION.
 5. PROVIDE (1) 27" MONITOR/BRACKET IN PASSAGE PROVIDED BY DIVISION 18. PROVIDE TYPICAL AS INDICATED AND NO VCR MOUNT AT 8" TO BOTTOM OF BRACKET.
 6. PROVIDE (1) 27" MONITOR/BRACKET IN PASSAGE PROVIDED BY DIVISION 18. PROVIDE TYPICAL AS INDICATED AND NO VCR MOUNT AT 8" TO BOTTOM OF BRACKET.
 7. PROVIDE (1) 27" MONITOR/BRACKET IN PASSAGE PROVIDED BY DIVISION 18. PROVIDE TYPICAL AS INDICATED AND NO VCR MOUNT AT 8" TO BOTTOM OF BRACKET.
 8. PROVIDE (1) 27" MONITOR/BRACKET IN PASSAGE PROVIDED BY DIVISION 18. PROVIDE TYPICAL AS INDICATED AND NO VCR MOUNT AT 8" TO BOTTOM OF BRACKET.
 9. PROVIDE (1) 27" MONITOR/BRACKET IN PASSAGE PROVIDED BY DIVISION 18. PROVIDE TYPICAL AS INDICATED AND NO VCR MOUNT AT 8" TO BOTTOM OF BRACKET.
 10. PROVIDE (1) 27" MONITOR/BRACKET IN PASSAGE PROVIDED BY DIVISION 18. PROVIDE TYPICAL AS INDICATED AND NO VCR MOUNT AT 8" TO BOTTOM OF BRACKET.
 11. PROVIDE (1) 27" MONITOR/BRACKET IN PASSAGE PROVIDED BY DIVISION 18. PROVIDE TYPICAL AS INDICATED AND NO VCR MOUNT AT 8" TO BOTTOM OF BRACKET.
 12. PROVIDE (1) 27" MONITOR/BRACKET IN PASSAGE PROVIDED BY DIVISION 18. PROVIDE TYPICAL AS INDICATED AND NO VCR MOUNT AT 8" TO BOTTOM OF BRACKET.
 13. PROVIDE (1) 27" MONITOR/BRACKET IN PASSAGE PROVIDED BY DIVISION 18. PROVIDE TYPICAL AS INDICATED AND NO VCR MOUNT AT 8" TO BOTTOM OF BRACKET.
 14. PROVIDE (1) 27" MONITOR/BRACKET IN PASSAGE PROVIDED BY DIVISION 18. PROVIDE TYPICAL AS INDICATED AND NO VCR MOUNT AT 8" TO BOTTOM OF BRACKET.
 15. PROVIDE (1) 27" MONITOR/BRACKET IN PASSAGE PROVIDED BY DIVISION 18. PROVIDE TYPICAL AS INDICATED AND NO VCR MOUNT AT 8" TO BOTTOM OF BRACKET.
 16. PROVIDE (1) 27" MONITOR/BRACKET IN PASSAGE PROVIDED BY DIVISION 18. PROVIDE TYPICAL AS INDICATED AND NO VCR MOUNT AT 8" TO BOTTOM OF BRACKET.
 17. PROVIDE (1) 27" MONITOR/BRACKET IN PASSAGE PROVIDED BY DIVISION 18. PROVIDE TYPICAL AS INDICATED AND NO VCR MOUNT AT 8" TO BOTTOM OF BRACKET.
 18. PROVIDE (1) 27" MONITOR/BRACKET IN PASSAGE PROVIDED BY DIVISION 18. PROVIDE TYPICAL AS INDICATED AND NO VCR MOUNT AT 8" TO BOTTOM OF BRACKET.
 19. PROVIDE (1) 27" MONITOR/BRACKET IN PASSAGE PROVIDED BY DIVISION 18. PROVIDE TYPICAL AS INDICATED AND NO VCR MOUNT AT 8" TO BOTTOM OF BRACKET.
 20. PROVIDE (1) 27" MONITOR/BRACKET IN PASSAGE PROVIDED BY DIVISION 18. PROVIDE TYPICAL AS INDICATED AND NO VCR MOUNT AT 8" TO BOTTOM OF BRACKET.
 21. PROVIDE (1) 27" MONITOR/BRACKET IN PASSAGE PROVIDED BY DIVISION 18. PROVIDE TYPICAL AS INDICATED AND NO VCR MOUNT AT 8" TO BOTTOM OF BRACKET.

KEY PLAN:

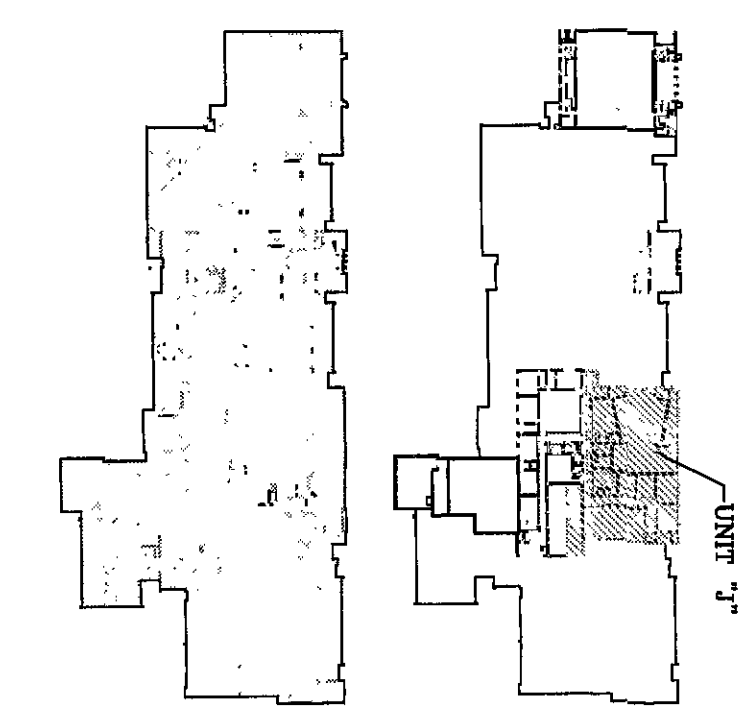

NORTH
SCALE: NTS

D S & A INC.
Technology Design Consultants
4448 East 79th Street
Indianapolis IN 46060-9530
765-534-4152
D S & A ARCHITECTS

**VEAZEY
PARROTT
DURKIN
&
SHOULDERS**
ARCHITECTS
ENGINEERS
PLANNERS
2800 Broadway NW 3rd
Indianapolis, IN 46204

RENOVATION PROJECT FOR:
**DUNELAND SCHOOL
CORPORATION**
OBERLIN MIDDLE SCHOOL
OBERLIN, INDIANA

Drawing Title:
**TECHNOLOGY SYSTEMS REFLECTED
CEILING PLAN UNIT J**

Project No: 44-1024

Project Date: 6-14-2000

Drawn By: TDES

Approved By: LMD

Drawing Inc: 2000-0000

TS 4.2