

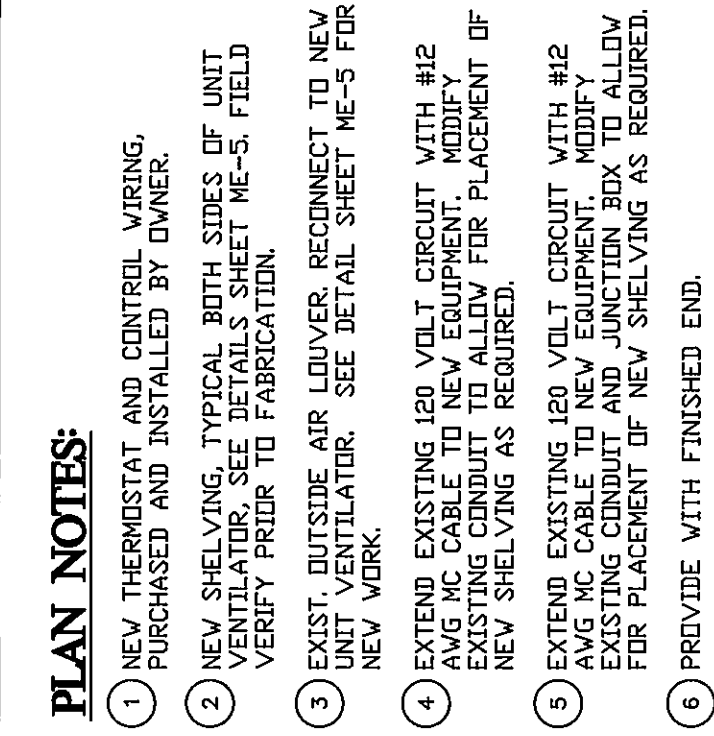


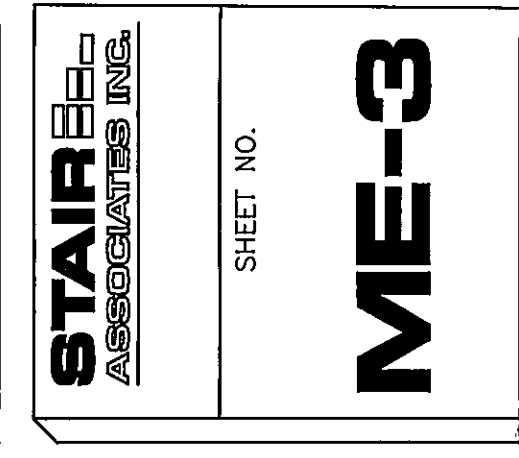

UNIT A - MECHANICAL FLOOR PLAN

DRAWN BY: RWT
CHECKED BY: WWH

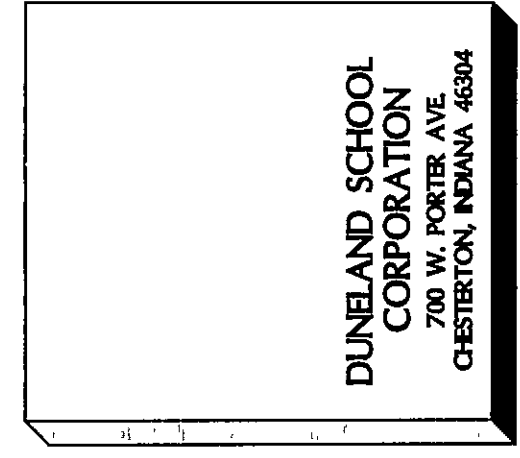

ME-3



SCALE: 1/8" = 1'-0"