


PLAN NOTES:

1. NEW THERMOSTAT AND CONTROL WIRING, PURCHASED AND INSTALLED BY OWNER.
2. NEW SHELVESS SET BEHIND WALLS OF UNIT, VERIFY PRIOR TO FABRICATION.
3. EXIST. OUTSIDE AIR LOUVER, RECONNECT TO NEW UNIT VENTILATOR. SEE DETAIL SHEET ME-3 FOR NEW VENTILATOR.
4. NEW WIRING FOR VOLT. CIRCUIT, VTL #22 EXISTING CONDUIT TO ALLOW FOR PLACEMENT OF NEW SHELVESS AS REQUIRED.
5. NEW WIRING FOR VOLT. CIRCUIT, VTL #42 EXISTING CONDUIT TO ALLOW FOR PLACEMENT OF NEW SHELVESS AS REQUIRED.
6. PROVIDE VTL# FINISHED END.

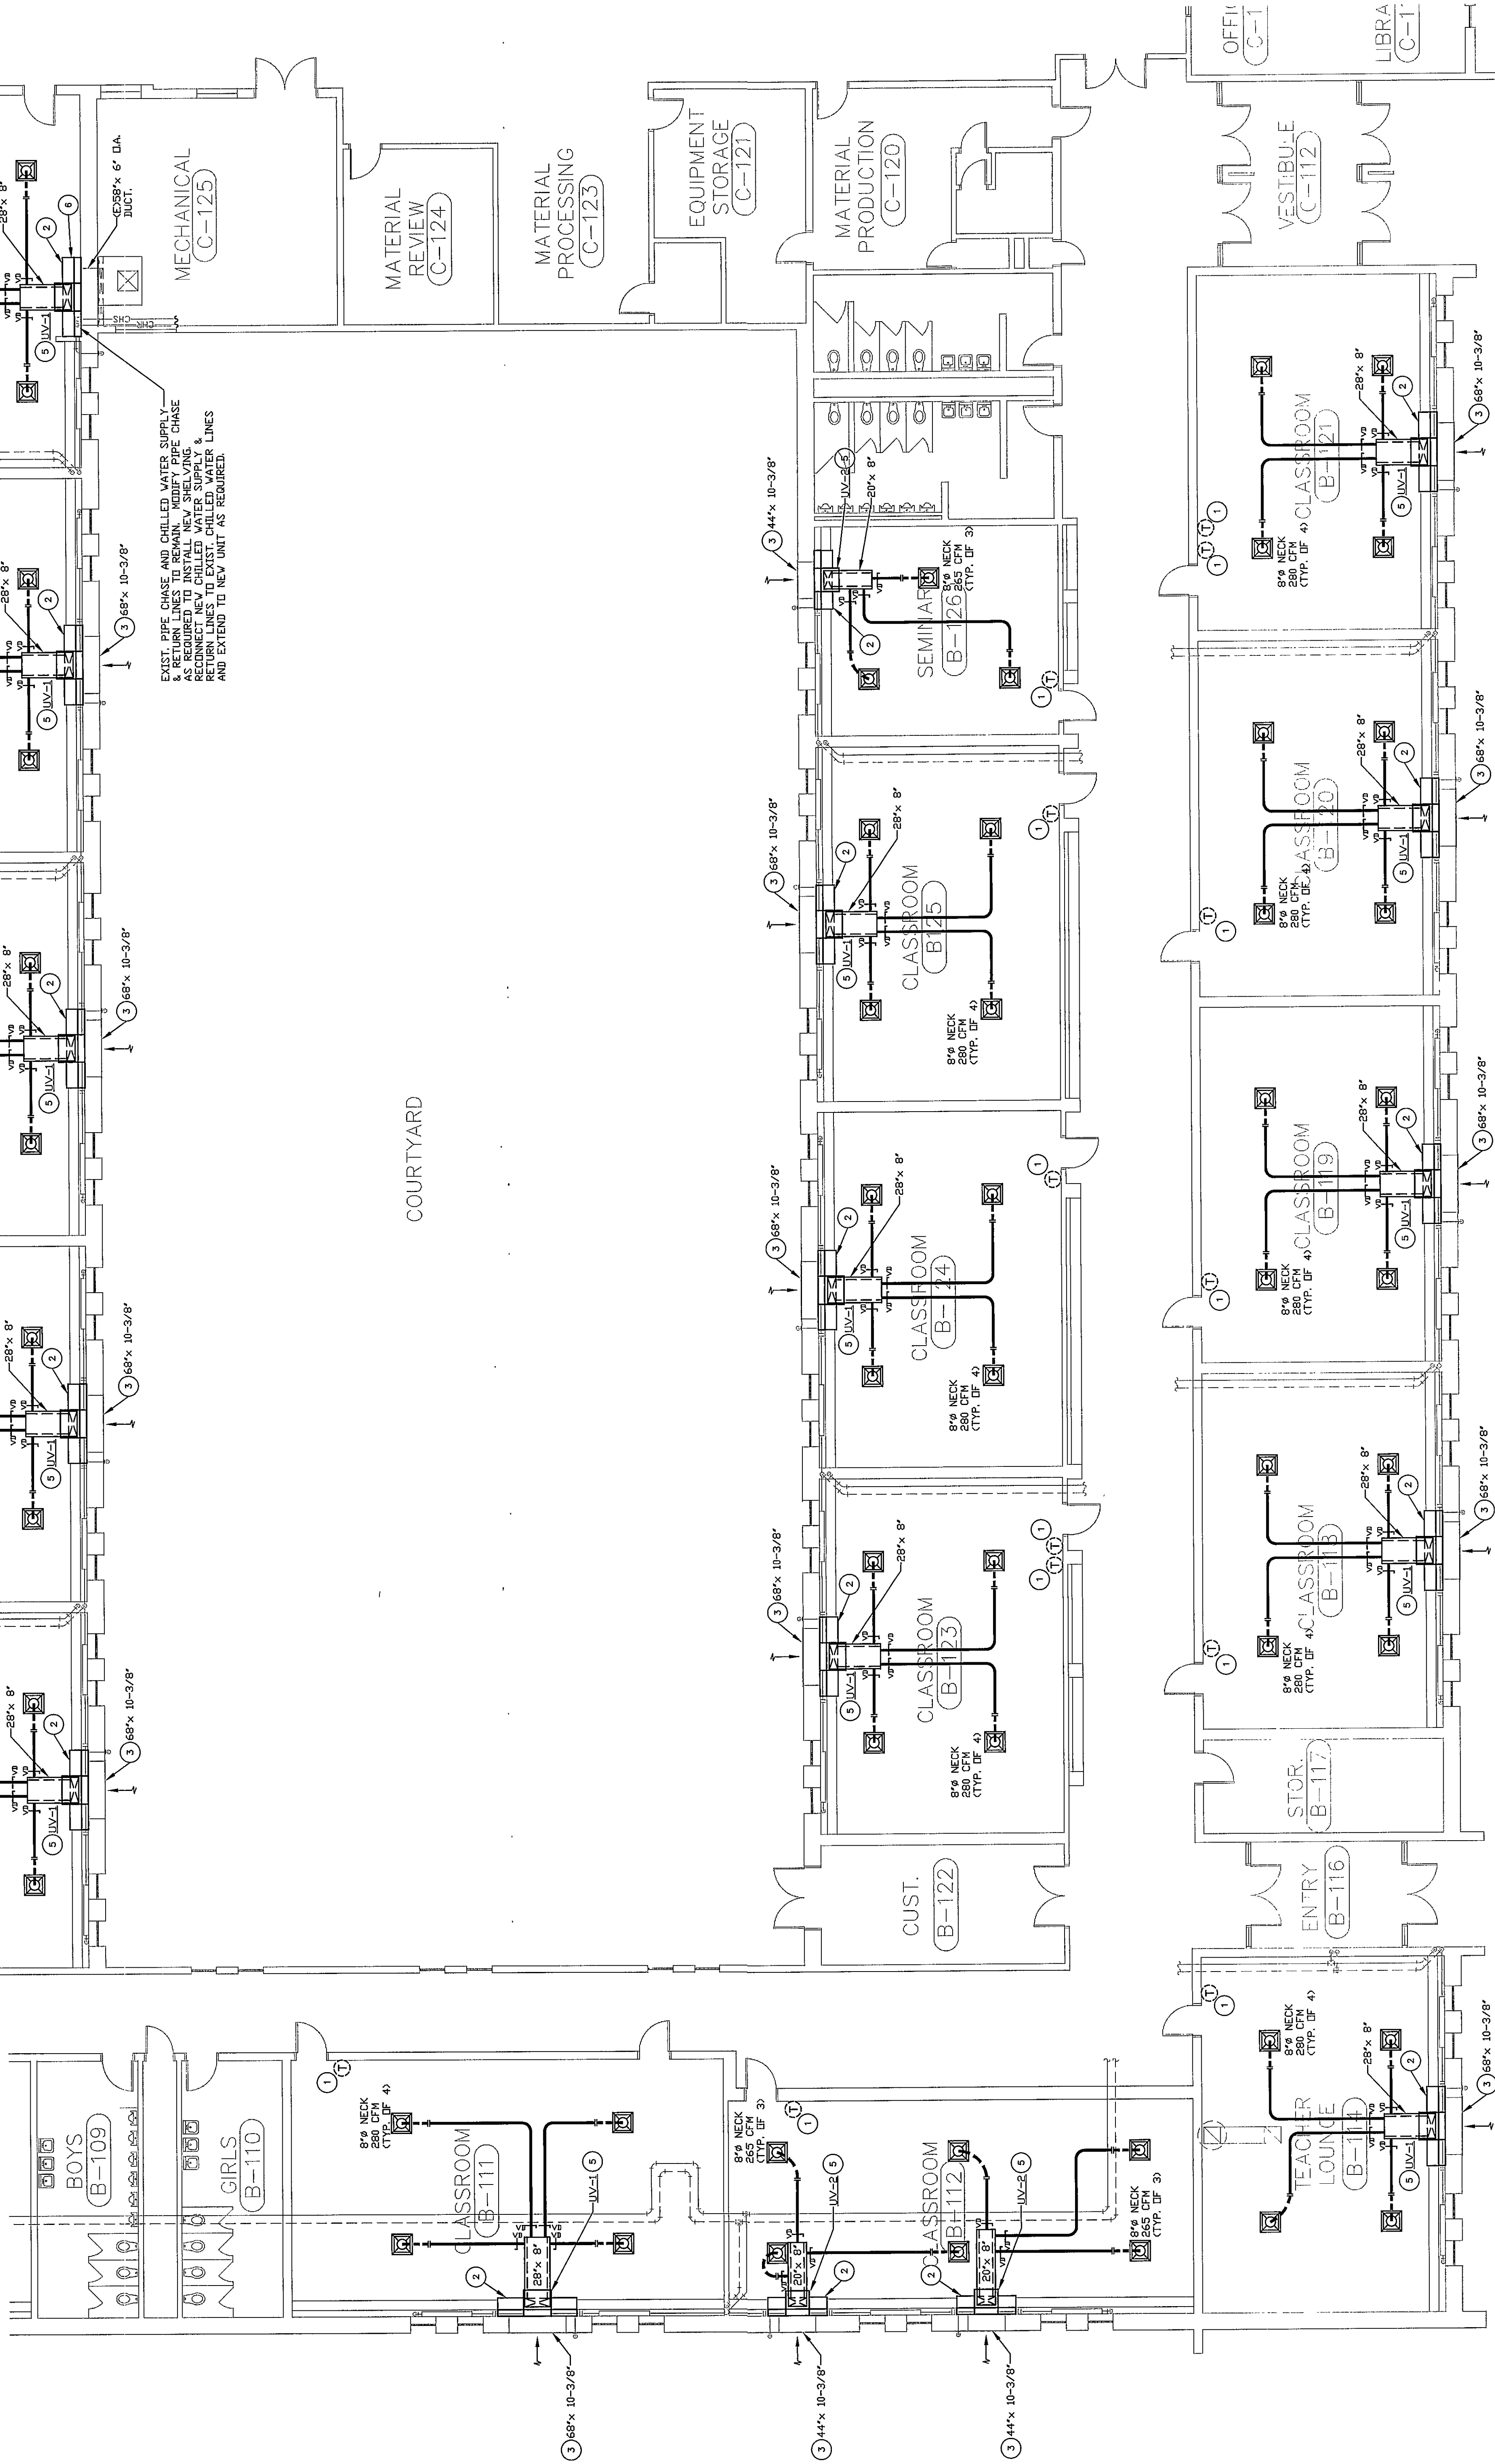

UNIT B - MECHANICAL FLOOR PLAN
SCALE: 1/8" = 1'-0"

STAIR ASSOCIATES INC.
MECHANICAL/ELECTRICAL
9700 W. 90TH STREET INDIANAPOLIS, IN 46268
PHONE 317-228-1900
FAX 317-228-7700

REVISIONS:


NO.	DESCRIPTION

UNIT B - MECHANICAL FLOOR PLAN
LIBERTY INTERMEDIATE SCHOOL
50 W. 900 N.
CHESTERTON, INDIANA 46304

PROJECT NO.
943

DATE
03/28/2008

DRAWN BY: CHECKED BY:
RWT WWH

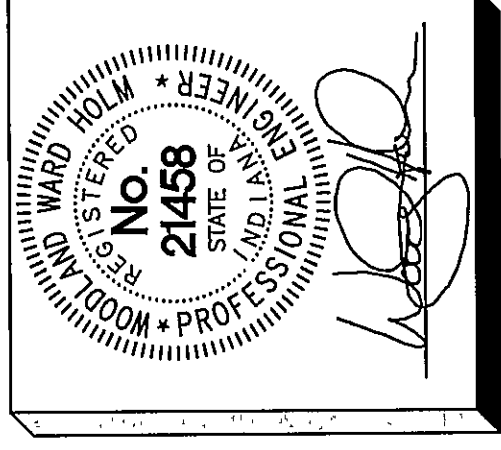

DUNELAND SCHOOL CORPORATION
CORPORATION
CHESTERTON, INDIANA 46304

KEY PLAN
NORTH
B

STAIR ASSOCIATES INC.
SHEET NO.
ME-4

08-ME-4