
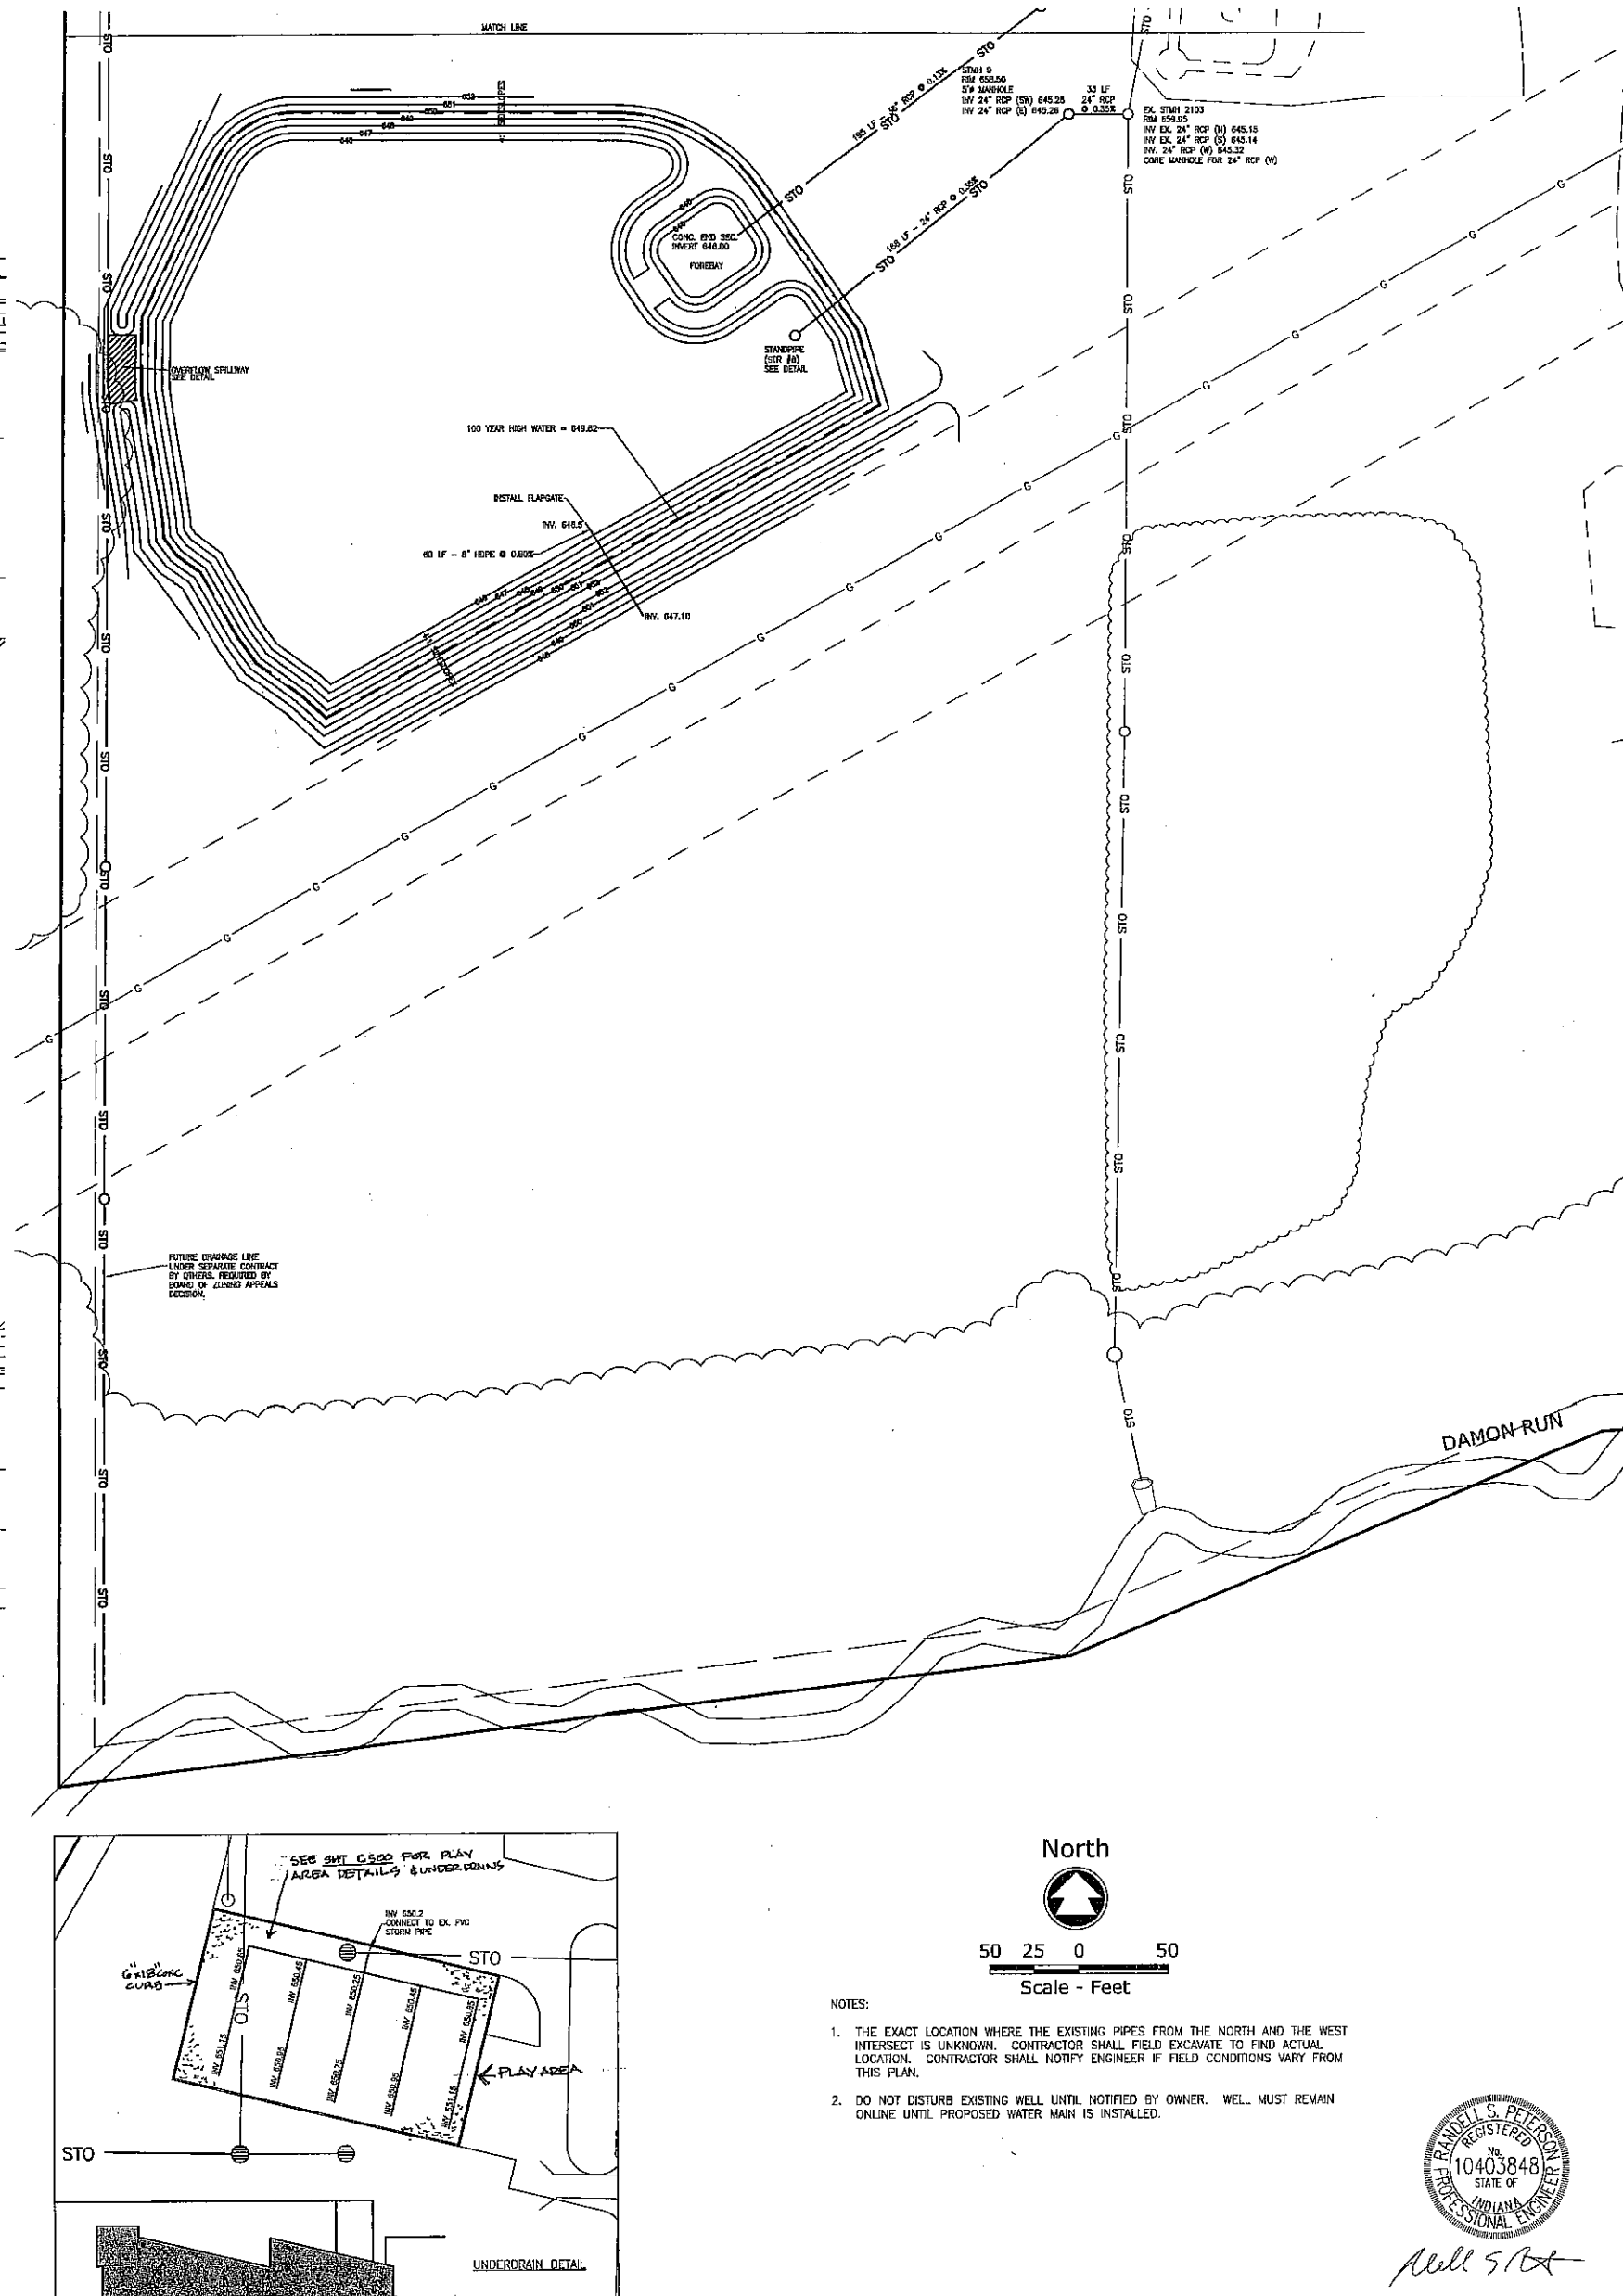


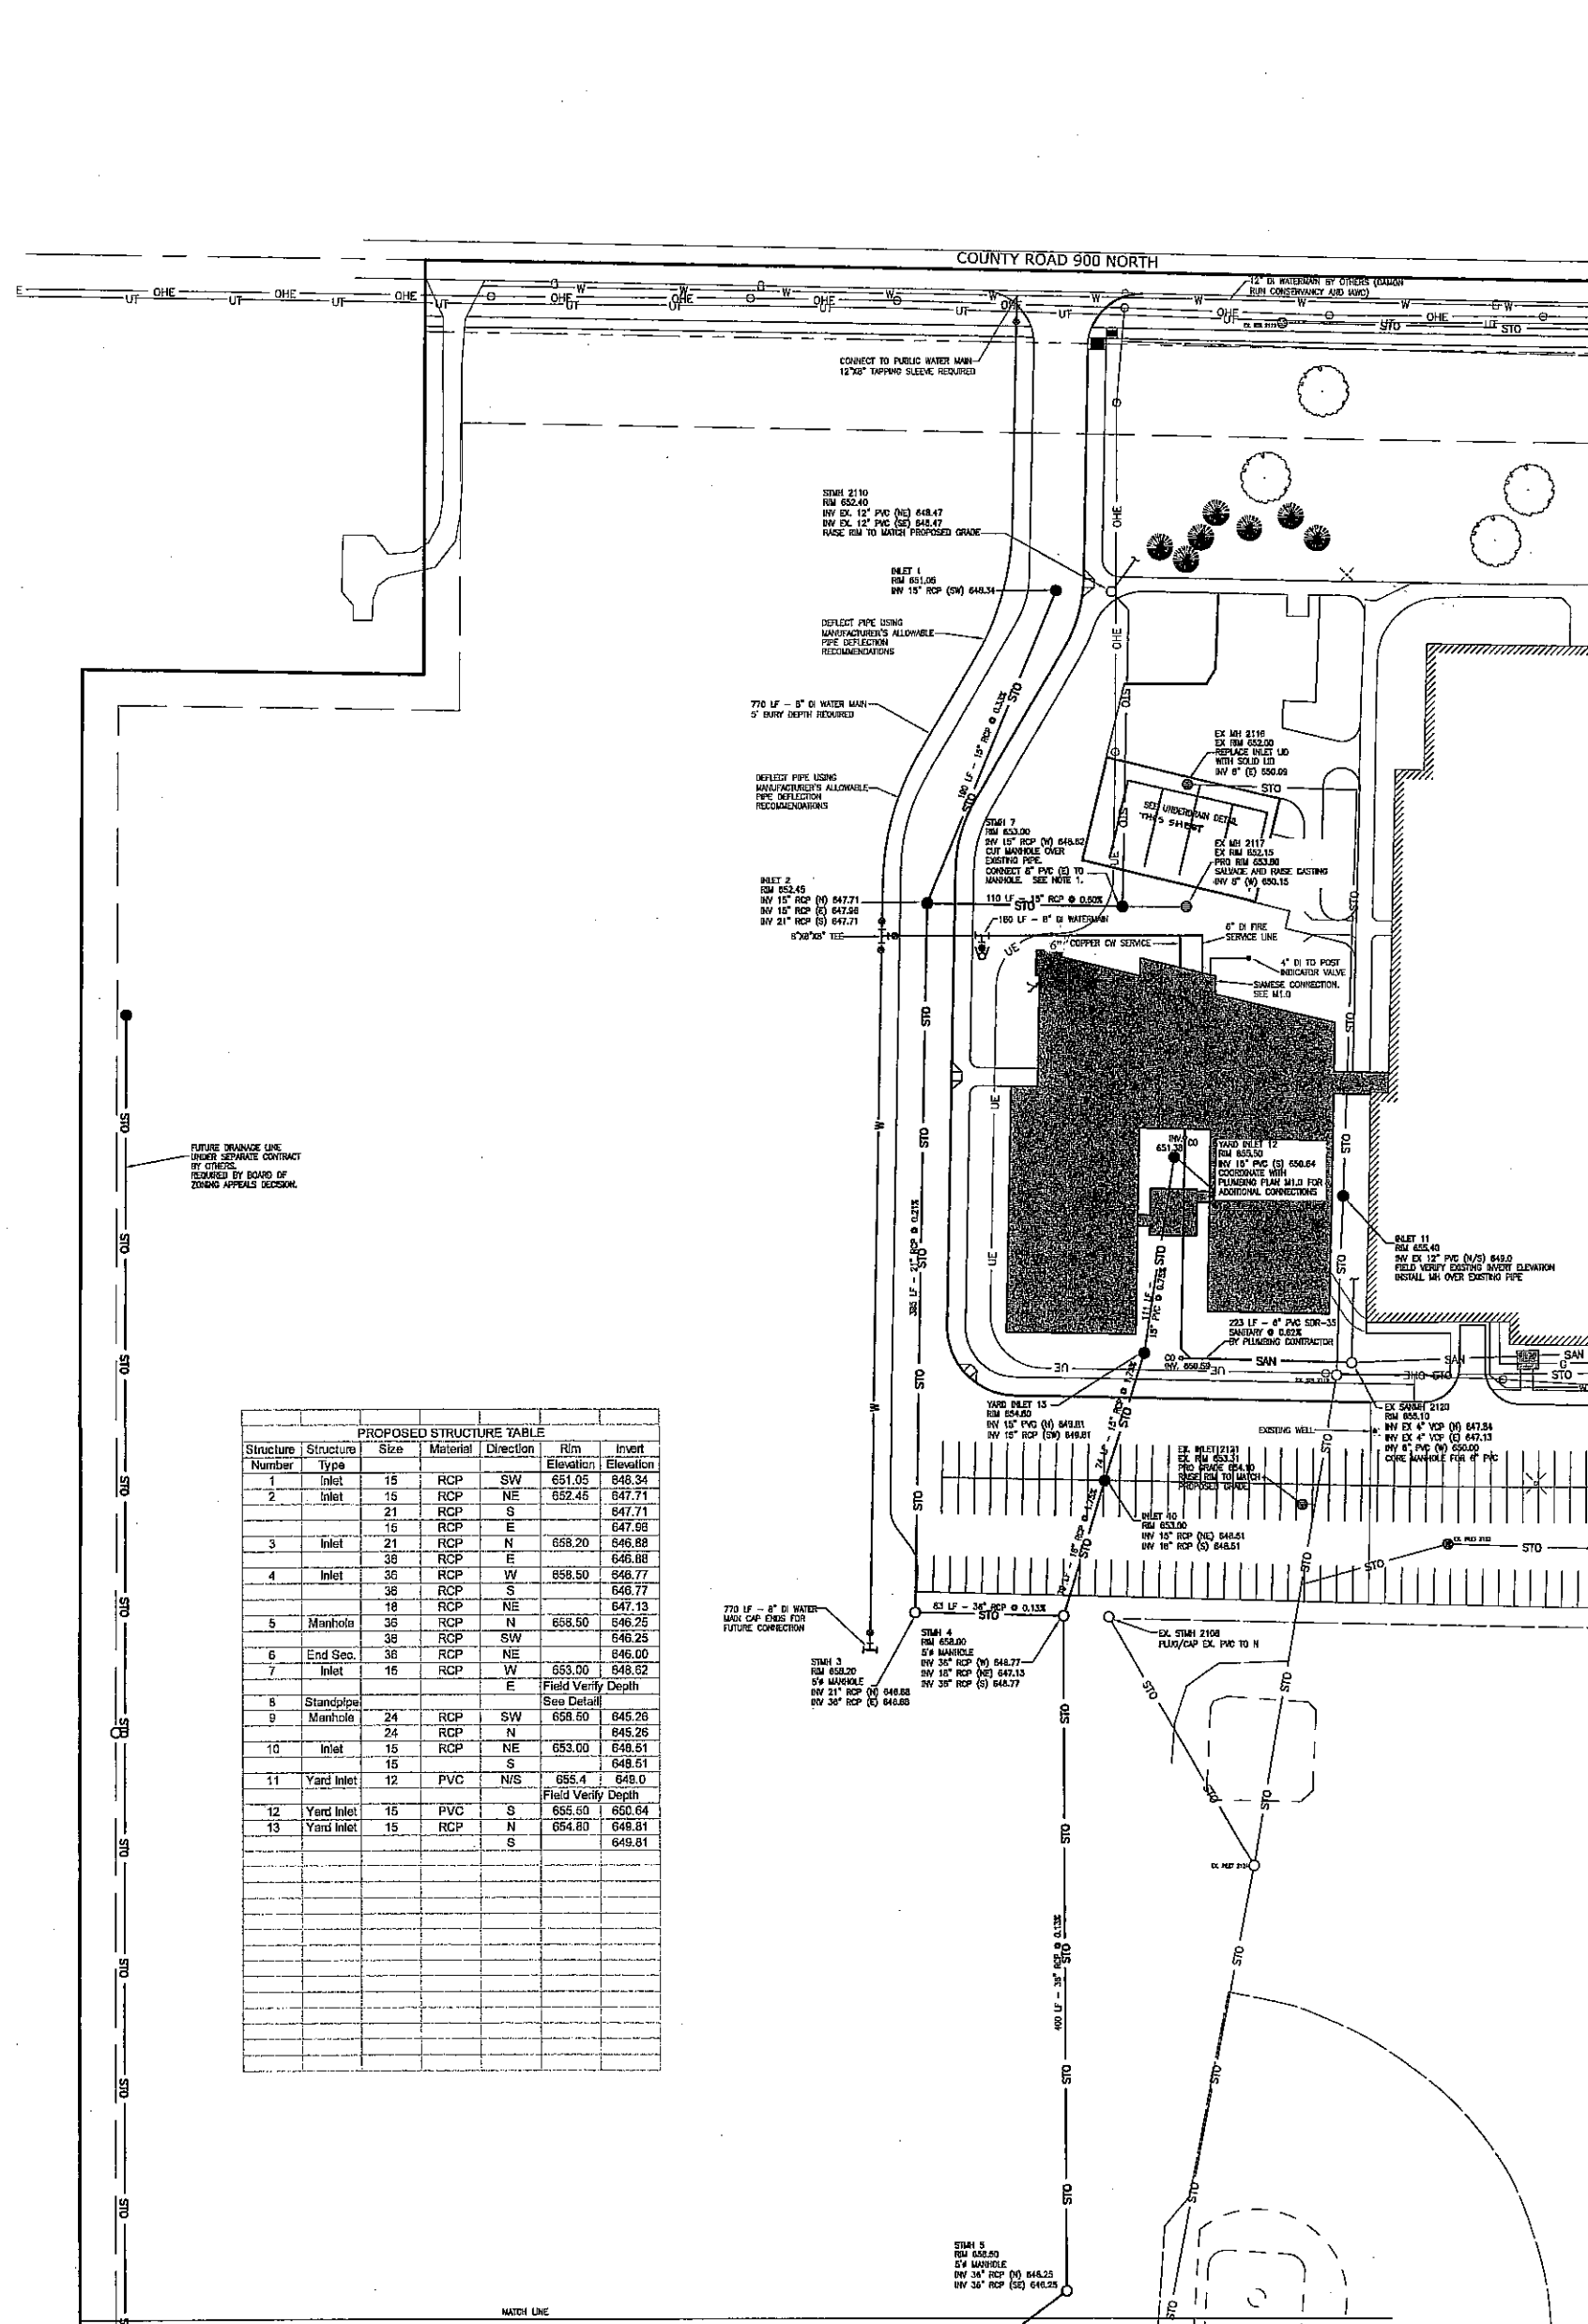

McMAHON
ENGINEERS ARCHITECTS
952 South State Road 2
Valparaiso, Indiana 46385
Phone: (219) 462-1111
Fax: (219) 462-1112
meh@mcmaffp.in.com

Utility Plan
Liberty Elementary and Middle Schools - Duneland School Corp.
Liberty Township, Porter County, Indiana

DESIGNED: RSP
PROJECT NO.: D0528-59-0134.00
DATE: September 24, 2009
SHEET NO.

DRAWN: RSP
PROJECT NO.: D0528-59-0134.00
DATE: September 24, 2009
SHEET NO.

C300