




REVISIONS	BY

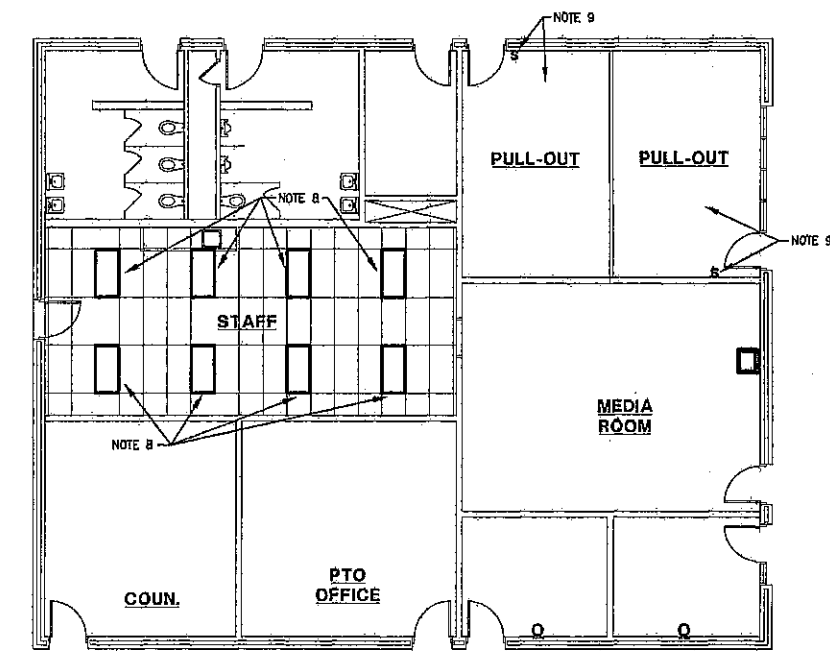

LIGHTING PLAN - EXISTING BUILDING
1/8" = 1'-0"
NORTH

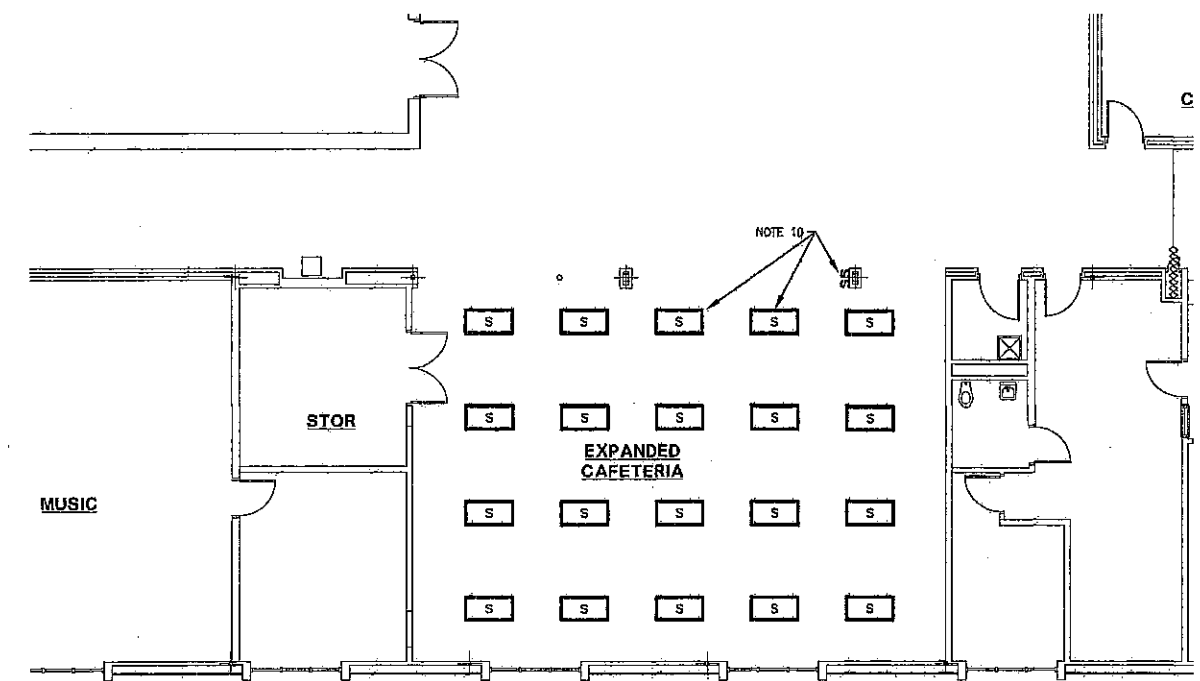


LIGHTING PLAN - EXISTING BUILDING
1/8" = 1'-0"
NORTH

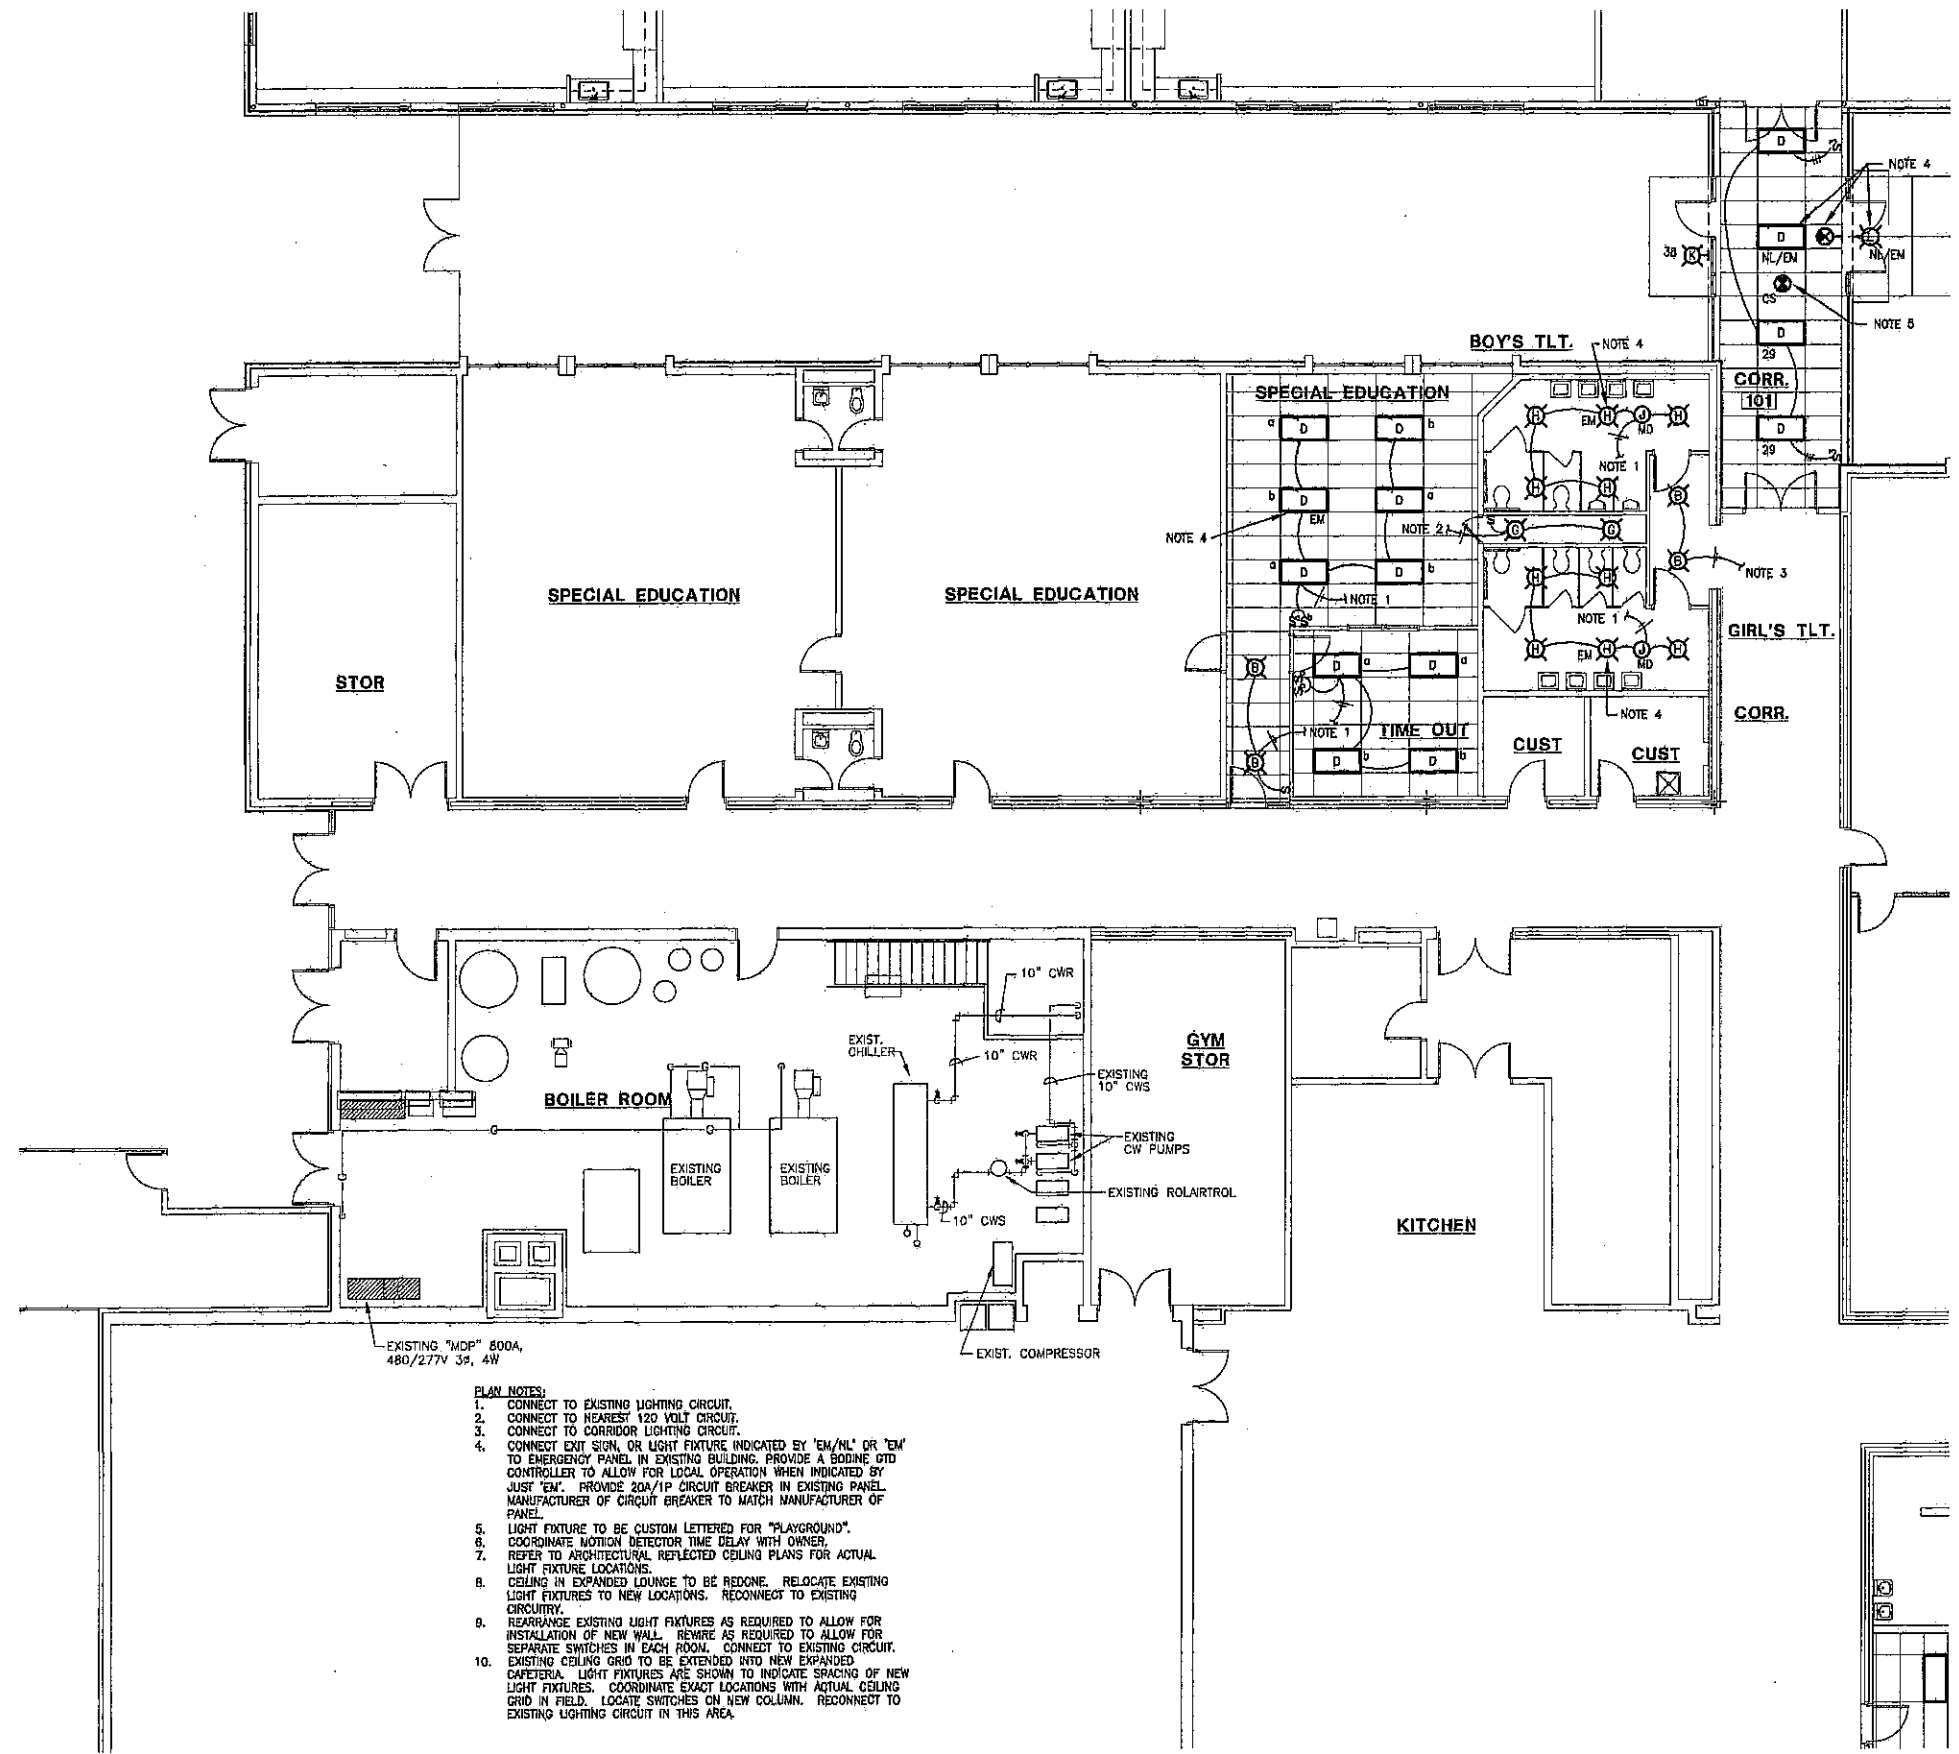


LIGHTING PLAN - EXISTING BUILDING
1/8" = 1'-0"
NORTH

- PLAN NOTES:**
1. CONNECT TO EXISTING LIGHTING CIRCUIT.
 2. CONNECT TO NEAREST 120 VOLT CIRCUIT.
 3. CONNECT TO CORRIDOR LIGHTING CIRCUIT.
 4. CONNECT EXIST. SIGN OR LIGHT FIXTURE INDICATED BY "EM/ML" OR "EM" TO EMERGENCY PANEL. IN EXISTING BUILDING, PROVIDE A SODING LTD CONTROLLER TO ALLOW FOR LOCAL OPERATION WHEN INDICATED BY "JUST EM". PROVIDE 20A/1P CIRCUIT BREAKER IN EXISTING PANEL. MANUFACTURER OF CIRCUIT BREAKER TO MATCH MANUFACTURER OF PANEL.
 5. LIGHT FIXTURE TO BE CUSTOM LETTERED FOR "PLAYGROUND".
 6. COORDINATE MOTION DETECTOR TIME DELAY WITH OWNER.
 7. REFER TO ARCHITECTURAL REFLECTED CEILING PLANS FOR ACTUAL LIGHT FIXTURE LOCATIONS.
 8. CEILING IN EXPANDED LOUNGE TO BE REDONE. RELOCATE EXISTING LIGHT FIXTURES TO NEW LOCATIONS. RECONNECT TO EXISTING CIRCUITRY.
 9. REARRANGE EXISTING LIGHT FIXTURES AS REQUIRED TO ALLOW FOR INSTALLATION OF NEW WALL. REWIRE AS REQUIRED TO ALLOW FOR SEPARATE SWITCHES IN EACH ROOM. CONNECT TO EXISTING CIRCUIT.
 10. EXISTING CEILING GRID TO BE EXTENDED INTO NEW EXPANDED CAFETERIA. LIGHT FIXTURES ARE SHOWN TO INDICATE SPACING OF NEW LIGHT FIXTURES. COORDINATE EXACT LOCATIONS WITH ACTUAL CEILING GRID IN FIELD. LOCATE SWITCHES ON NEW COLUMN. RECONNECT TO EXISTING LIGHTING CIRCUIT IN THIS AREA.

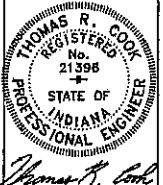

LIBERTY ELEMENTARY SCHOOL
EARLY LEARNING CENTER ADDITION & REMODEL
50-1 W. COUNTY ROAD 900 N.
CHESTERTON, INDIANA 46515
gerometta & kinel architects, inc.

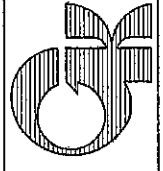

DATE	8-24-08
SCALE	
DRAWN	
JOB	2814
SHEET	