


PLAN NOTES:
1. ALL FURNITURE, DUCTWORK AND DIFFUSERS FROM THIS PROJECT WILL BE PROVIDED BY THE CLIENT. THE MECHANICAL ROOM PROVIDES A 4 TON FLOWER COIL UNIT WITH DX COOLING COIL AND HEATING WATER COIL. UNIT TO HAVE AIR COOLED CONDENSING UNIT LOCATED OUTSIDE. PROVIDE DUCTWORK AND DRAINAGE THROUGH ROOF. PROVIDE DUCTWORK AND DIFFUSERS.

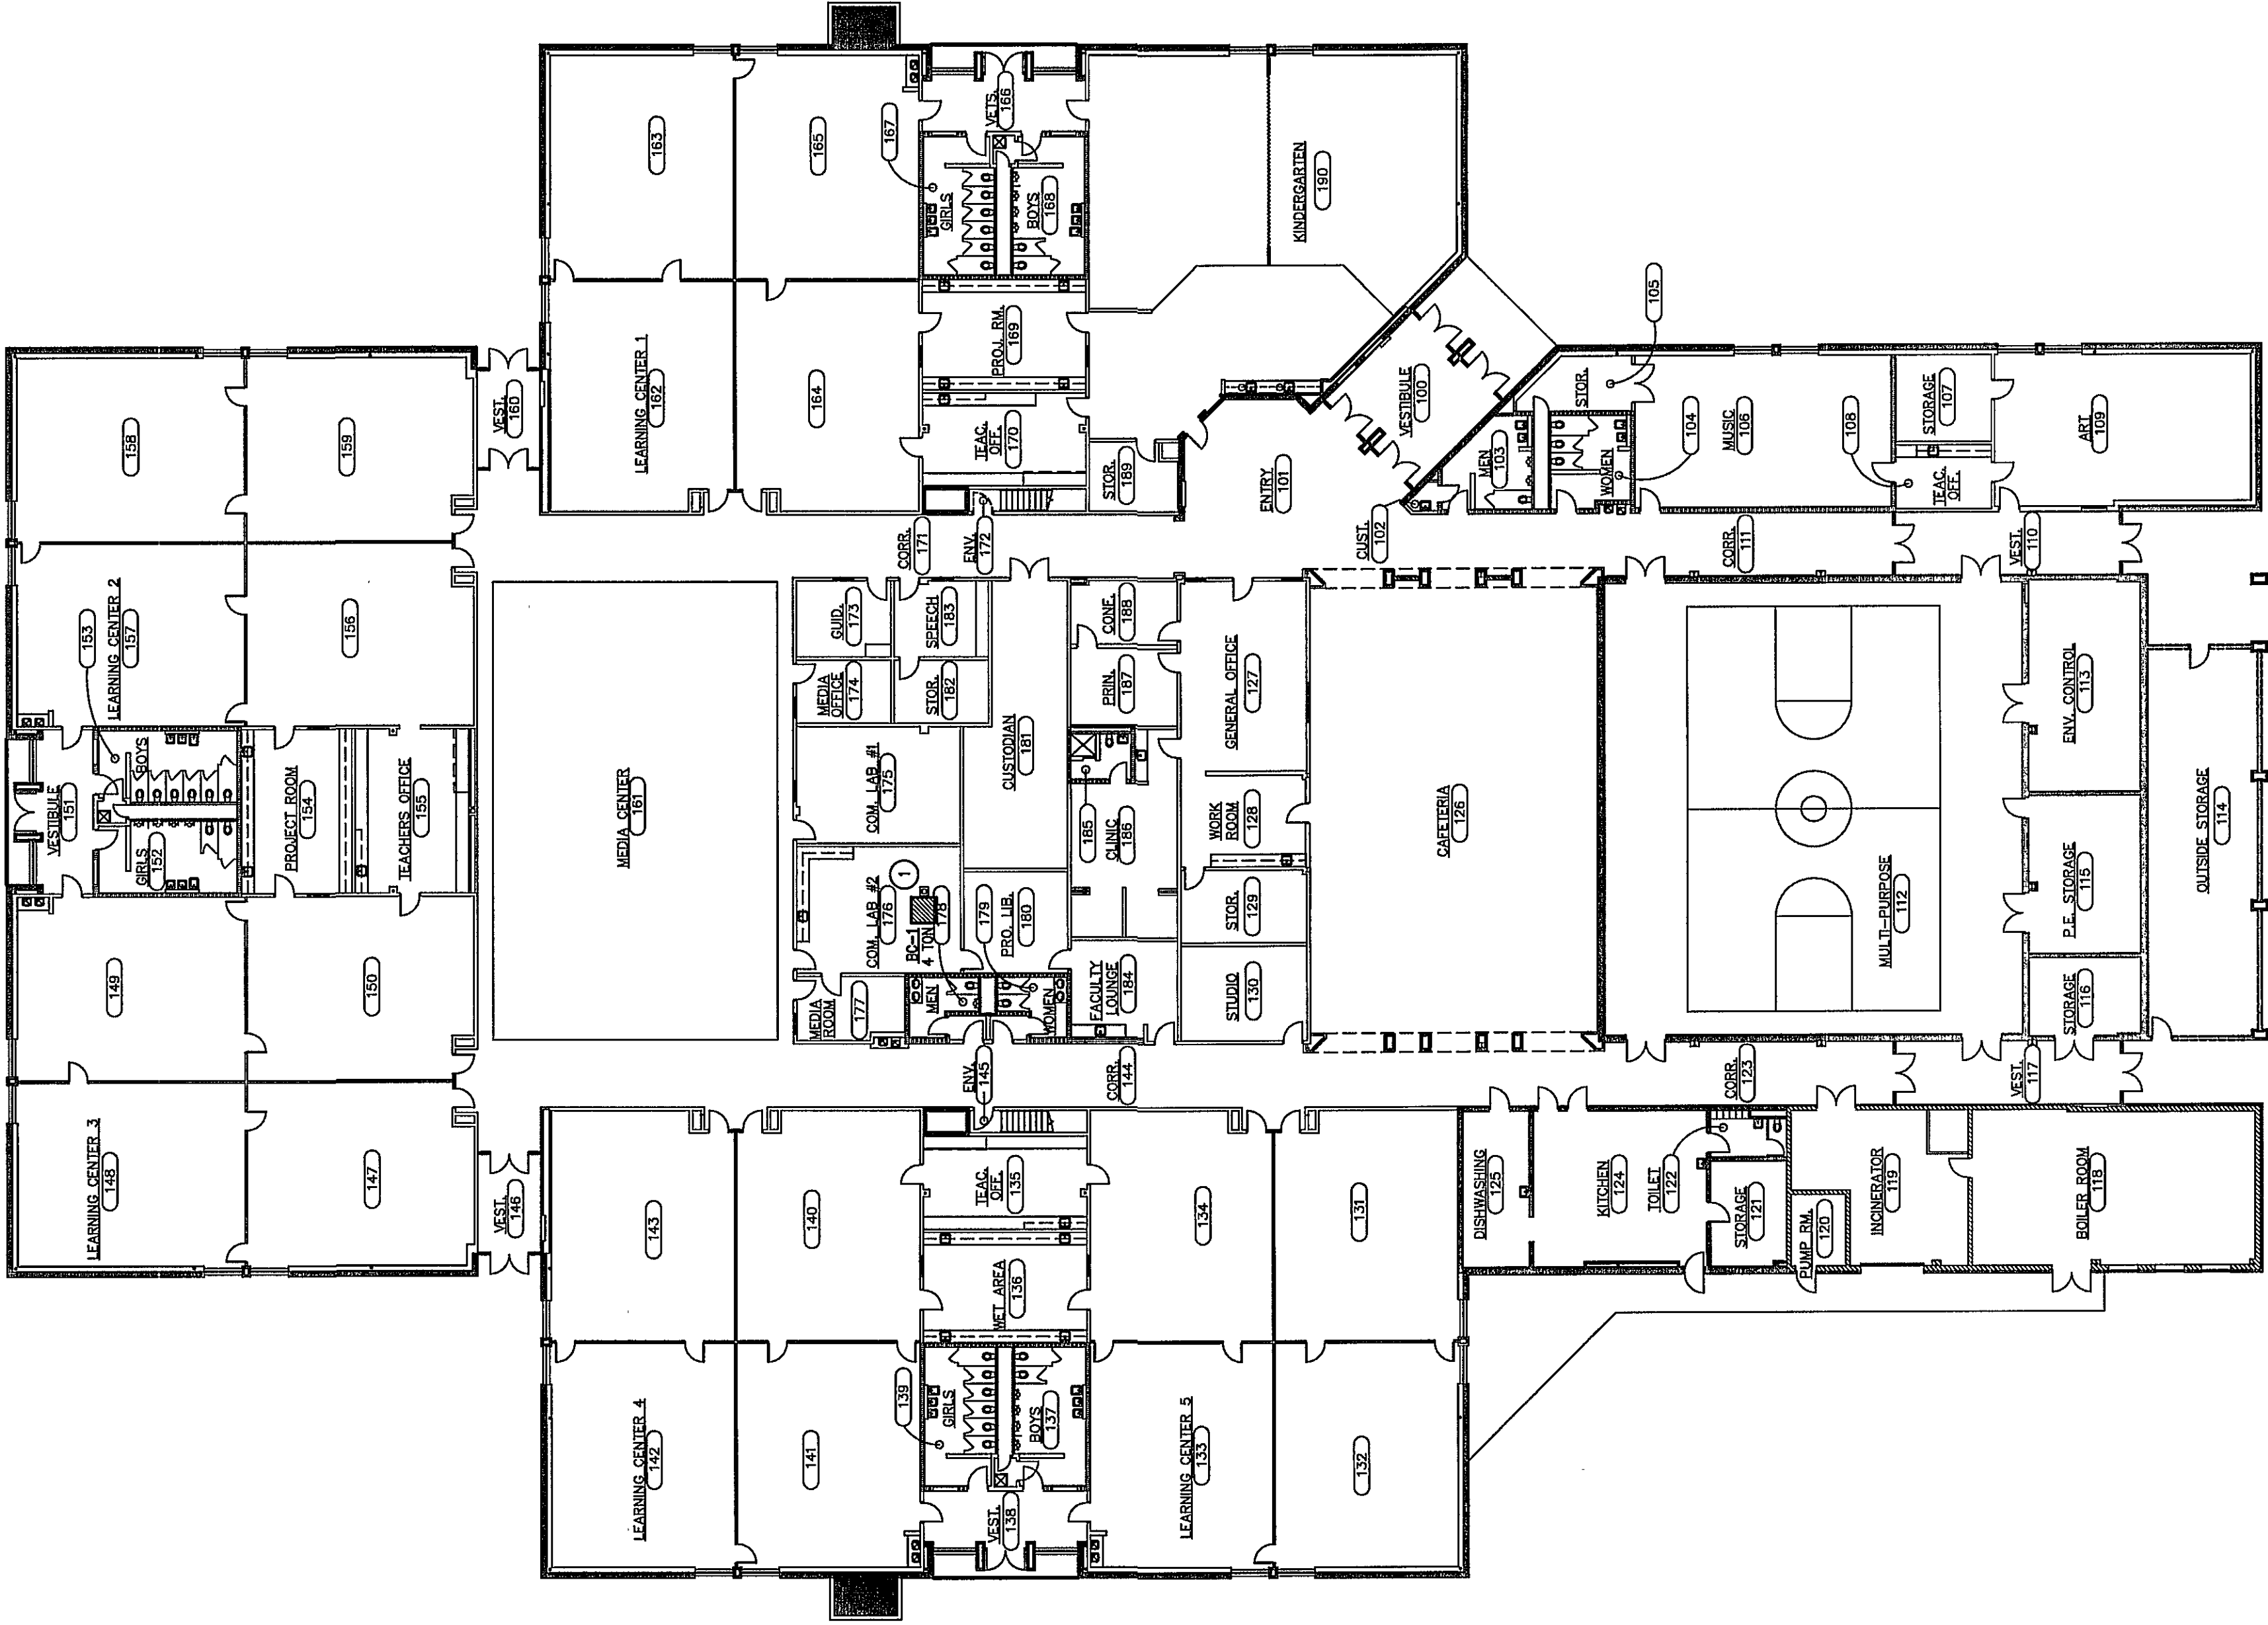

MECHANICAL PLAN
1/16" = 1'-0"

MECHANICAL
PLAN
Sheet No. M1.1

MECHANICAL RENOVATIONS
to the
JACKSON ELEMENTARY SCHOOL
Valparaiso, Indiana

Honeywell
The Precedent
9355 Delegates Row
Indianapolis, IN 46240