




PROJECT NUMBER: 14-005	REVISIONS:
PROJECT MANAGER: JF	1
DRAWN BY: JF	2
DATE FOR PROPOSAL: 06/02/2014	3
ADMINISTRATION / MAINTENANCE BUILDING	4
FIRST FLOOR PLAN - POWER	5

GENERAL NOTES

- ALL DEVICES IN UNFINISHED STORAGE AND GARAGE SPACES SHALL BE MOUNTED TO STEEL FRAMING ONLY. HOLES SHALL NOT BE CUT INTO THE METAL BUILDING.
- SURFACE MOUNTED RACEWAYS SHALL BE PROVIDED AT ALL OCCUPIED SPACES - COLOR TO BE SELECTED BY ARCHITECT
- SURFACE MOUNTED CONDUIT AND KNOCK BOXES ARE TO BE PROVIDED AT ALL STORAGE AND GARAGE SPACES.
- PANEL LOCATIONS SHALL BE VERIFIED IN FIELD BY CONTRACTOR

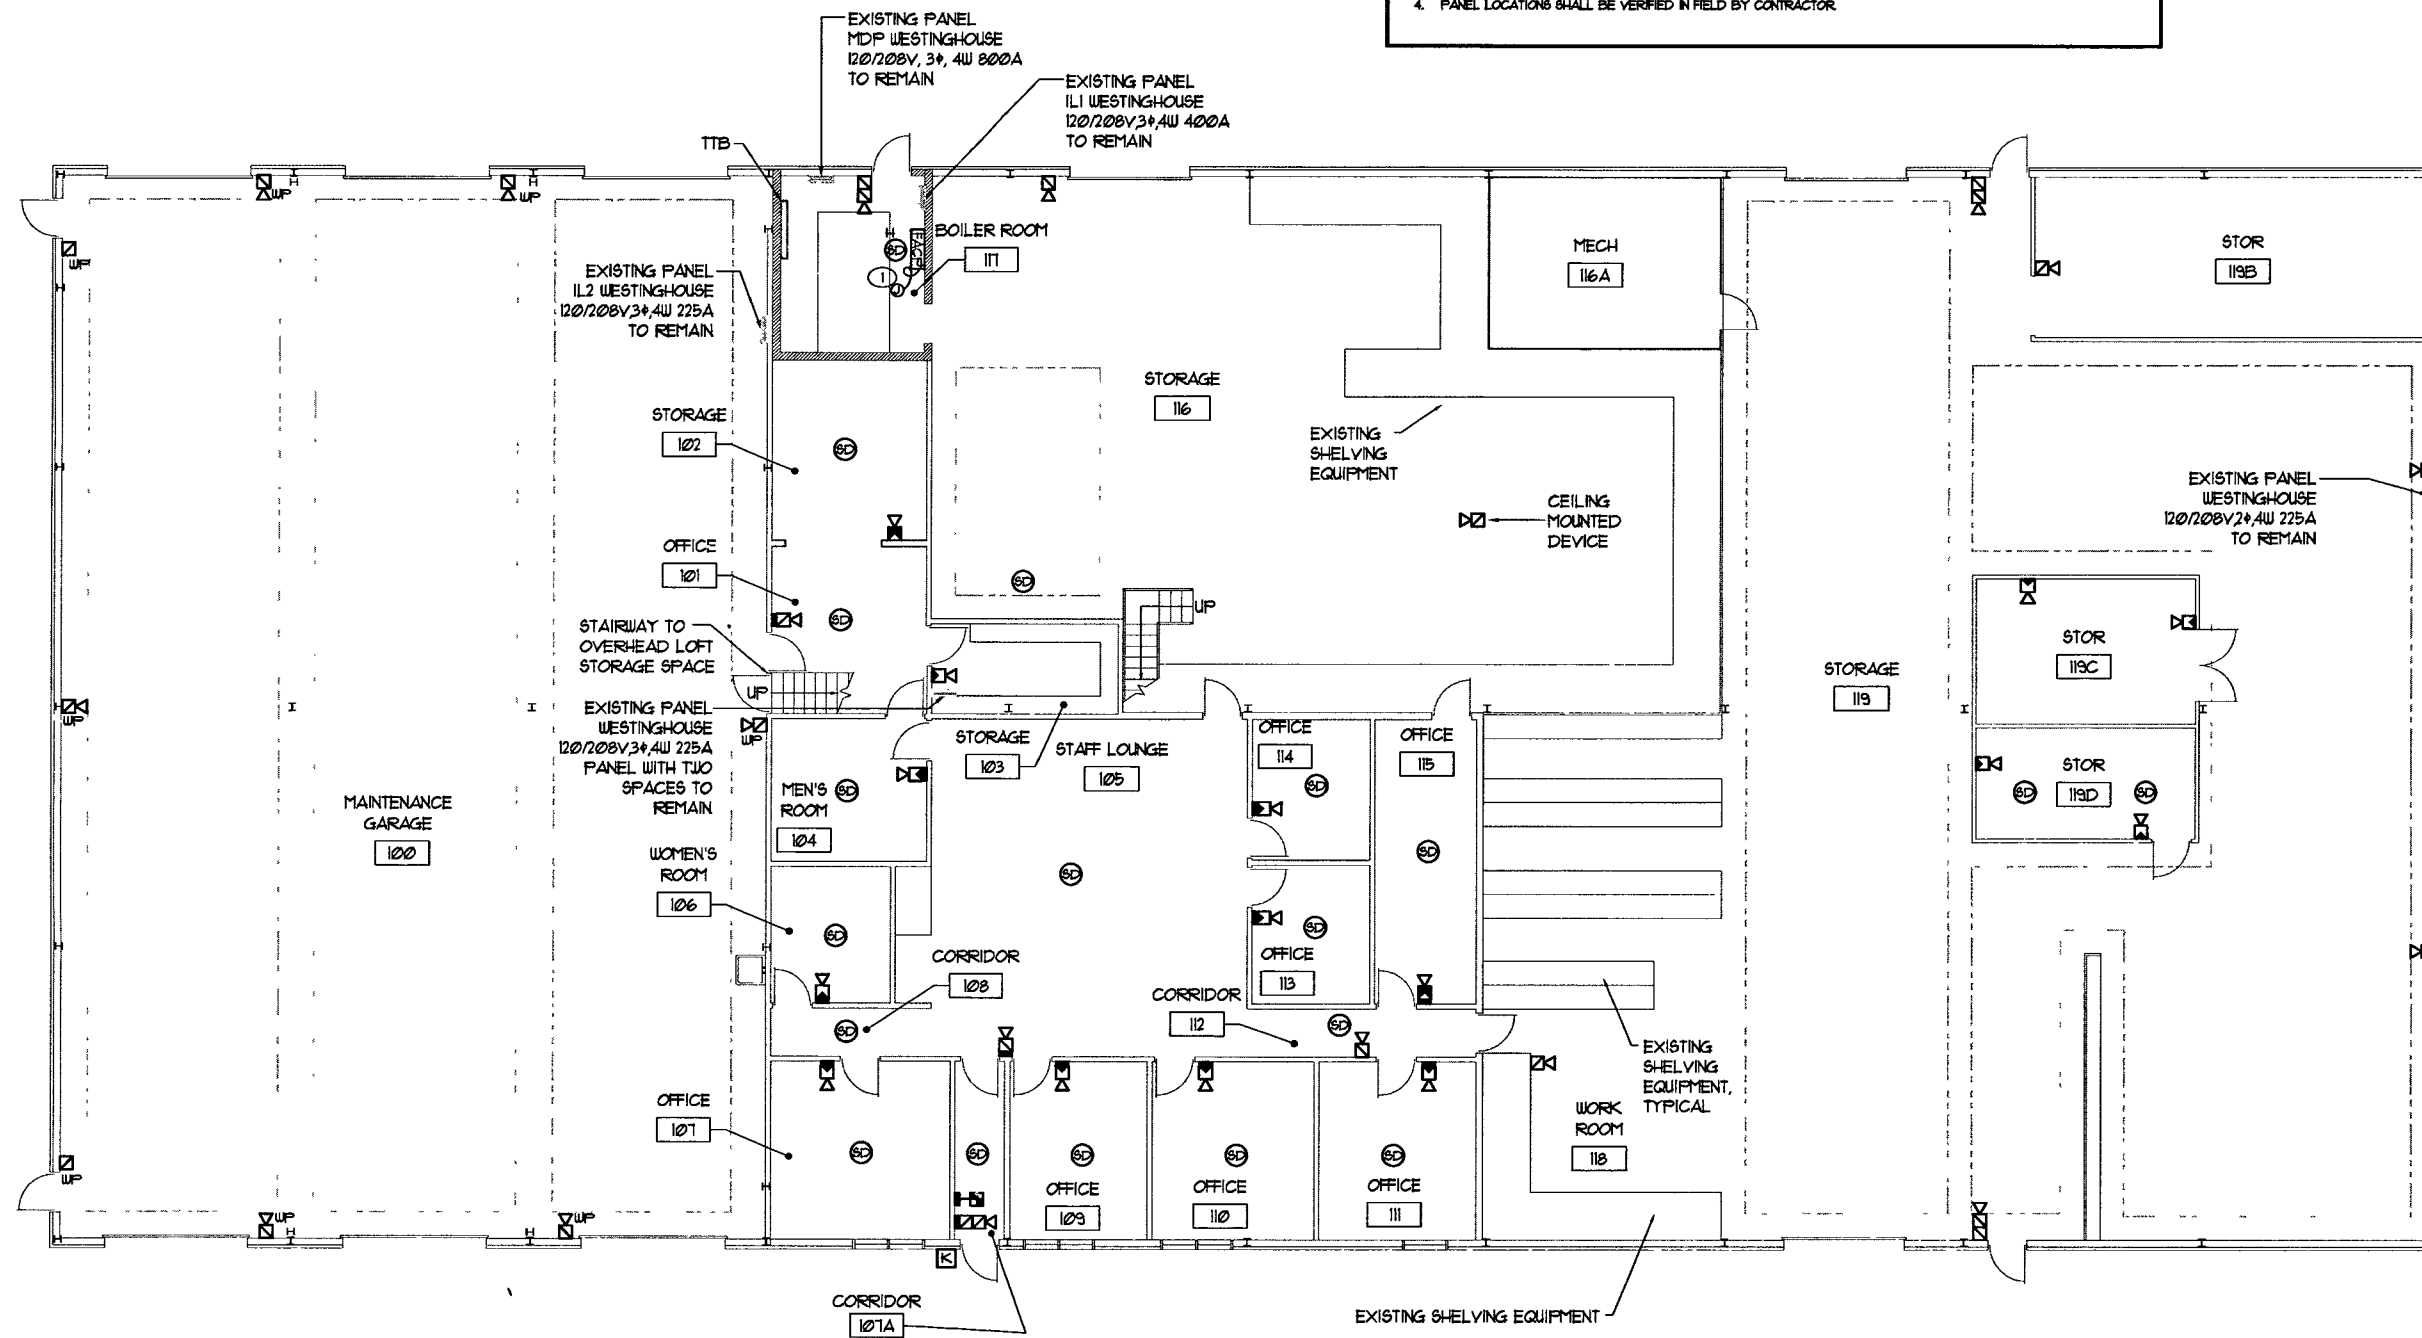

SHEET NOTES

- ROUTE 4 #2 @ 1 #2 GRD - 3/4" C. CONCEALED ABOVE ACCESSIBLE CEILING TO TWO (2) NEW 20A/1P LOCK-ON TYPE CIRCUIT BREAKERS IN AVAILABLE SPACE OF EXISTING WESTINGHOUSE 120/208V PANEL LOCATED IN STORAGE ROOM 103. VERIFY POWER REQUIREMENTS WITH MANUFACTURER AND EXISTING CONDITIONS AND REQUIREMENTS IN FIELD PRIOR TO ROUGH-IN. COMPLETE AS REQUIRED

1 ADMINISTRATION/MAINTENANCE BUILDING - FIRST FLOOR PLAN- POWER
1/8" = 1'-0"

