


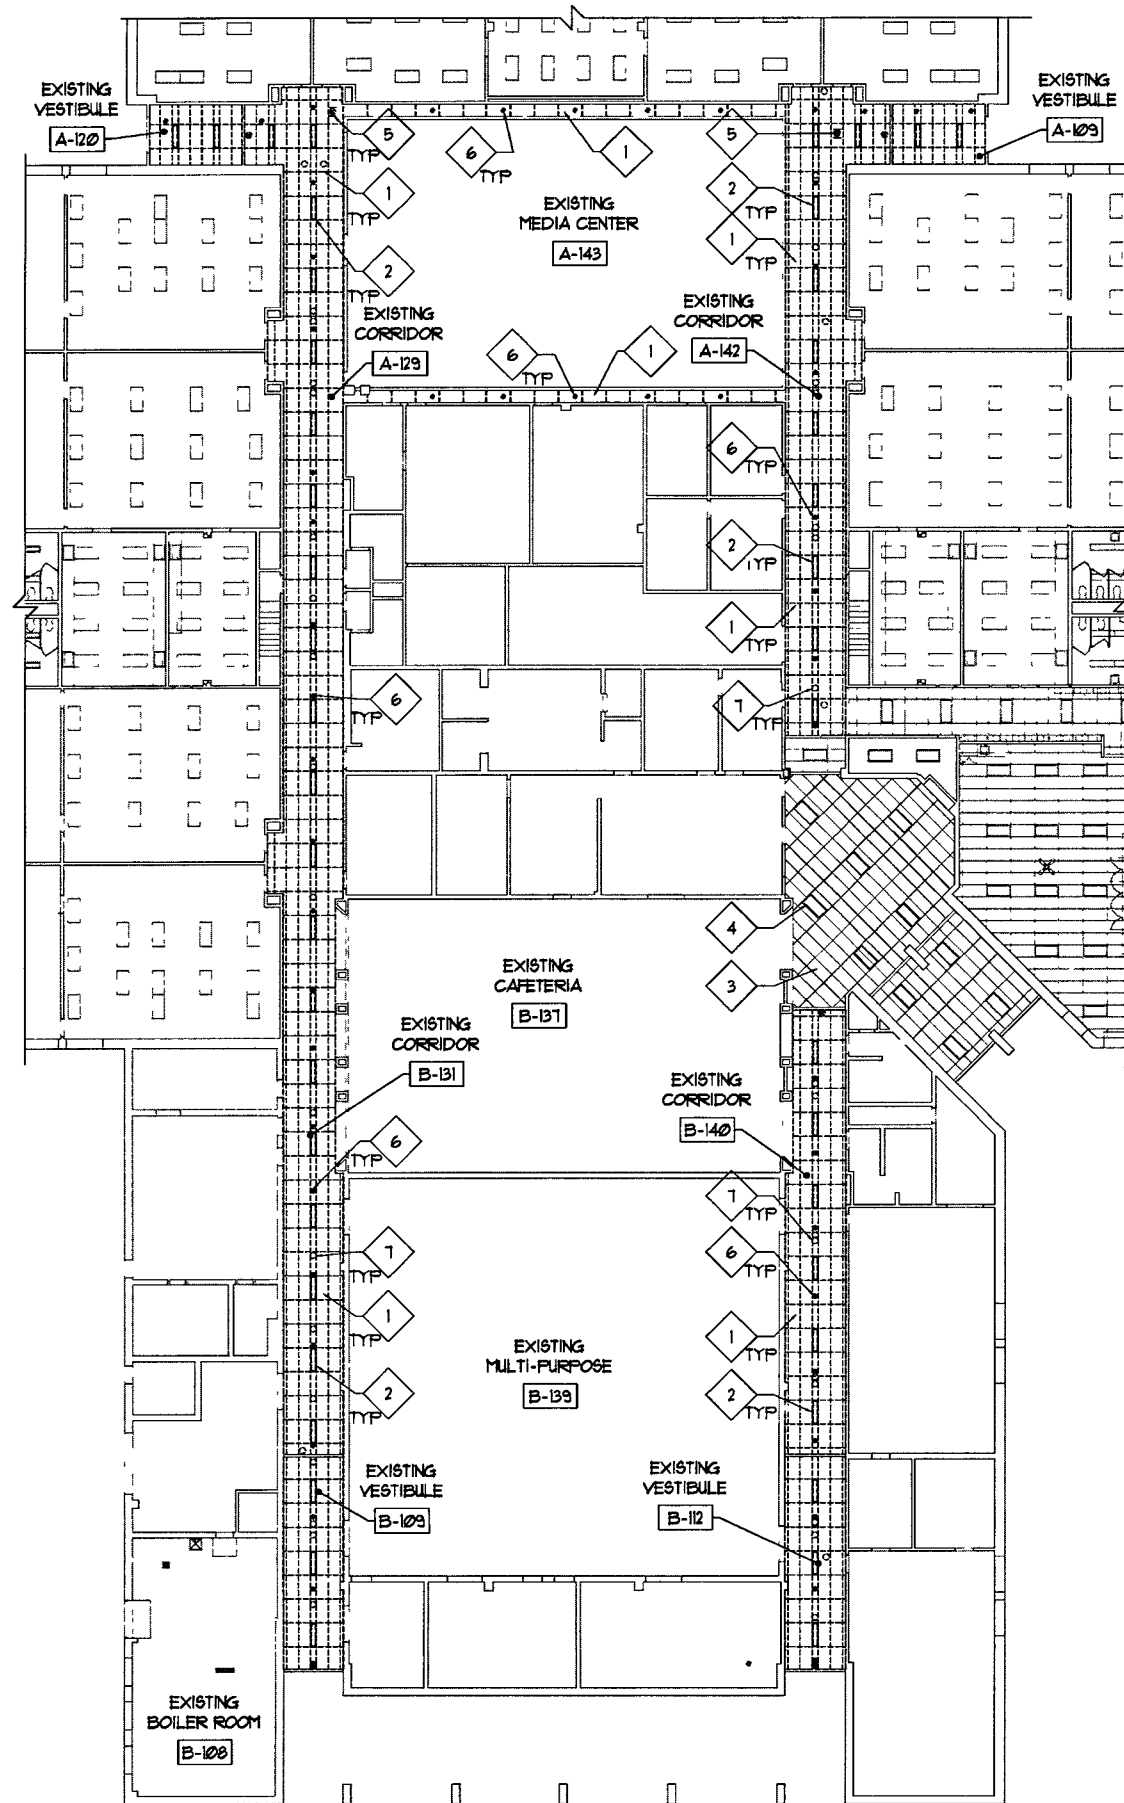


REFLECTED CEILING PLAN GENERAL NOTES

1. VERIFY EXACT DIMENSIONS OF ALL EXISTING CONDITIONS IN FIELD.
2. ALL CONTRACTORS SHALL REPORT ALL DISCREPANCIES OR DIMENSIONAL QUESTIONS TO THE ATTENTION OF THE ARCHITECT PRIOR TO INSTALLATION.
3. REFER TO PROJECT MANUAL FOR PRODUCTS, MATERIALS, PROCEDURES AND ADDITIONAL INFORMATION NOT COVERED IN DRAWINGS.
4. PROTECT ALL EXISTING FINISHES, EQUIPMENT, AND ADJACENT WORK SCHEDULED TO REMAIN FROM DAMAGE DURING CONSTRUCTION. ANY DAMAGED FINISHES, EQUIPMENT, OR ADJACENT SURFACES SHALL BE REPAIRED OR REPLACED BY CONTRACTOR AT NO ADDITIONAL COST TO OWNER.
5. REFER TO ELECTRICAL DRAWINGS FOR ADDITIONAL INFORMATION.
6. REMOVE EXISTING CEILING SYSTEMS NOT SHOWN AS NECESSARY TO PROVIDE WORK INDICATED.
7. CEILING WORK ON CORRIDORS IS BY ALTERNATE BID.


REFLECTED CEILING PLAN REFERENCED NOTES

(NOT ALL NOTES WILL BE REFERENCED ON ALL SHEETS)

1. EXISTING CEILING SYSTEM TO BE REMOVED
2. EXISTING LIGHT FIXTURES TO BE REMOVED - REFER TO ELECTRICAL DRAWINGS
3. EXISTING CEILING SYSTEM TO REMAIN
4. EXISTING LIGHT FIXTURES TO REMAIN
5. EXISTING EXIT LIGHTS TO BE REMOVED REFER TO FIRE PROTECTION DRAWINGS
6. EXISTING SPRINKLER HEADS TO BE REMOVED - REFER TO FIRE PROTECTION DRAWINGS
7. EXISTING FIRE ALARM SYSTEM DEVICES TO BE REMOVED - REFER TO ELECTRICAL DRAWINGS

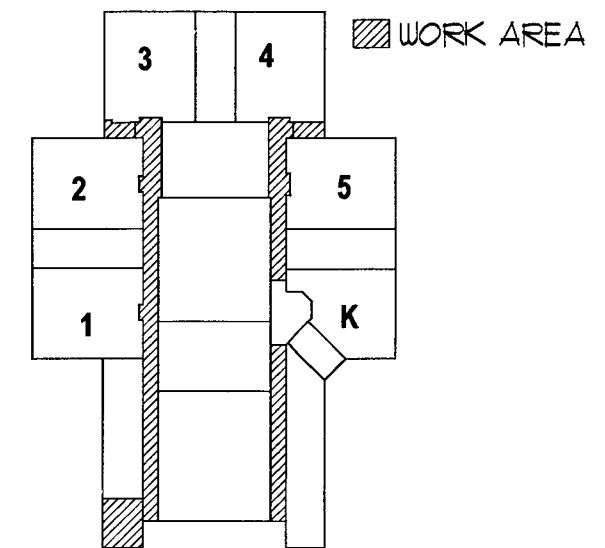

KEY PLAN
NOT TO SCALE

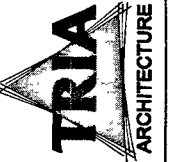

MEP ENGINEER
Miles Engineering Group
1111 N. 400 E. VALPARAISO, IN. 46383
(765) 463-4400
(765) 463-4401

DUNELAND SCHOOL CORPORATION
2017 MECHANICAL RENOVATIONS AT:
JACKSON ELEMENTARY SCHOOL
811 N. 400 E. VALPARAISO, IN. 46383



PROJECT NUMBER: 11-006	REVISIONS:
PROJECT MANAGER: TS	1. 09/15/2017
DRAWN BY:	2. 09/15/2017
DESIGNED FOR BID: 09/15/2017	3. 09/15/2017
EXISTING FIRST FLOOR REFLECTIVE CEILING PLAN	



Expires 12/31/2017

A0.11

1 EXISTING FIRST FLOOR REFLECTED CEILING PLAN
1/16" = 1'-0"

