



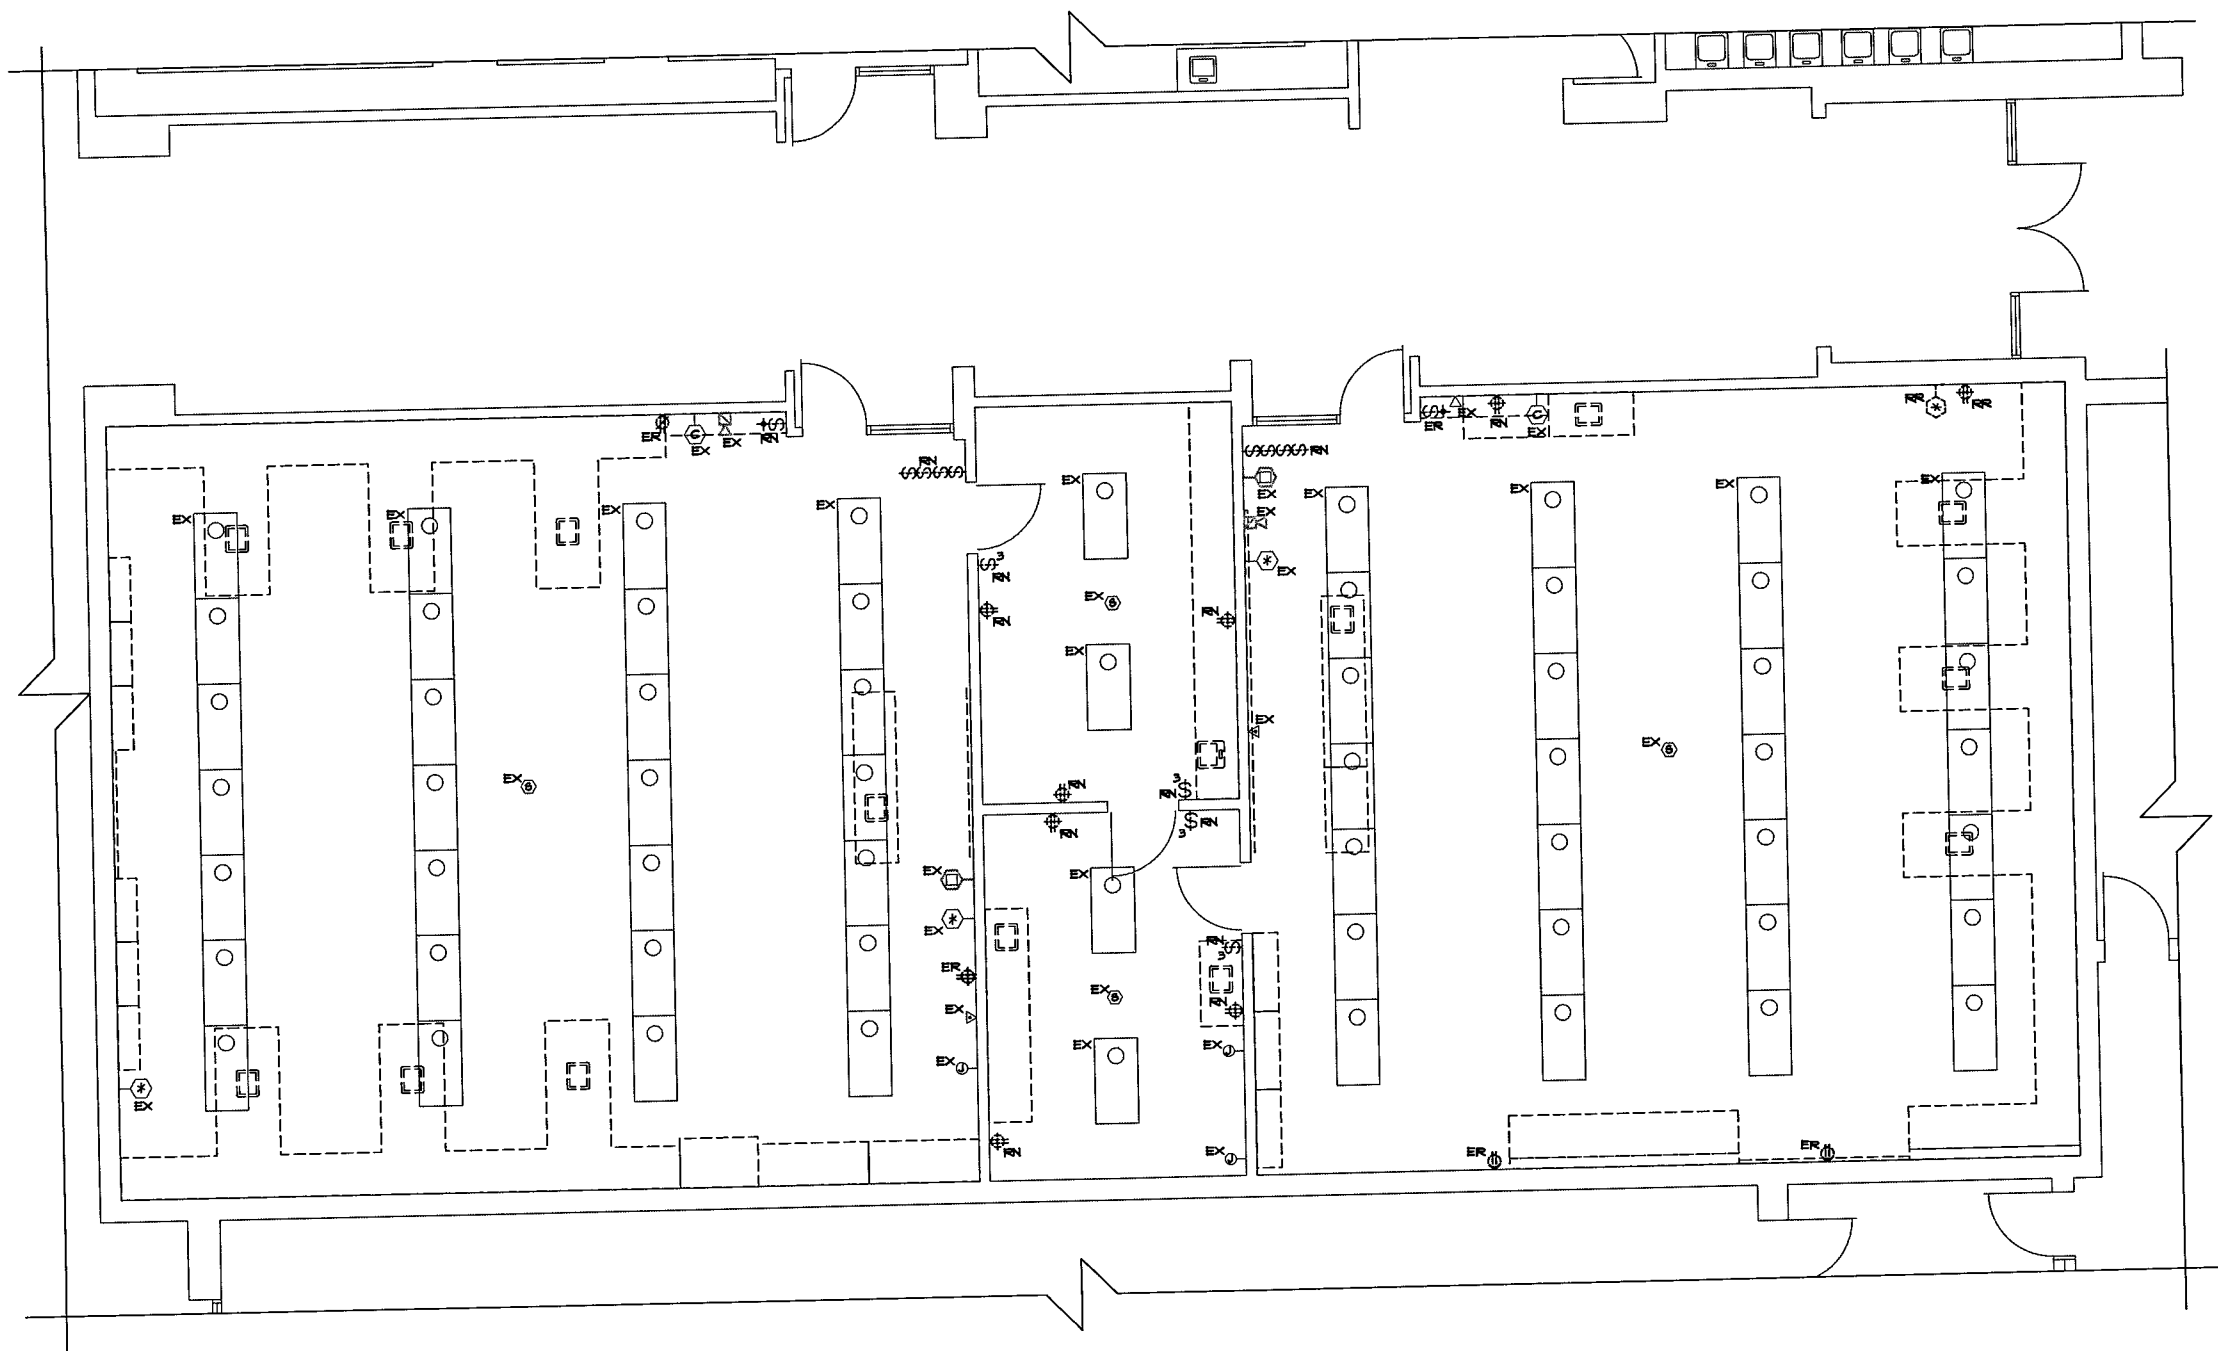

1 PARTIAL FIRST FLOOR PLAN - ELECTRICAL DEMOLITION
1/4" = 1'-0"

- SHEET NOTES**
1. APPROXIMATE LOCATION OF EXISTING 120/208V, 3Ø, 4W ELECTRICAL PANEL LPA WITH THIRTY-TWO (32) SPACES. VERIFY EXACT LOCATION IN FIELD
 2. APPROXIMATE LOCATION OF EXISTING 120/208V, 3Ø, 4W ELECTRICAL PANEL L-3 WITH TWENTY-FOUR (24) SPACES. VERIFY EXACT LOCATION IN FIELD
 3. APPROXIMATE LOCATION OF EXISTING IDF SERVING AREA. VERIFY EXACT LOCATION IN FIELD
 4. APPROXIMATE LOCATION OF EXISTING NOTIFIER FACP. VERIFY EXACT LOCATION IN FIELD

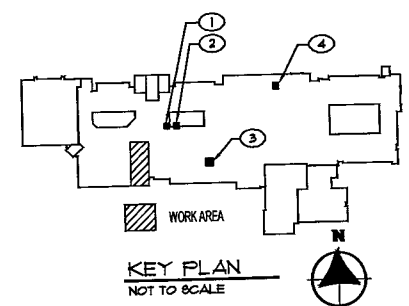

Miles Engineering Group
1111 W. MORGAN AVENUE, SUITE 100
CHESTERTON, INDIANA 46304
TEL: 219.326.1000
FAX: 219.326.1001
WWW.MILES-ENGINEERING.COM

DUNELAND SCHOOL CORPORATION
2017 SCIENCE LAB RENOVATIONS AT:
CHESTERTON MIDDLE SCHOOL
651 W. MORGAN AVENUE, CHESTERTON, INDIANA 46304

REVISIONS	DATE	BY	DESCRIPTION
1	08/01/2017	TRIA	ISSUED FOR BIDDING
2	08/01/2017	TRIA	ISSUED FOR BIDDING
3	08/01/2017	TRIA	ISSUED FOR BIDDING
4	08/01/2017	TRIA	ISSUED FOR BIDDING
5	08/01/2017	TRIA	ISSUED FOR BIDDING
6	08/01/2017	TRIA	ISSUED FOR BIDDING
7	08/01/2017	TRIA	ISSUED FOR BIDDING
8	08/01/2017	TRIA	ISSUED FOR BIDDING
9	08/01/2017	TRIA	ISSUED FOR BIDDING
10	08/01/2017	TRIA	ISSUED FOR BIDDING

E0.10