


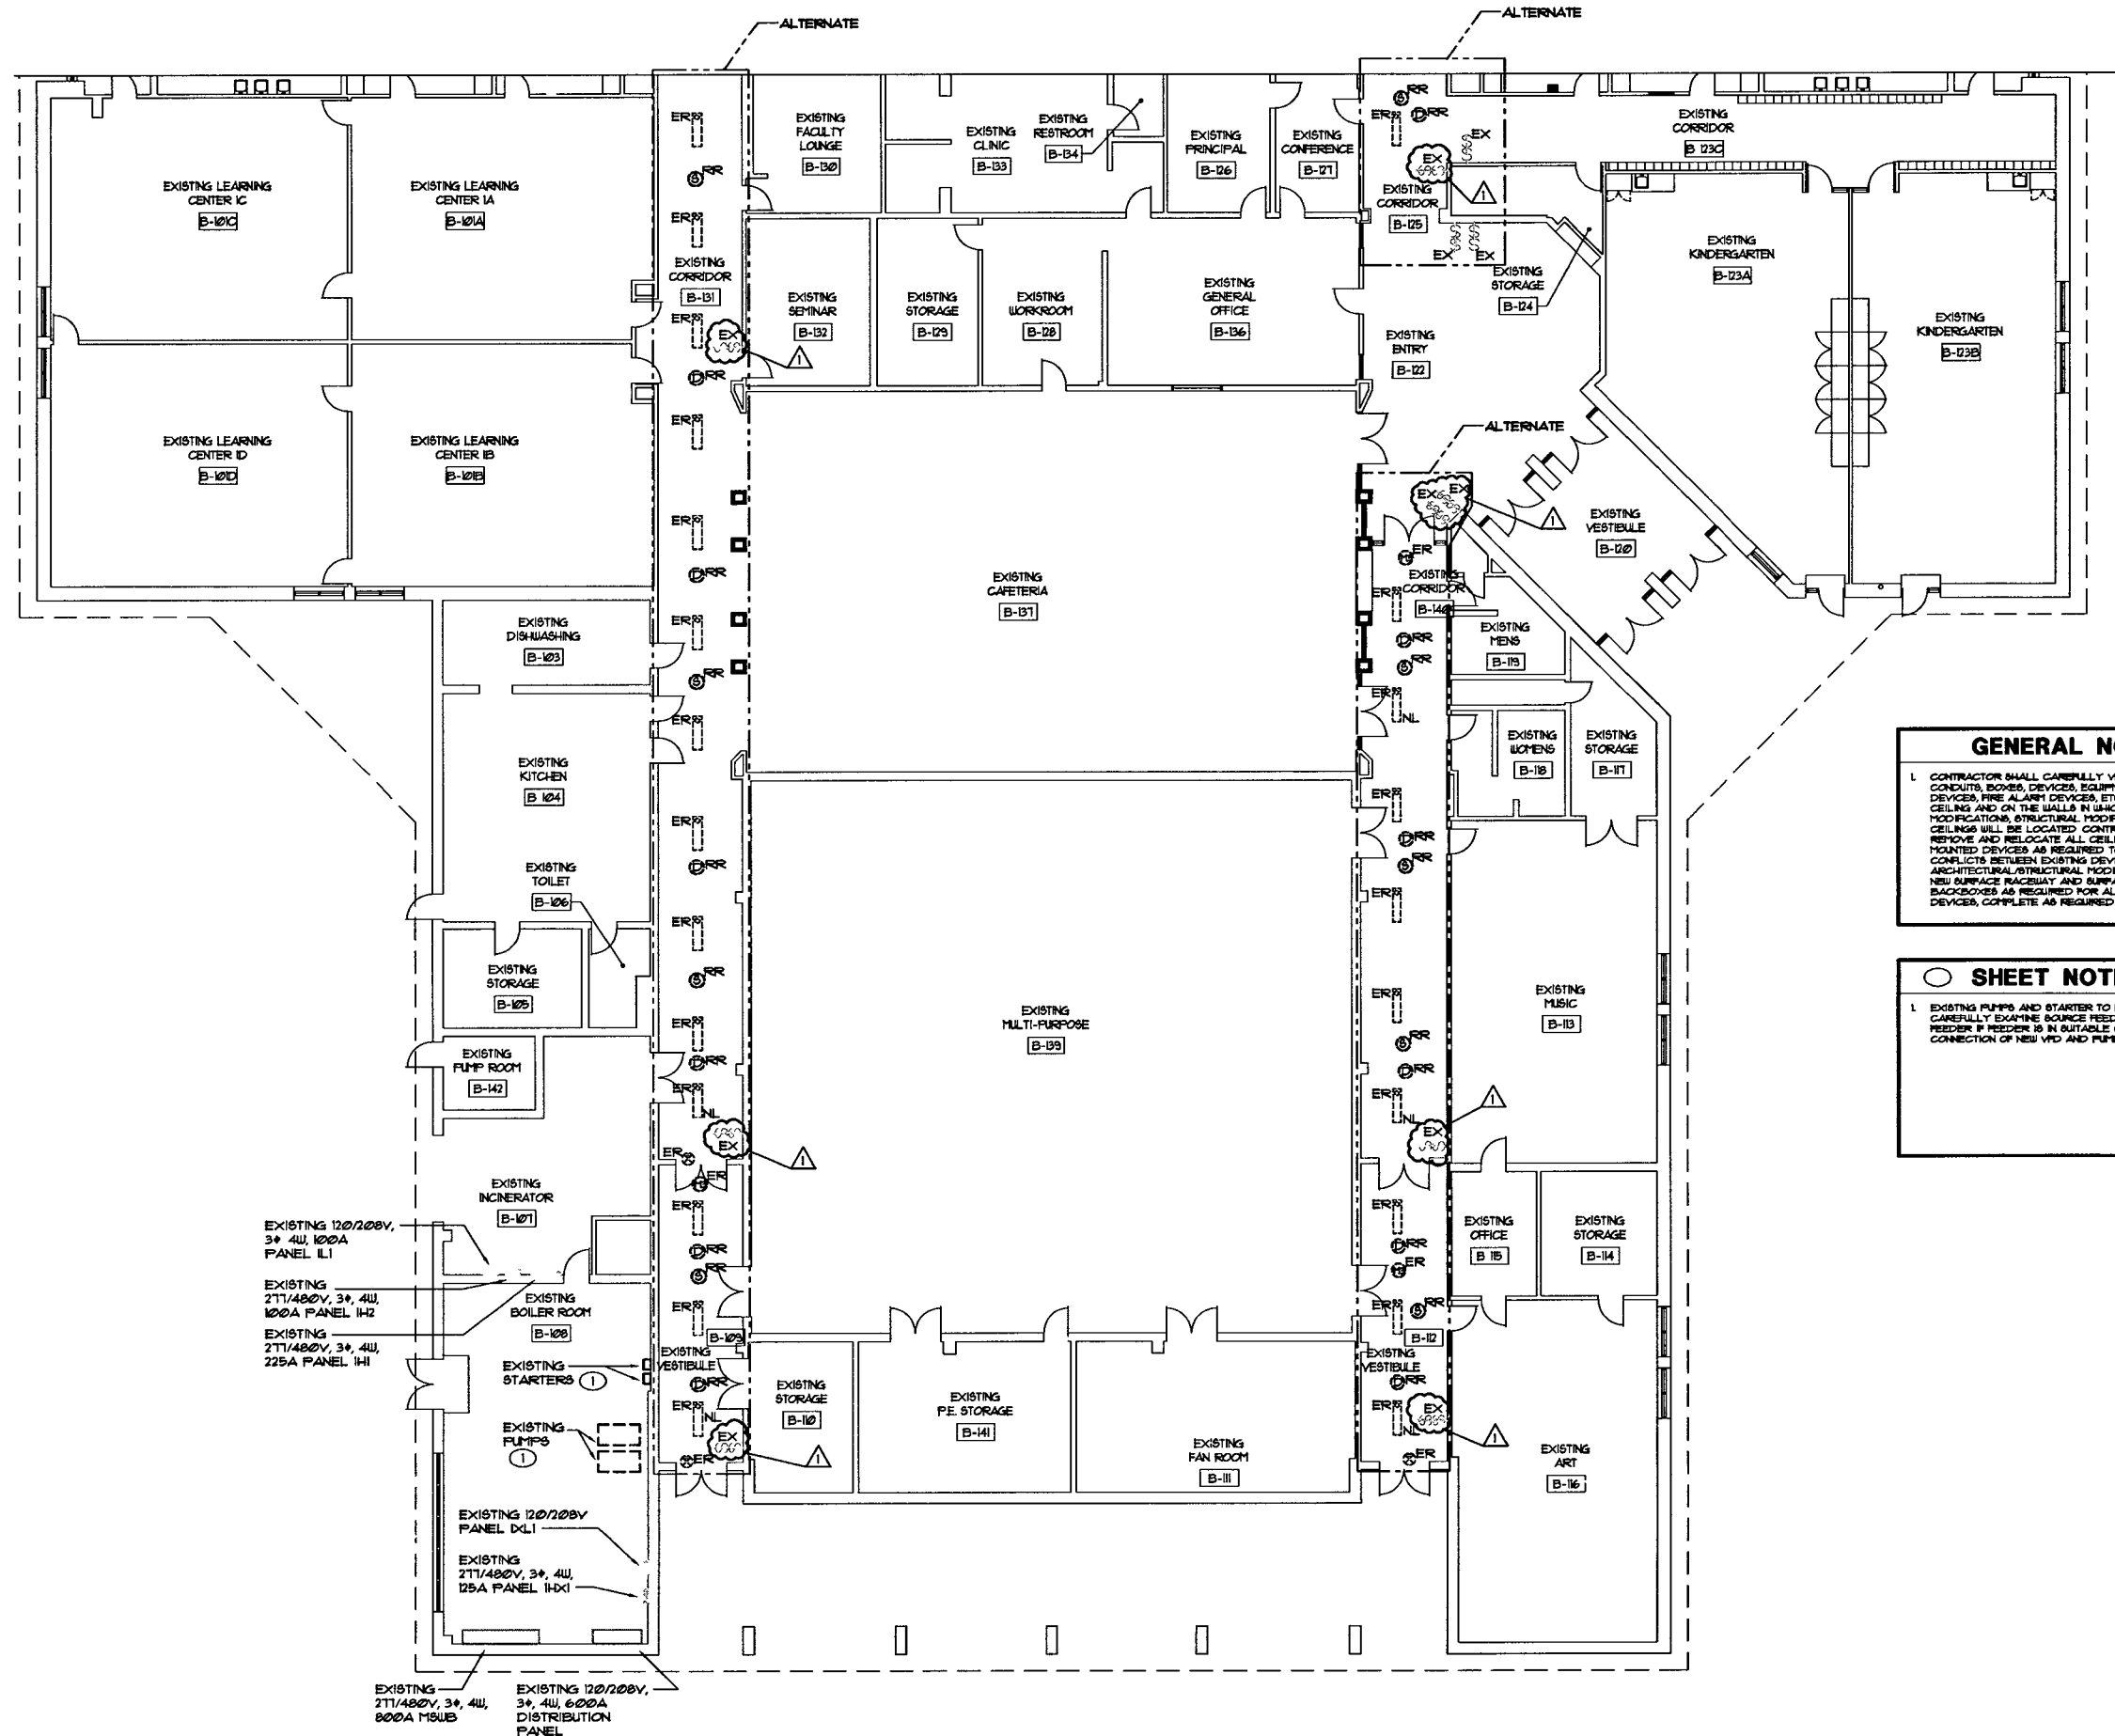

GENERAL NOTES

1. CONTRACTOR SHALL CAREFULLY VERIFY EXISTING CONDUITS, BOXES, DEVICES, EQUIPMENT LOW VOLTAGE DEVICES, FIRE ALARM DEVICES, ETC. LOCATED ON THE CEILING AND ON THE WALLS IN WHICH ARCHITECTURAL MODIFICATIONS, STRUCTURAL MODIFICATION OR NEW CEILING WILL BE LOCATED. CONTRACTOR SHALL REMOVE AND RELOCATE ALL CEILING AND WALL MOUNTED DEVICES AS REQUIRED TO ELIMINATE CONFLICTS BETWEEN EXISTING DEVICES AND ARCHITECTURAL/STRUCTURAL MODIFICATIONS. PROVIDE NEW SURFACE RACEWAY AND SURFACE RACEWAY BACKBOXES AS REQUIRED FOR ALL RELOCATED DEVICES, COMPLETE AS REQUIRED.

SHEET NOTES

1. EXISTING PUMPS AND STARTERS TO BE REMOVED. CAREFULLY EXAMINE SOURCE FEEDER AND RETAIN FEEDER IF FEEDER IS IN SATISFACTORY CONDITION FOR CONNECTION OF NEW VFD AND PUMP.

1 EXISTING FIRST FLOOR PLAN - ELECTRICAL
3/32" = 1'-0"



TRIA ARCHITECTURE
10775 E. 14TH AVE.
SUITE 1000
DENVER, CO 80231
303.755.4400
FAX 303.755.4401

DUNELAND SCHOOL CORPORATION
2017 MECHANICAL RENOVATIONS AT:
JACKSON ELEMENTARY SCHOOL
811 N. 400 E. VALPARAISO, IN. 46383



WILLIAM A. HROMADSKY
REGISTERED PROFESSIONAL ENGINEER
No. 10708283
STATE OF INDIANA

REVISION	DATE	BY	CHKD
1	11/14/18	CH	
2	11/14/18	CH	
3	11/14/18	CH	
4	11/14/18	CH	
5	11/14/18	CH	
6	11/14/18	CH	
7	11/14/18	CH	
8	11/14/18	CH	
9	11/14/18	CH	
10	11/14/18	CH	

EXISTING FIRST FLOOR PLAN - ELECTRICAL

E0.10