


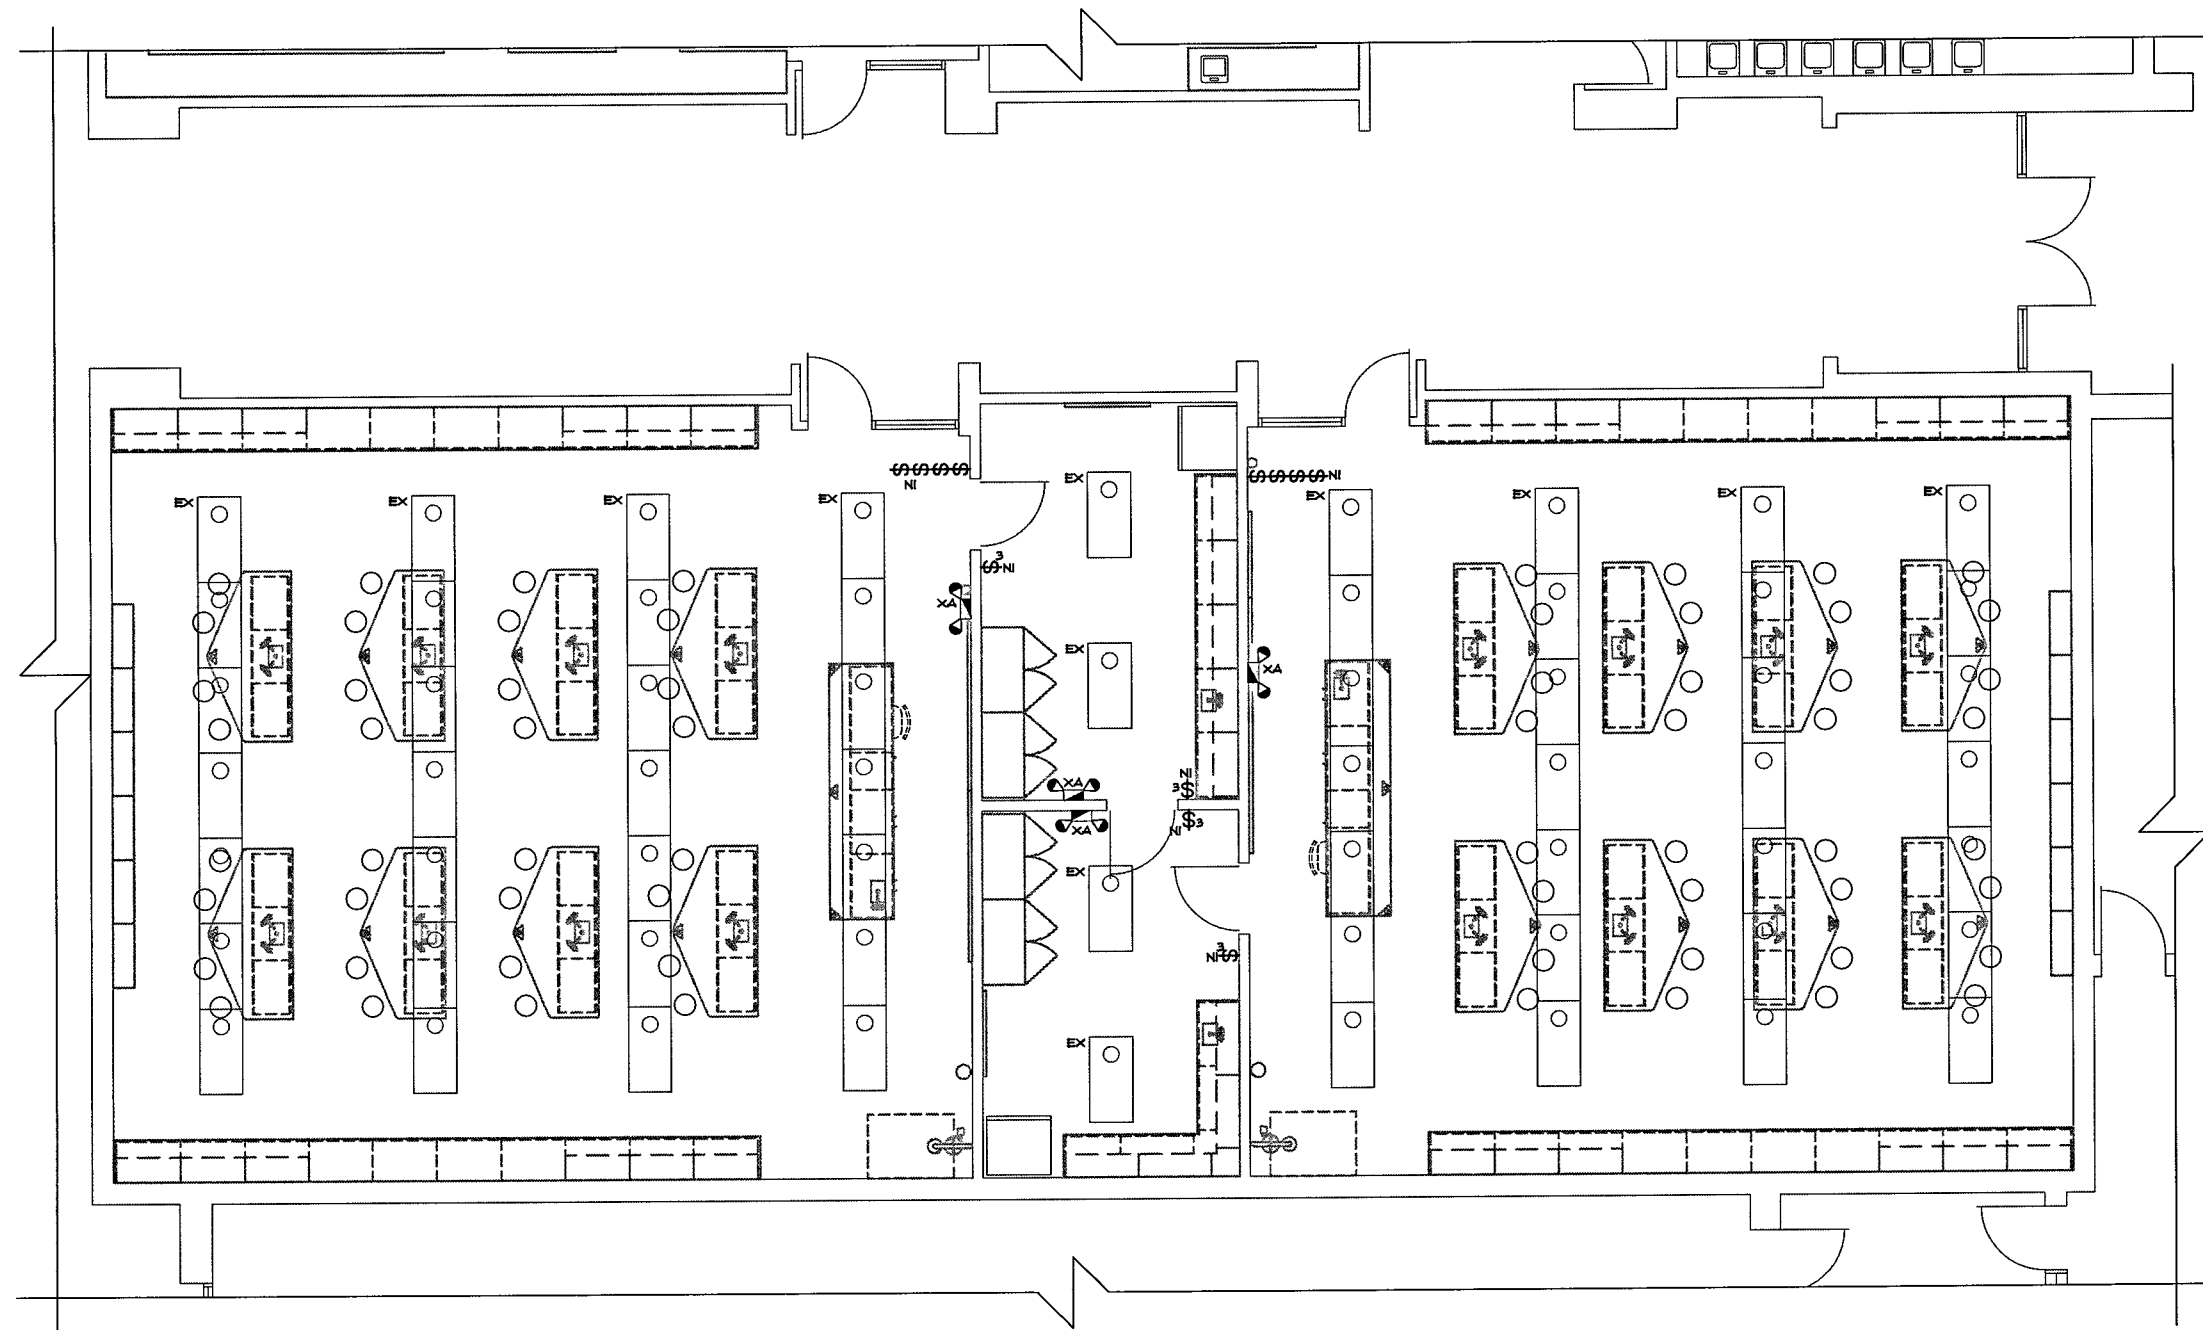


1 PARTIAL FIRST FLOOR PLAN - ELECTRICAL LIGHTING
1/4" = 1'-0"

GENERAL NOTES

1. NEW DEVICES OR FIXTURES ON EXISTING WALLS SHALL BE INSTALLED WITH NEW SURFACE RACEWAY BACKBOXES AND SHALL BE FED WITH NEW SURFACE RACEWAY. VERIFY EXACT SURFACE RACEWAY ROUTING WITH ARCHITECT PRIOR TO INSTALLATION.
2. EMERGENCY FIXTURES SHALL BE CONNECTED TO CONSTANT HOT, UNSWITCHED CIRCUIT FEEDING LIGHTING IN ROOM, AHEAD OF ANY SWITCHES, RELAYS OR CONTACTORS.

SHEET NOTES

1. APPROXIMATE LOCATION OF EXISTING 120/208V, 3Ø, 4W ELECTRICAL PANEL LPA WITH THIRTY-TWO (32) SPACES. VERIFY EXACT LOCATION IN FIELD.
2. APPROXIMATE LOCATION OF EXISTING 120/208V, 3Ø, 4W ELECTRICAL PANEL L-3 WITH TWENTY-FOUR (24) SPACES. VERIFY EXACT LOCATION IN FIELD.
3. APPROXIMATE LOCATION OF EXISTING IDF SERVING AREA. VERIFY EXACT LOCATION IN FIELD.
4. APPROXIMATE LOCATION OF EXISTING NOTIFIER FACP. VERIFY EXACT LOCATION IN FIELD.

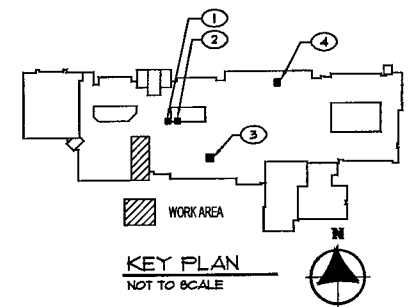

MEP DESIGNER
Miles Engineering Group
11111 N. 111th Ave.
Suite 1000, Omaha, NE 68148
(402) 733-0000
FAX (402) 733-0001

DUNELAND SCHOOL CORPORATION
2017 SCIENCE LAB RENOVATIONS AT:
CHESTERTON MIDDLE SCHOOL
651 W. MORGAN AVENUE, CHESTERTON, INDIANA 46304

PROJECT NUMBER	17-00
PROJECT MANAGER	XXX
DRAWN BY	XXX
REVISIONS	
1	ISSUED FOR BIDD AND PERMIT. TPO
2	
3	
4	

PARTIAL FIRST FLOOR PLAN - ELECTRICAL

E1.00