


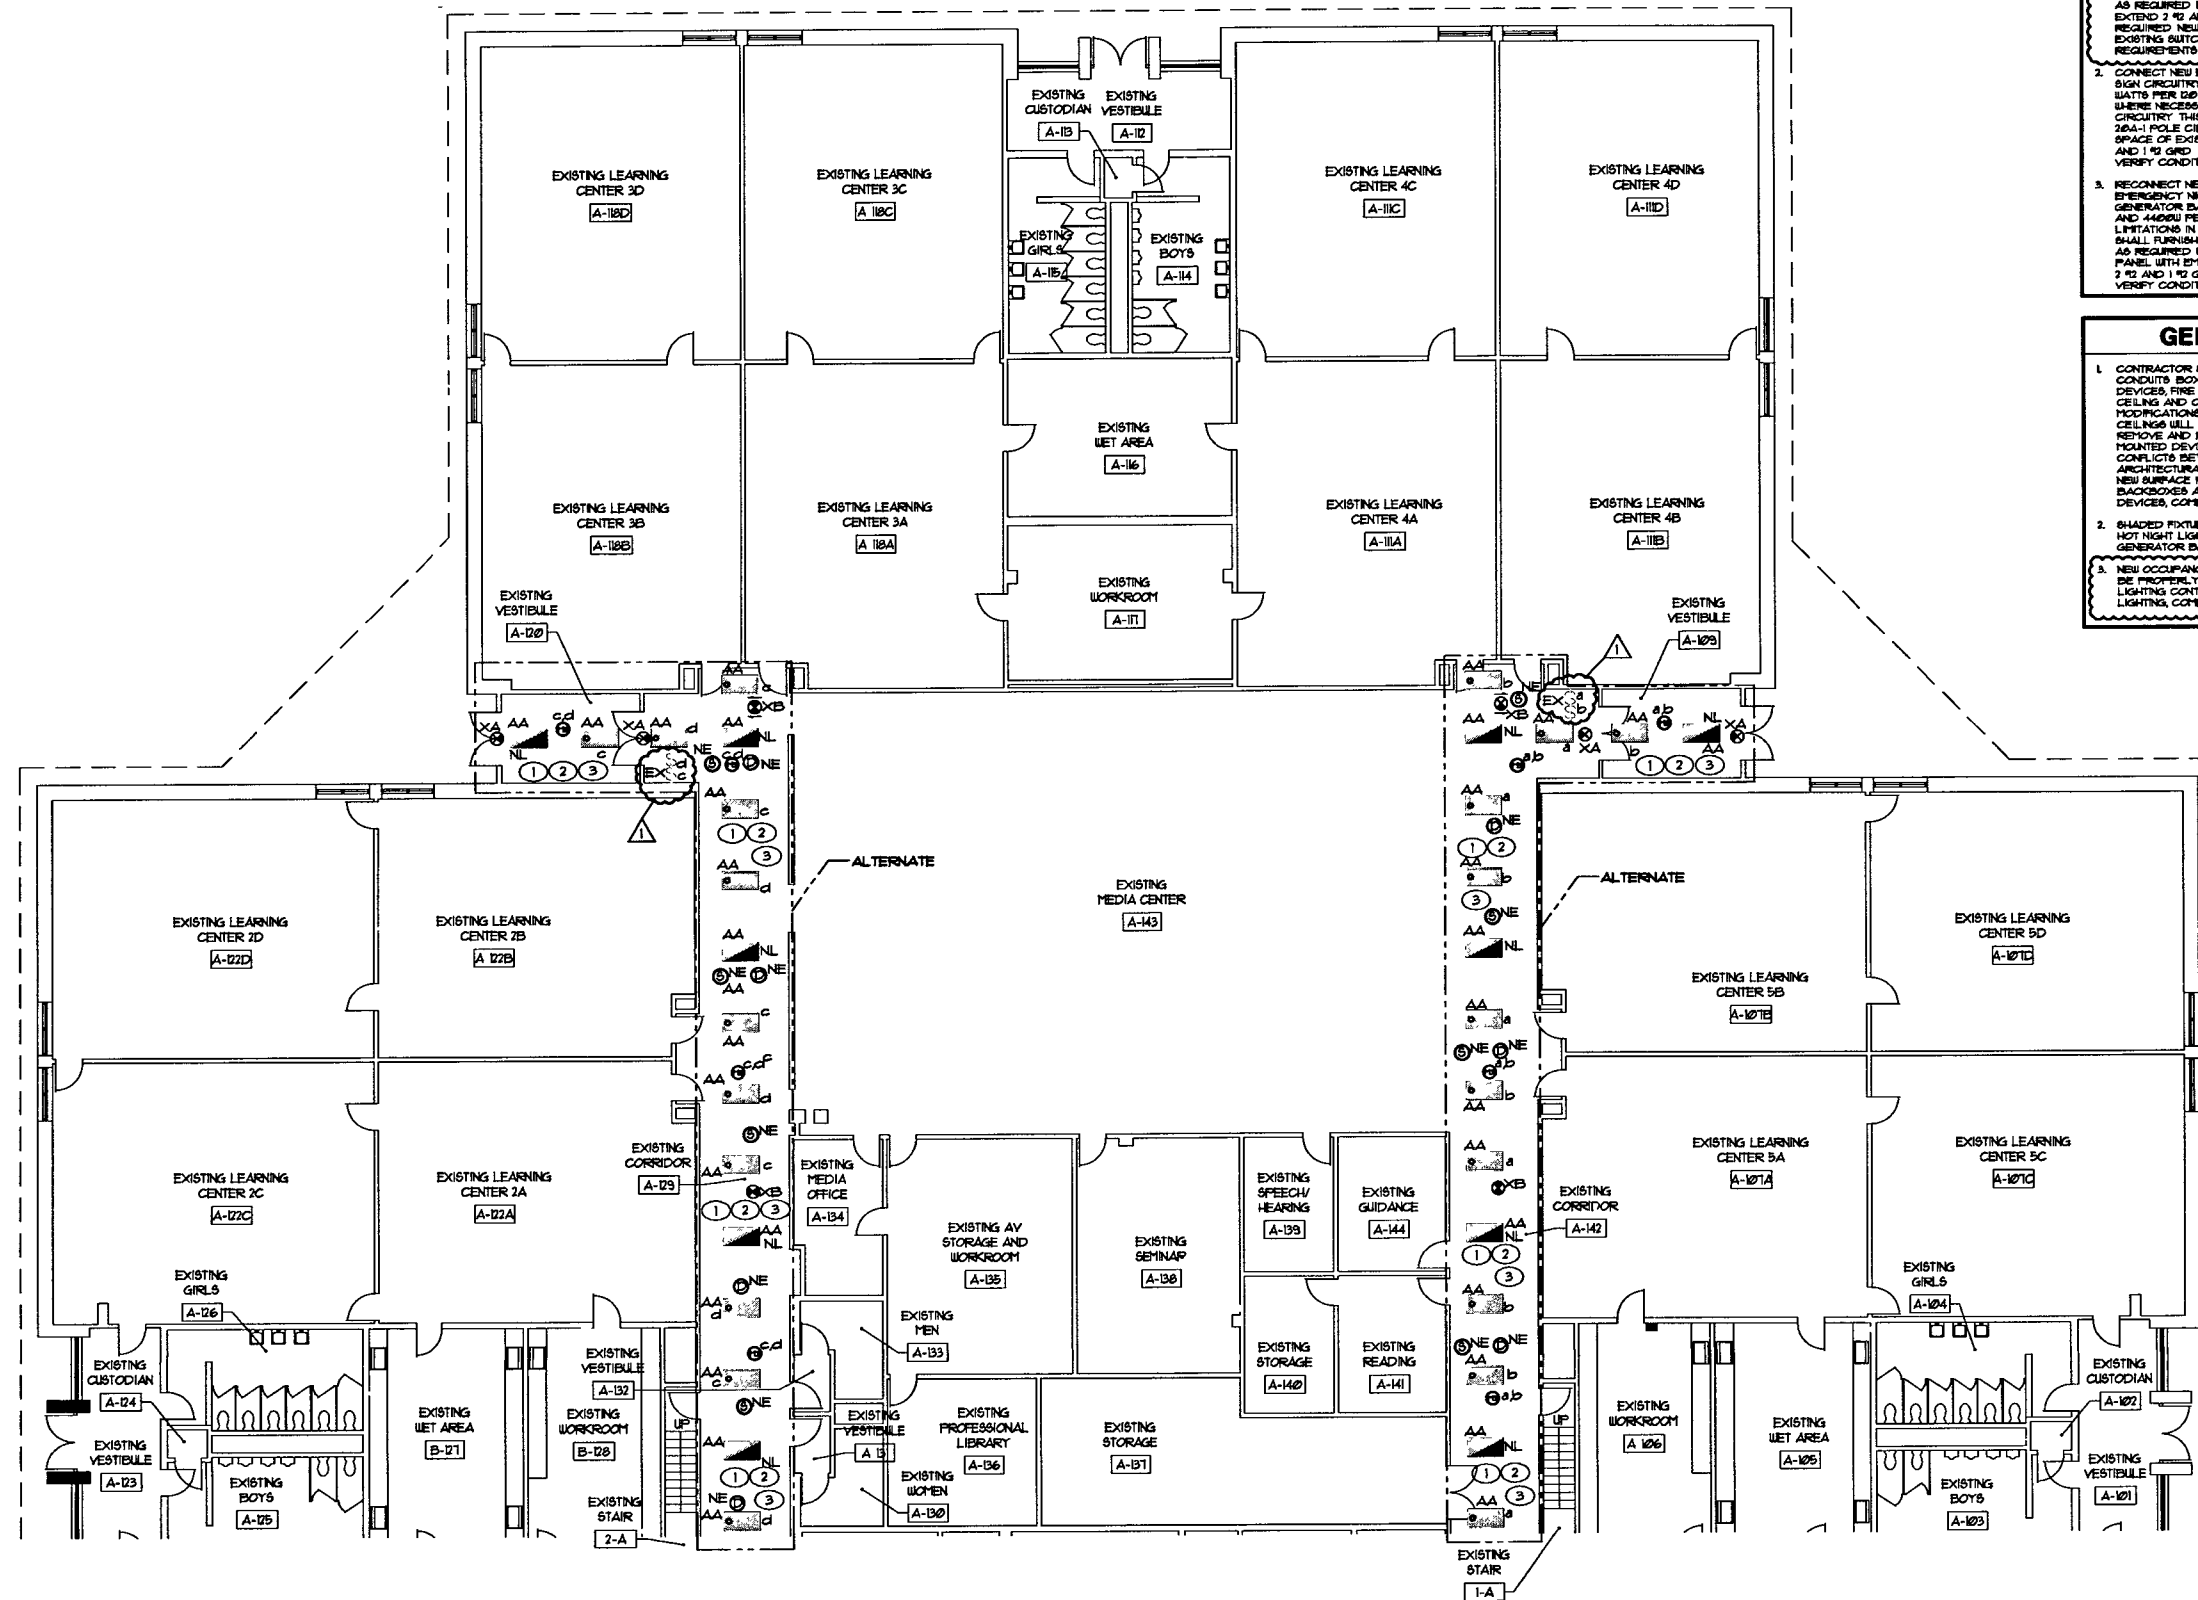

- ### SHEET NOTES
- CONNECT NEW CORRIDOR NORMAL POWER LIGHT FIXTURES TO EXISTING CORRIDOR LIGHTING CIRCUITRY AND EXISTING CORRIDOR SWITCHING VIA EXISTING SWITCHES/CONTROL SYSTEM AND NEW OCCUPANCY SENSORS, COMPLETE AS REQUIRED. MAXIMUM 1400W PER 20 VOLT CIRCUIT AND 4400W PER 277V CIRCUIT. WHERE NECESSARY DUE TO LIMITATIONS IN THE EXISTING CIRCUITRY, THIS CONTRACTOR SHALL FURNISH AND INSTALL 20A-1 POLE CIRCUIT BREAKERS AS REQUIRED IN EXISTING SPACE OF EXISTING PANEL AND EXTEND 2 #2 AND 1 #2 GND IN 1" CONDUIT COMPLETE AS REQUIRED. NEW SWITCHING ARRANGEMENTS SHALL MATCH EXISTING SWITCHING ARRANGEMENTS WHERE CONDITIONS AND REQUIREMENTS IN FIELD.
 - CONNECT NEW EXIT SIGNS TO EXISTING EMERGENCY EXIT SIGN CIRCUITRY COMPLETE AS REQUIRED. MAXIMUM 1400 WATTS PER 20 VOLT CIRCUIT AND 4400W PER 277V CIRCUIT. WHERE NECESSARY DUE TO LIMITATIONS IN THE EXISTING CIRCUITRY, THIS CONTRACTOR SHALL FURNISH AND INSTALL 20A-1 POLE CIRCUIT BREAKERS AS REQUIRED IN EXISTING SPACE OF EXISTING EMERGENCY PANEL AND EXTEND 2 #2 AND 1 #2 GND IN 1" CONDUIT COMPLETE AS REQUIRED. VERIFY CONDITIONS AND REQUIREMENTS IN FIELD.
 - RECONNECT NEW NIGHT LIGHT FIXTURES TO EXISTING EMERGENCY NIGHT LIGHTING CIRCUITRY WITH EMERGENCY GENERATOR BACKUP. MAXIMUM 1400W PER 20 VOLT CIRCUIT AND 4400W PER 277V CIRCUIT. WHERE NECESSARY DUE TO LIMITATIONS IN THE EXISTING CIRCUITRY, THIS CONTRACTOR SHALL FURNISH AND INSTALL 20A-1 POLE CIRCUIT BREAKERS AS REQUIRED IN EXISTING SPACE OF EXISTING EMERGENCY PANEL WITH EMERGENCY GENERATOR BACKUP AND EXTEND 2 #2 AND 1 #2 GND IN 1" CONDUIT COMPLETE AS REQUIRED. VERIFY CONDITIONS AND REQUIREMENTS IN FIELD.

- ### GENERAL NOTES
- CONTRACTOR SHALL CAREFULLY VERIFY EXISTING CONDUITS, BOXES, DEVICES, EQUIPMENT, LOW VOLTAGE DEVICES, FIRE ALARM DEVICES, ETC. LOCATED ON THE CEILING AND ON THE WALLS IN WHICH ARCHITECTURAL MODIFICATIONS, STRUCTURAL MODIFICATION OR NEW CEILING WILL BE LOCATED. CONTRACTOR SHALL REMOVE AND RELOCATE ALL CEILING AND WALL MOUNTED DEVICES AS REQUIRED TO ELIMINATE CONFLICTS BETWEEN EXISTING DEVICES AND ARCHITECTURAL/STRUCTURAL MODIFICATIONS. PROVIDE NEW SURFACE RACEWAY AND SURFACE RACEWAY BACKBOXES AS REQUIRED FOR ALL RELOCATED DEVICES. COMPLETE AS REQUIRED.
 - SHARED FIXTURES TO BE CONNECTED TO CONSTANT HOT NIGHT LIGHT CIRCUITRY WITH EMERGENCY GENERATOR BACKUP.
 - NEW OCCUPANCY SENSORS AND POWER PACKS SHALL BE PROPERLY INTERFACED TO EXISTING LOW VOLTAGE LIGHTING CONTROL SYSTEM TO PROPERLY CONTROL LIGHTING. COMPLETE AS REQUIRED.



TRIA ARCHITECTURE
1100 N. 10TH ST.
INDIANAPOLIS, IN 46202
(317) 326-1400
www.triaarch.com

DUNELAND SCHOOL CORPORATION
2017 MECHANICAL RENOVATIONS AT:
JACKSON ELEMENTARY SCHOOL
811 N. 400 E. VALPARAISO, IN. 46383



WILLIAM A. HROMADA
REGISTERED PROFESSIONAL ENGINEER
No. 10706283
STATE OF INDIANA
W. Hromada

PROJECT NUMBER: T-406	REVISIONS:
PROJECT CHANGER: CH	1. 8/15/2017
DRAWN BY: CH	2. 8/15/2017
DATE FOR SET: 8/15/2017	3. 8/15/2017
PARTIAL FIRST FLOOR PLAN - ELECTRICAL	

1 PARTIAL FIRST FLOOR PLAN - ELECTRICAL
3/32" = 1'-0"

E1.11