




WILLIAM A. HROMADA
REGISTERED PROFESSIONAL ENGINEER
No. 10706283
STATE OF INDIANA
William A. Hromada

PROJECT NUMBER	1-606
PROJECT NAME	CI
DATE	8/2/2017
DESIGNED BY	CI
CHECKED BY	CI
DATE	8/2/2017
PROJECT LOCATION	811 N. 400 E. VALPARAISO, IN. 46383
PROJECT TYPE	SCHOOL RENOVATION
PROJECT PHASE	MECHANICAL RENOVATIONS
PROJECT STATUS	IN PROGRESS
PROJECT OWNER	DUNELAND SCHOOL CORPORATION
PROJECT CONTACT	811 N. 400 E. VALPARAISO, IN. 46383
PROJECT PHONE	(317) 434-1100
PROJECT FAX	(317) 434-1100
PROJECT EMAIL	info@triaarch.com
PROJECT WEBSITE	www.triaarch.com

SHEET NOTES

1. REMOVE EXISTING TRANSFER AIR GRILLE COMPLETE AS REQUIRED. REPLACE WITH NEW TRANSFER AIR GRILLE.

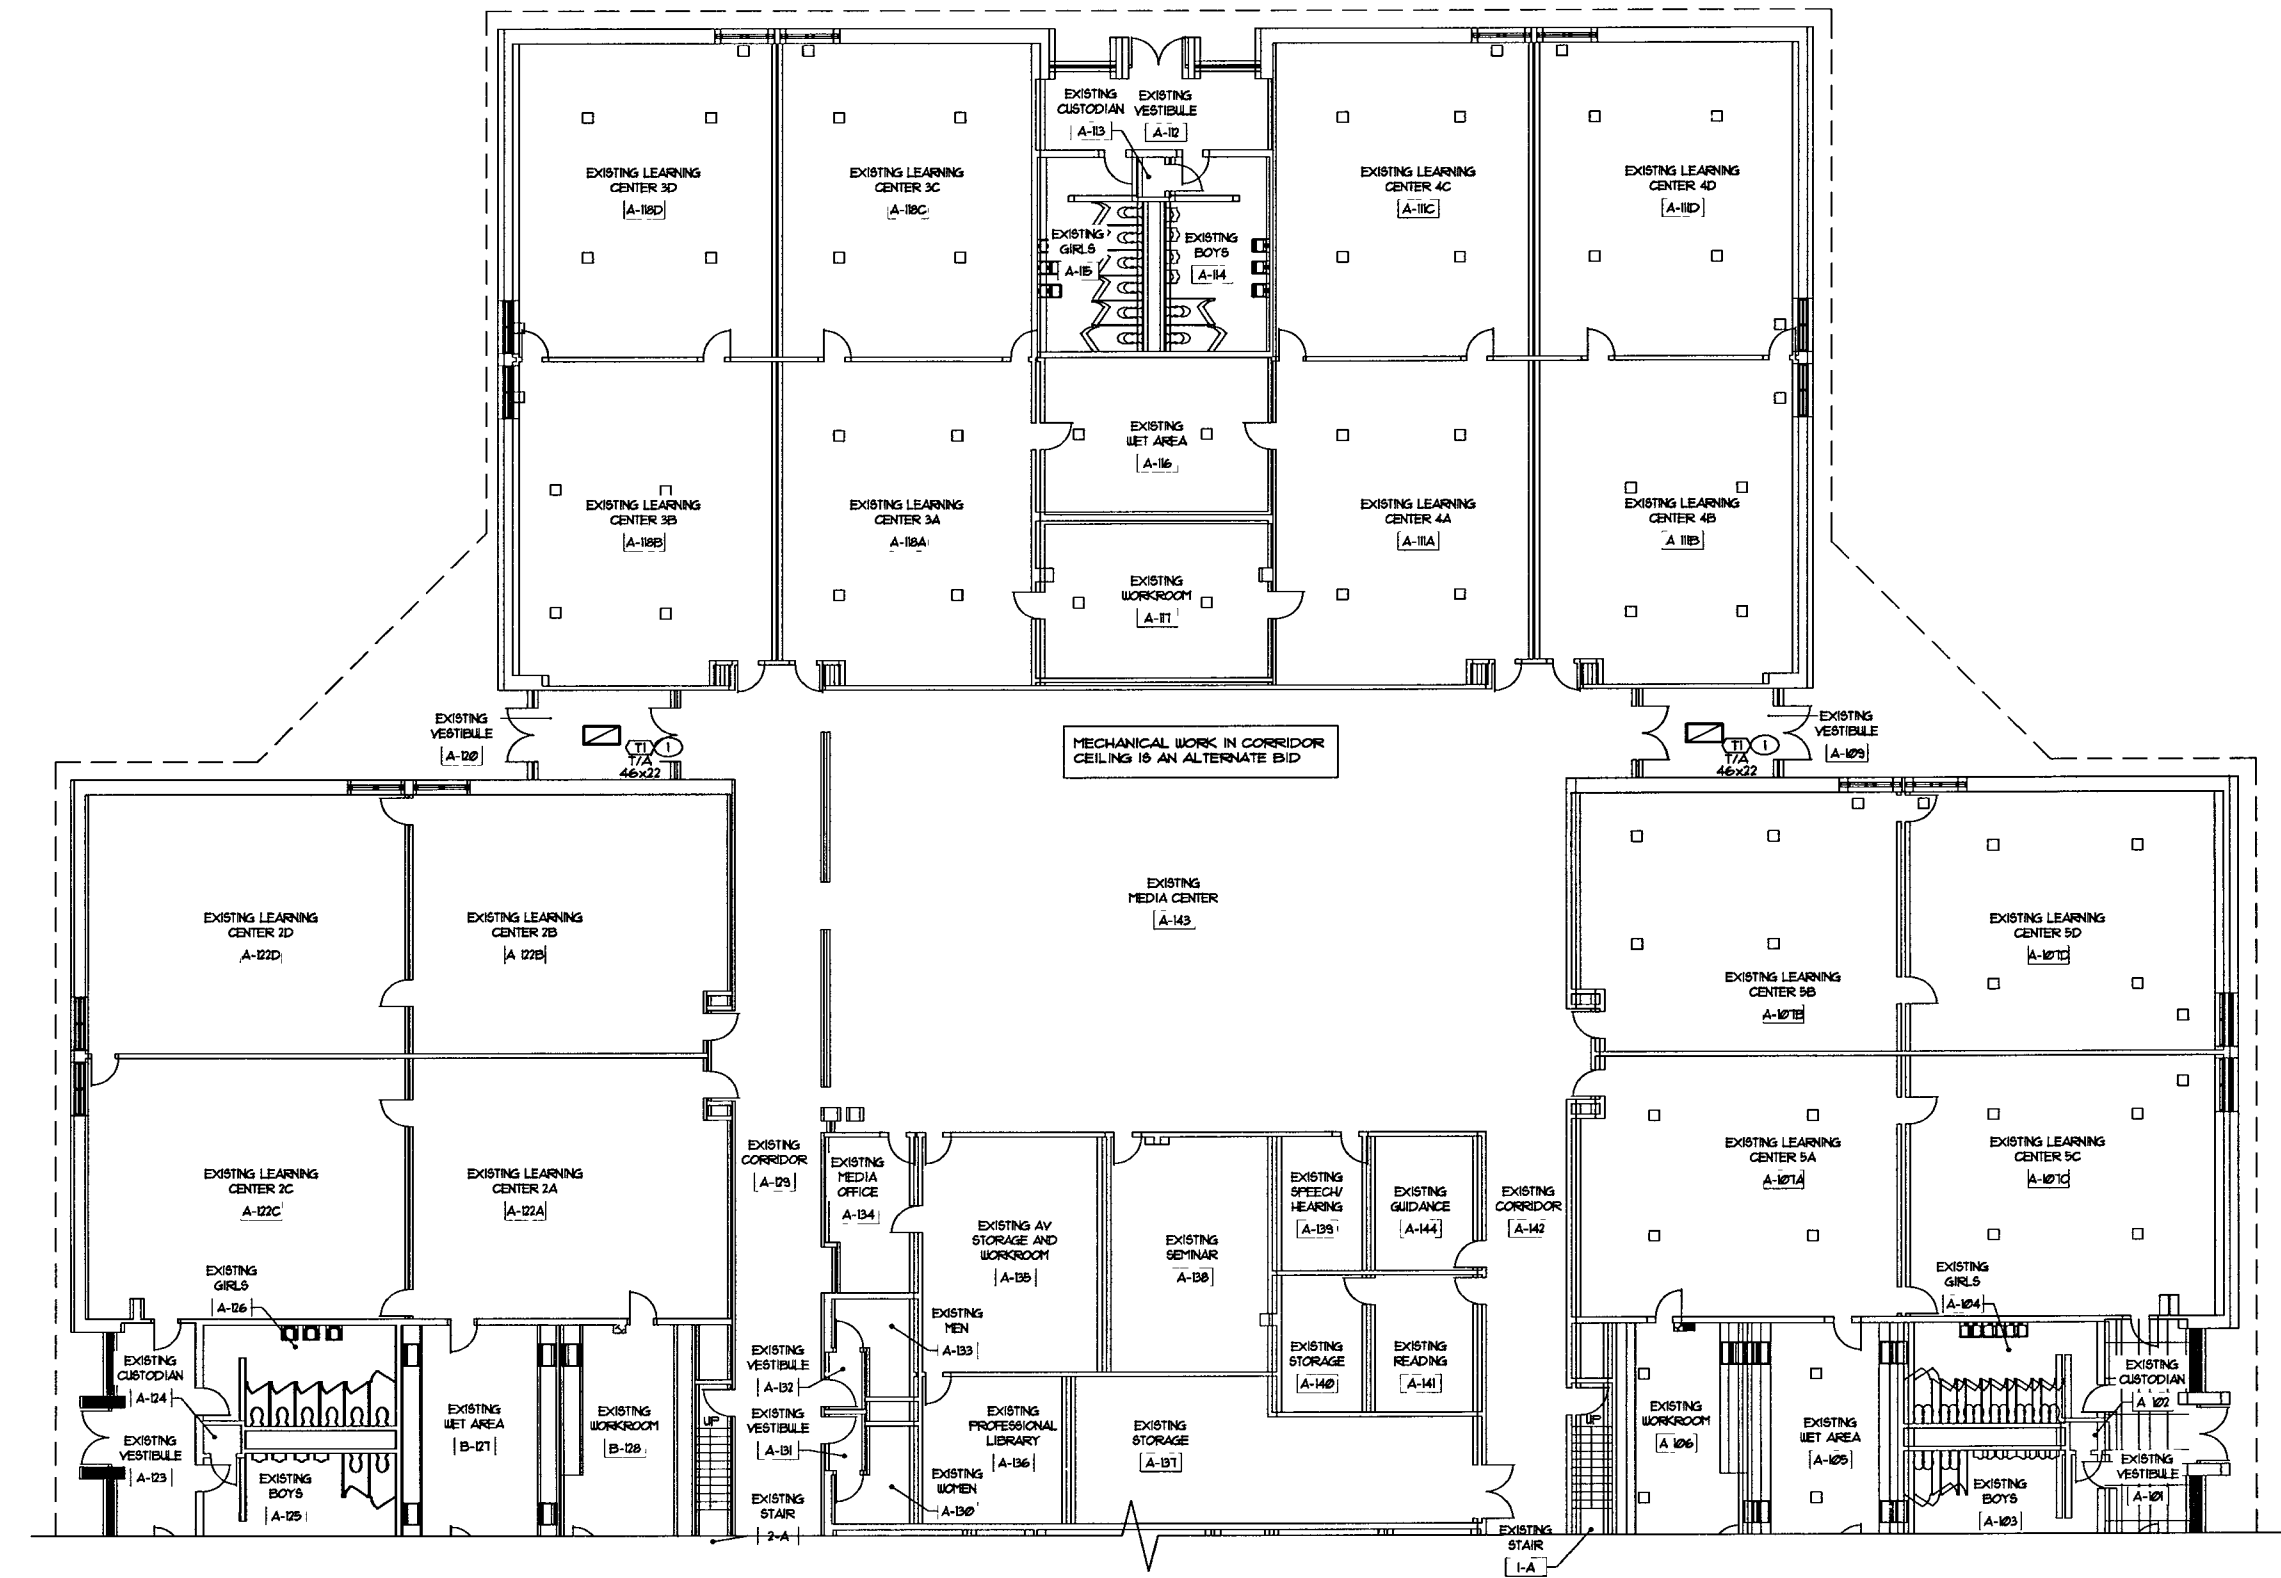

1 PARTIAL FIRST FLOOR PLAN - MECHANICAL FLOOR PLAN
3/32" = 1'-0"

