


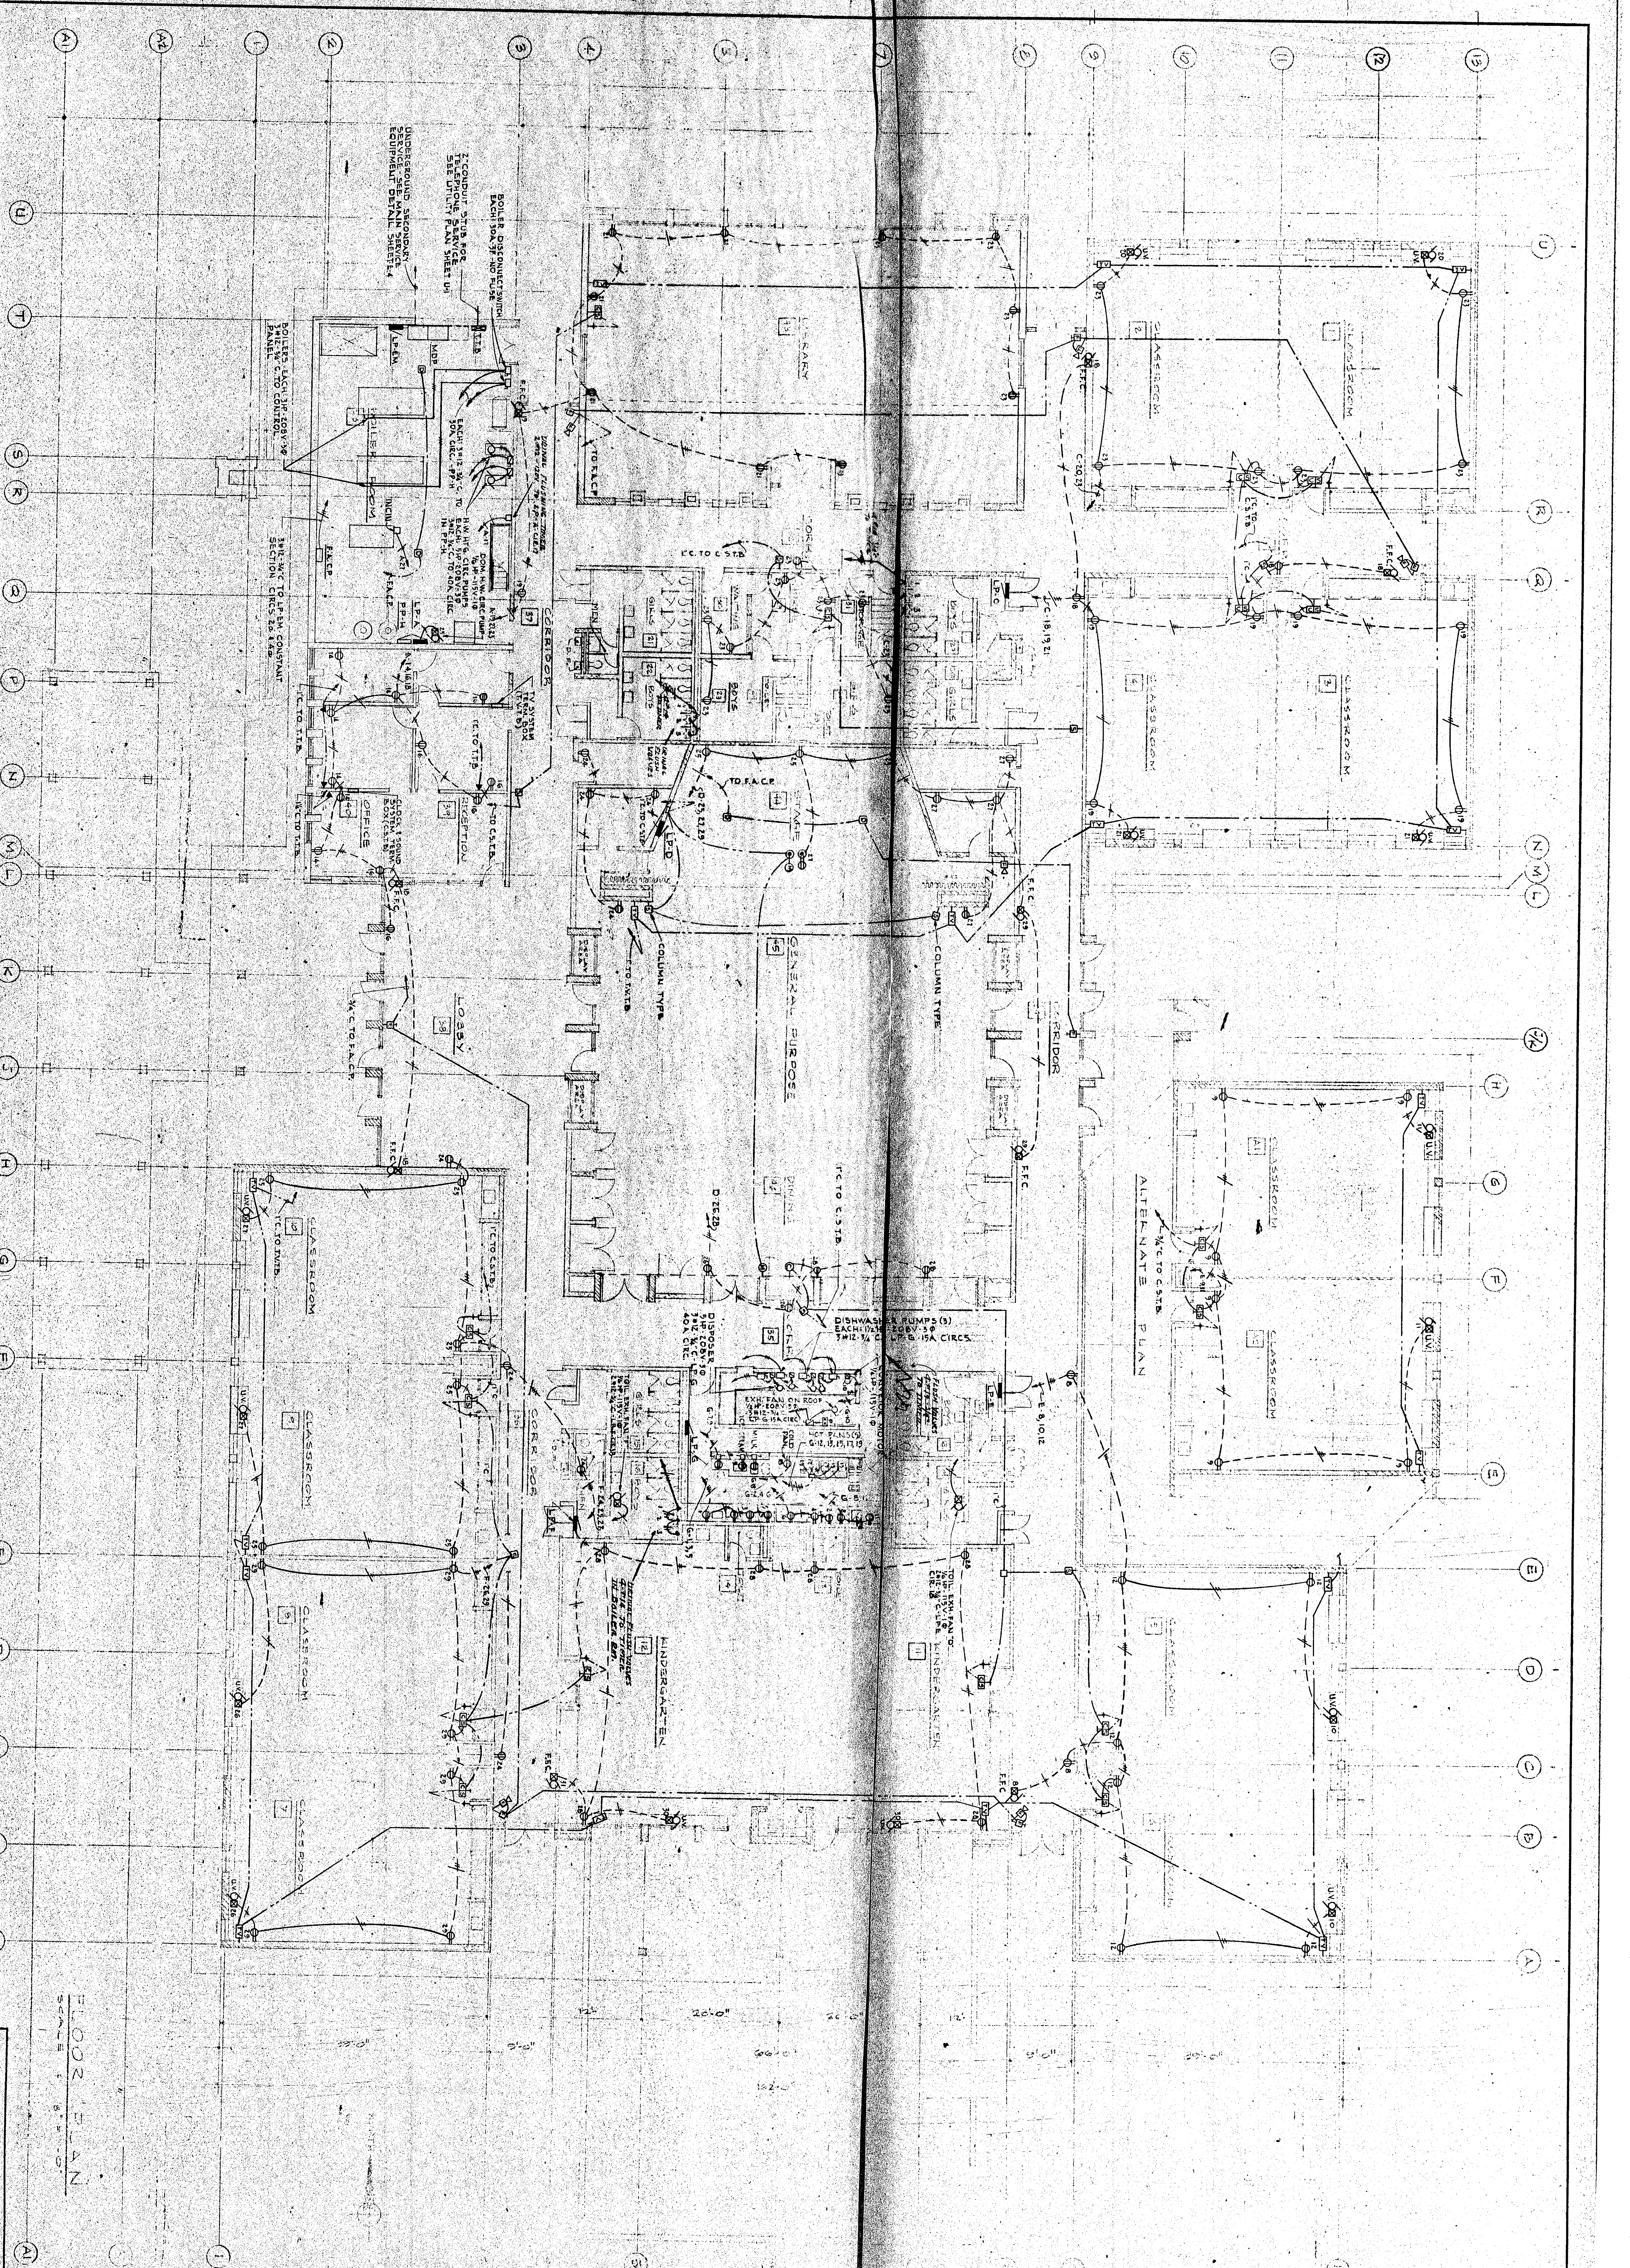

WESTCHESTER TOWNSHIP ELEMENTARY SCHOOL		POWER PLAN	
5th STREET UNION AVENUE CHESTER TOWNSHIP INDIANA FOR THE WESTCHESTER TOWNSHIP SCHOOL CORPORATION		DATE: 3/2/68 DRAWN BY: H. E. SCHARRES CHECKED BY: J. E. SCHARRES PROJECT NO.: 31-2-68-1 SHEET NO.: 1E-2	
SCHARRES & ASSOCIATES		ARCHITECTS	
100 N. 10th St., Suite 100 Indianapolis, Indiana 46204 Phone: 317-421-1111		100 N. 10th St., Suite 100 Indianapolis, Indiana 46204 Phone: 317-421-1111	

NO.	REVISIONS	DATE	BY	APPROVED
1				
2				
3				
100				