

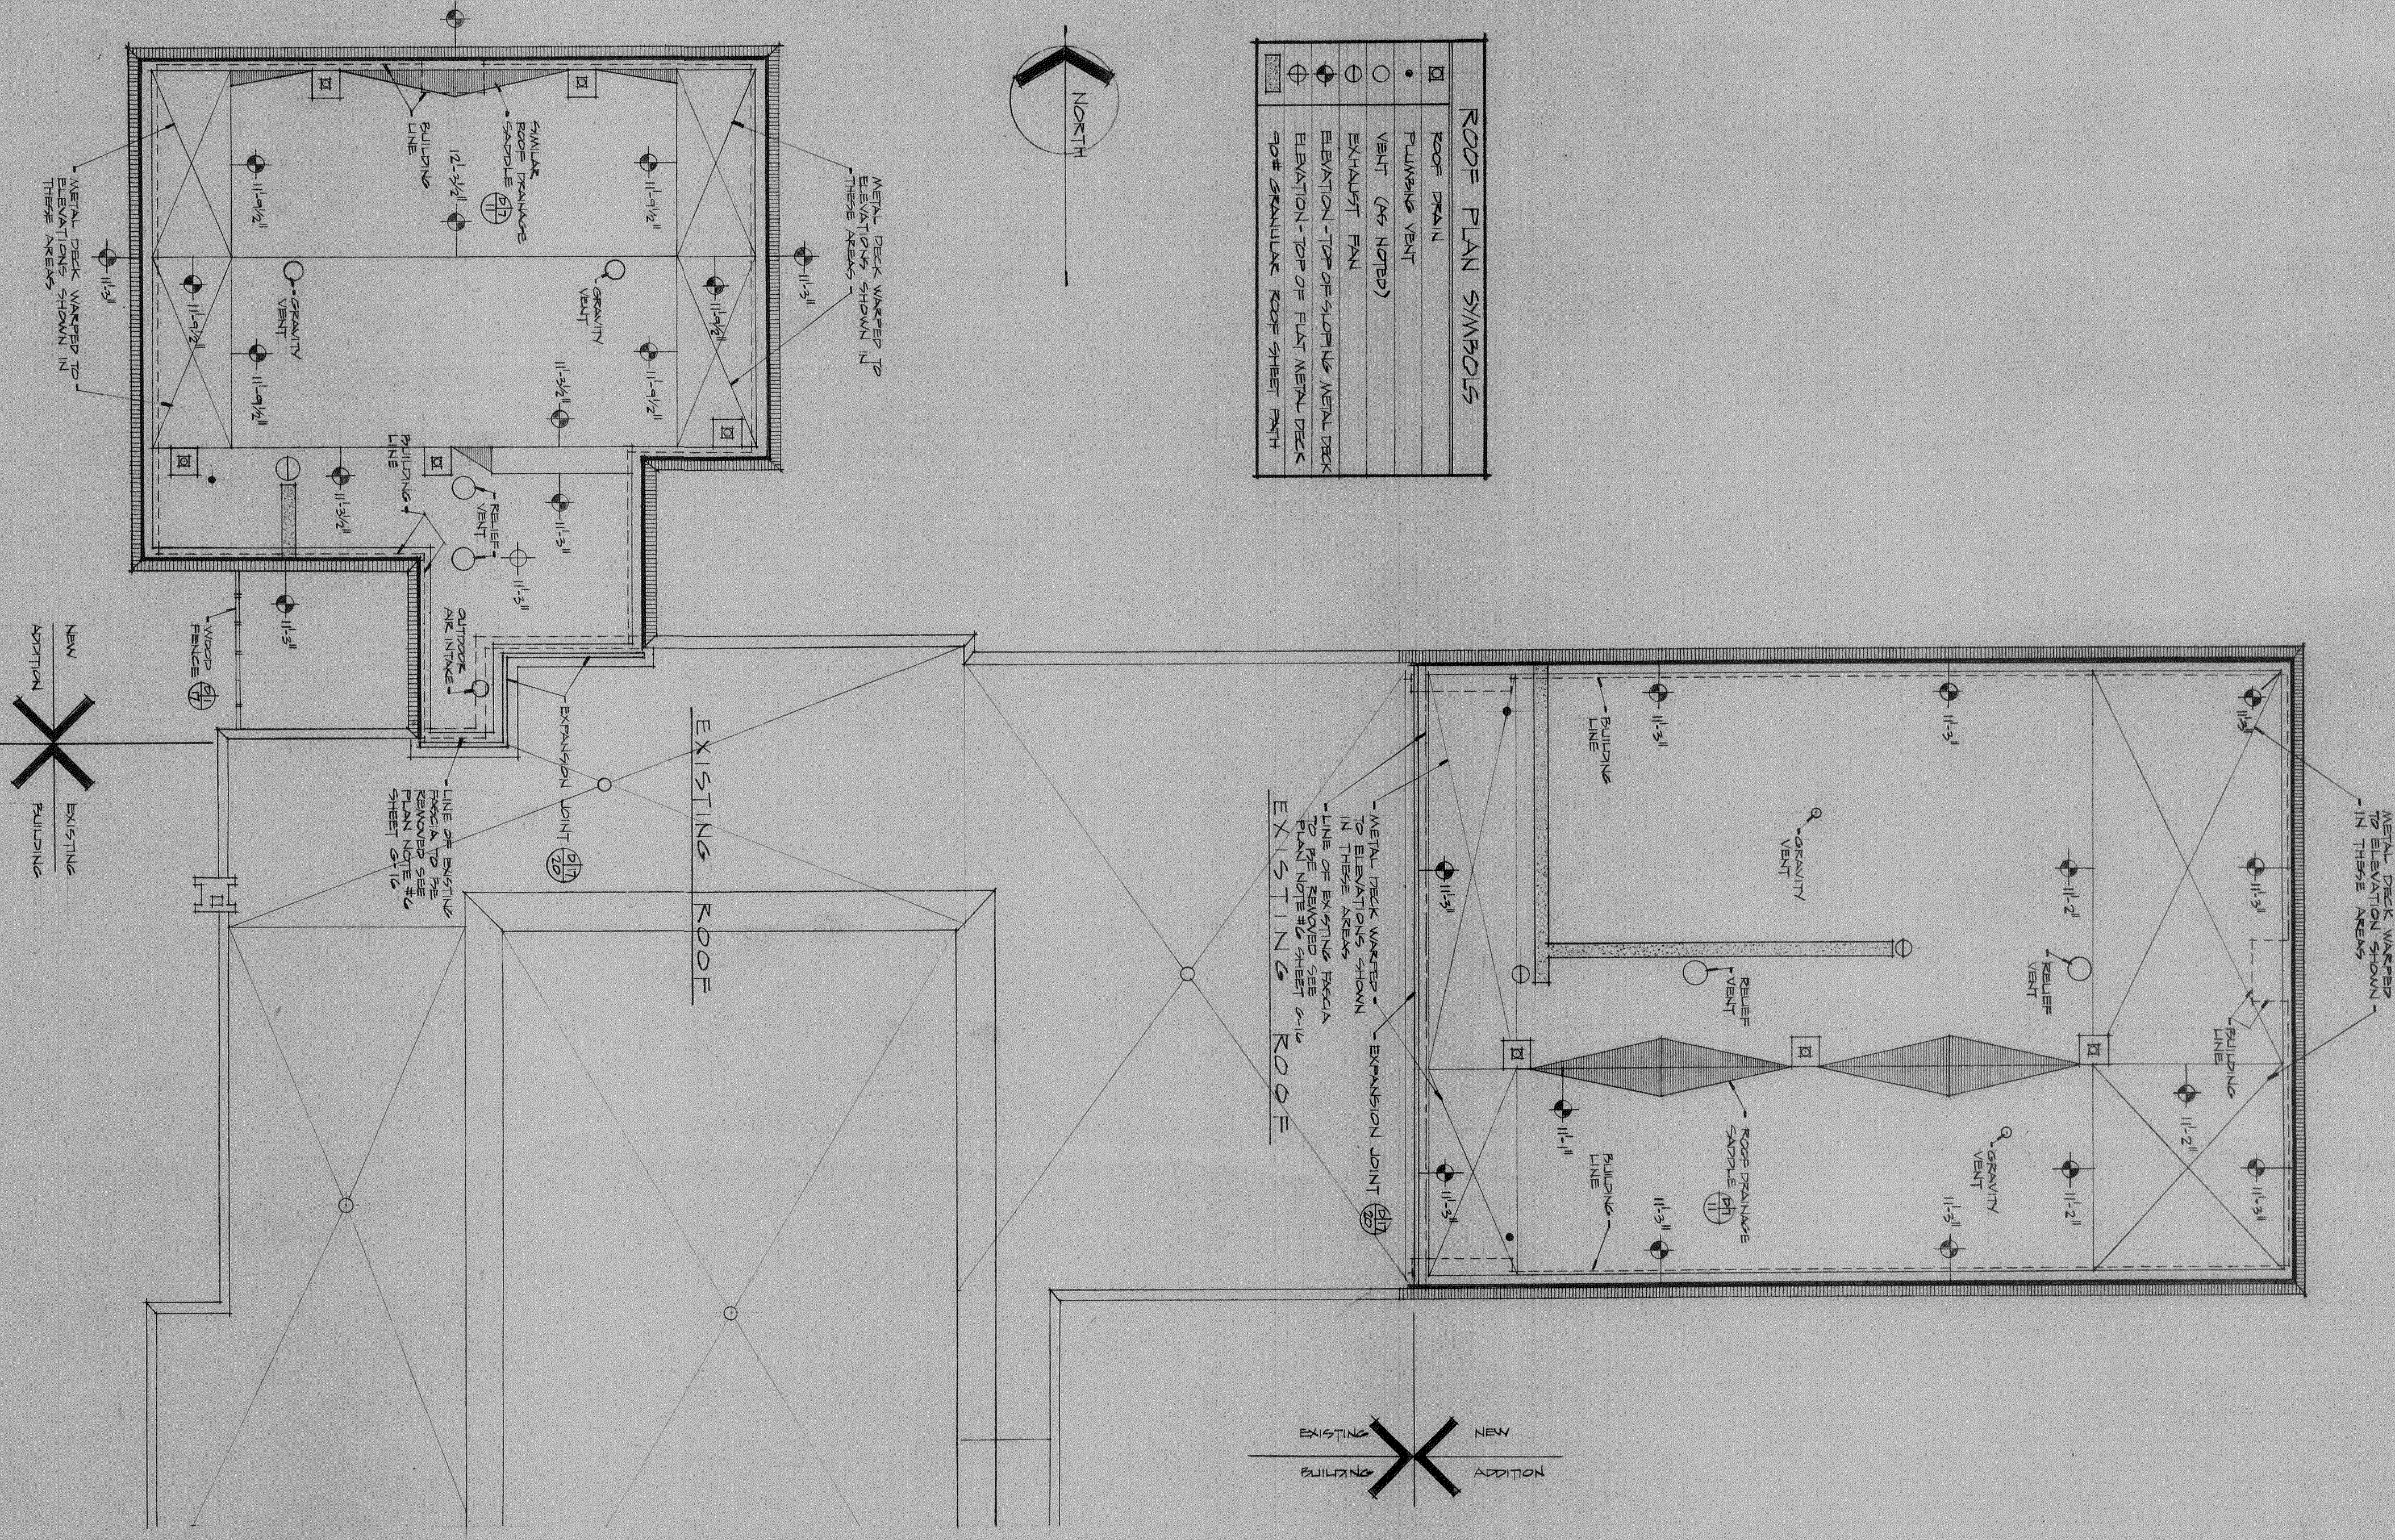
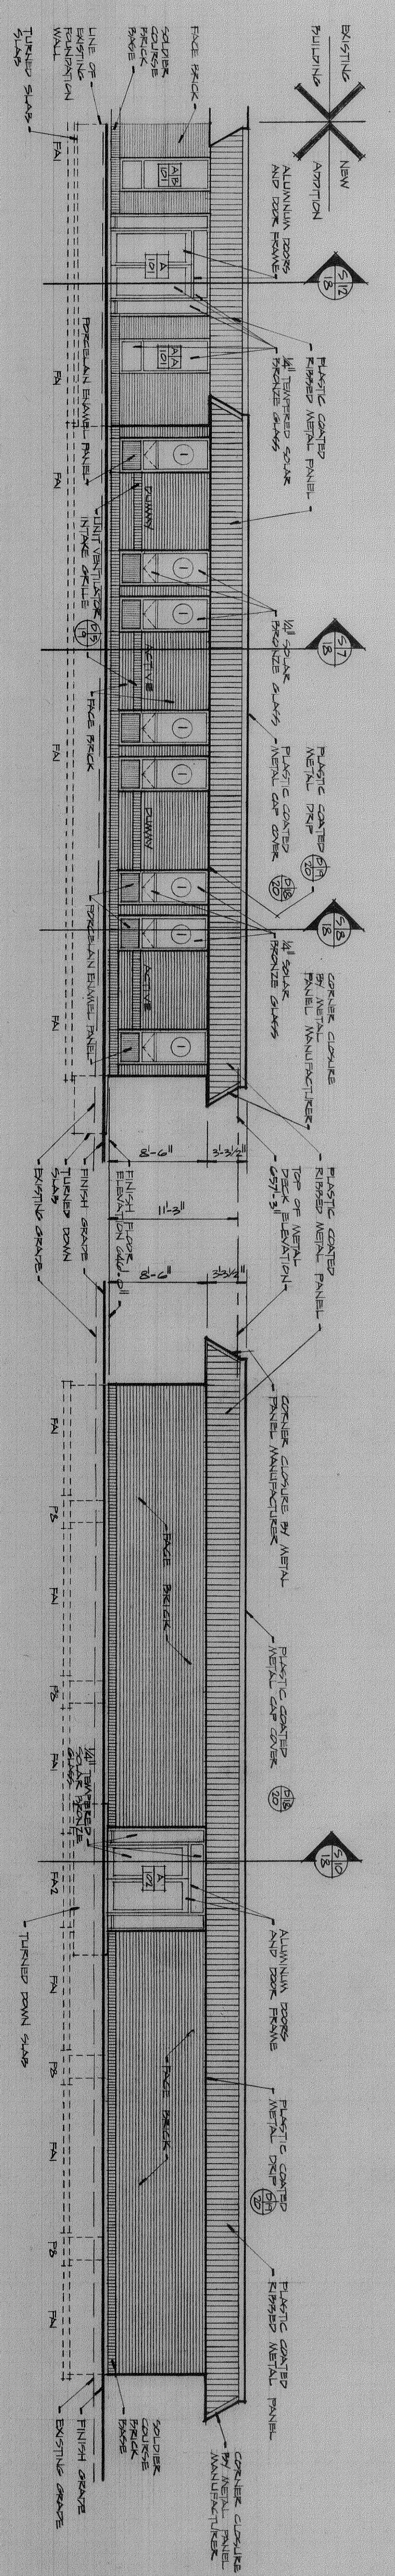
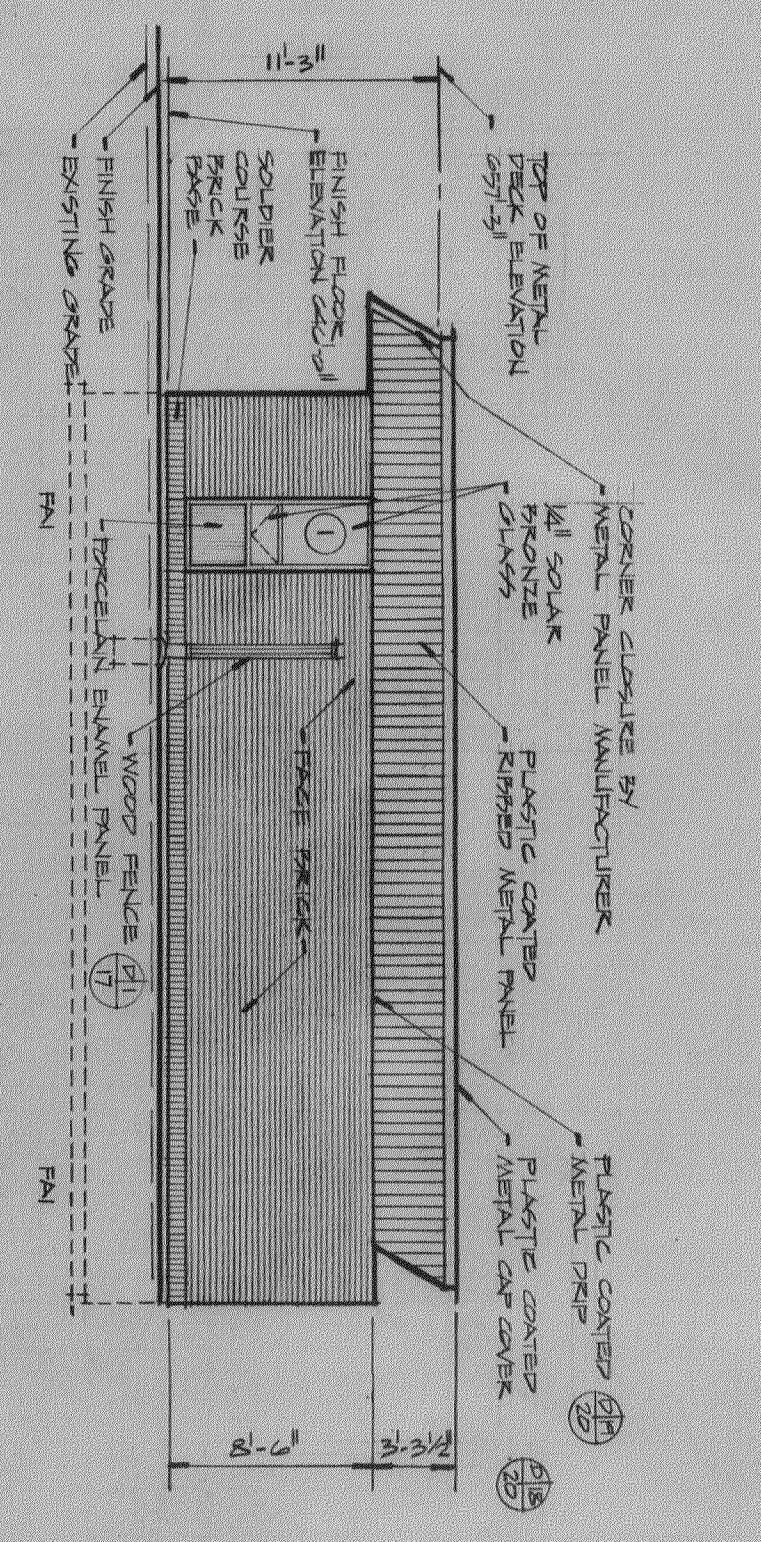


ROOF PLAN SYMBOLS	
ROOF DRAIN	⊗
FLUVENT VENT	⊙
VENT (4" DIA)	⊙
EXHAUST FAN	⊙
ELEVATION-TOP OF FLASH VENT, DECK	⊙
TOP OF DOWNPIPE, ROOF DRAIN, FAN	⊙

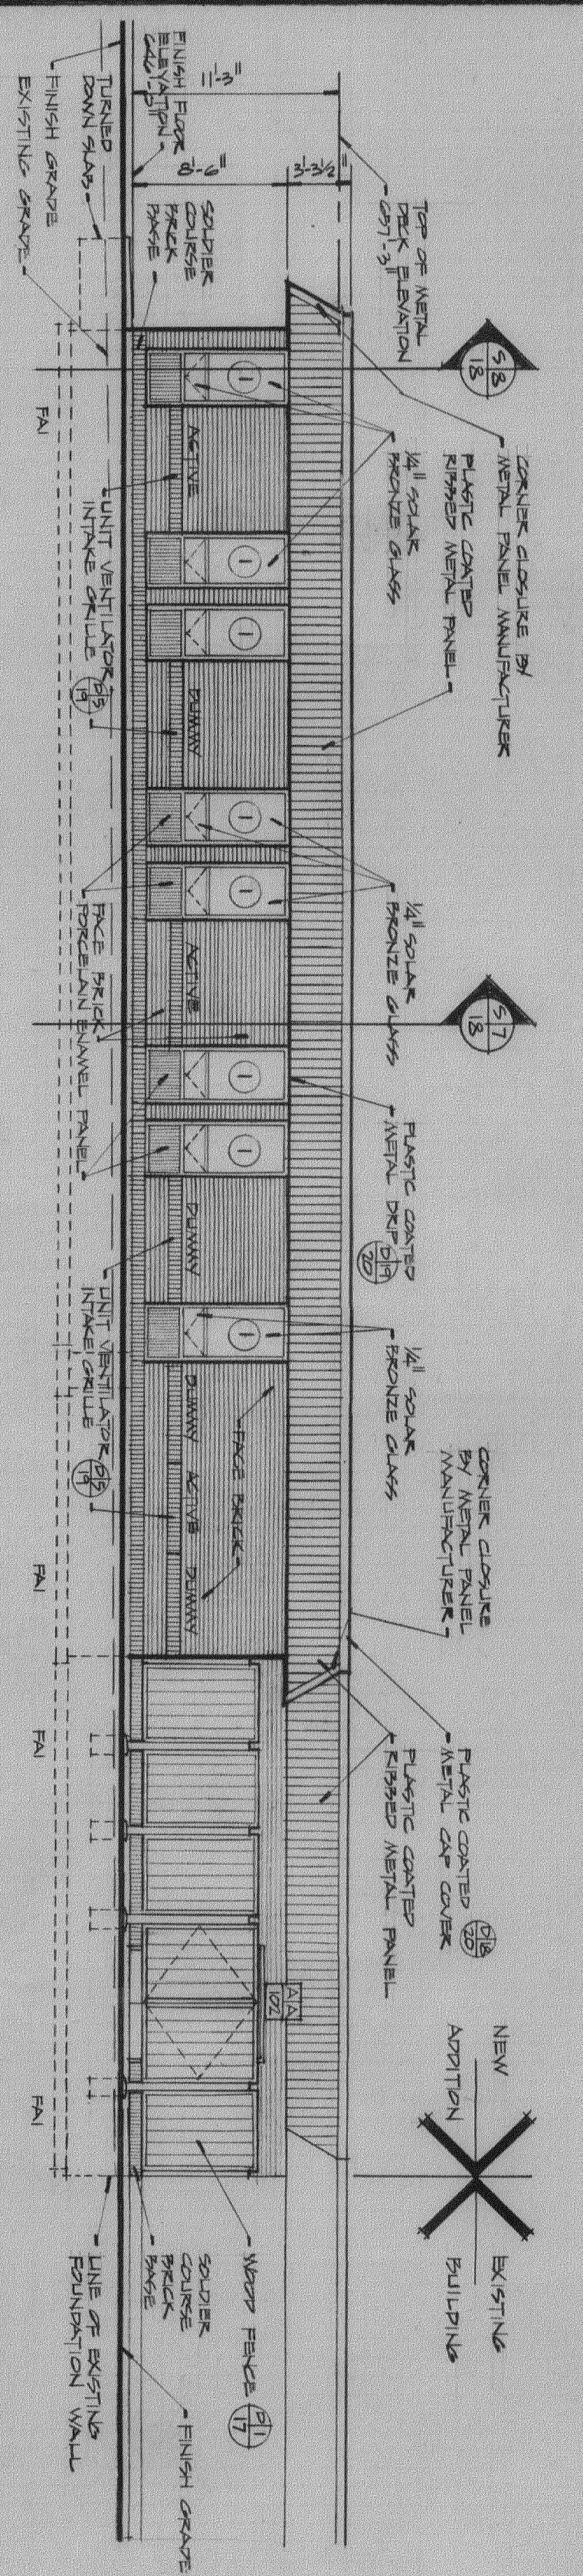


ROOF PLAN

SCALE: 1/8" = 1'-0"

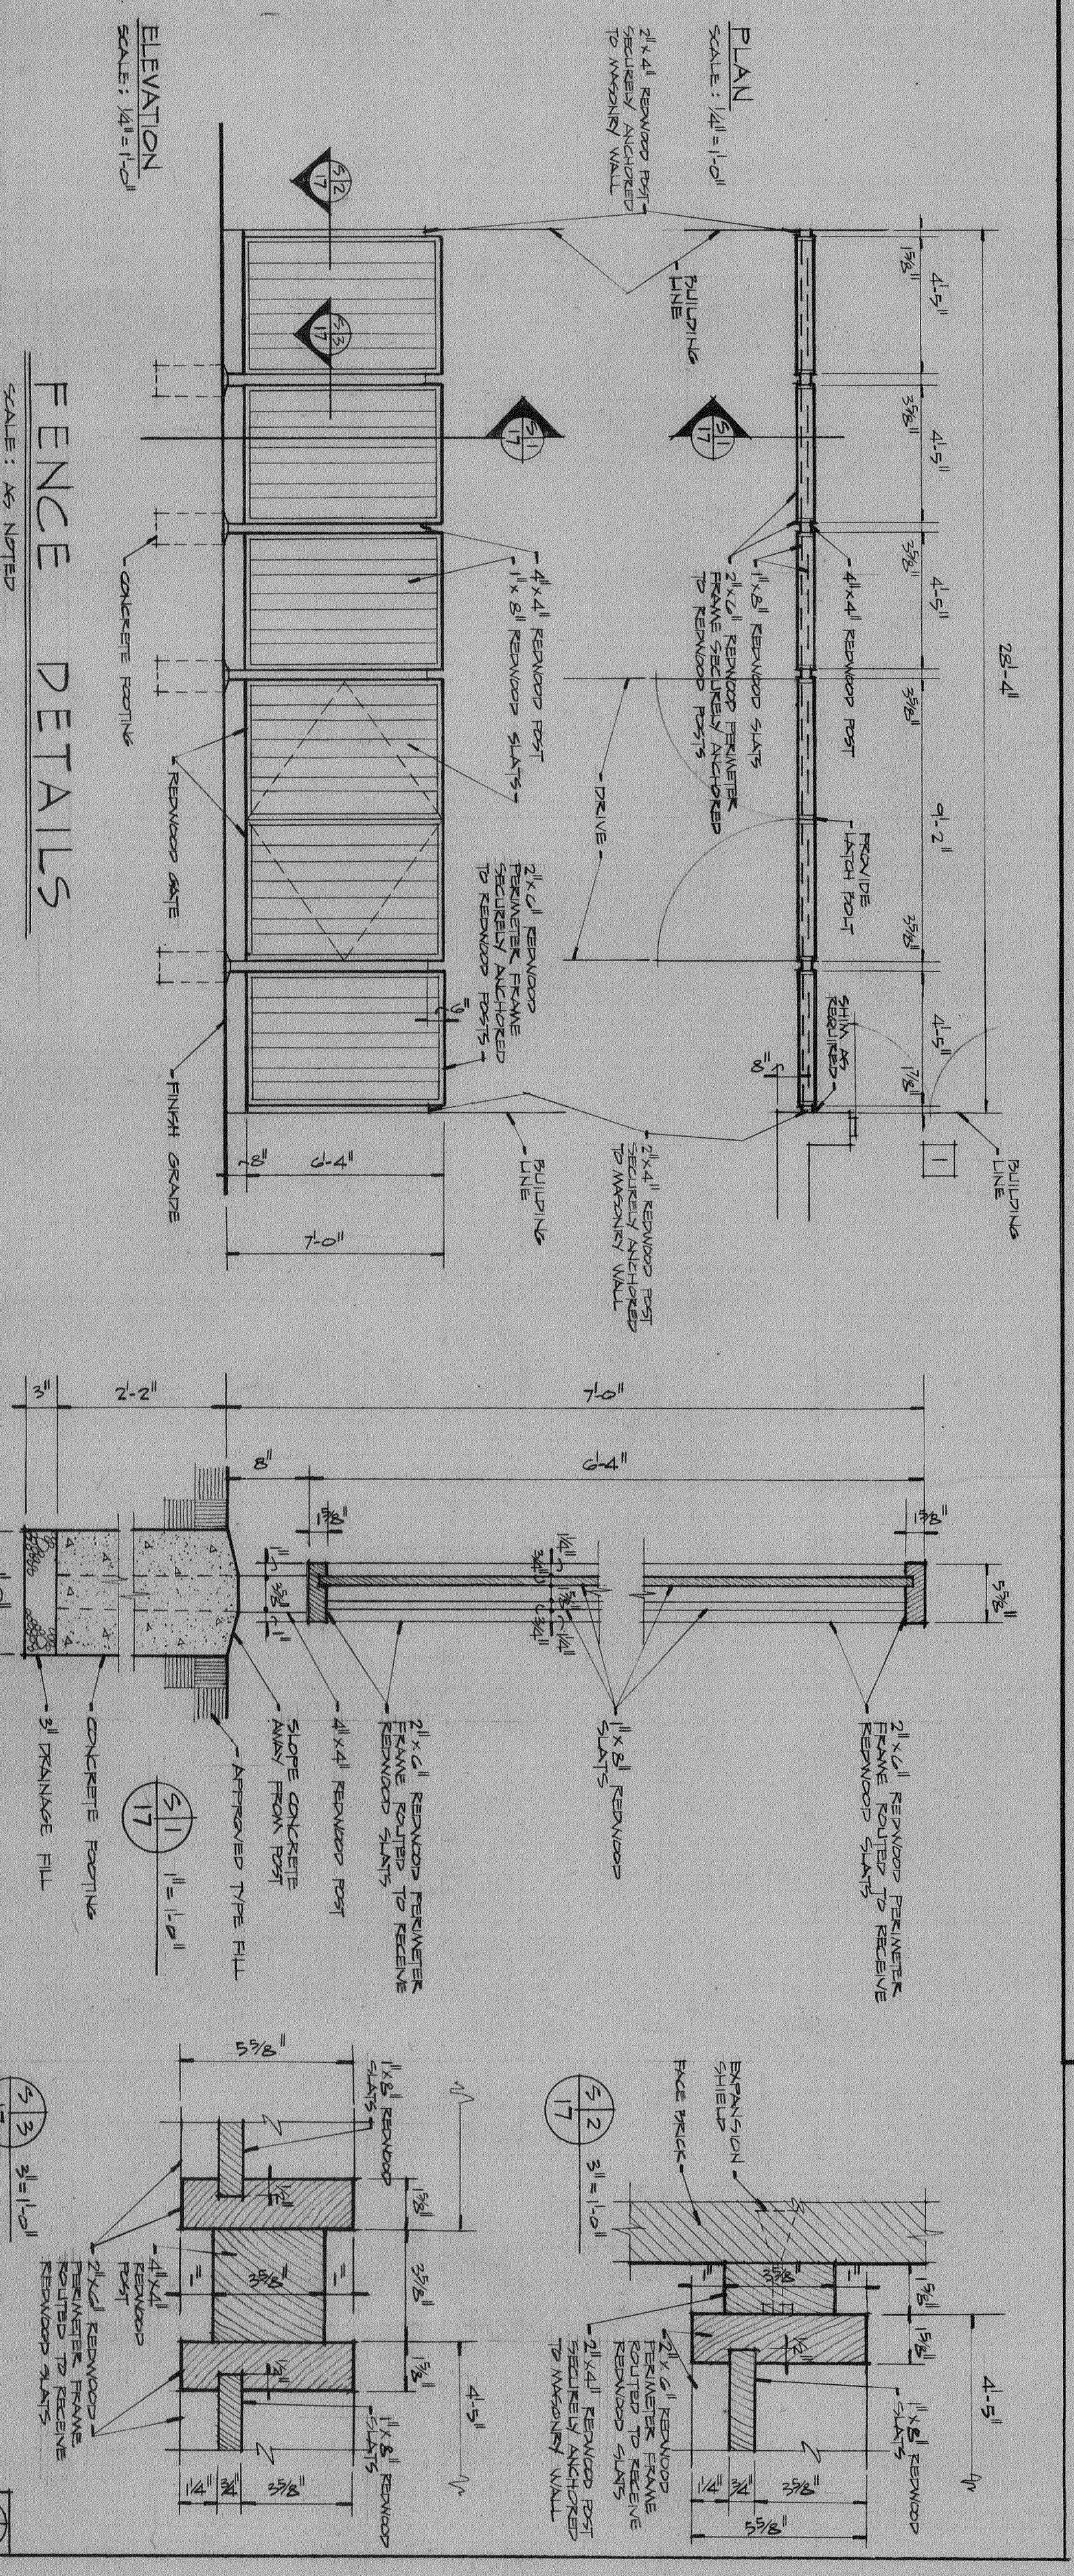


ELEVATION N 4

SCALE: 1/8" = 1'-0"

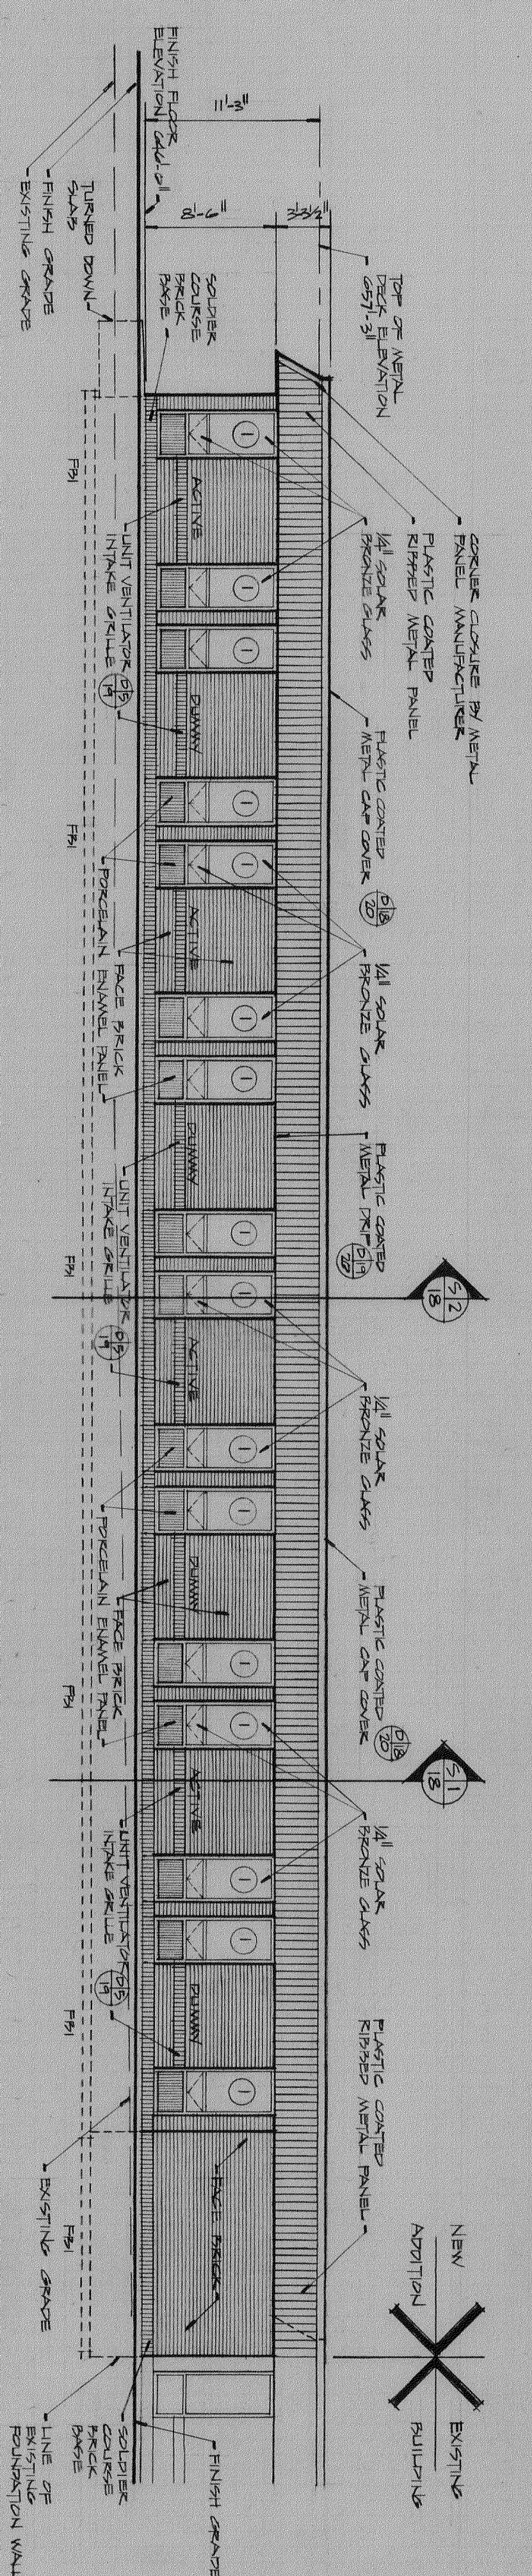


ELEVATION N 6

SCALE: 1/8" = 1'-0"

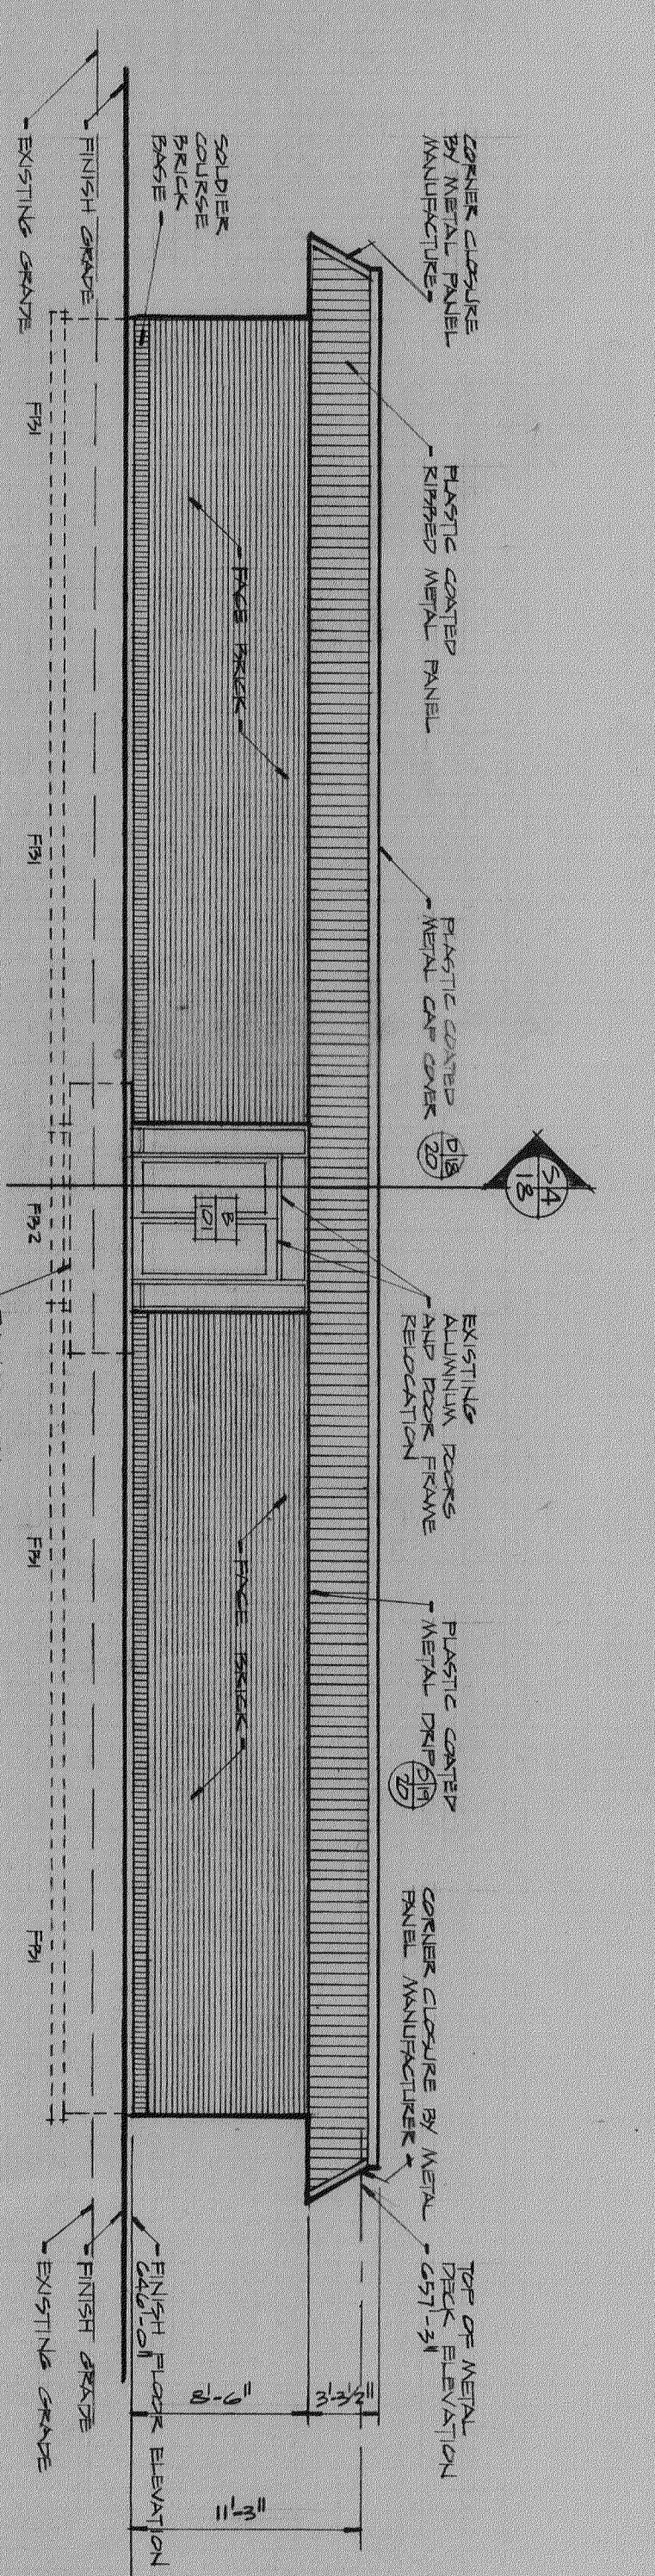

ELEVATION N 8

SCALE: 1/8" = 1'-0"

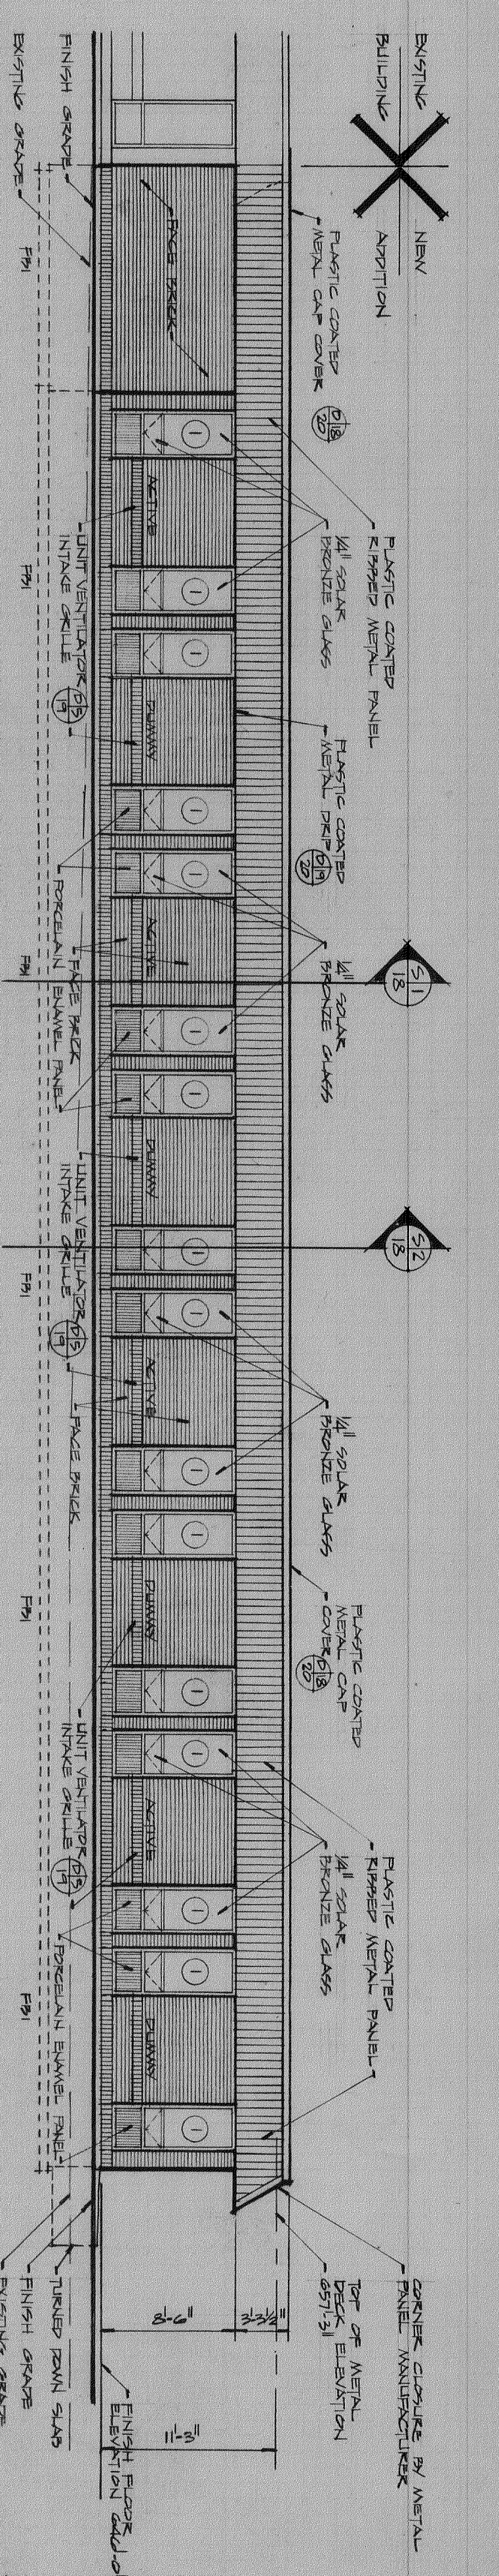

ELEVATION N 10

SCALE: 1/8" = 1'-0"

