



AMERECO, INC.

CONSULTING • ENGINEERING • PROJECT MANAGEMENT  15

May 12, 2018

Mr. Greg Lindy, Director
Support Services
Duneland School Corporation
601 W. Morgan Avenue
Chesterton, IN 46304

**Re: Jackson ES – Underground Storage Tank
Ground Penetrating Radar
Amereco Project No. 18.4033.1**

Dear Mr. Lindy:

Attached, please find the site plan showing the underground utilities in the area of the heating oil underground storage tank (UST). In addition to the Indiana Underground Locate Service, Ground Penetrating Radar was utilized prior to closing the UST to identify underground obstacles that may be encountered during the excavation and soil boring work.


Thank you for allowing Amereco provide you this service. Please call if you have any questions or if we can be of service in the future.

Respectfully,


John Blosky, CHMM
Principal



C: Rudy Sutton, R.V. Sutton, Inc.

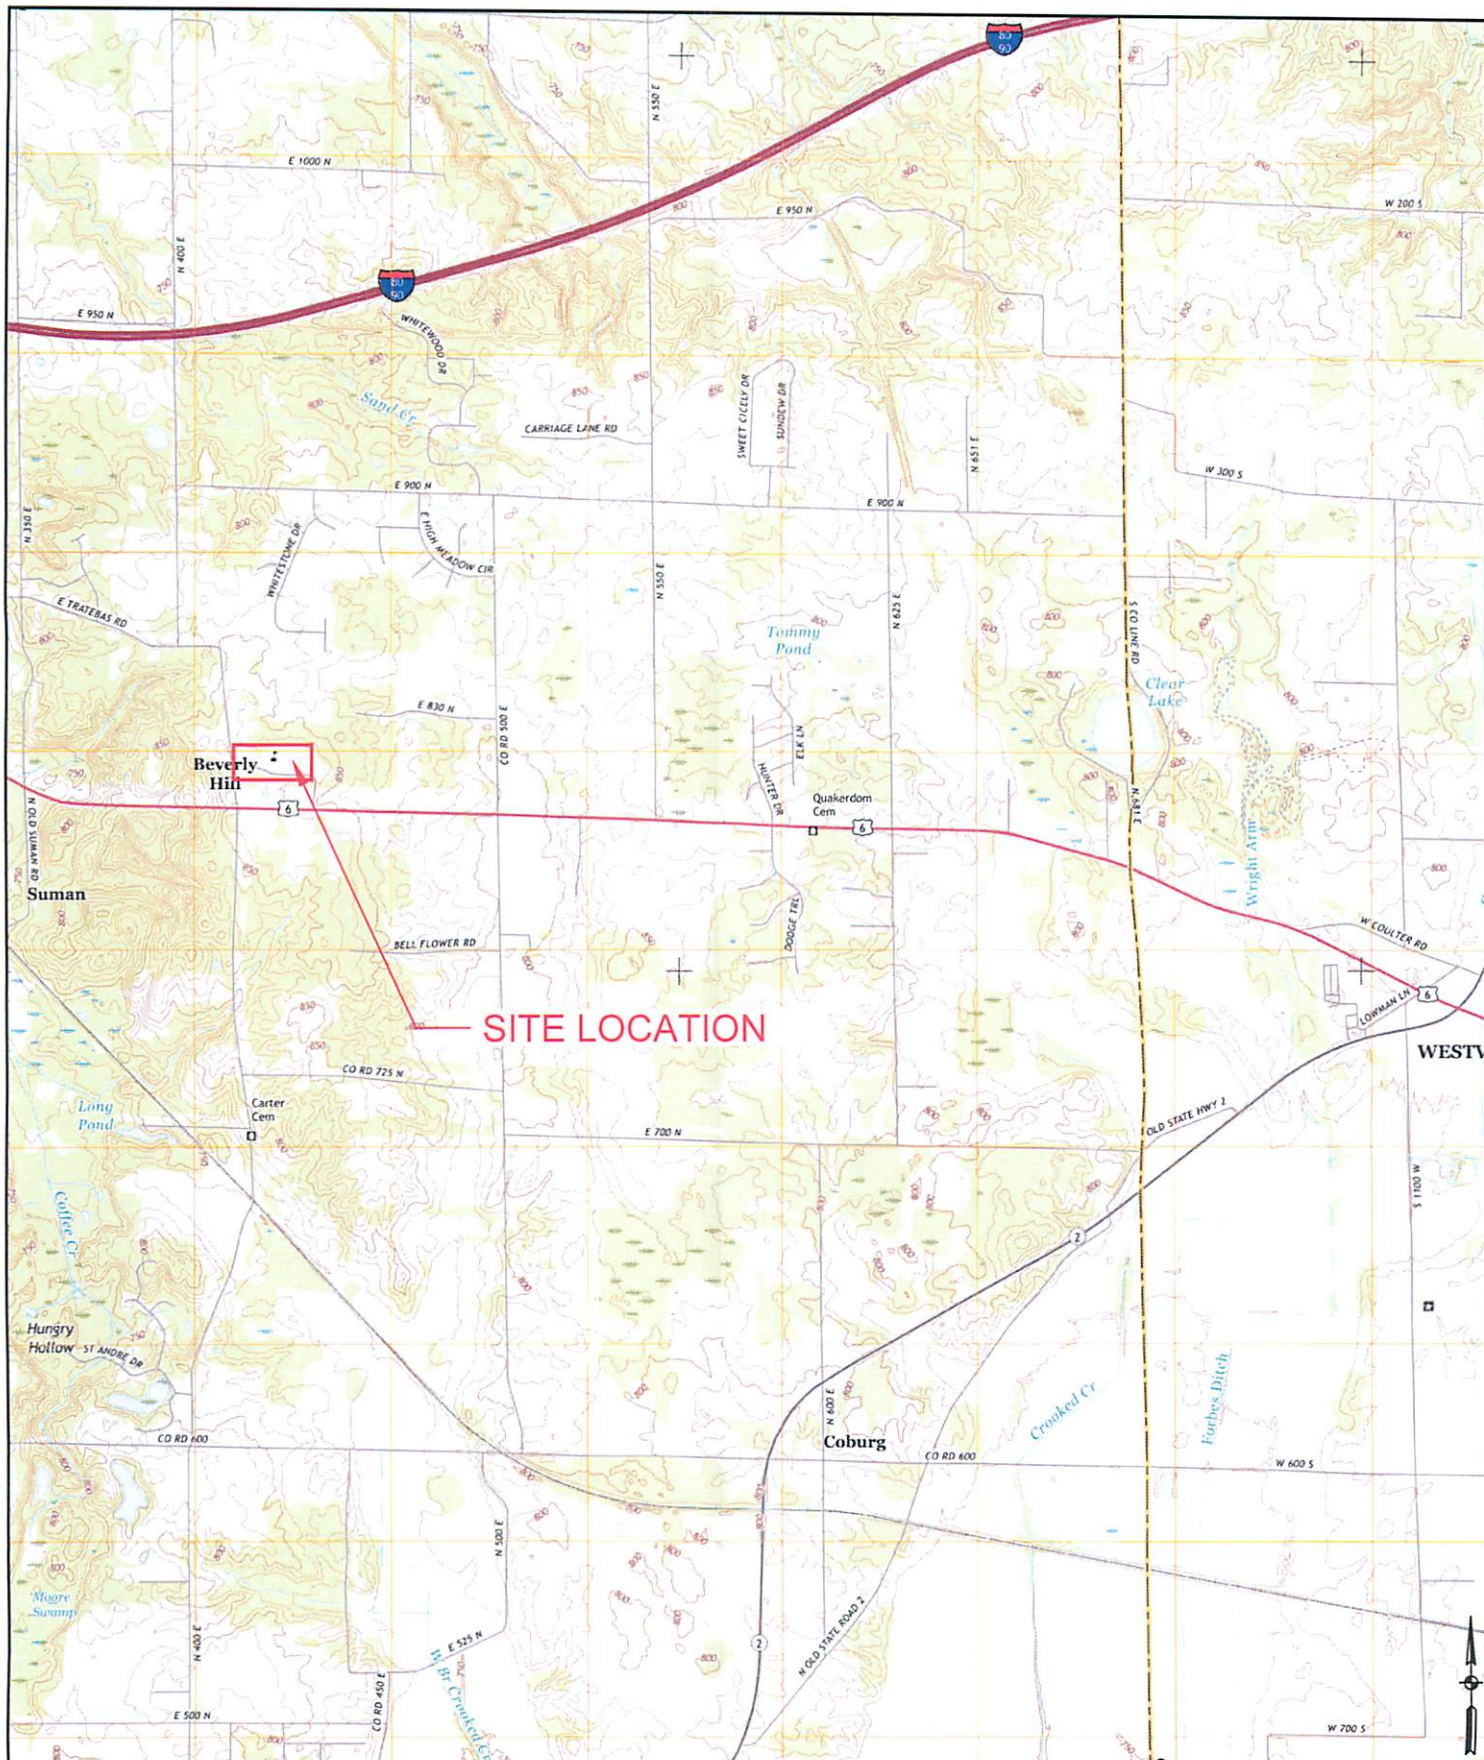

SHEET 1 OF 3

DRAWING NUMBER

SP1

SITE LOCATION MAP

GROUND PENETRATING RADAR
JACKSON ELEMENTARY SCHOOL

VALPARAISO

INDIANA

DRAWN: N. SCHUR
DESIGNED: S. TRAVIS
APPROVED: S. TRAVIS
DATE: MAY 07, 2018
PROJECT NUMBER:
18.4033.1

NO.	REVISION	BY	DATE
1			
2			
3			
4			
5			
6			
7			
8			
9			
10			



AMERESCO, INC.

CONSULTING ENGINEERS-PROJECT MANAGERS
54 MICHIGAN AVENUE
VALPARAISO, IN 46383 219-531-0531



© 2018 GOOGLE

*NOTE: NOT TO SCALE

SHEET 2 OF 3
DRAWING NUMBER

UST LOCATION MAP

SP2

GROUND PENETRATING RADAR
JACKSON ELEMENTARY SCHOOL

VALPARAISO

INDIANA

DRAWN: N. SCHUR
DESIGNED: S. TRAVIS
APPRVD: S. TRAVIS
DATE: MAY 07, 2018
PROJECT NUMBER:
18.4033.1

NO.	REVISION	BY	DATE
1			
2			
3			
4			
5			
6			
7			
8			
9			
10			



AMERECO, INC.
CONSULTING ENGINEERS-PROJECT MANAGERS
54 MICHIGAN AVENUE
VALPARAISO, IN 46383 219-531-0531

SP3

SHEET 3 OF 3
DRAWING NUMBER


UST - 10,000-GALLON HEATING OIL
GROUND PENETRATING RADAR
JACKSON ELEMENTARY SCHOOL

INDIANA
VALPARAISO

18.4033.1
PROJECT NUMBER
DATE: MAY 07, 2018
APPROVED: S. TRAVIS
DESIGNED: S. TRAVIS
DRAWN: N. SCHUR

NO.	REVISION	BY	DATE

AMERRECO, INC.
CONSULTING ENGINEERS-PROJECT MANAGERS
54 MICHIGAN AVENUE
VALPARAISO, IN 46383 219-531-0531

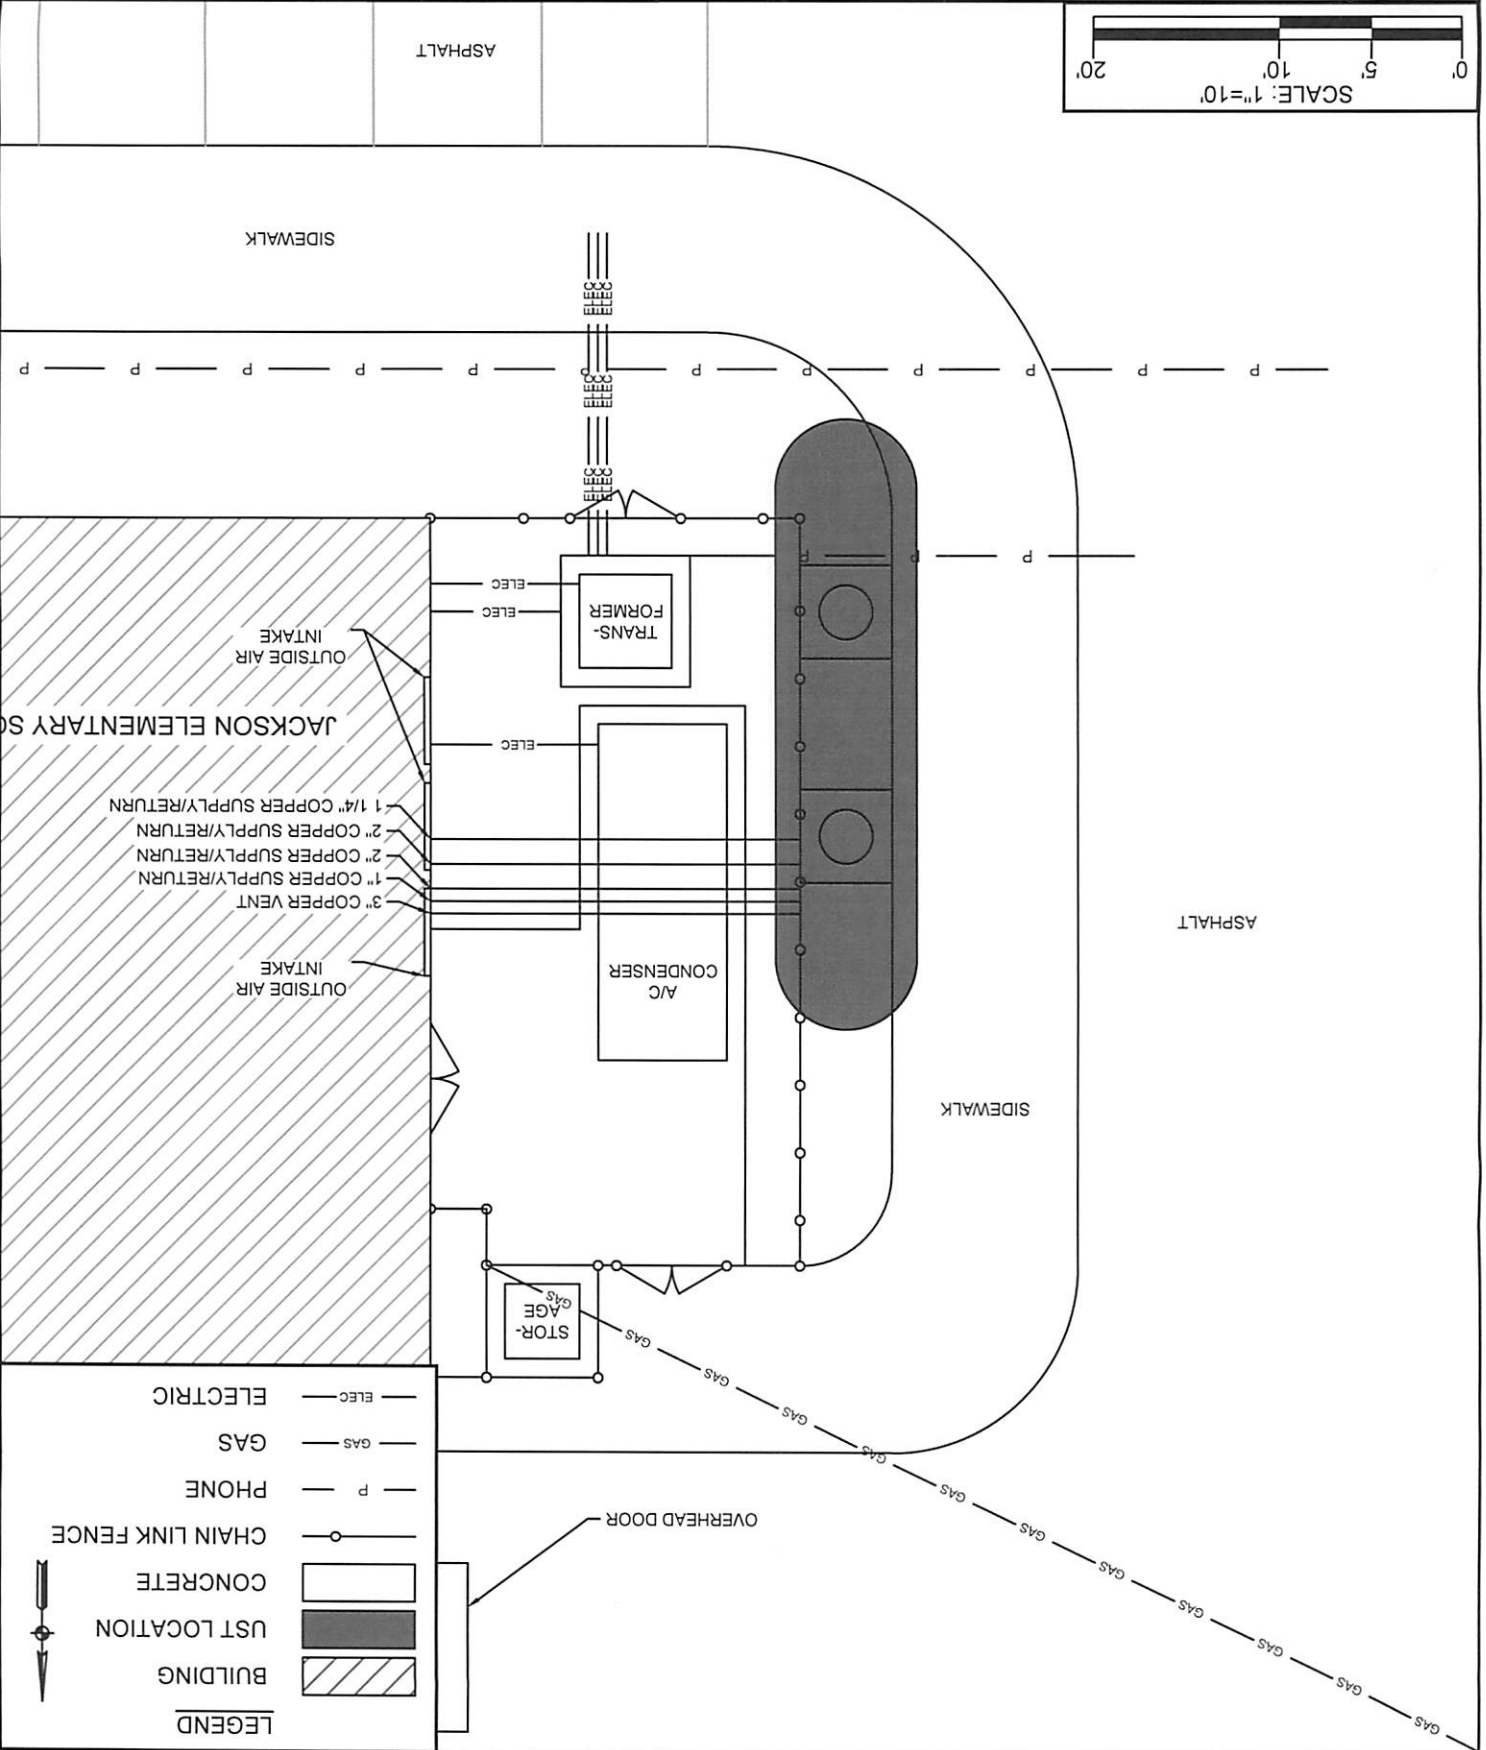

LEGEND

	BUILDING
	UST LOCATION
	CONCRETE
	CHAIN LINK FENCE
	PHONE
	GAS
	ELECTRIC