



AMERECO, INC.

CONSULTING • ENGINEERING • PROJECT MANAGEMENT



May 12, 2018

Mr. Greg Lindy, Director
Support Services
Duneland School Corporation
601 W. Morgan Avenue
Chesterton, IN 46304

**Re: Liberty Intermediate School – Underground Storage Tank
Ground Penetrating Radar
Amereco Project No. 18.4033.1**

Dear Mr. Lindy:

Attached, please find site plans showing the locations of the two underground storage tanks (UST) at Liberty Intermediate School. The USTs include a 10,000-gallon historic gasoline tank that was closed in-place back in 1987, and a 10,000-gallon heating oil tank that was removed this year. In addition to the Indiana Underground Locate Service, Ground Penetrating Radar was utilized prior to removing the heating oil UST to identify underground obstacles that may be encountered during the excavation.


Thank you for allowing Amereco provide you this service. Please call if you have any questions or if we can be of service in the future.

Respectfully,


John Blosky, CHMM
Principal



C: Rudy Sutton, R.V. Sutton, Inc.

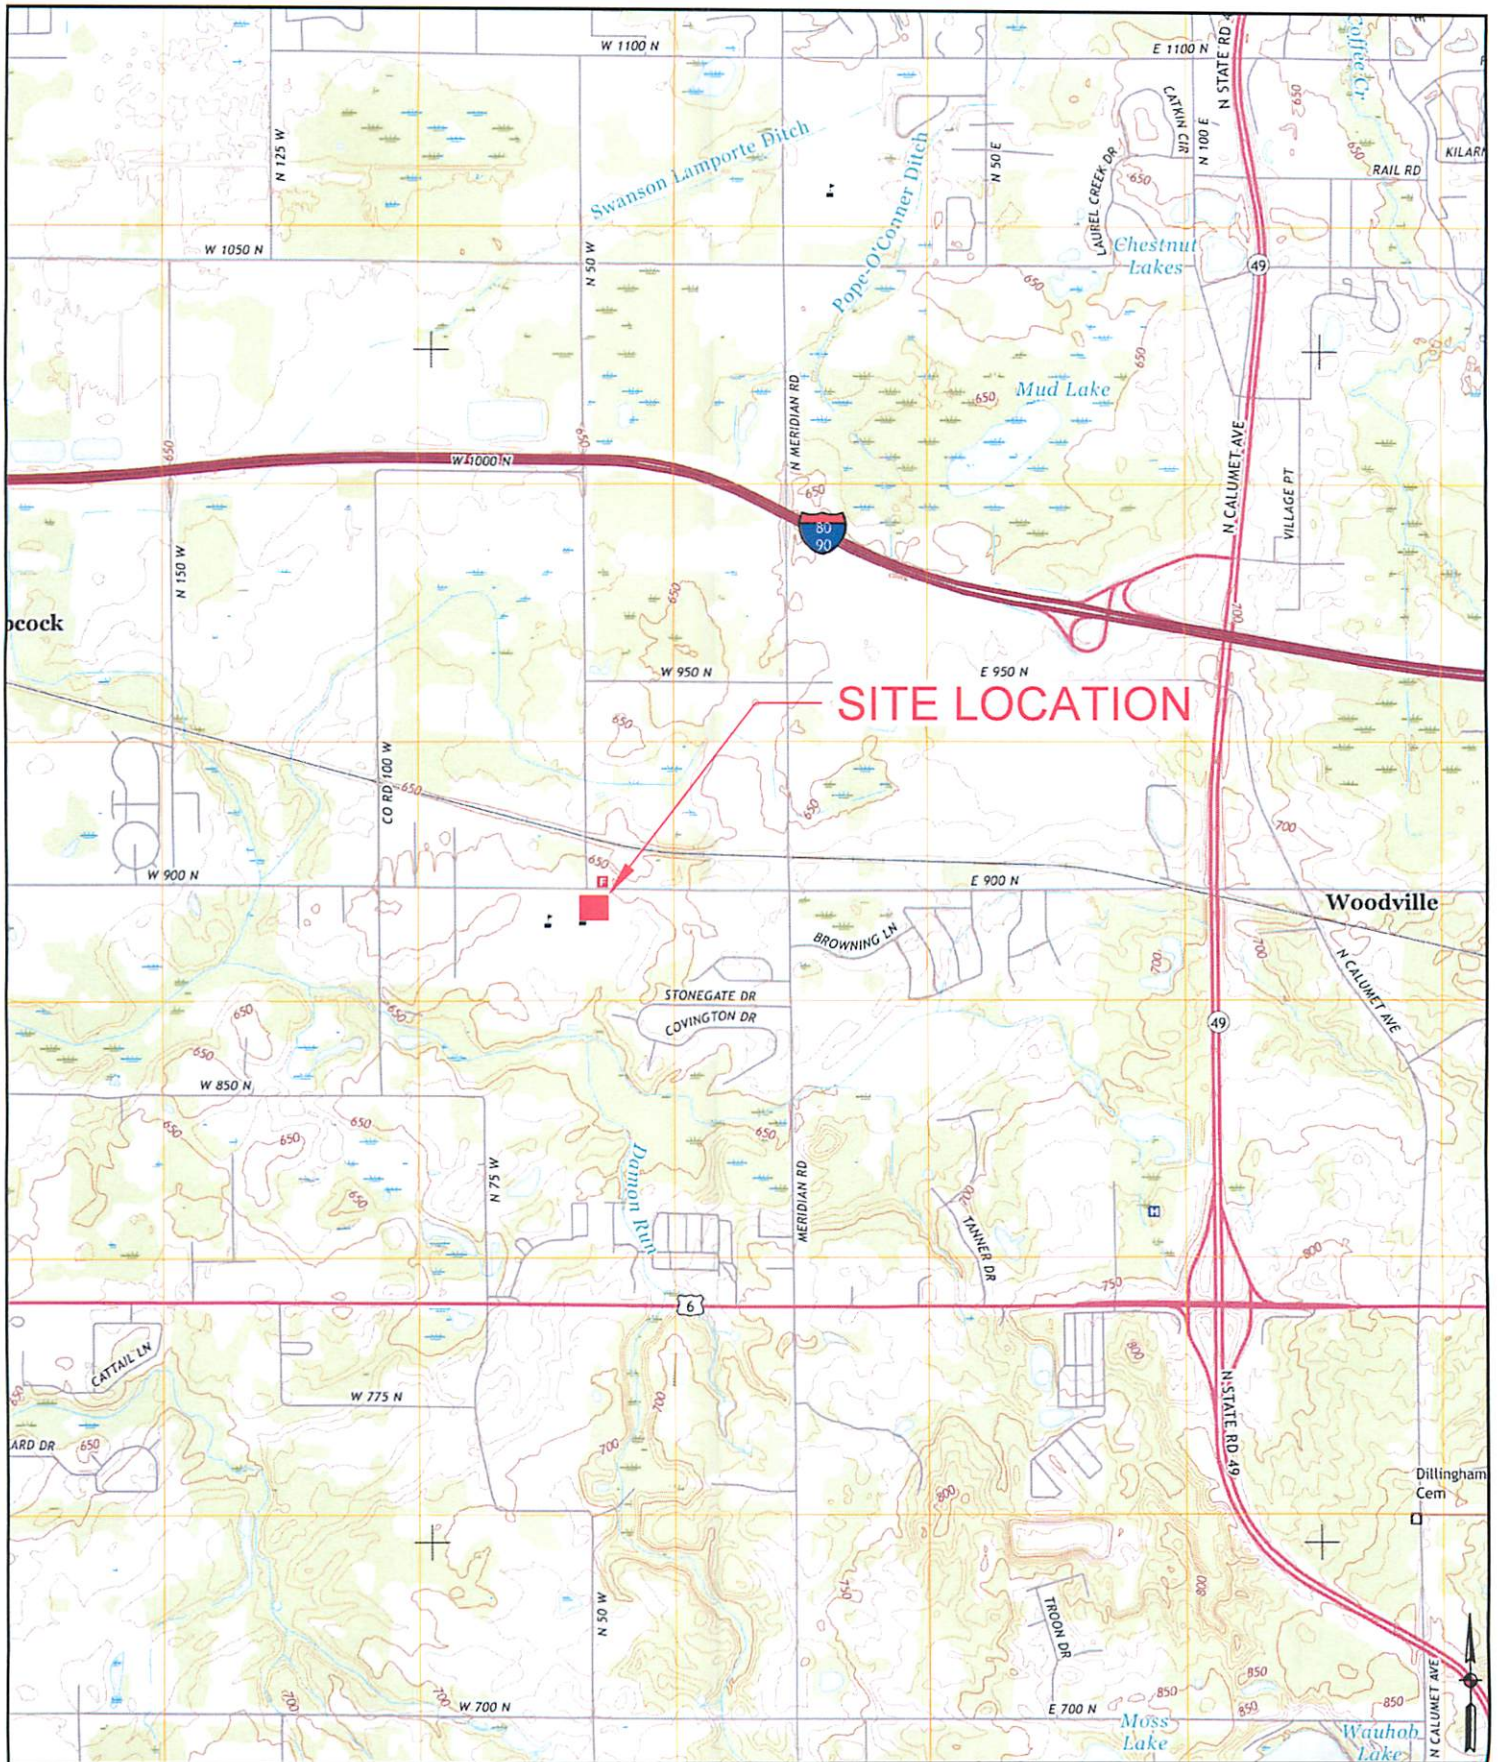

SHEET 1 OF 4		SITE LOCATION MAP		DRAWN: N. SCHUR		NO.	REVISION		BY	DATE		AMERECO, INC. CONSULTING ENGINEERS-PROJECT MANAGERS 54 MICHIGAN AVENUE VALPARAISO, IN 46383 219-531-0531
DRAWING NUMBER				DESIGNED: S. TRAVIS								
SP1		GROUND PENETRATING RADAR LIBERTY INTERMEDIATE SCHOOL, 50 W. 900 N. CHESTERTON INDIANA		APPRVD: S. TRAVIS								
				DATE: APR. 16, 2018								
				PROJECT NUMBER: 18.4033.1								

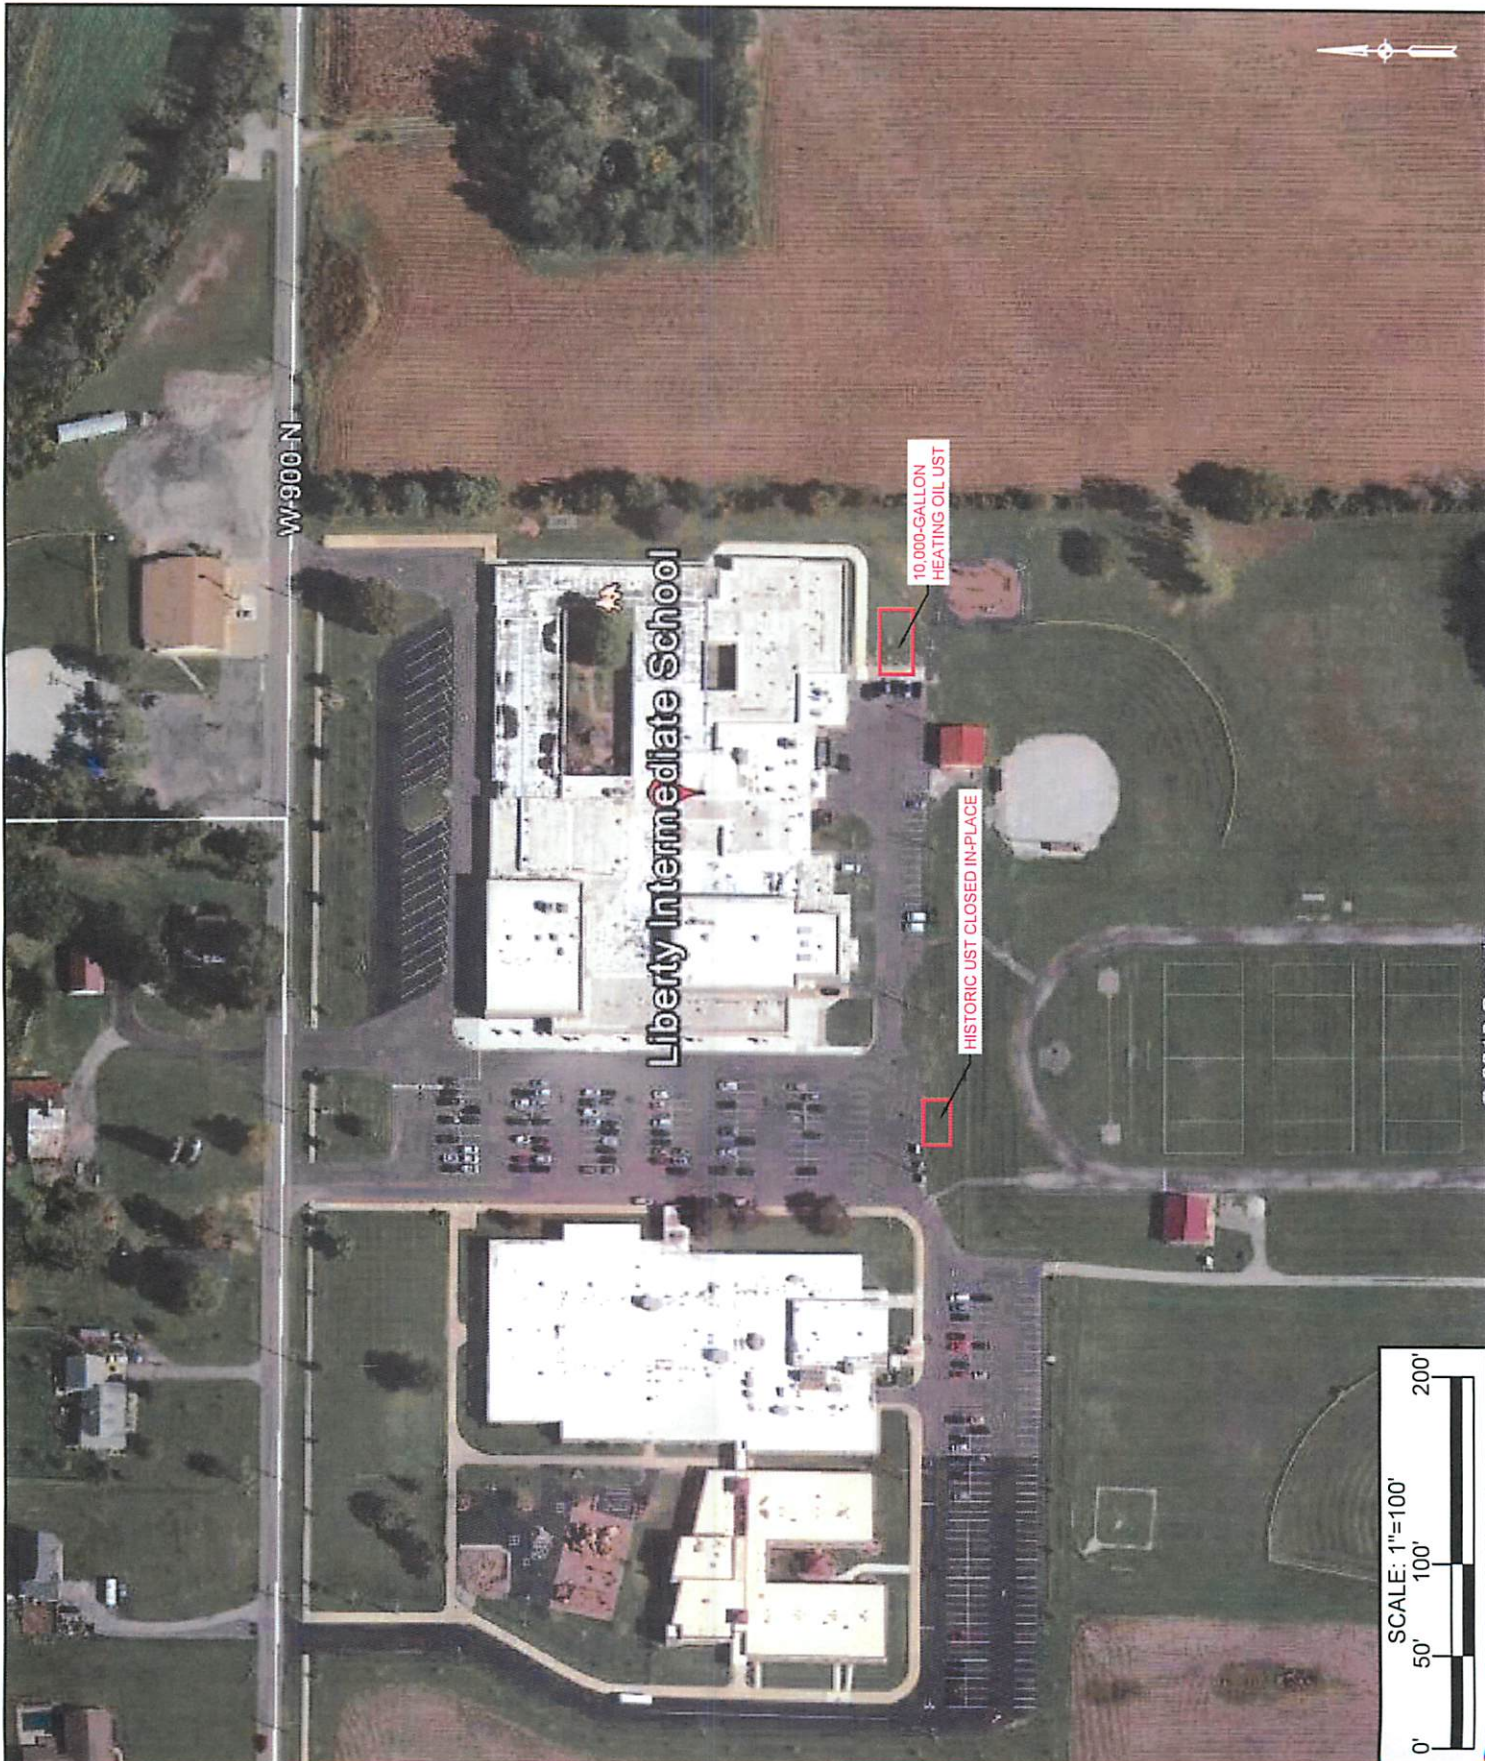

SHEET 2 OF 4

DRAWING NUMBER

SP2

SITE PLAN

GROUND PENETRATING RADAR
LIBERTY INTERMEDIATE SCHOOL, 50 W. 900 N.
CHESTERTON INDIANA


DRAWN: N. SCHUR
DESIGNED: S. TRAVIS
APPRVD: S. TRAVIS
DATE: FEB 21, 2017
PROJECT NUMBER:
18.4033.1

NO.	REVISION	BY	DATE



AMERECO, INC.

CONSULTING ENGINEERS-PROJECT MANAGERS
54 MICHIGAN AVENUE
VALPARAISO, IN 46383 219-531-0531

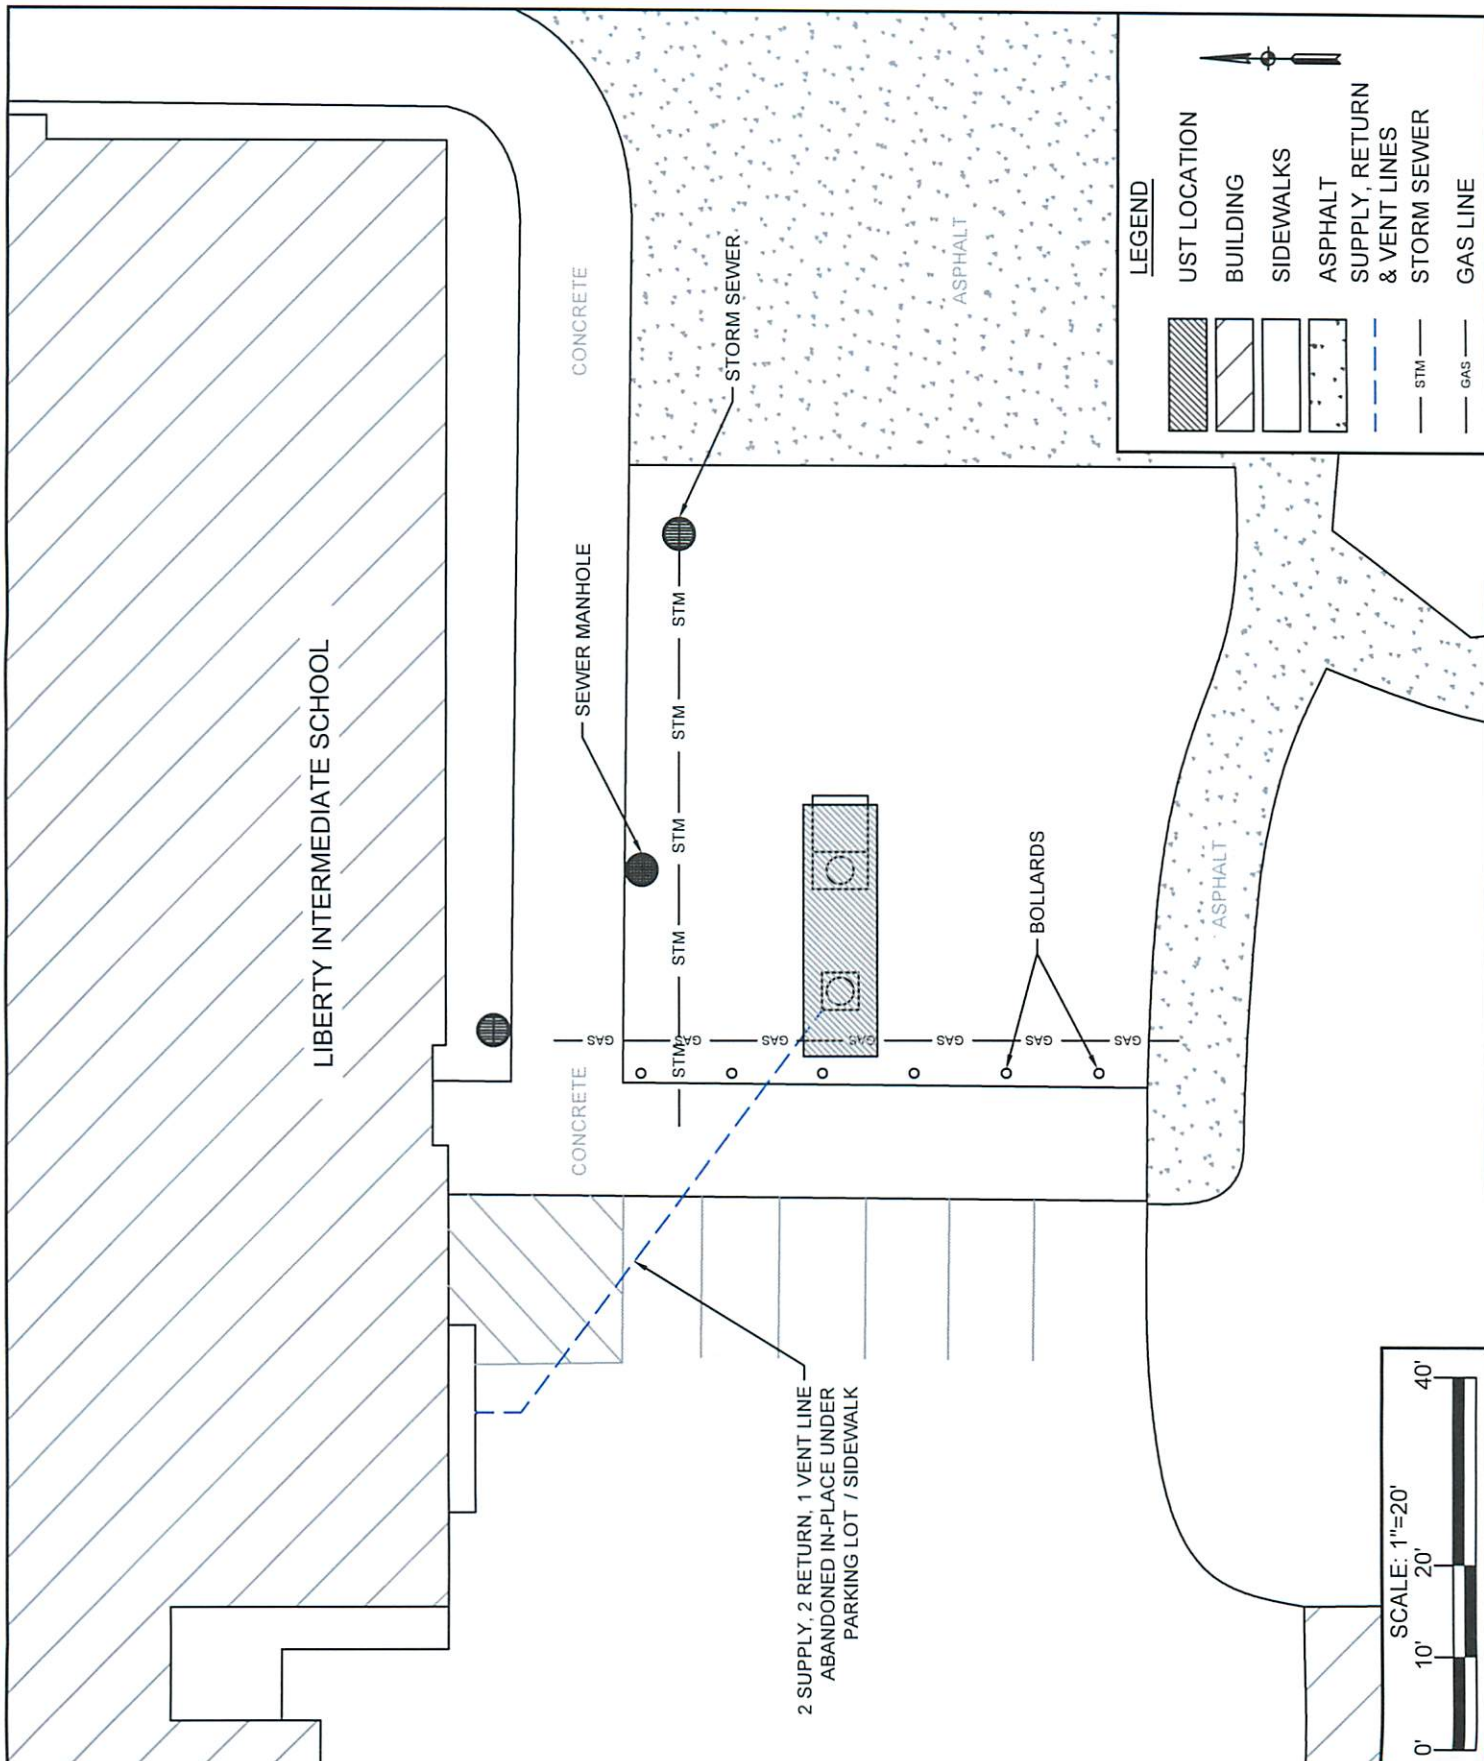

SHEET 3 OF 4

DRAWING NUMBER

SP3

UST - 10,000-GALLON HEATING OIL

GROUND PENETRATING RADAR
LIBERTY INTERMEDIATE SCHOOL, 50 W. 900 N.
CHESTERTON INDIANA

DRAWN: N. SCHUR
DESIGNED: S. TRAVIS
APPROVED: S. TRAVIS
DATE: FEB 21, 2017
PROJECT NUMBER:
18.4033.3

NO.	REVISION	BY	DATE
1			
2			
3			
4			
5			
6			
7			
8			
9			
10			



AMERESCO, INC.

CONSULTING ENGINEERS-PROJECT MANAGERS
54 MICHIGAN AVENUE
VALPARAISO, IN 46383 219-531-0531



SHEET 4 OF 4		HISTORIC UST CLOSED IN-PLACE		DRAWN: N. SCHUR		NO.	REVISION		BY DATE			AMERECO, INC. CONSULTING ENGINEERS-PROJECT MANAGERS 54 MICHIGAN AVENUE VALPARAISO, IN 46383 219-531-0531
DRAWING NUMBER				DESIGNED: S. TRAVIS								
SP4		GROUND PENETRATING RADAR LIBERTY INTERMEDIATE SCHOOL, 50 W. 900 N. CHESTERTON INDIANA		APPRVD: S. TRAVIS								
				DATE: FEB. 21, 2017								
				PROJECT NUMBER:								
				18.4033.1								