


1 PARTIAL SECOND FLOOR PLAN - POWER & SYSTEMS
 1/8" = 1'-0"

GENERAL ELECTRICAL NOTES:

- ALL NEW CIRCUITS ARE FED FROM NEW PANEL "L1" UNLESS NOTED OTHERWISE.
- UNLESS NOTED OTHERWISE, ALL NEW RECEPTACLES SHALL BE FLUSH MOUNTED WITHIN NEW WALLS. FOR NEW COMPONENTS INDICATED ON EXISTING WALLS, FLUSH MOUNT THE RECEPTACLES IF THE WALL IS CONSTRUCTED OF GWB. IF WALL IS CMU, SURFACE MOUNT COMPONENTS WITH WIREMOLD V700 SERIES IF POWER ONLY, OR 6000 SERIES IF 2-COMPARTMENT IS REQUIRED.
- PROVIDE NEW SPEAKERS FOR INTERCOM SYSTEM AS INDICATED. SPEAKERS TO MATCH EXISTING SYSTEM. FIELD VERIFY EXISTING INTERCOM SYSTEM MANUFACTURER, LOCATION, ETC. AND PROVIDE AS REQUIRED.

ELECTRICAL KEY NOTES:

- PROVIDE FINAL CONNECTION TO CHAIR LIFT. PROVIDE HEAVY DUTY SWITCH FOR 20A, 120V CIRCUIT, FURNISHED AND INSTALLED PER MANUFACTURER REQUIREMENTS. PROVIDE PHONE CONNECTION, PER LOCAL AUTHORITY REQUIREMENTS.
- COORDINATE LOCATION OF NEW PANEL WITH MECHANICAL CONTRACTOR AND ASSOCIATED PIPING FROM BELOW.

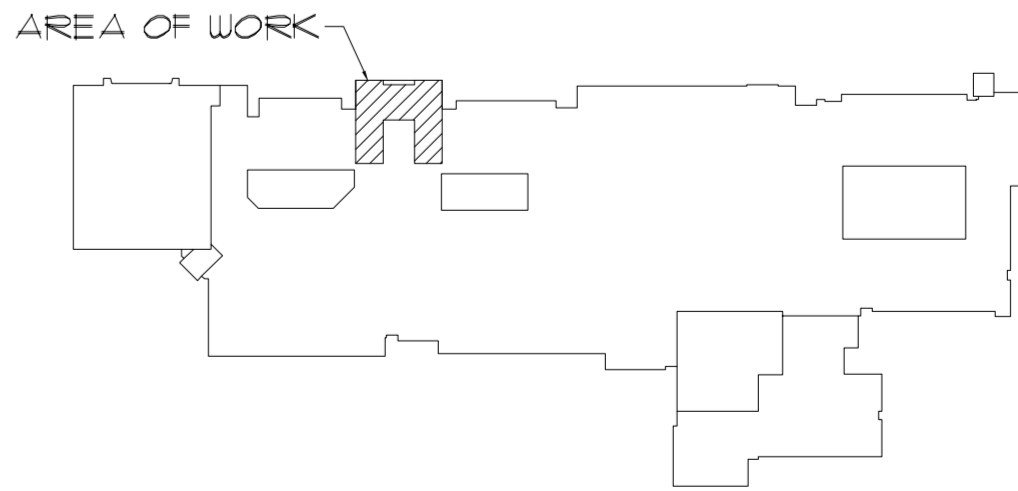


KEY PLAN
 NOT TO SCALE



DUNELAND SCHOOL CORPORATION
 2018 MAIN OFFICE RENOVATIONS AT:
 CHESTERTON MIDDLE SCHOOL (CMS)
 651 W. MORGAN AVENUE, CHESTERTON, INDIANA 46304

PROJECT NUMBER: 18-003	REVISIONS:
PROJECT MANAGER: KCS	
DRAWN BY: CJS	
ISSUED FOR BIDDING: 03/28/2018	
PARTIAL SECOND FLOOR PLAN - POWER & SYSTEMS	

E2.20

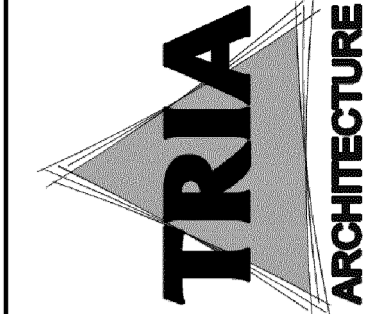

HEPF: CONSULTANT
 (P) 6305331556
 700 HIGHLAND DR., SUITE 100
 ARLINGTON HEIGHTS, IL 60005
 DAS
 700 HIGHLAND DR., SUITE 100
 ARLINGTON HEIGHTS, IL 60005
 GreenbergFarrow
 21 SOUTH EVERGREEN, SUITE 200
 ARLINGTON HEIGHTS, IL 60005