




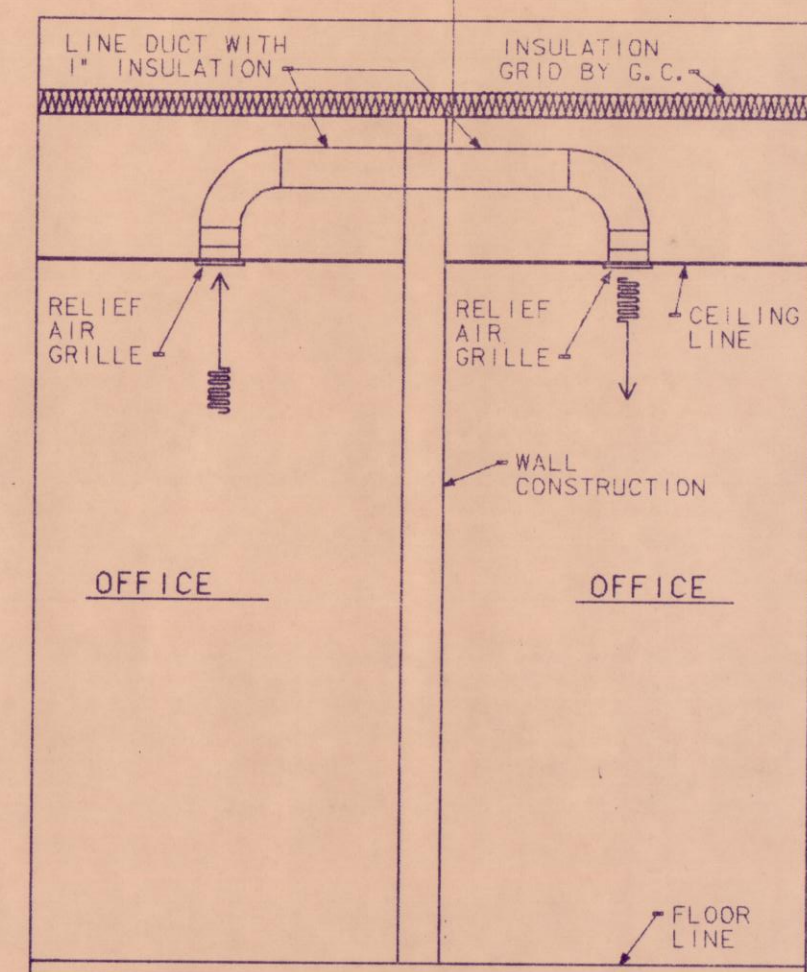

RELIEF AIR DETAIL "A"
NO SCALE

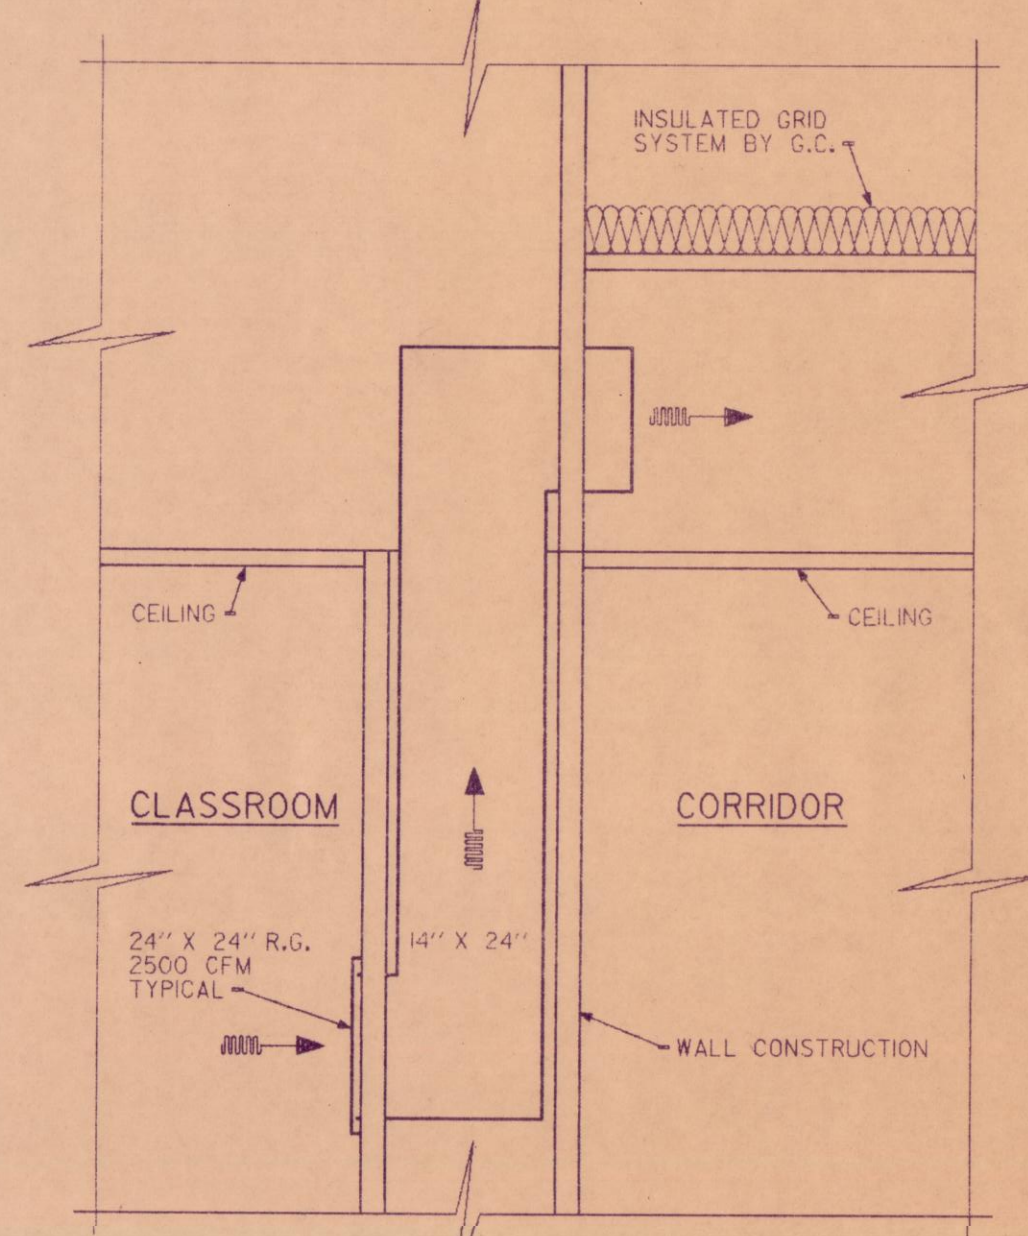

TYPICAL CLASSROOM RETURN / RELIEF
DETAIL "B"
NO SCALE

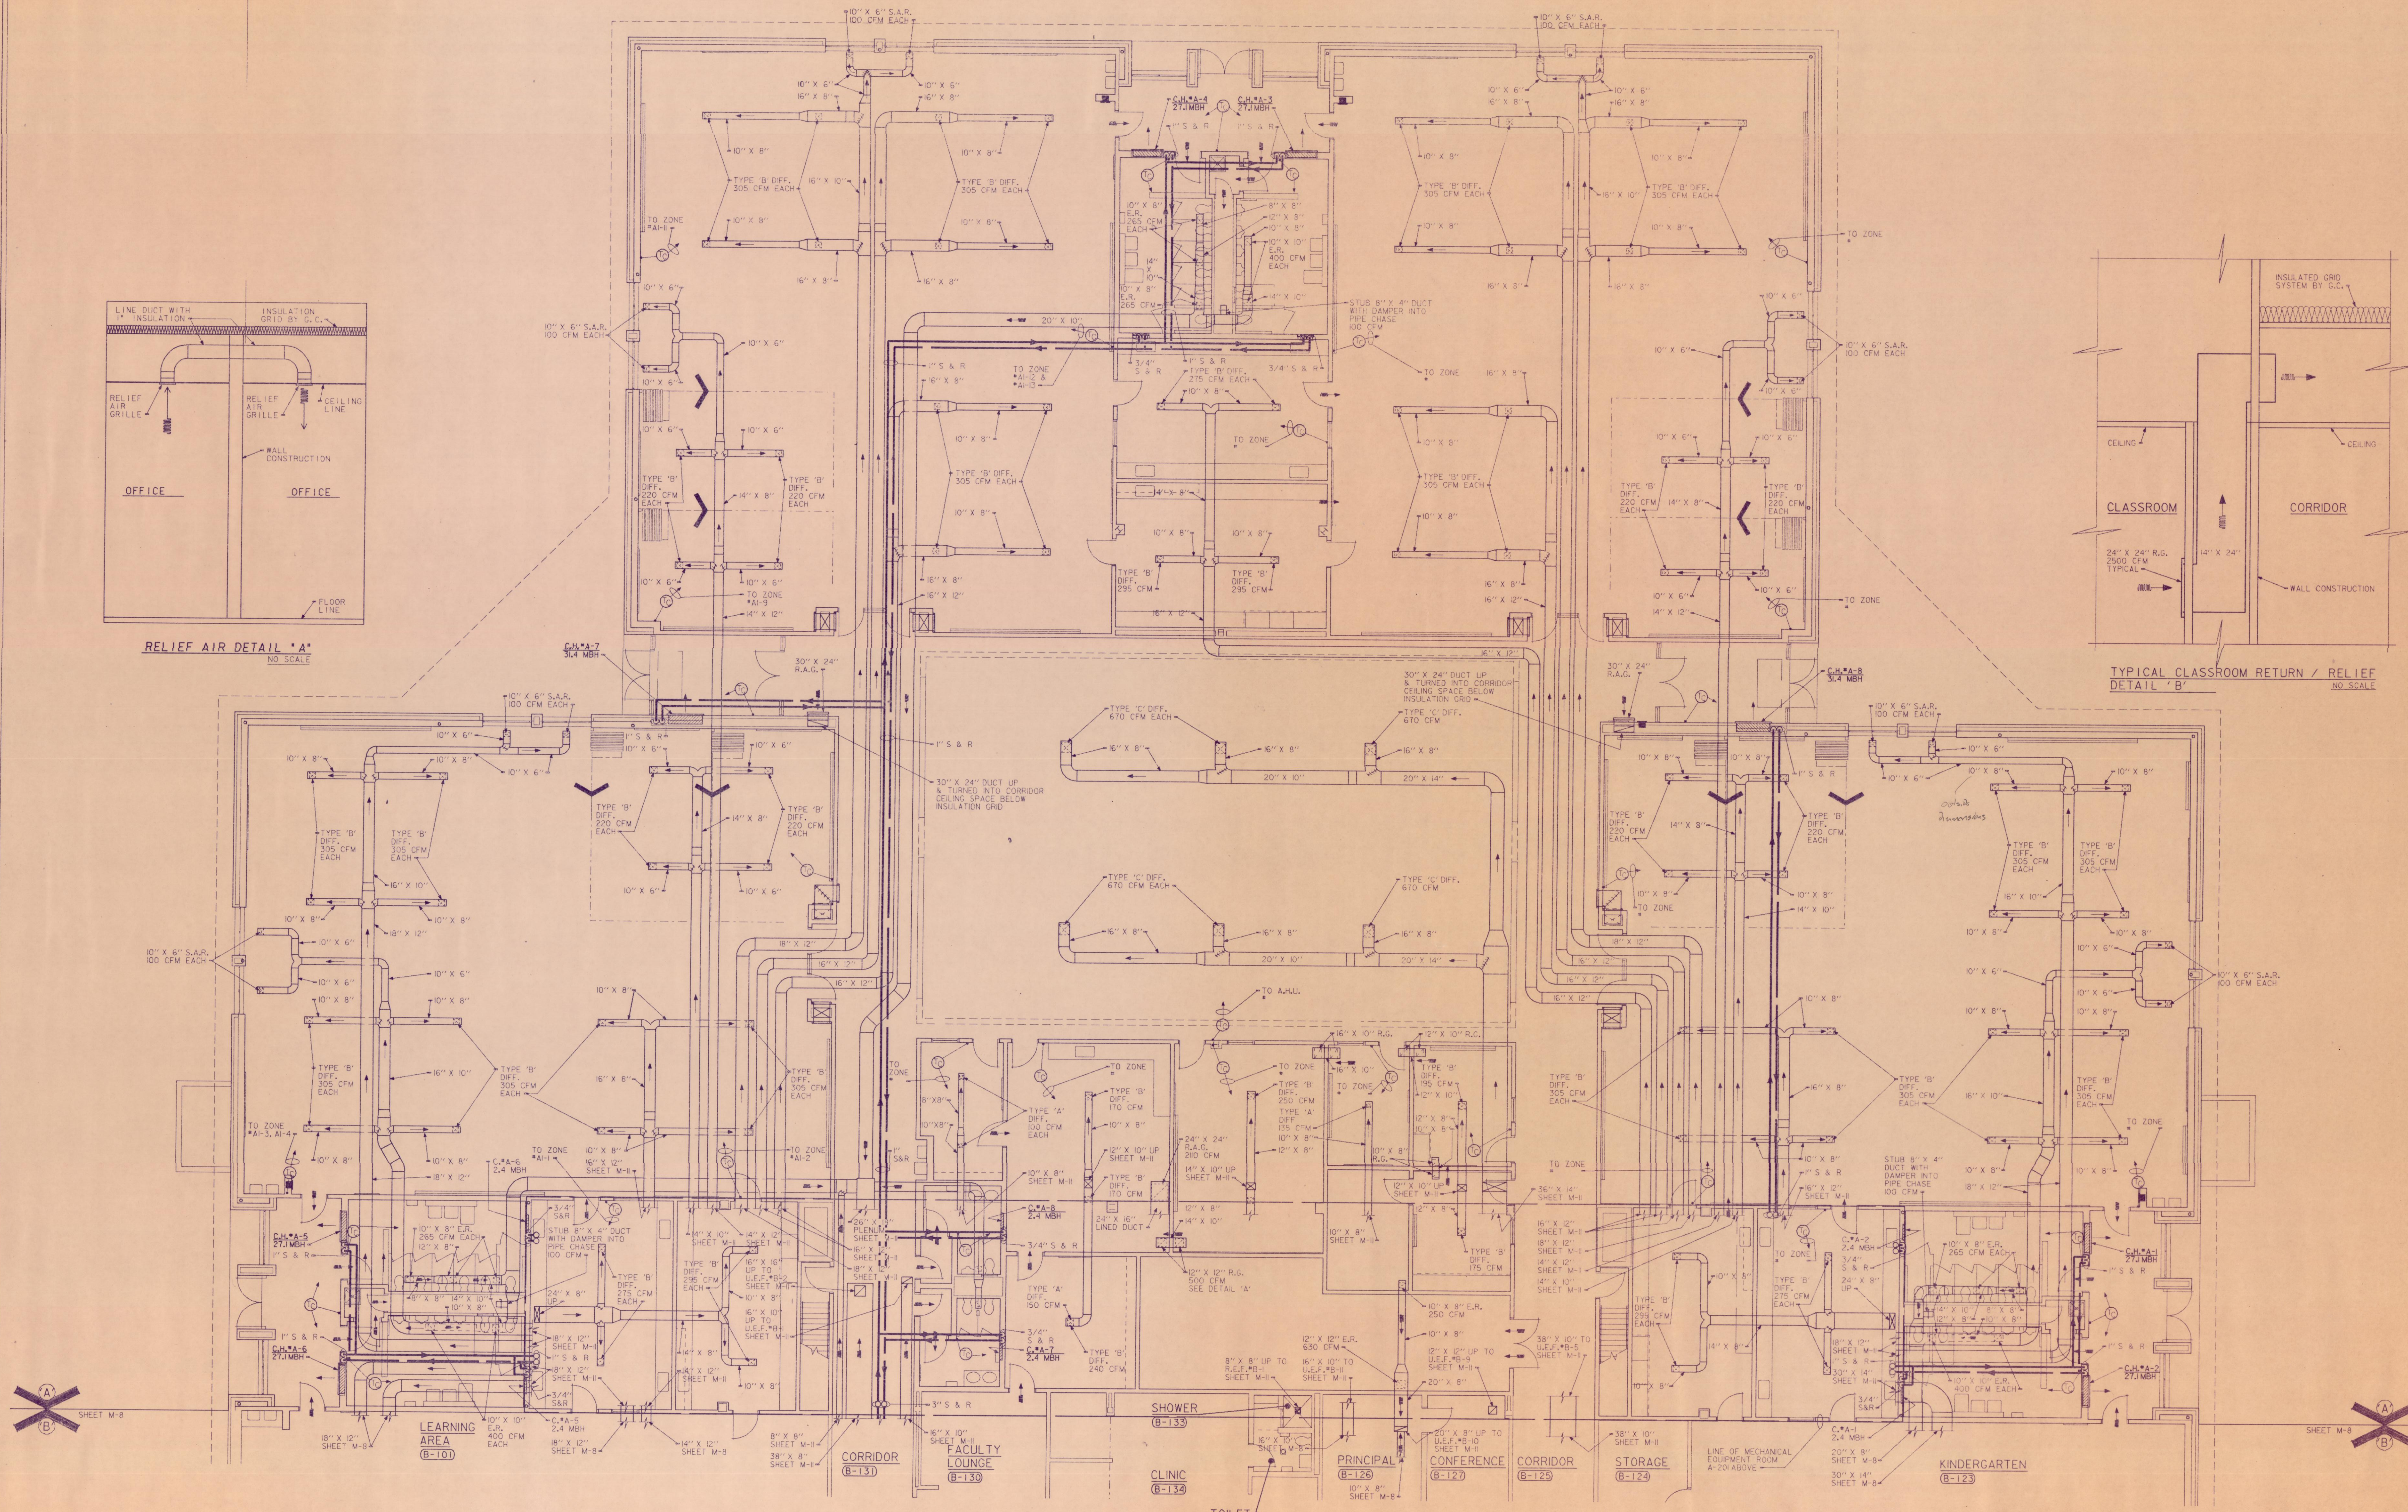

UNIT 'A' HEATING, VENTILATING, AIR-CONDITIONING FIRST FLOOR PLAN
SCALE: 1/8" = 1'-0"



PROJECT
12579.00
DATE
3 MAY 82
REVISED

NO. M-5
OF 37

EVERETT I. BROWN COMPANY
ARCHITECTS
ENGINEERS
INDIANAPOLIS, INDIANA • 46241
JACKSON ELEMENTARY SCHOOL
5500 WEST BRADBURY AVENUE • PARK FLETCHER •

EVERETT I. BROWN COMPANY